


Hobson's Pier, Inc.
390 Commercial Street, Portland, Maine 04103

2nd Floor Fire Alarm System Legend

Symbol	Description
☒	Horn w/ Light
⊗	Light

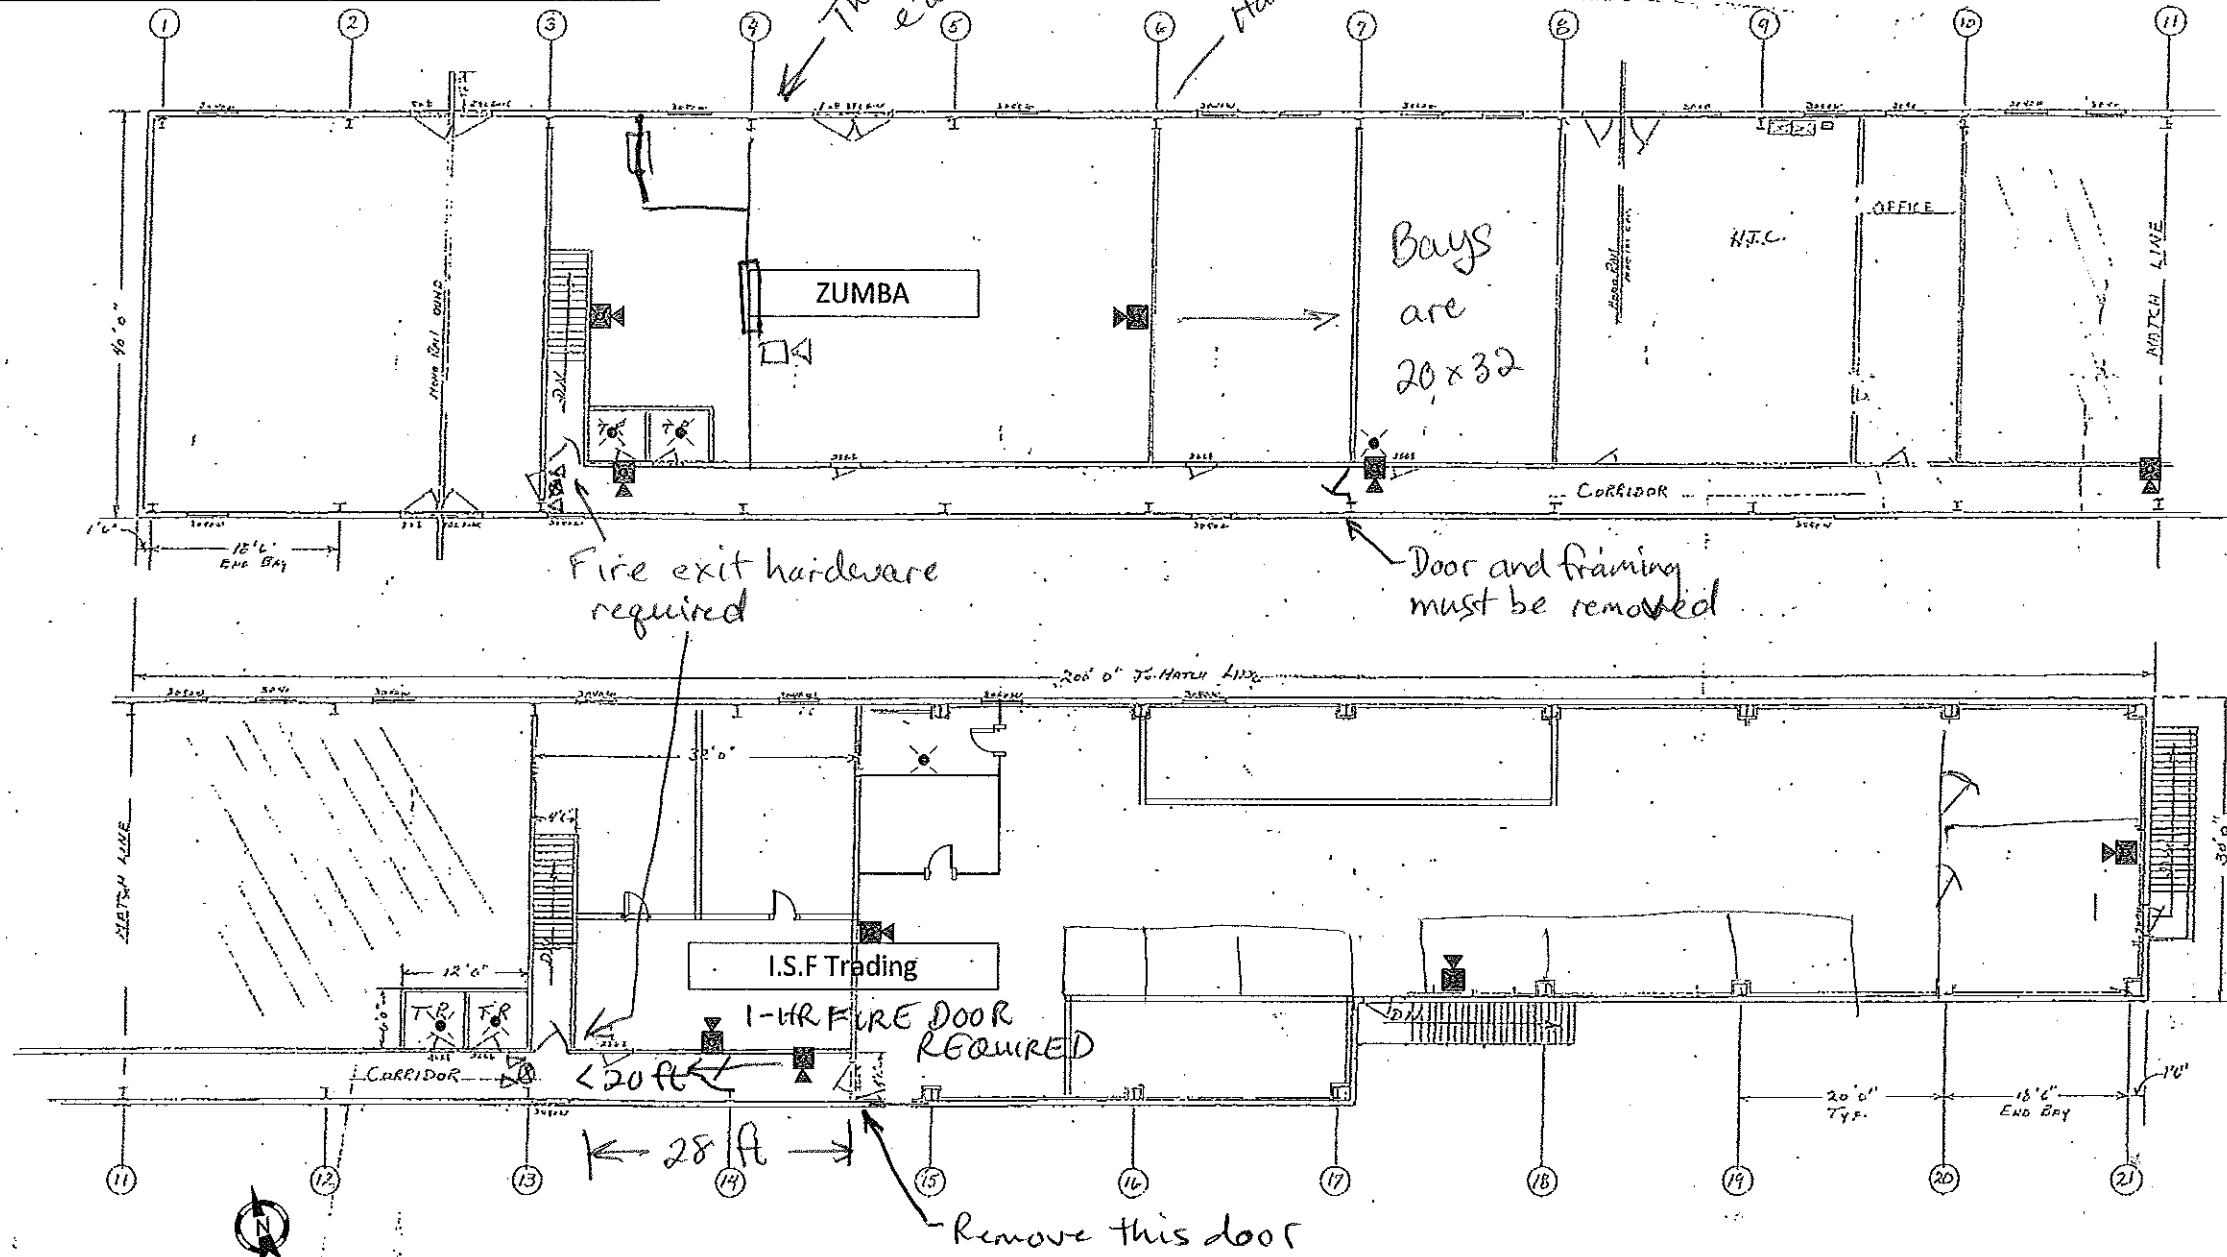

Robin Russell, Certified Engineering Technician, NICET Cert. # 110826

10 Manuel Drive, Portland, Maine 04103 (207) 347-5327

12/6/12

HOBSON'S WHARF

SCALE: 1/8" = 1'	DATE: 9-18-12	REVISION: DDG
YANKEE CONST. CORP.		REVISION: 12-14-12
SECOND FLOOR		REVISION: R 2

