


ENLARGED RESTROOM REFLECTED CEILING PLAN
SCALE: 1/4"=1'-0"

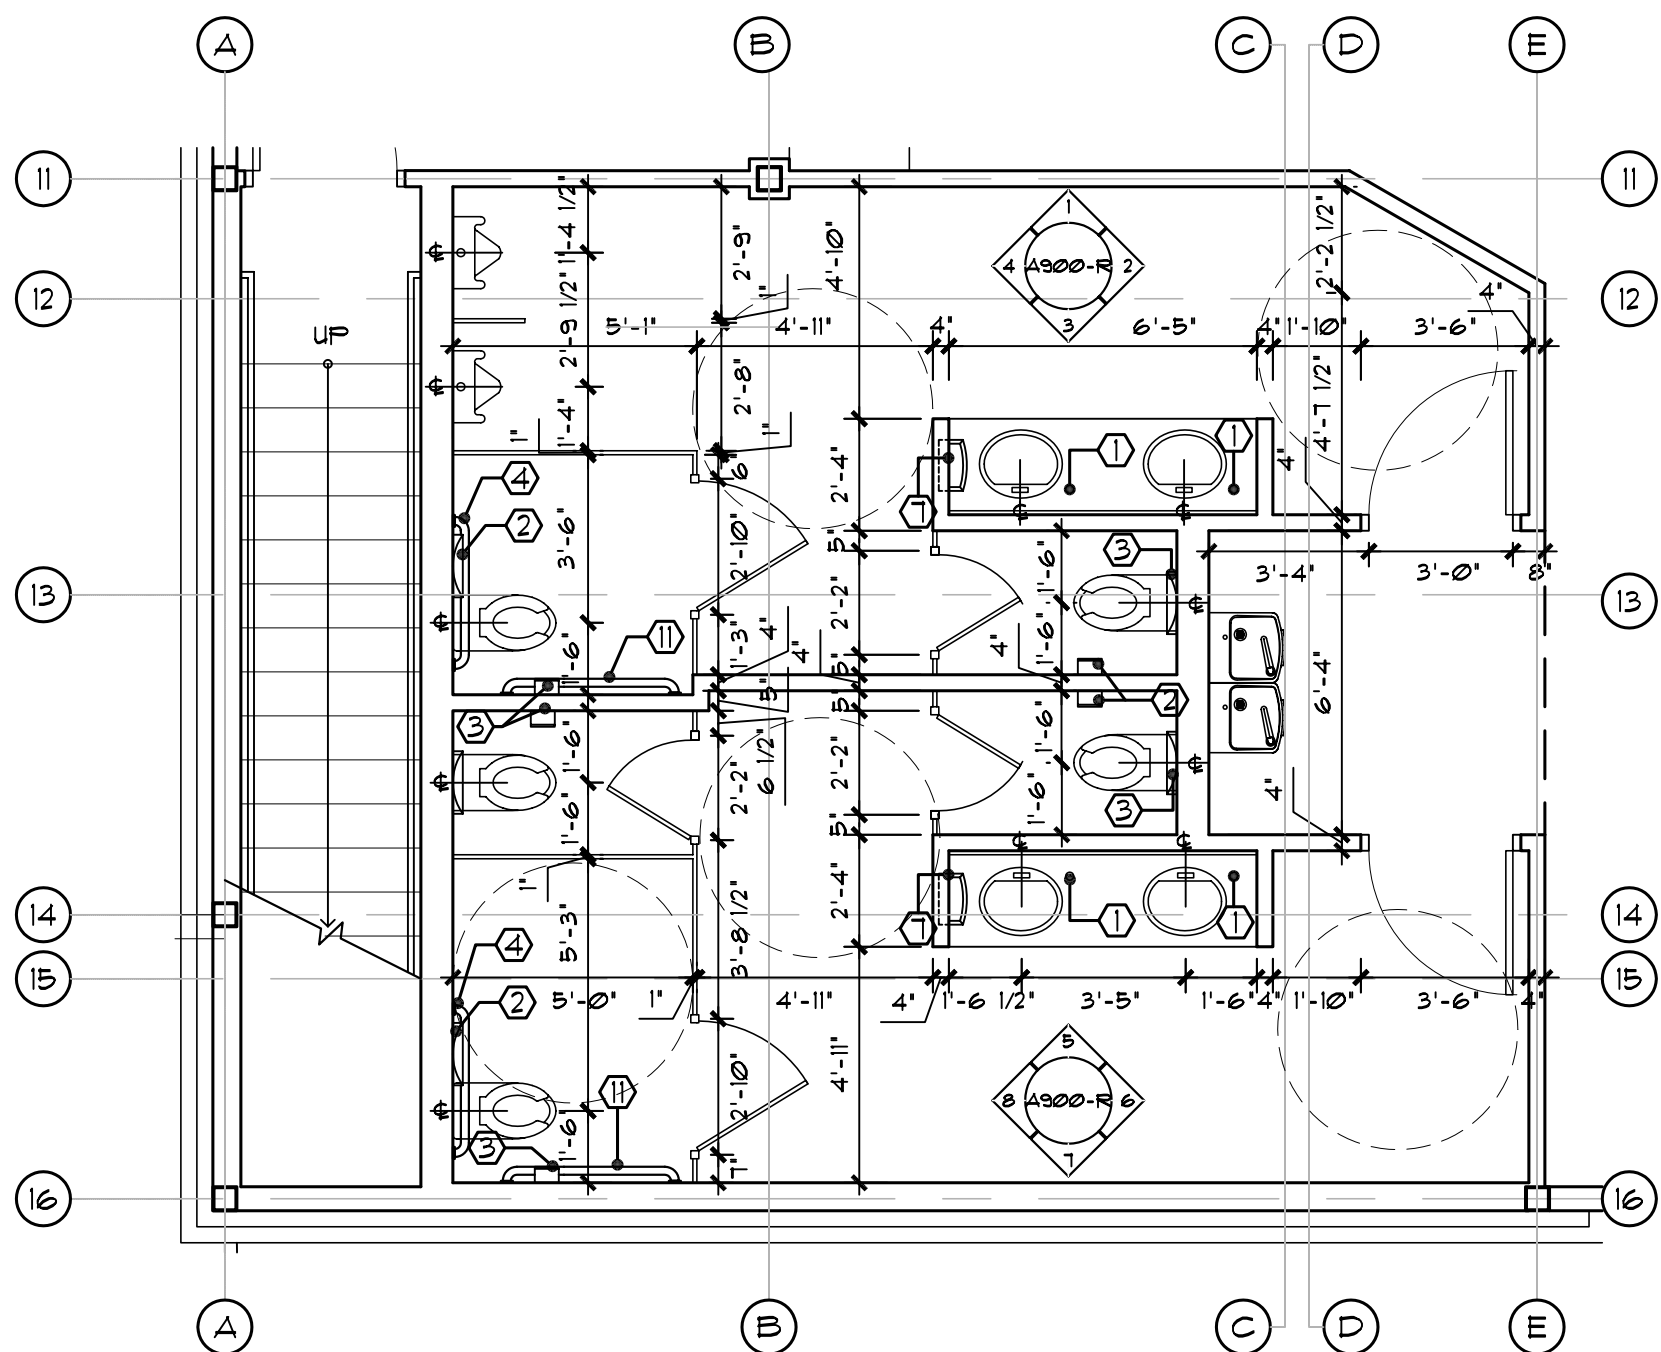





ENLARGED RESTROOM FLOOR PLAN
SCALE: 1/4"=1'-0"

RESTROOM ACCESSORIES		
#	DESCRIPTION	MOUNTING HEIGHT AFF. UNLESS OTHERWISE NOTED
1	LAVATORY MOUNTED LATHER SOAP VALVE	HCP COUNTER STD. HEIGHT
2	RECESSED TOILET SEAT COVER DISPENSER	HCP 44 1/2" T.O.U. STD. 60" T.O.U.
3	TOILET PAPER HOLDER FOR TWO ROLLS	HCP 18" B.O.U. STD. 31" T.O.U.
4	36" STAINLESS STEEL GRAB BAR 1 1/2" DIAMETER CONCEALED MOUNTING	HCP STD.
5	RECESSED NAPKIN - TAMPON DISPENSER	HCP 52" T.O.U. STD. 69" T.O.U.
6	HANDICAP MIRROR	HCP 40" B.O.U. STD. N/A
7	RECESSED COMBINATION PAPER TOWEL DISPENSER AND WASTE RECEPTACLE	HCP 52 3/4" T.O.U. STD. 71" T.O.U.
8	COAT HOOK & BUMPER	HCP 3'-6" STD. 5'-0"
9	SURFACE MOUNTED PAPER TOWEL DISPENSER	HCP 3'-10" T.O.U. STD. N/A
10	SURFACE MOUNTED WASTE RECEPTACLE	HCP 2'-2" T.O.U. STD. N/A
11	42" STAINLESS STEEL GRAB BAR 1 1/2" DIAMETER CONCEALED MOUNTING	HCP 33" T.O.U. STD.
12	MIRROR	HCP ----- STD. ---
13	SURFACE MOUNTED LATHER SOAP DISPENSER	HCP 44" B.O.U. STD. 44" MAX. B.O.U.



NOTES: T.O.U. = TOP OF UNIT B.O.U. = BOTTOM OF UNIT HCP = HANDICAPPED AFF. = ABOVE FINISHED FLOOR

GENERAL RESTROOM NOTES:	
TOILET ROOMS SHALL CONFORM TO ALL ACCESSIBILITY REQUIREMENTS OF THE AMERICANS WITH DISABILITIES ACT (ADA) INCLUDING, BUT NOT LIMITED TO, THE FOLLOWING:	
A.	WATER CLOSETS SEAT HEIGHT - 17" - 19" AFF.
B.	CENTER LINE OF WATER CLOSET - 18" FROM SIDE WALL.
C.	TOILET PAPER DISPENSER - 36" MAX. FROM REAR WALL, 19" MIN. AFF.
D.	KNEE CLEARANCE AT LAVATORY - APRON 29" MIN. HT., 8" MIN. DEPTH.
E.	LAVATORY DEPTH - 17" MIN.
F.	LAVATORY HOT WATER AND DRAIN PIPES INSULATED WHEREVER EXPOSED.
G.	LAVATORY RIM SURFACE - 34" MAX. AFF.
H.	INTERNATIONAL SYMBOL OF ACCESSIBILITY SHALL BE MOUNTED IN THE VICINITY OF MAIN ENTRY.

FIXTURE LEGEND	
	A5 RECESSED 1 x 4 STATIC FLUORESCENT TROFFER WITH FLUSH FRAM FOR SUSPENDED GRID CEILING, A 1/2" SQUARE WHITE EGGRATE LOVER AND ELECTRONIC, LOW HARMONIC BALLASTS.
	B1 1-3/8" RECESSED WALL WASH ACCENT FIXTURE DIAMETER OPEN PENDANT MOUNTED FIXTURE WITH 8" DIAMETER OPEN REFLECTOR CONE WITH LOW IRIDESCENT FINISH.
	B2 RECESSED SOENLIGHT WITH 4-1/2" DIAMETER OPEN APERTURE WITH WHITE REGRESSED BAFFLE AND WHITE METAL TRIM RING.
	HVAC RETURN AIR GRILLE
	SMOKE DETECTOR
	SPRINKLER HEAD

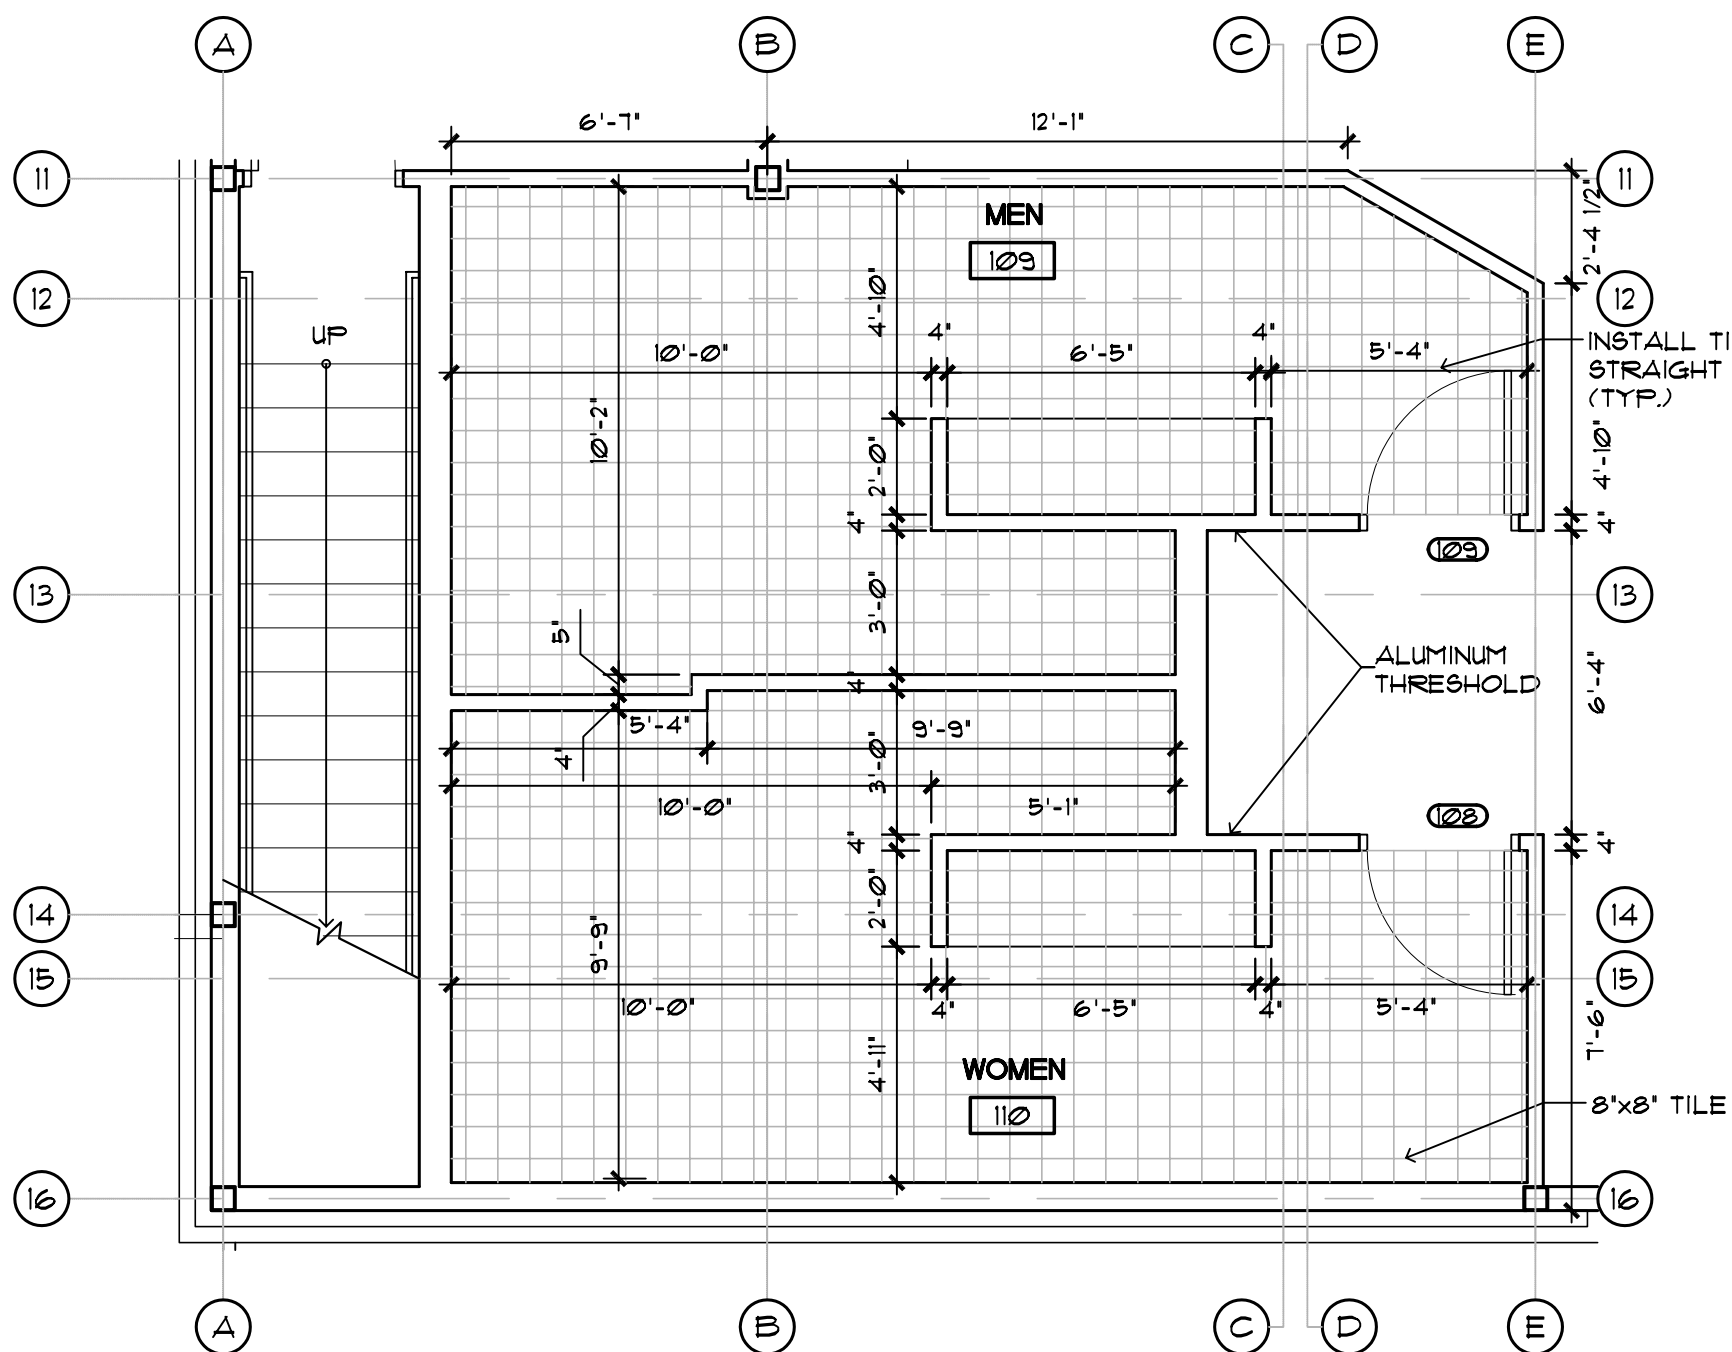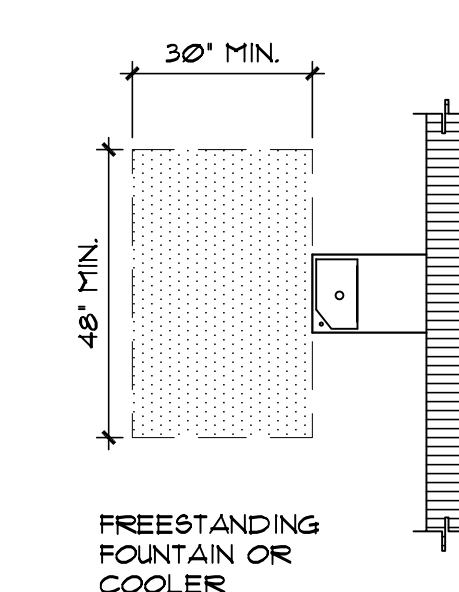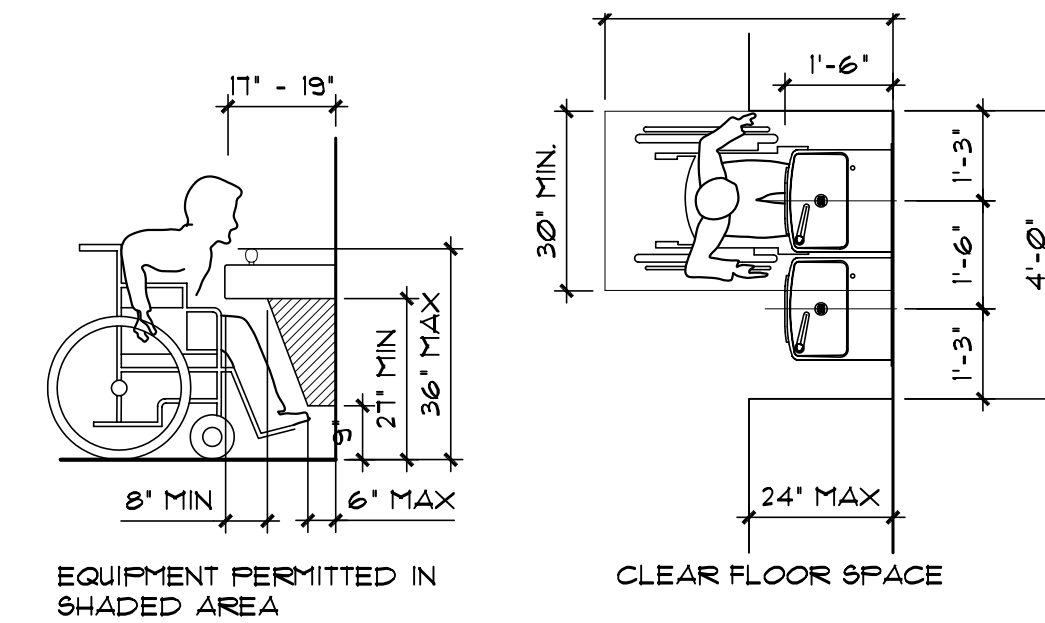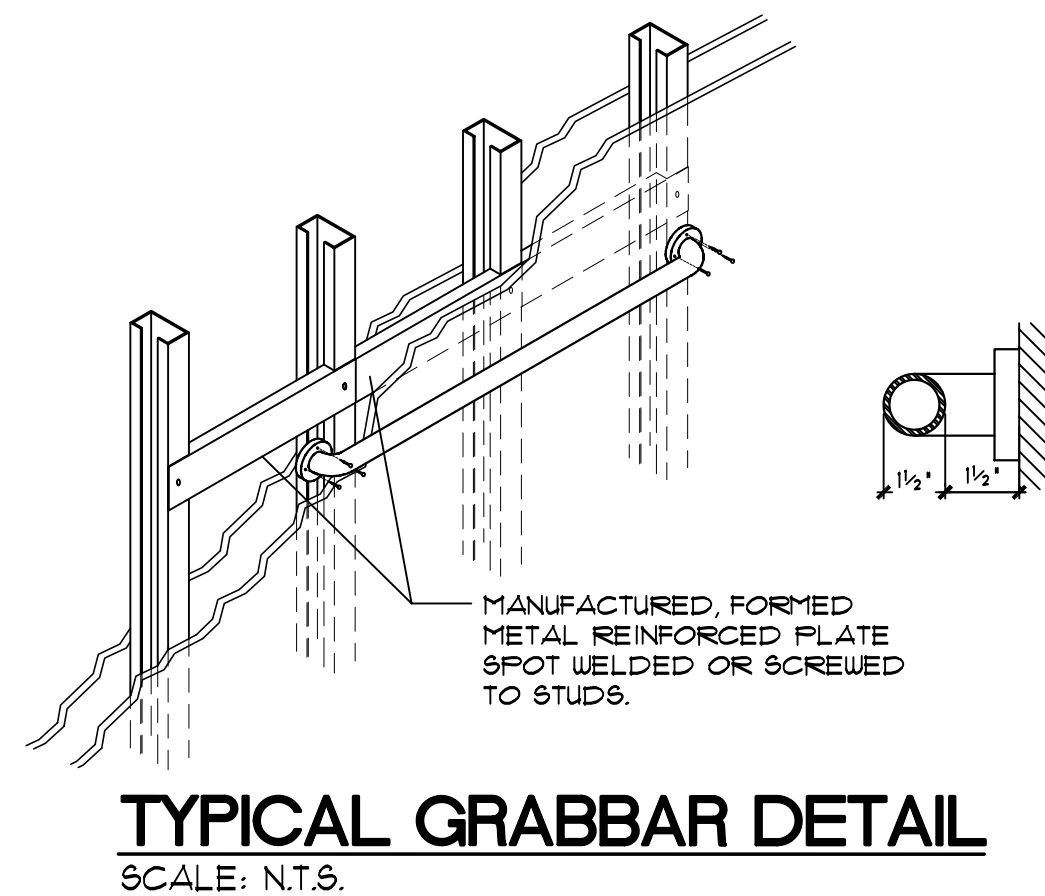

ENLARGED RESTROOM FLOOR TILE PLAN
SCALE: 1/4"=1'-0"

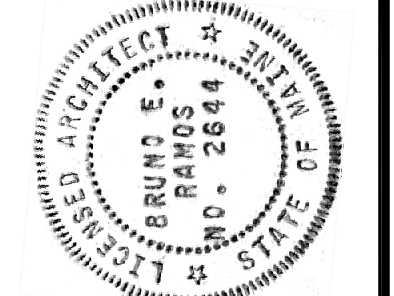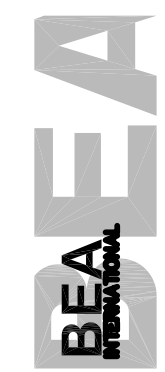

PAUL POTTLE
SIGNATURE
P. LICENCE NUMBER
DATE 12/23/05

PROJ. MANAGER	DATE	BY
PAUL POTTLE		
DESIGN-DETAILED		
CHECKED-REVIEWED		
DESIGN2-DETAILED2		
DESIGN3-DETAILED3		
REVISIONS 1	VAAP 22 DESIGN CHANGE 10/15/05	
REVISIONS 2	VAAP-VE-CODE CHANGES 12/23/05	
REVISIONS 3		
REVISIONS 4		
REVISIONS 5		
FIELD CHANGES		