
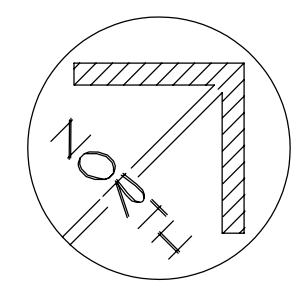


Filename:

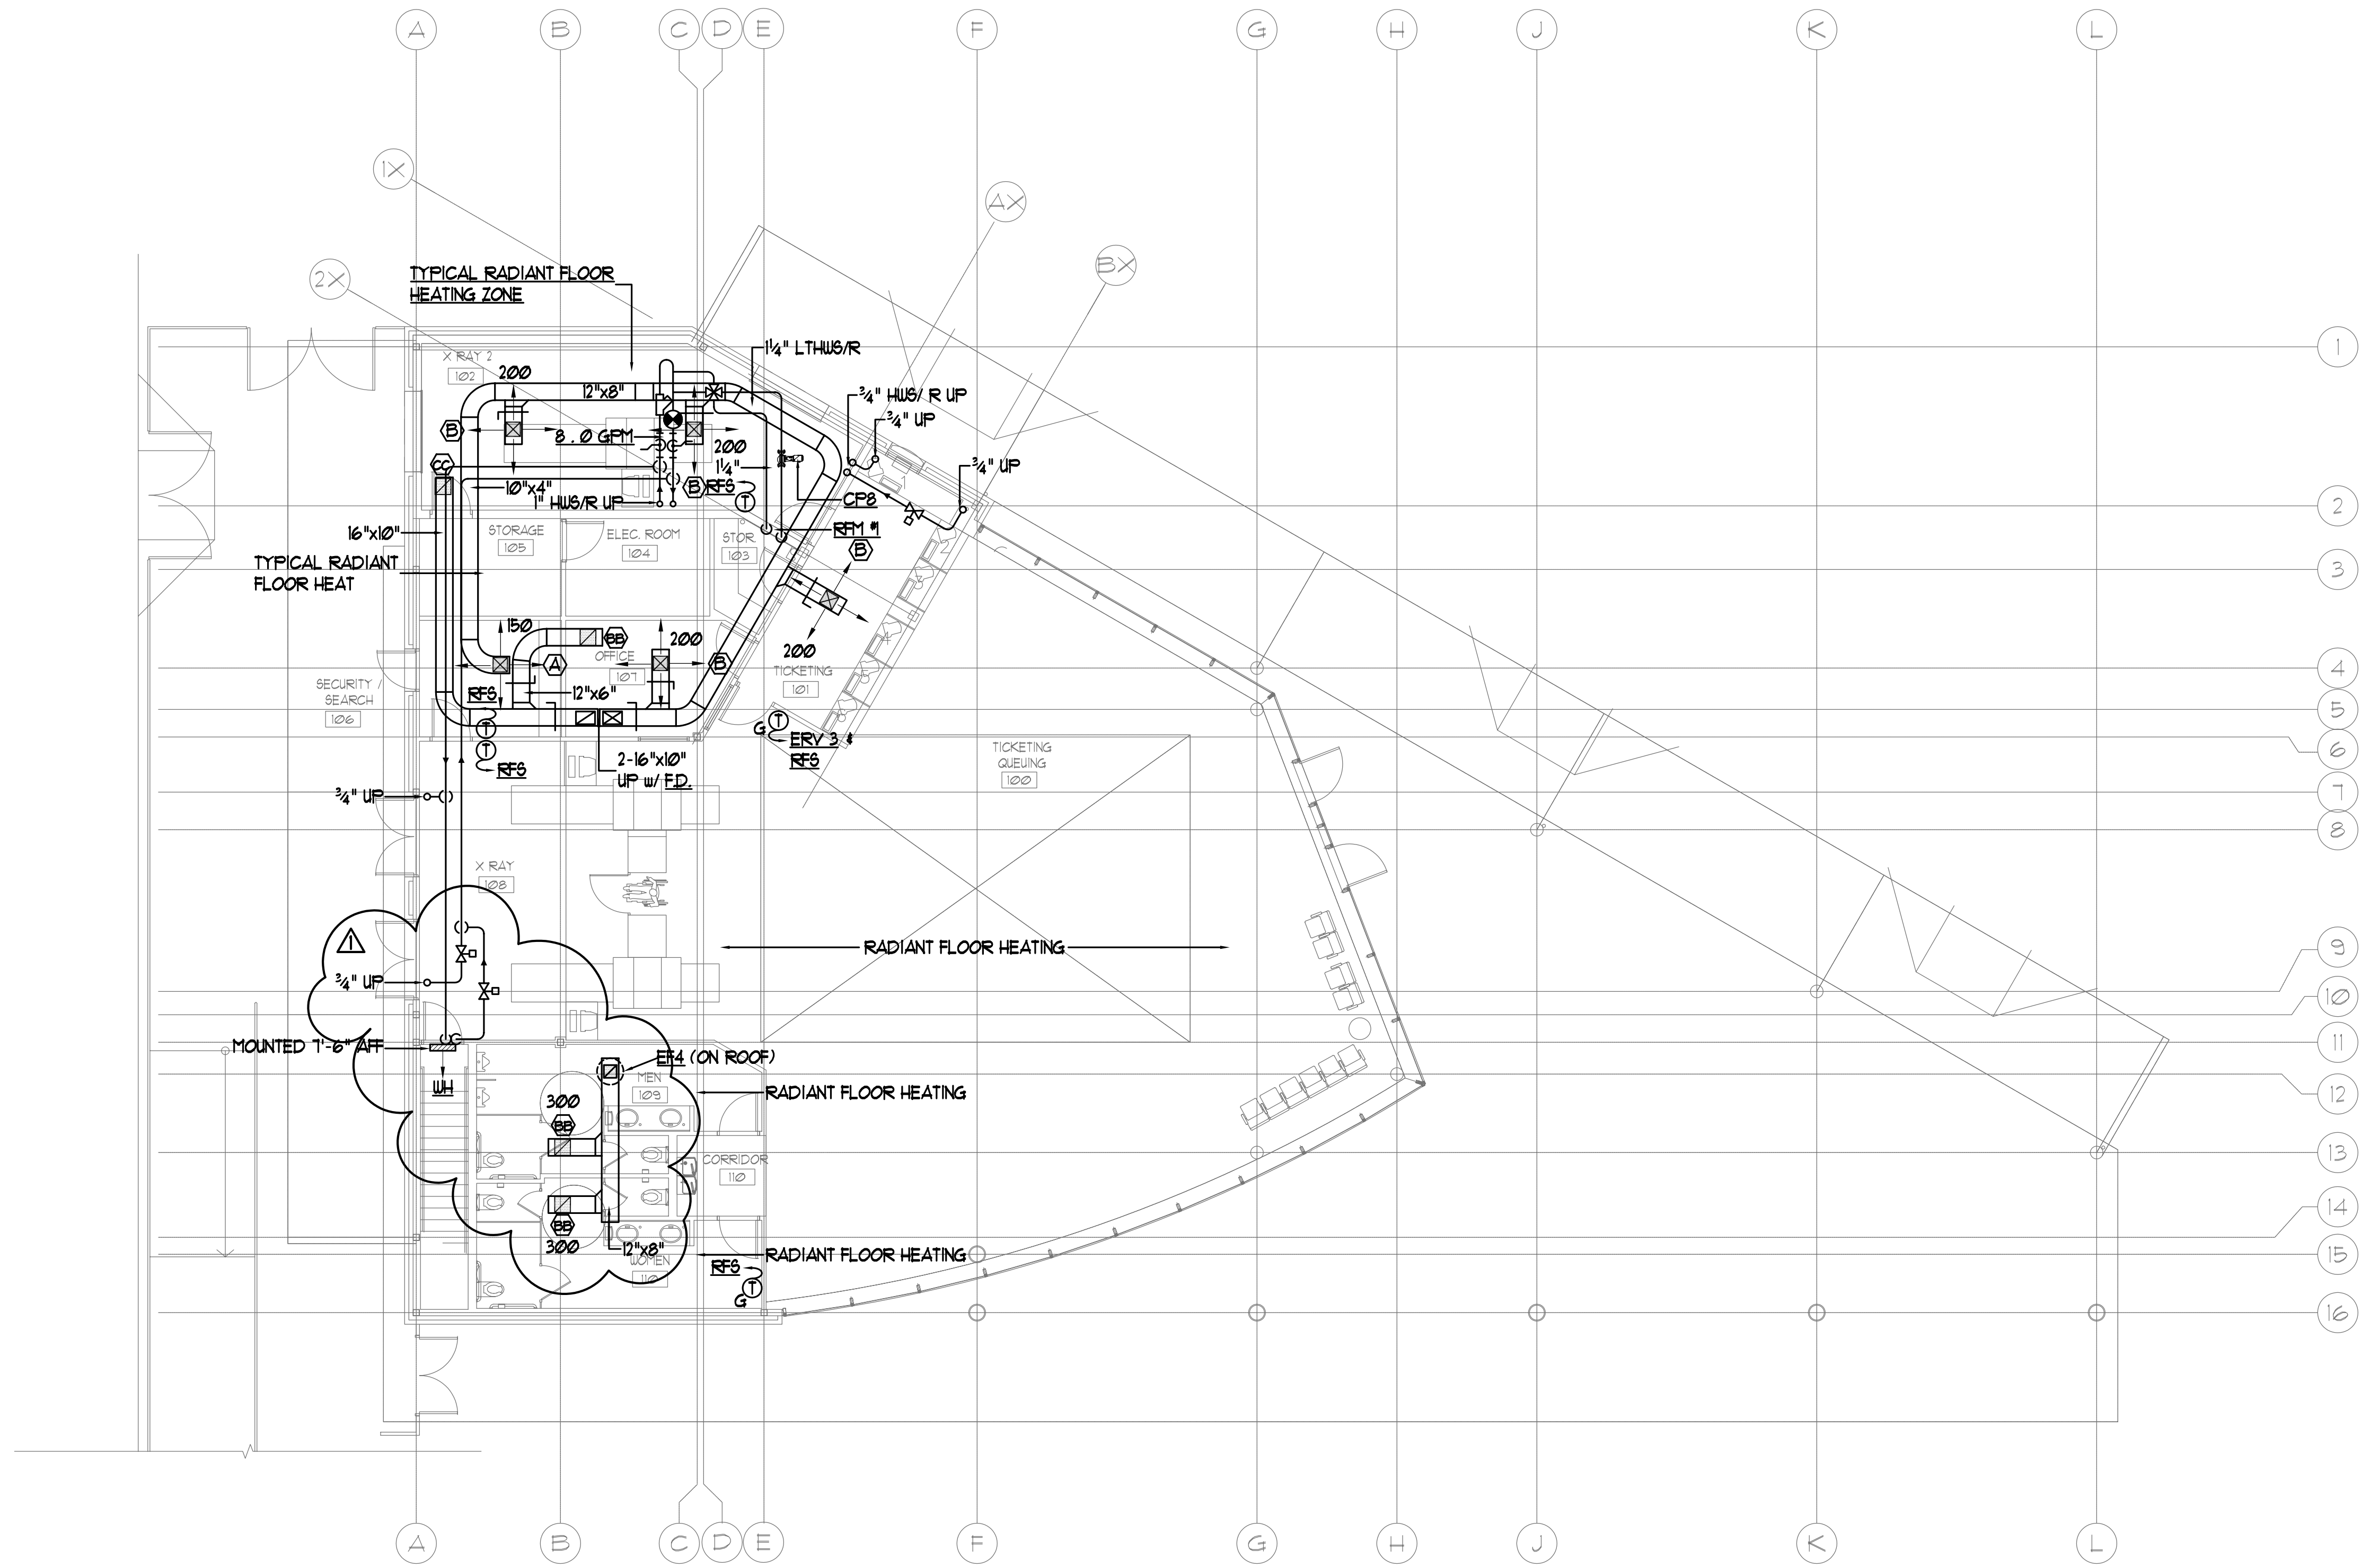


RECEIVING STATION GROUND FLOOR PLAN  
 SCALE 1/8" = 1'-0"

**BENNETT ENGINEERING**  
 CONSULTING ENGINEERS

7 Bennett Road  
 P.O. Box 297  
 Bangor, ME 04401  
 Tel - (207) 865-9475  
 Fax - (207) 865-1800  
 office@bennetteng.com

STATE OF MAINE  
 DEPARTMENT OF TRANSPORTATION  
 PROJECT NUMBER 009215.00  
 PIN  
 009215.00

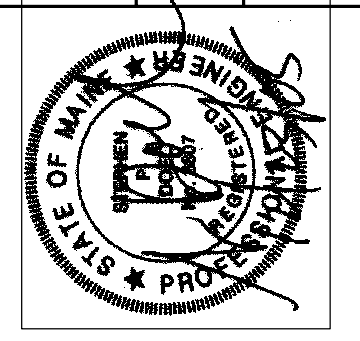

PROJ. MANAGER	PAUL POTTE	BY	DATE
DESIGN-DETAILED	SMR	SP DOEL	10/05/04
CHECKED-REVIEWED	SMR	SP DOEL	10/05/04
DESIGN2-DETAILED2	SMR	SP DOEL	10/05/04
DESIGN3-DETAILED3	SMR	SP DOEL	10/05/04
REVISIONS 1	VAAP	20.1/VE	12/23/05
REVISIONS 2			
REVISIONS 3			
REVISIONS 4			
FIELD CHANGES			

CITY OF PORTLAND  
 OCEAN GATEWAY PHASE 1  
 RECEIVING STATION  
 HVAC FIRST FLOOR PLAN

H100-R  
 250 OF 288