


Filename:

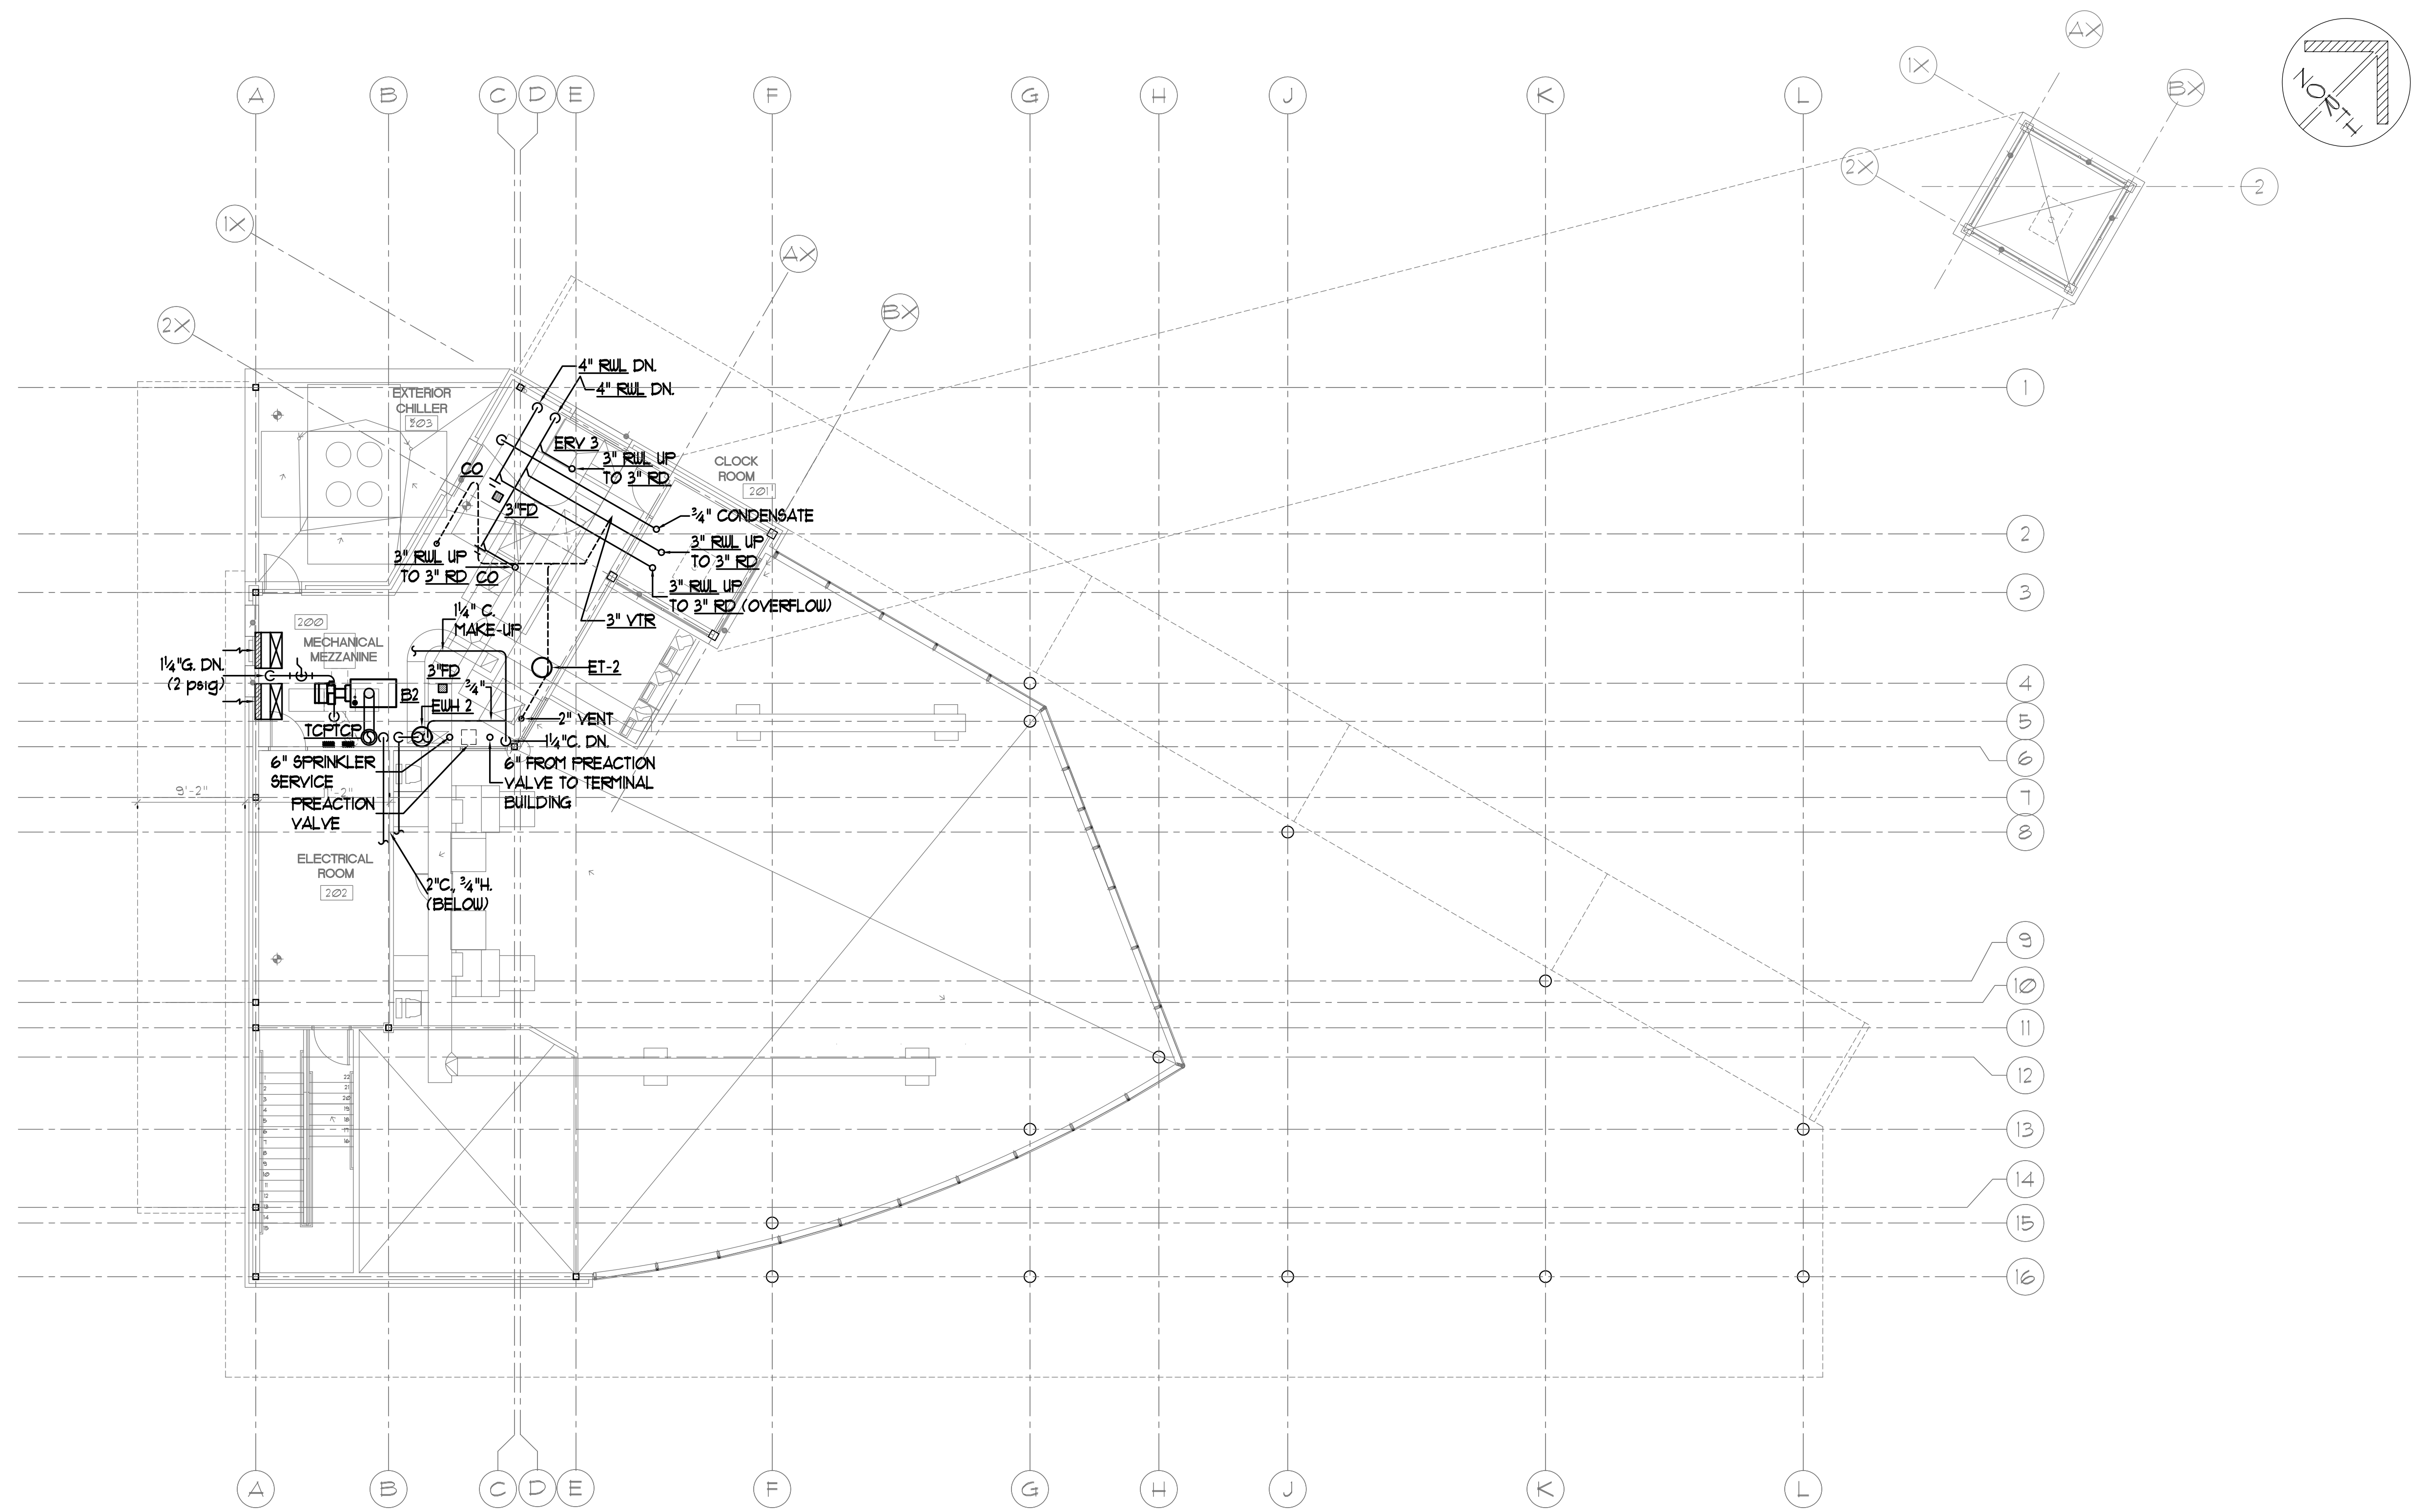


RECEIVING STATION MEZZANINE FLOOR PLAN
SCALE 1/8" = 1'-0"



7 Bennett Road
P.O. Box 297
Portland, ME 04106
Tel - (207) 865-0475
Fax - (207) 865-1800
office@bennettengineering.net

STATE OF MAINE
DEPARTMENT OF TRANSPORTATION
PROJECT NUMBER 009215.00
PIN
009215.00

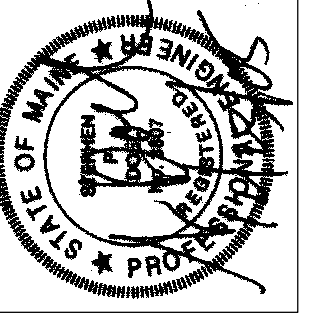

PROJ. MANAGER	PAUL POTTLE	BY	DATE
DESIGN-DETAILED	SMR	SP	DOEL 10/05/04
CHECKED-REVIEWED	SMR	SP	DOEL 10/05/04
DESIGN2-DETAILED2			
DESIGN3-DETAILED3			
REVISIONS 1	VAAP 201/VE		12/23/05
REVISIONS 2			
REVISIONS 3			
REVISIONS 4			
REVISIONS 5			
FIELD CHANGES			

CITY OF PORTLAND
OCEAN GATEWAY PHASE 1
RECEIVING STATION
PLUMBING MEZZANINE PLAN

P101-R
253 OF 288