



7 Pleasant Road  
 Portland, ME 04103  
 Tel: (207) 865-9475  
 office@bennett-engineering.net

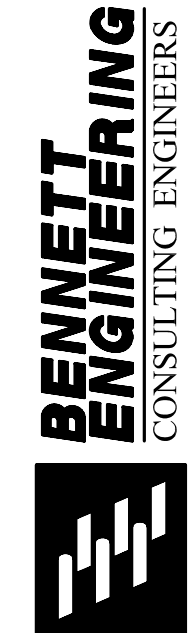


STATE OF MAINE  
 DEPARTMENT OF TRANSPORTATION  
 PROJECT NUMBER 009215.00  
 PIN  
 009215.00

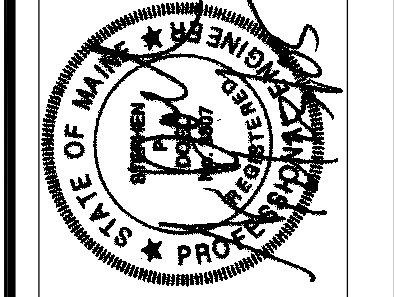

PROJ. MANAGER	DATE	BY	DATE
PAUL POTTLE	10/05/04	SP DOEL	10/05/04
DESIGN-DETAILED		SMR	
CHECKED-REVIEWED		SP DOEL	10/05/04
DESIGN2-DETAILED2		SMR	
DESIGN3-DETAILED3		VAAP	12/23/05
REVISIONS 1		VAAP	22/AE
REVISIONS 2			
REVISIONS 3			
REVISIONS 4			
FIELD CHANGES			

CITY OF PORTLAND  
 OCEAN GATEWAY PHASE 1  
 TERMINAL BUILDING  
 LOWER LEVEL HVAC PLAN

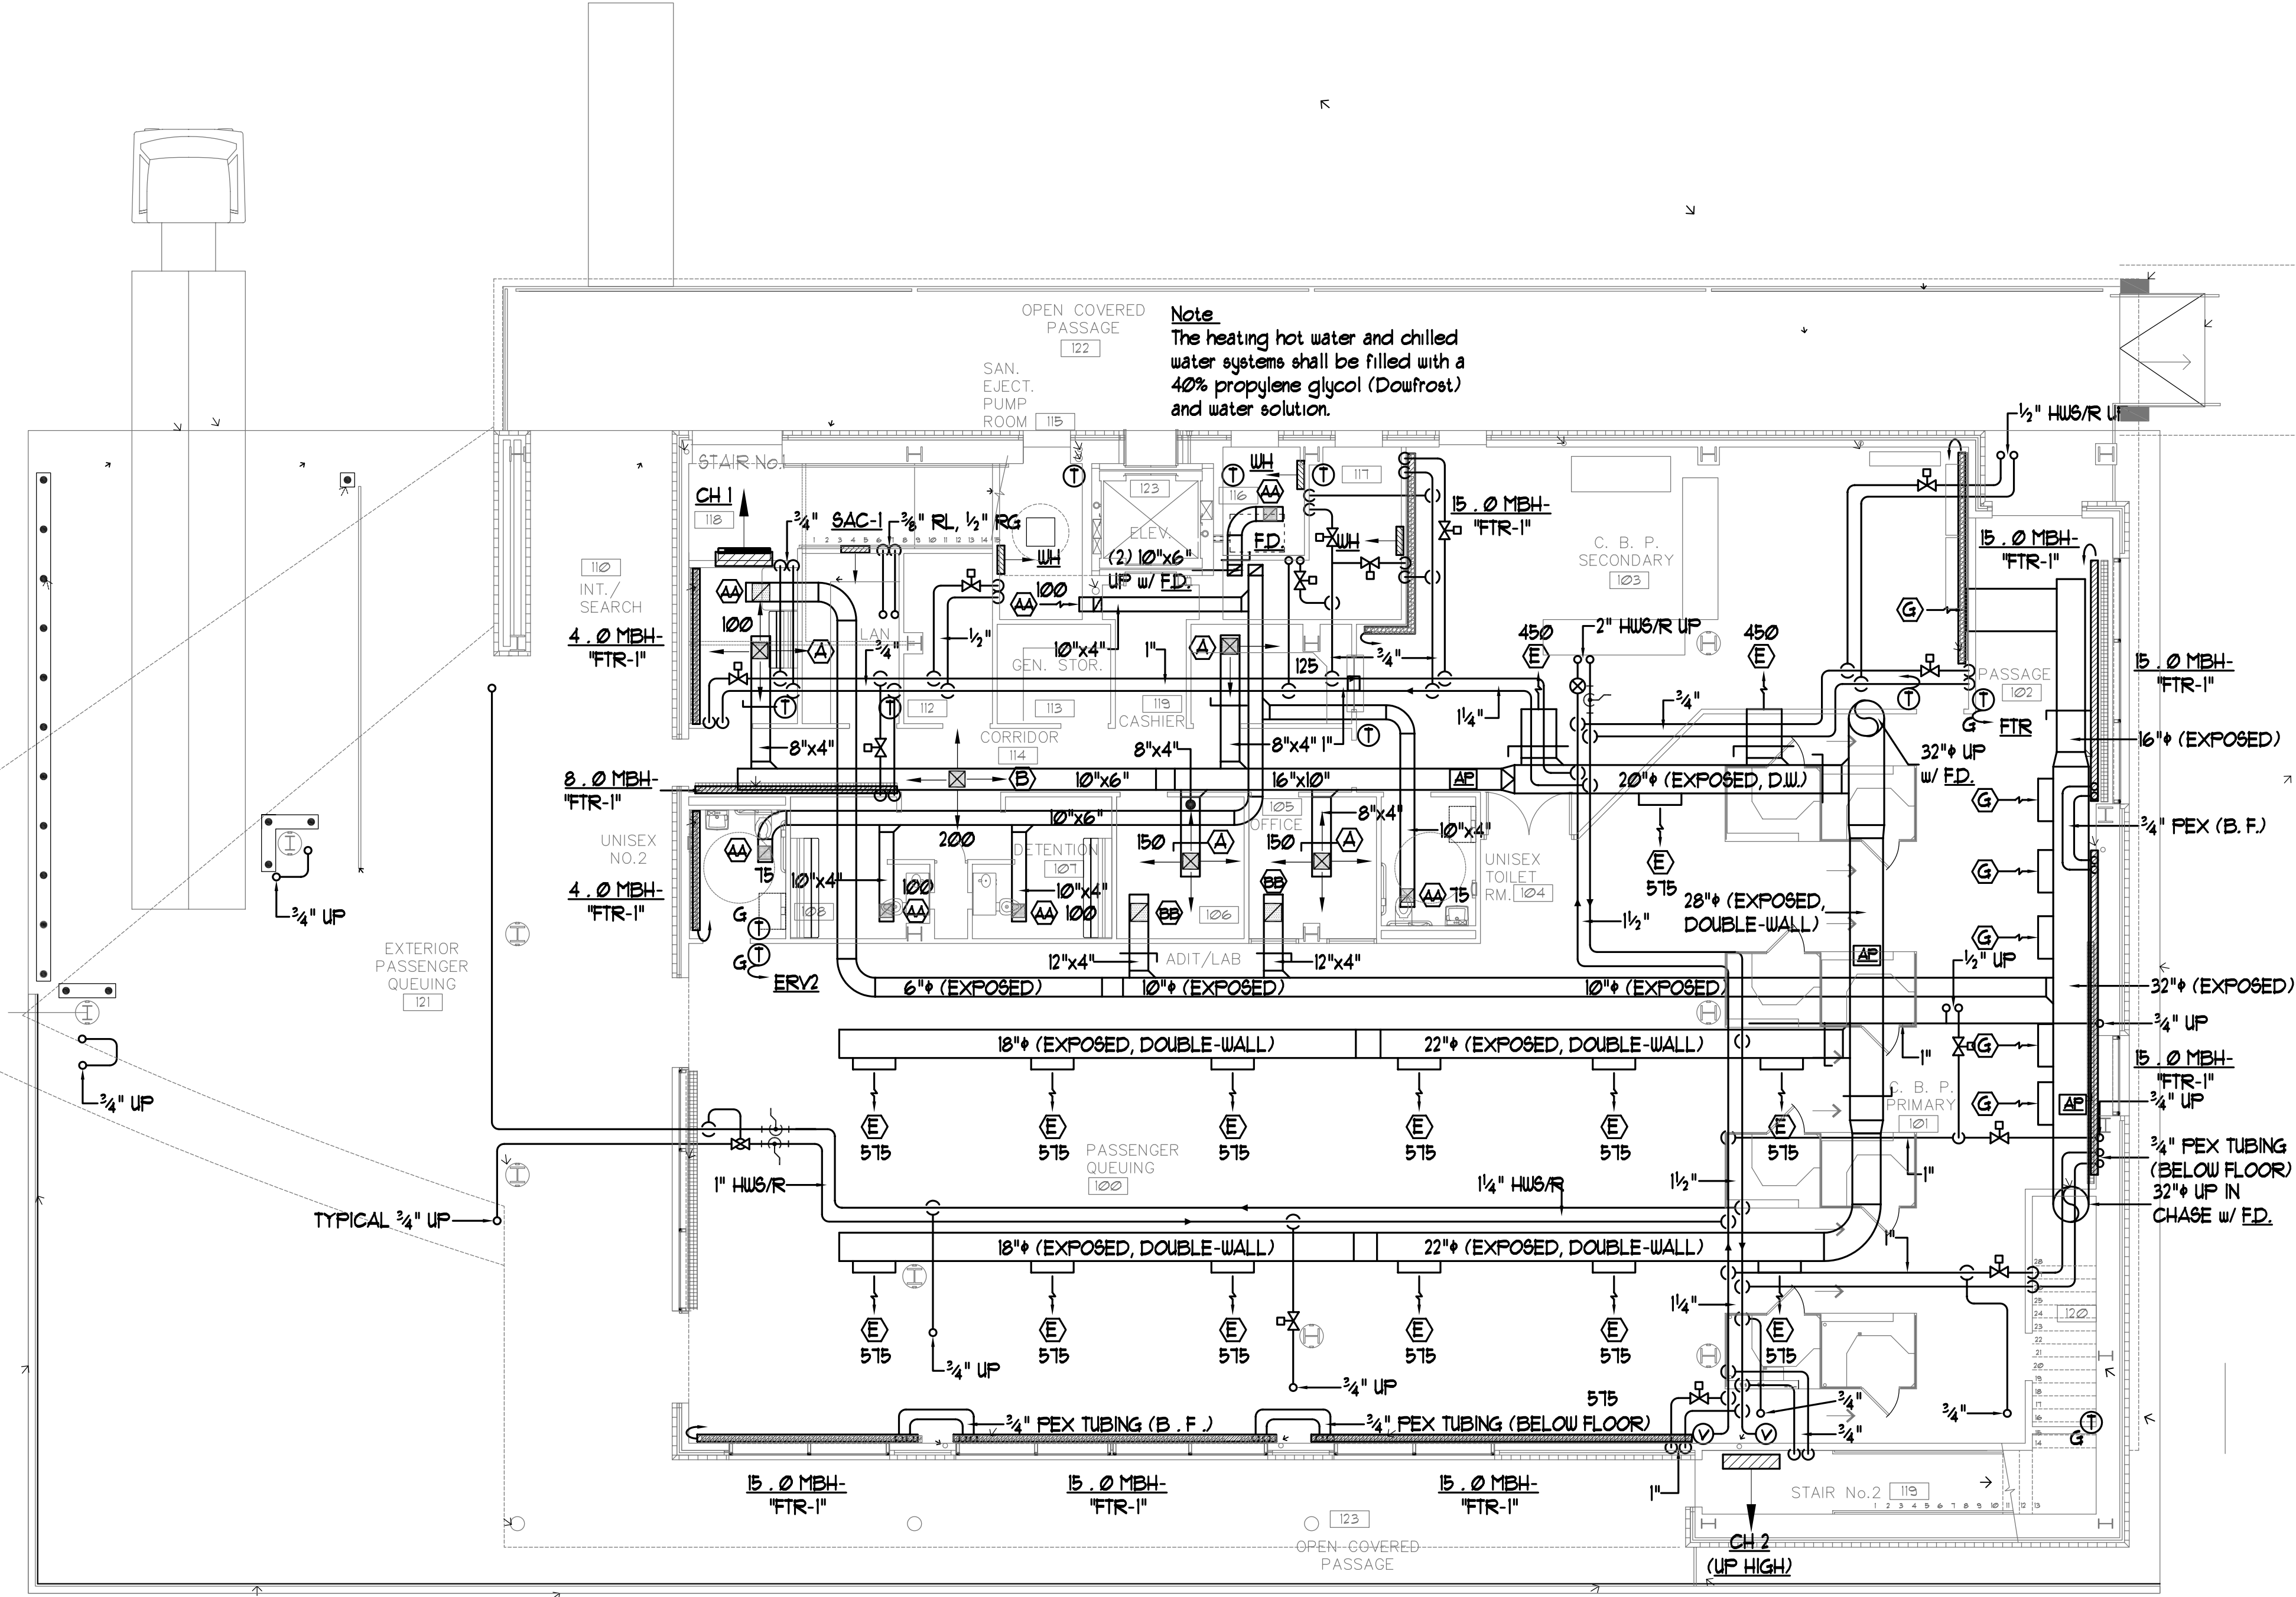

Note:  
 The heating hot water and chilled water systems shall be filled with a 40% propylene glycol (Dowfrost) and water solution.

TERMINAL BUILDING LOWER LEVEL PLAN  
 SCALE 1/8"=1'-0"

H100-T