


1 MAIN FLOOR LIGHTING PLAN
1/8" = 1'-0"


DRAWING NOTES:
1. SEE SHEET E303 FOR EMERGENCY LIGHTING WIRING AND EXTERIOR LIGHTING WIRING CONTROL DIAGRAMS.

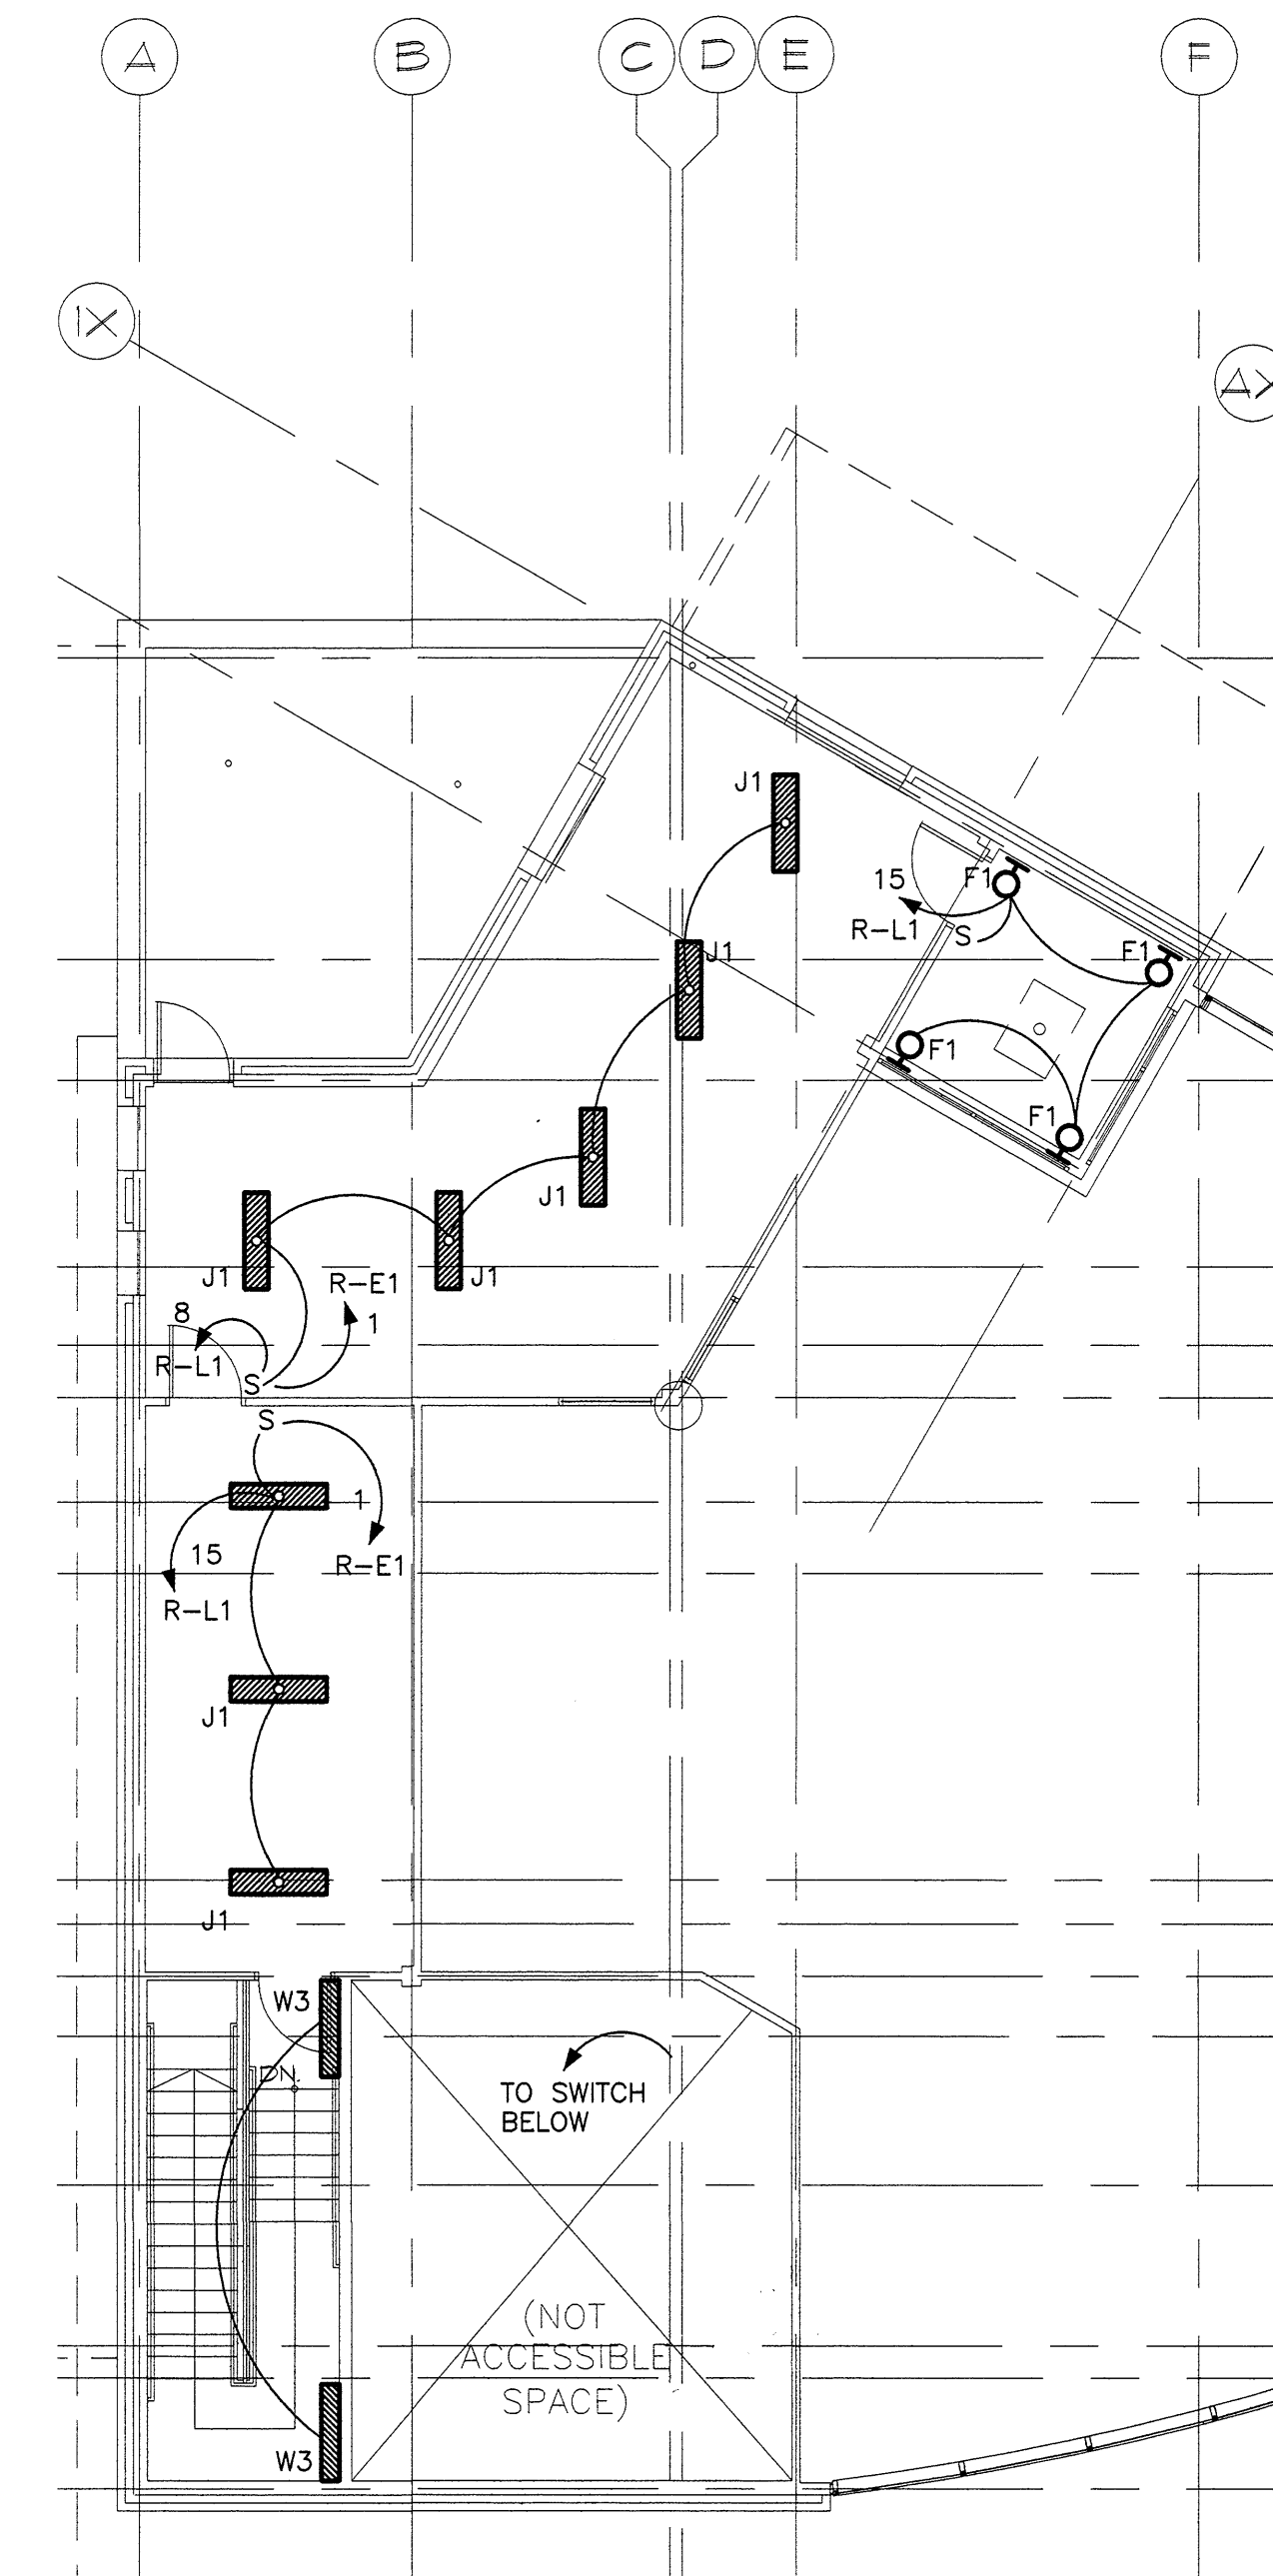

2 MEZZANINE LIGHTING PLAN
1/8" = 1'-0"

Bartlett Design
LIGHTING & ELECTRICAL ENGINEERING
942 WASHINGTON STREET, PORTLAND, ME 04108
TEL: (207) 443-3447 FAX: (207) 443-3680

STATE OF MAINE
DEPARTMENT OF TRANSPORTATION
PROJECT NUMBER 009215.00
PIN
009215.00

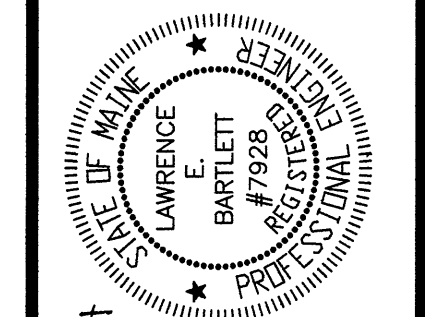

Lawrence E. Bartlett
SIGNATURE
7-12-05
P.E. NUMBER
12/23/05
DATE

PROJ. MANAGER	DATE	BY	DATE
PAUL POTLE	10/27/04	J.C. LEB	
DESIGN-DETAILED		LEB	
CHECKED-REVIEWED		LEB	
DESIGN-DETAILED2			
DESIGN-DETAILED3			
REVISIONS 1	12/23/05	WAP 201/VE	
REVISIONS 2			
REVISIONS 3			
REVISIONS 4			
FIELD CHANGES			

CITY OF PORTLAND
OCEAN GATEWAY PHASE 1
RECEIVING BUILDING
LIGHTING PLAN

E101-R