


Filename:

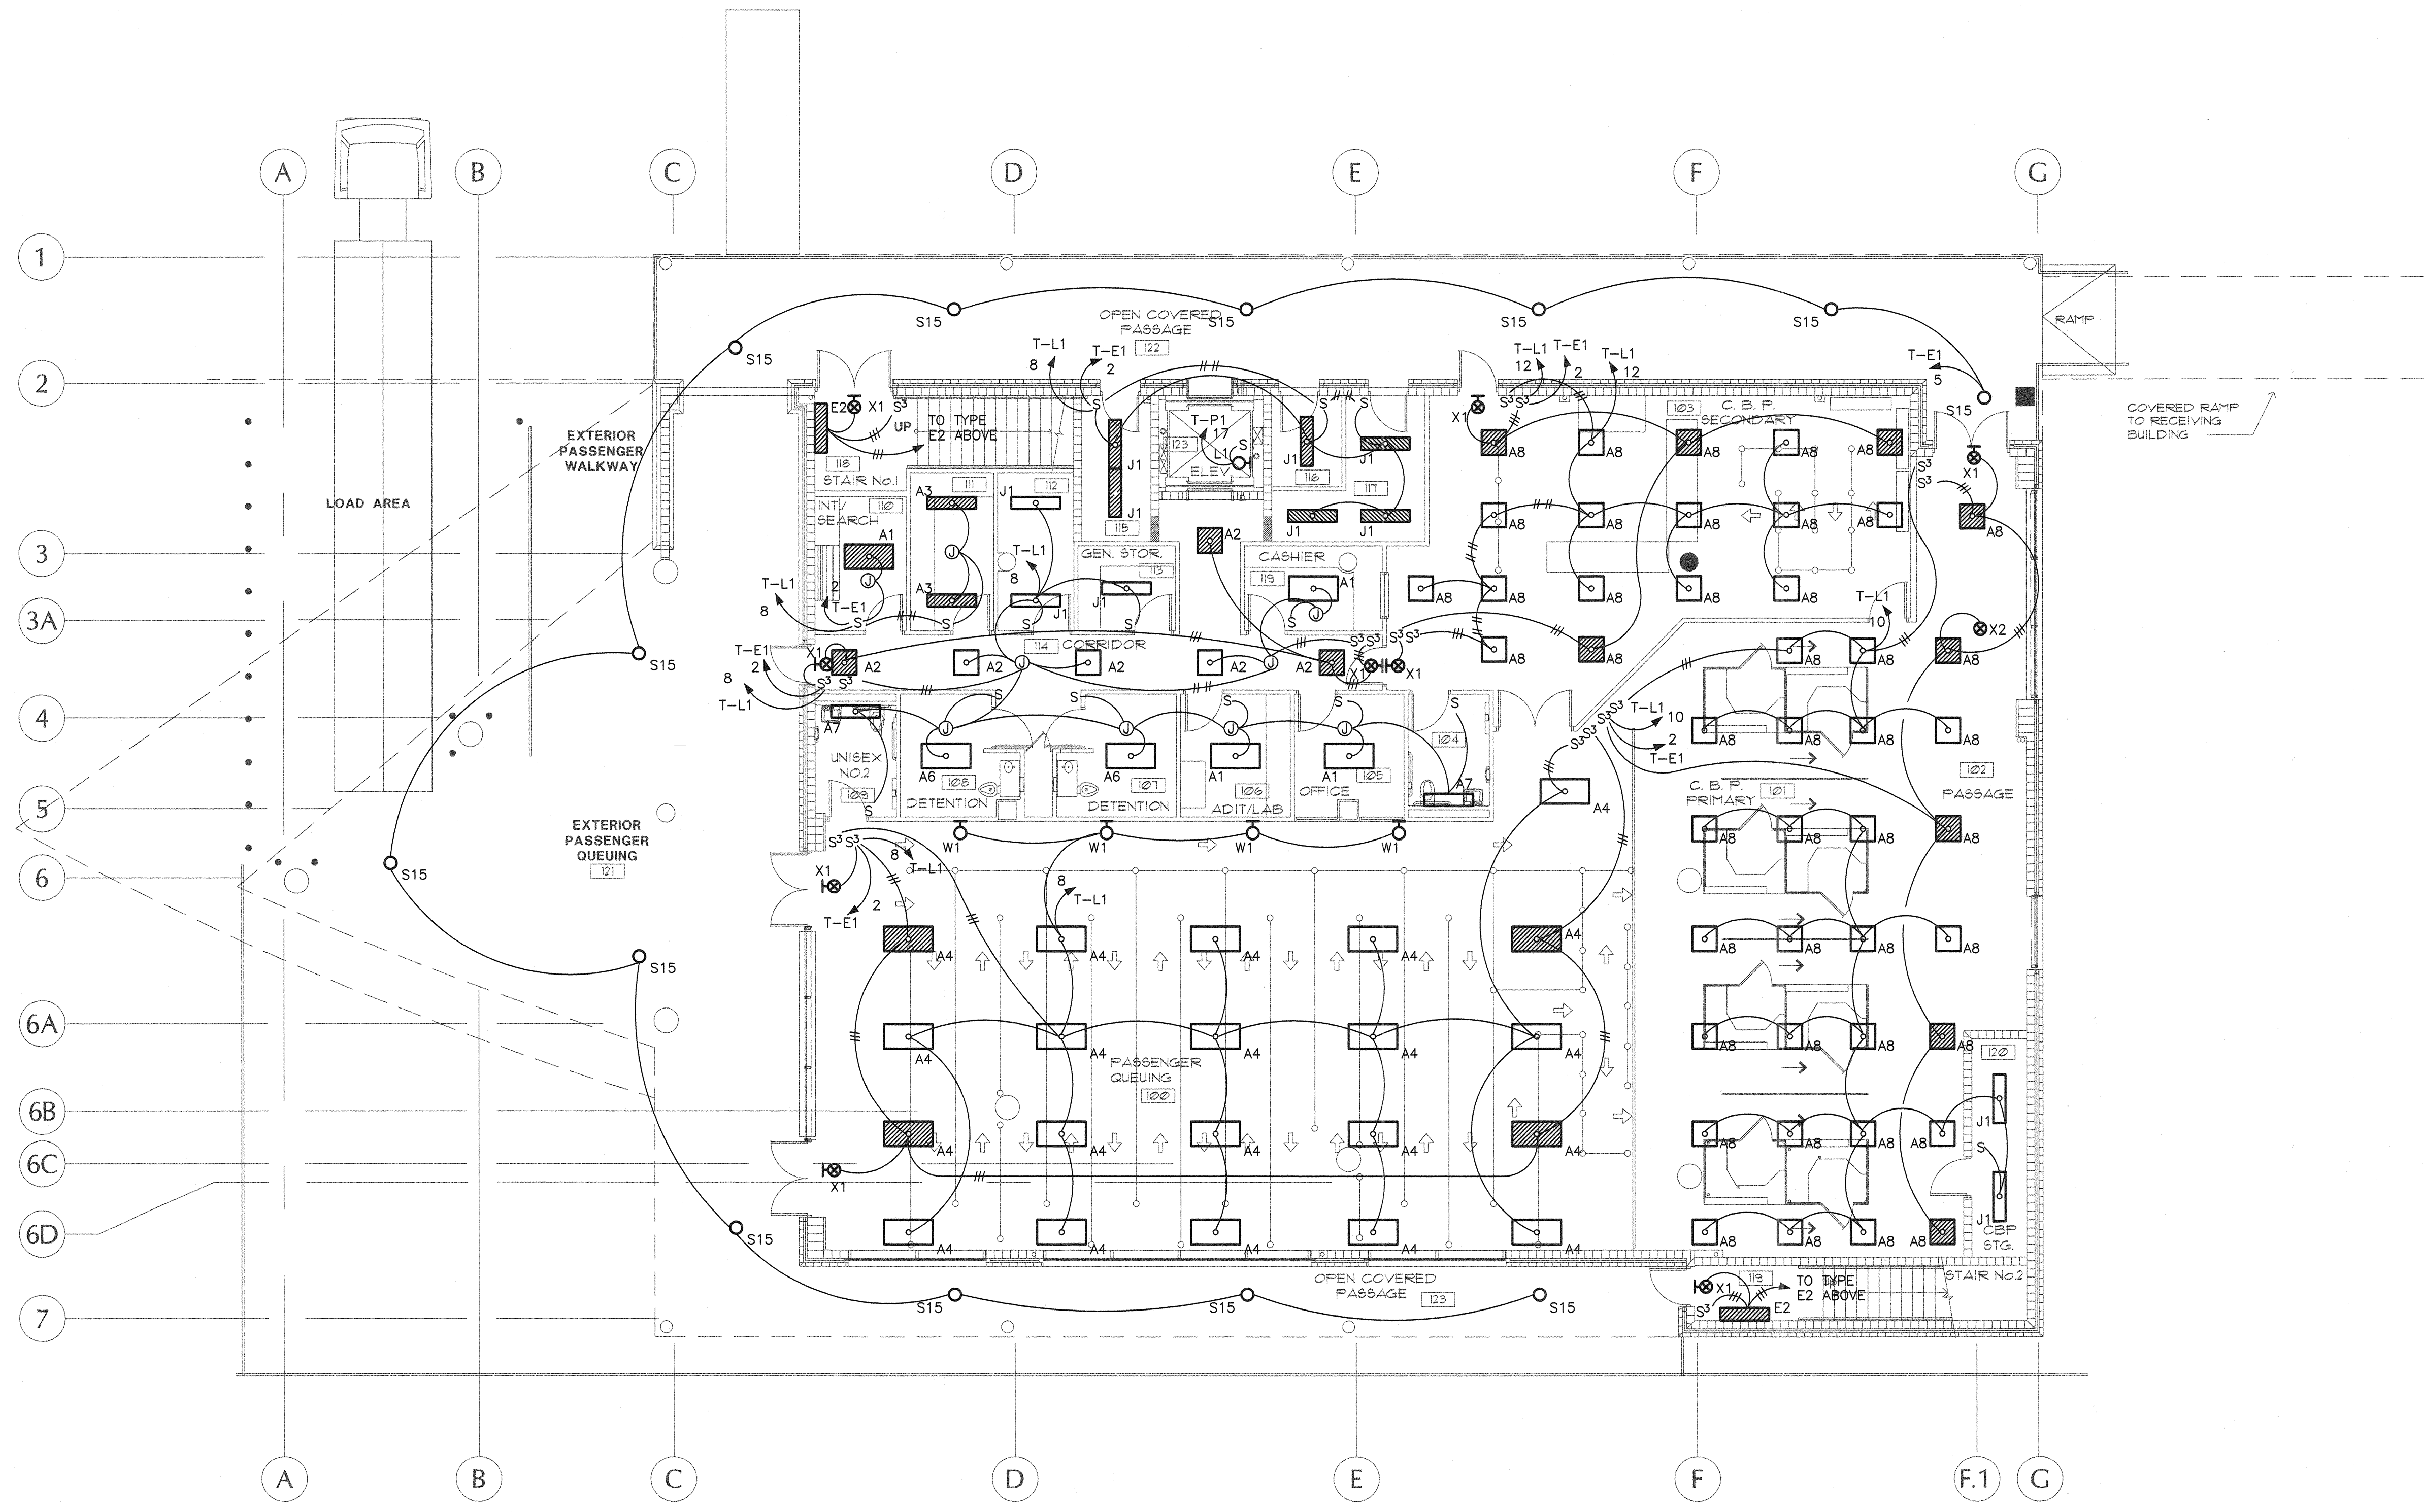


1 FIRST FLOOR LIGHTING PLAN
1/8" = 1'-0"

DRAWING NOTES:
1. SEE SHEET E302 FOR EMERGENCY LIGHTING WIRING AND EXTERIOR LIGHTING WIRING CONTROL DIAGRAMS.

Bartlett Design
LIGHTING & ELECTRICAL ENGINEERING
212 BOSTON STREET, PORTLAND, ME 04101
TEL (207) 443-5447 FAX (207) 443-5800

STATE OF MAINE
DEPARTMENT OF TRANSPORTATION
PROJECT NUMBER 009215.00
PIN
009215.00

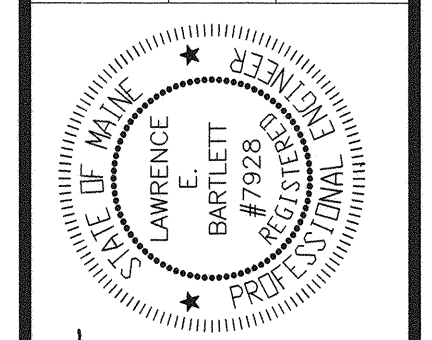

Lawrence C. Bartlett
SIGNATURE
7978
P.E. NUMBER
10/27/04
DATE

PROJ. MANAGER	PAUL POTTE	DATE
DESIGN-DETAILED	J.C.	10/27/04
CHECKED-REVIEWED	LEB	
DESIGN2-DETAILED2	LEB	
DESIGN3-DETAILED3		
REVISIONS 1		
REVISIONS 2		
REVISIONS 3		
REVISIONS 4		
FIELD CHANGES		

CITY OF PORTLAND
OCEAN GATEWAY PHASE 1
FIRST FLOOR
FERRY TERMINAL LIGHTING PLAN

E101-T