


RESERVED FOR CITY STAMP

REVISION	DESCRIPTION	DATE
0	ISSUED FOR REVIEW & APPROVAL	8/14/2017

**CUNNINGHAM**  
**Security Systems**  
 10 Princes Point Road, Yarmouth, Maine 04096  
 Office: 207.846.3350 • Fax: 207.846.6080

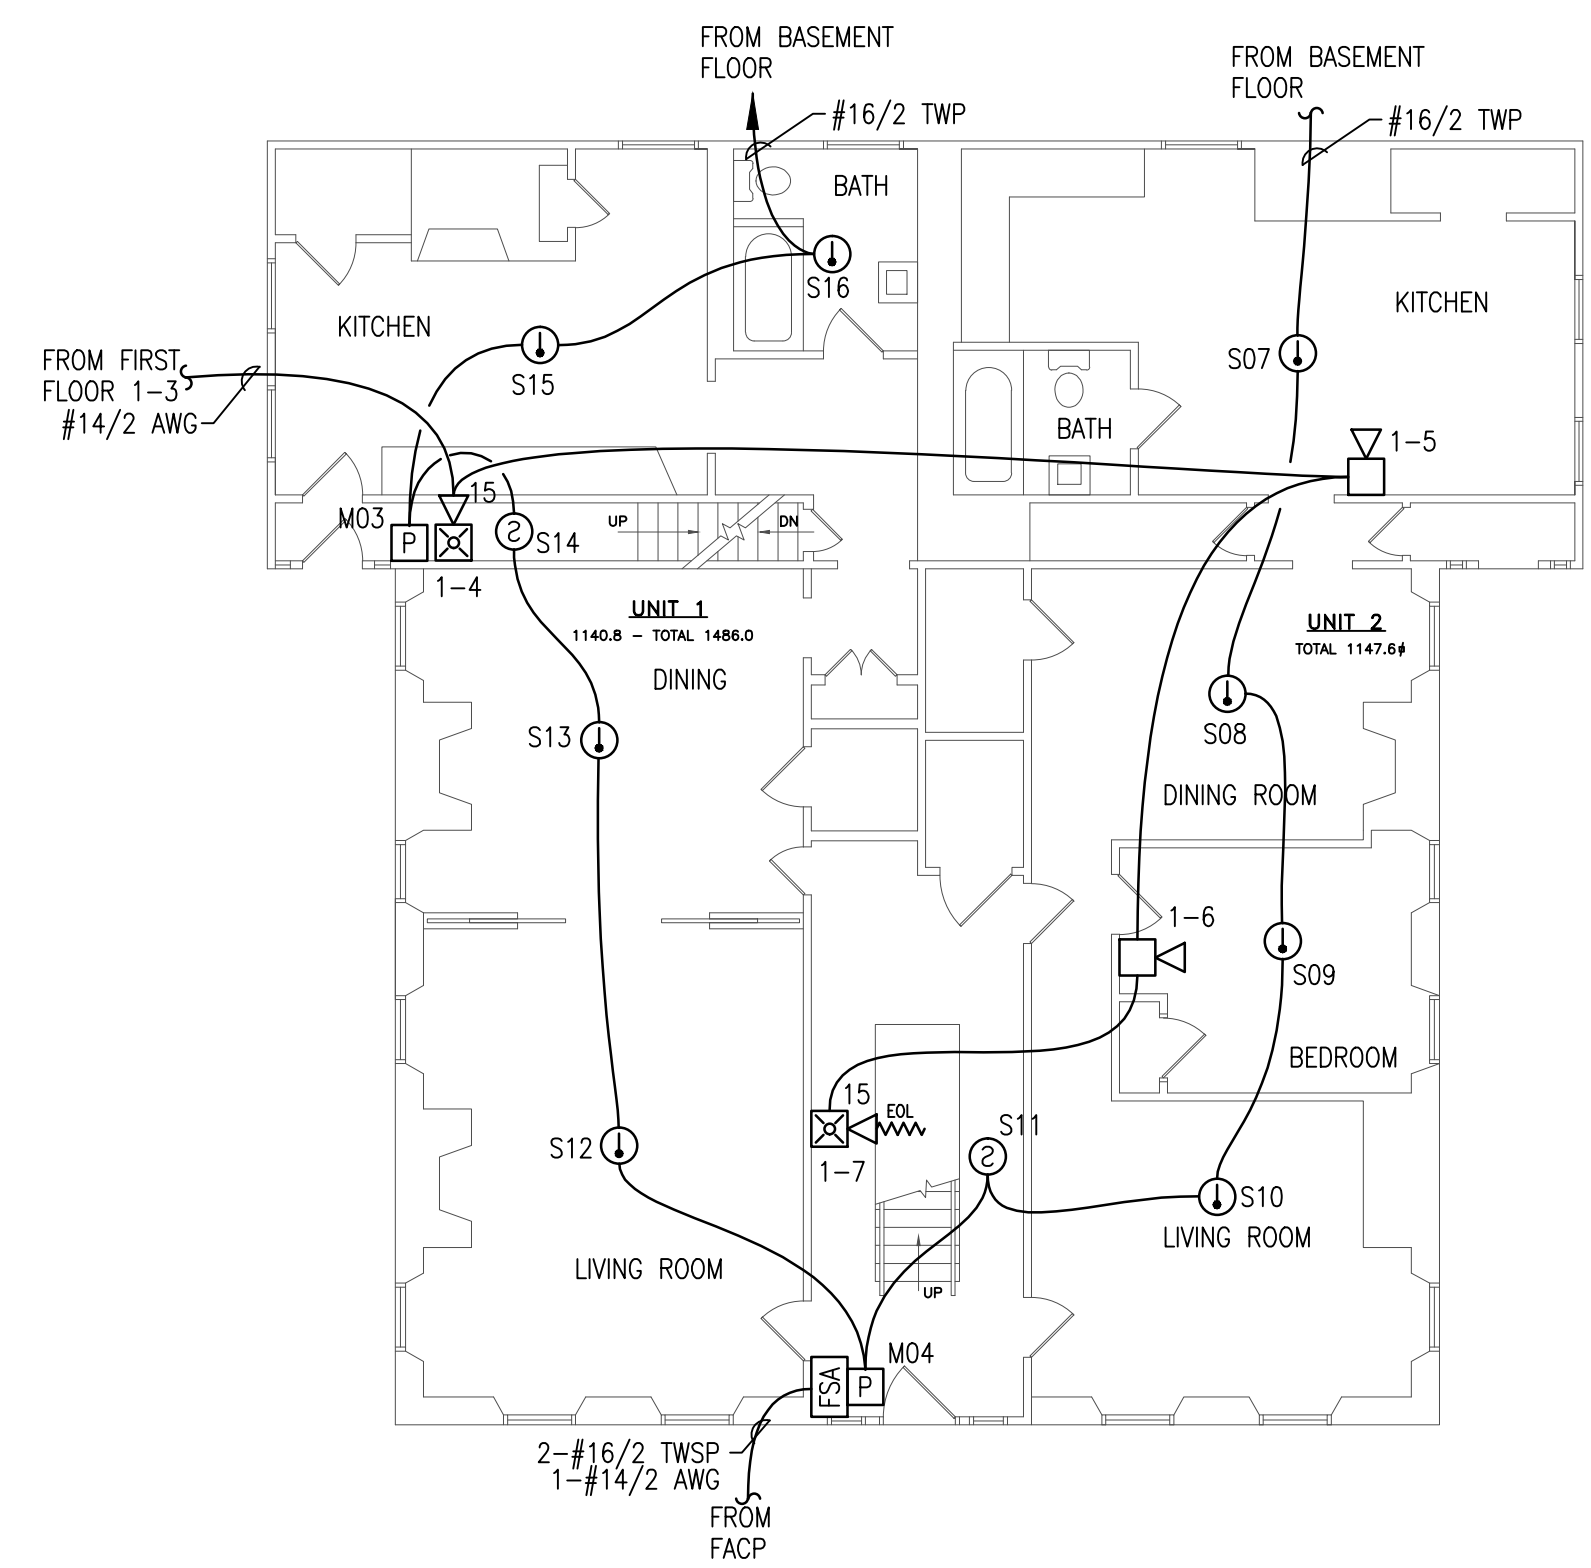

**FIRST FLOOR  
 FIRE ALARM PLAN**  
 SCALE: 1/8"=1'-0" 0 4' 8' 16'

**49 PARK STREET  
 PORTLAND, ME**

**FIRST FLOOR FIRE ALARM PLAN**

DRAWN	CWS UNICAD JOB #17538
CHECKED	BRADY B. HAWS NICET III 138751
DATE	8/14/2017
REVISION	0
SCALE	1/8"=1'-0"

Shop drawings created by:  
 5794 W. 4900 St.  
 Haverhill, UT 84313  
 Office: 801.955.0410  
 www.unicad.net

**UNICAD** Inc.  
 Fire Alarm Design & Drafting Services

**FA-2**