

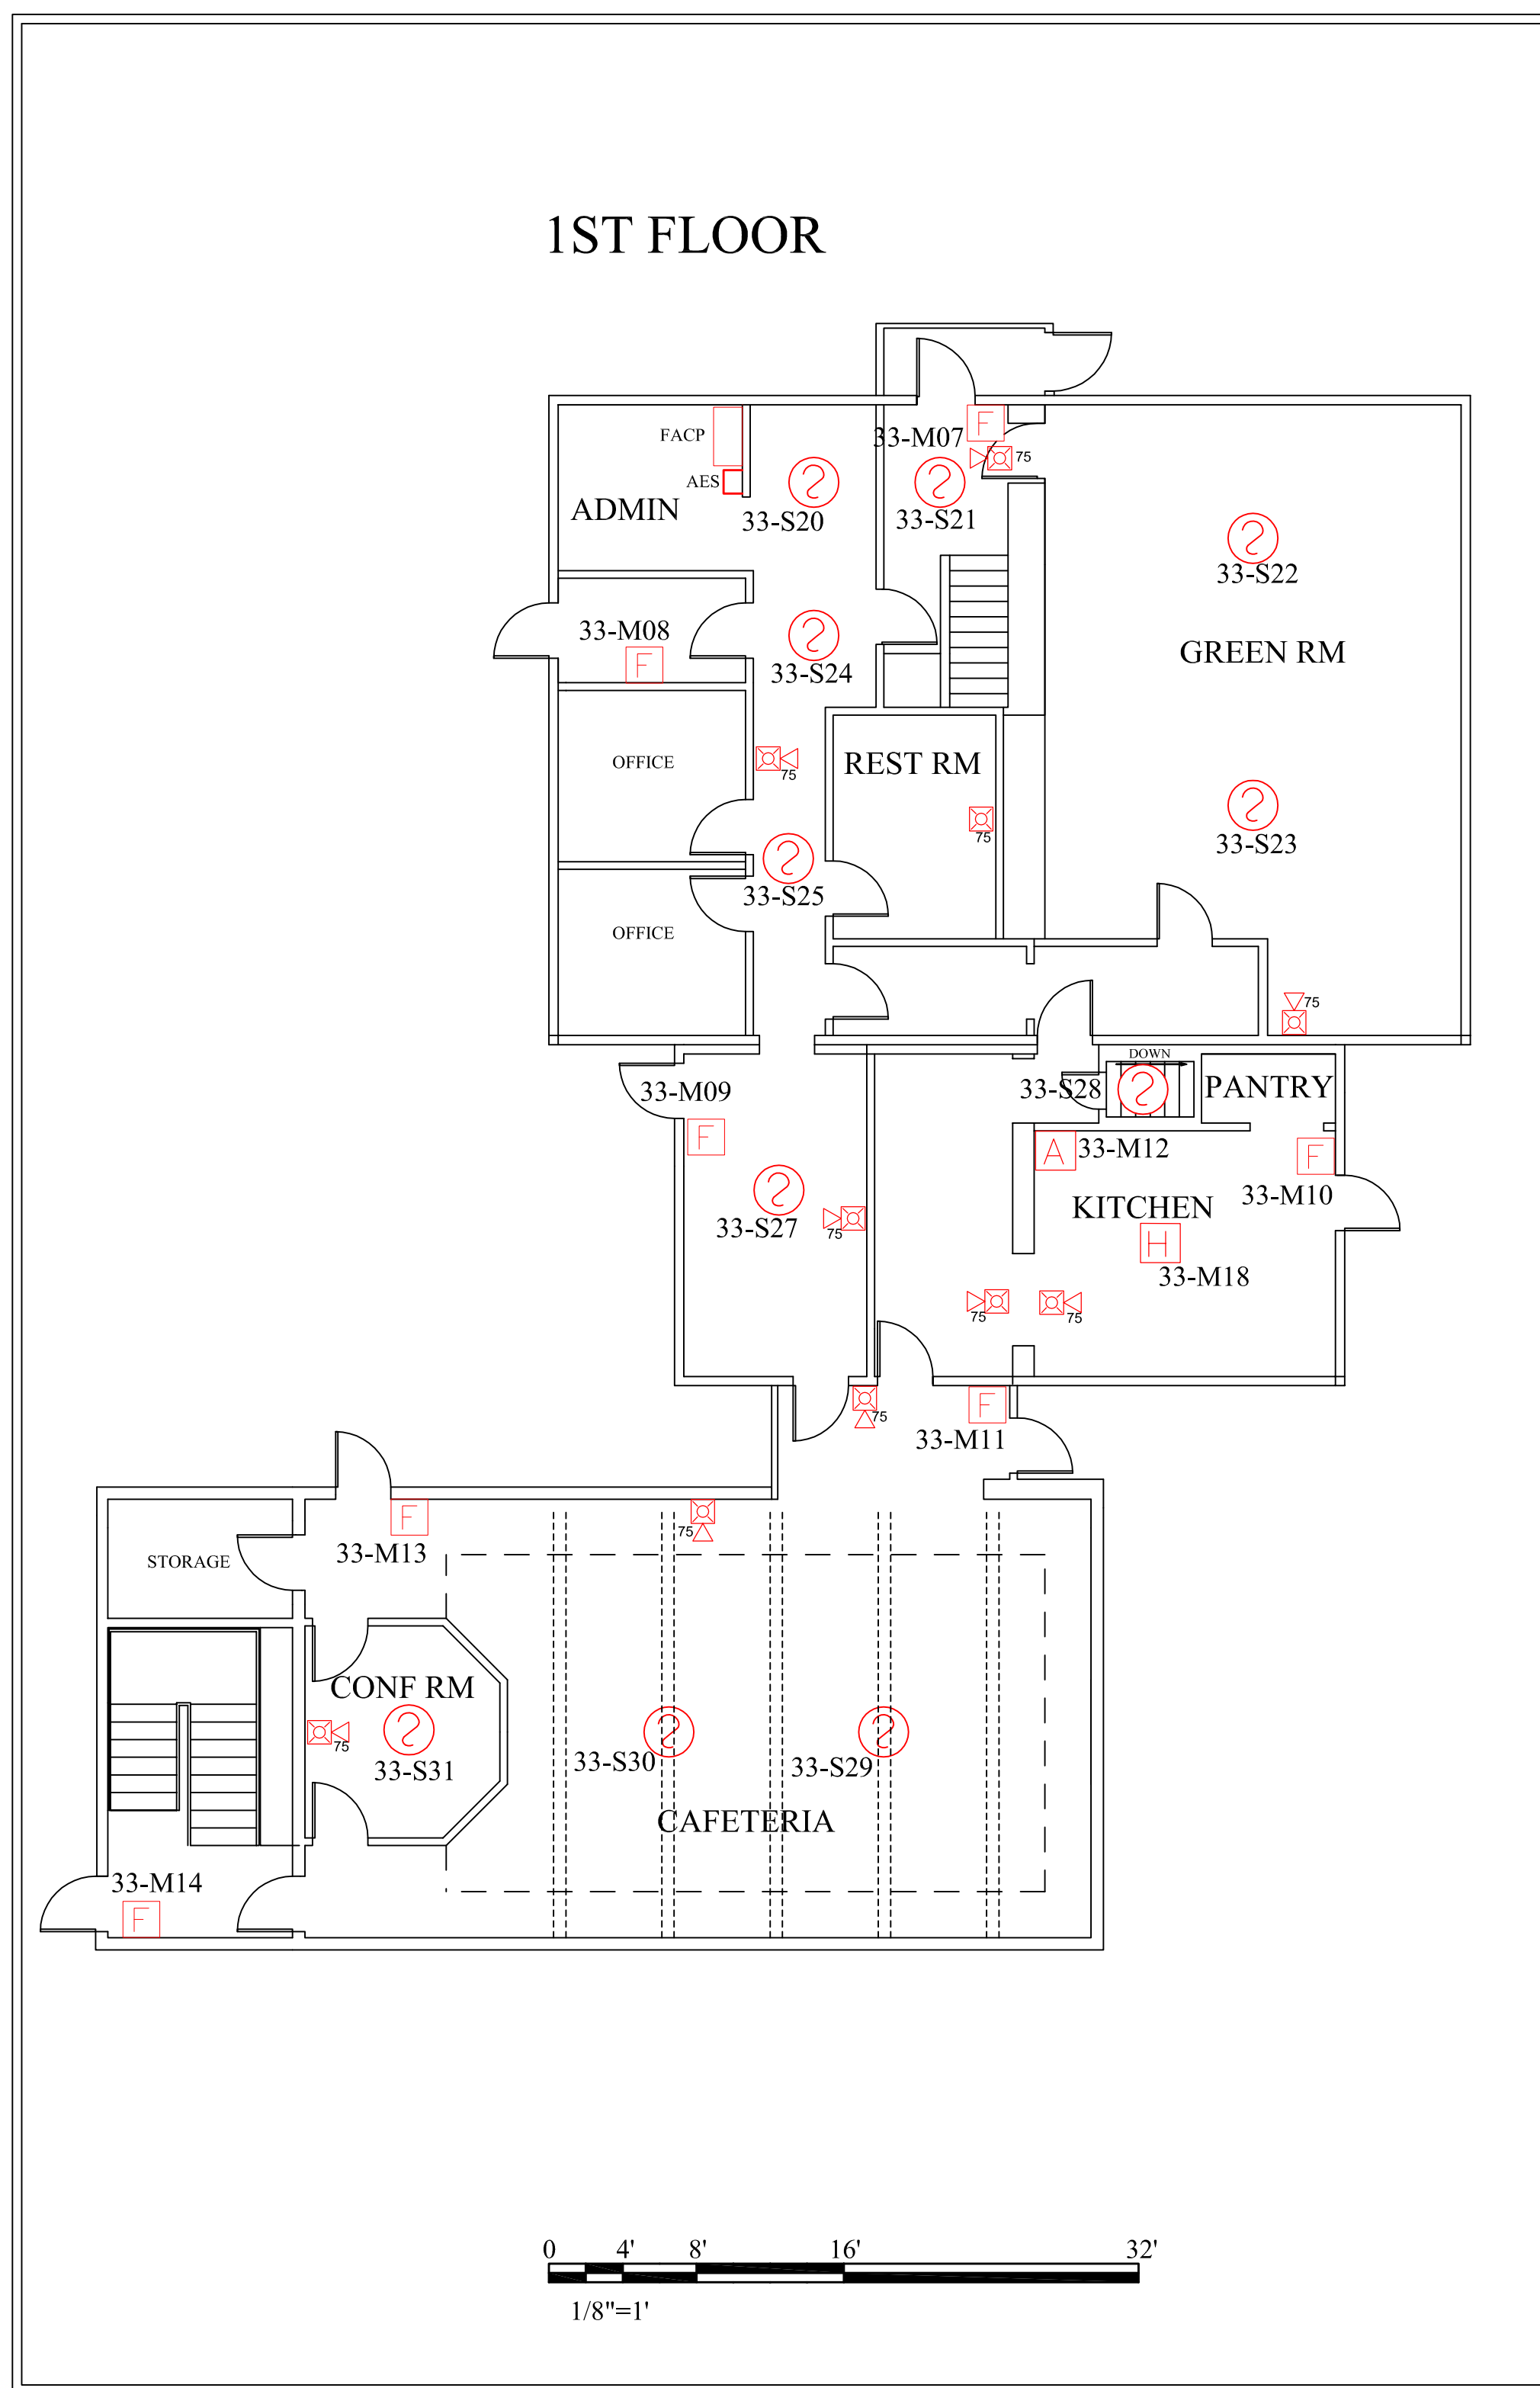
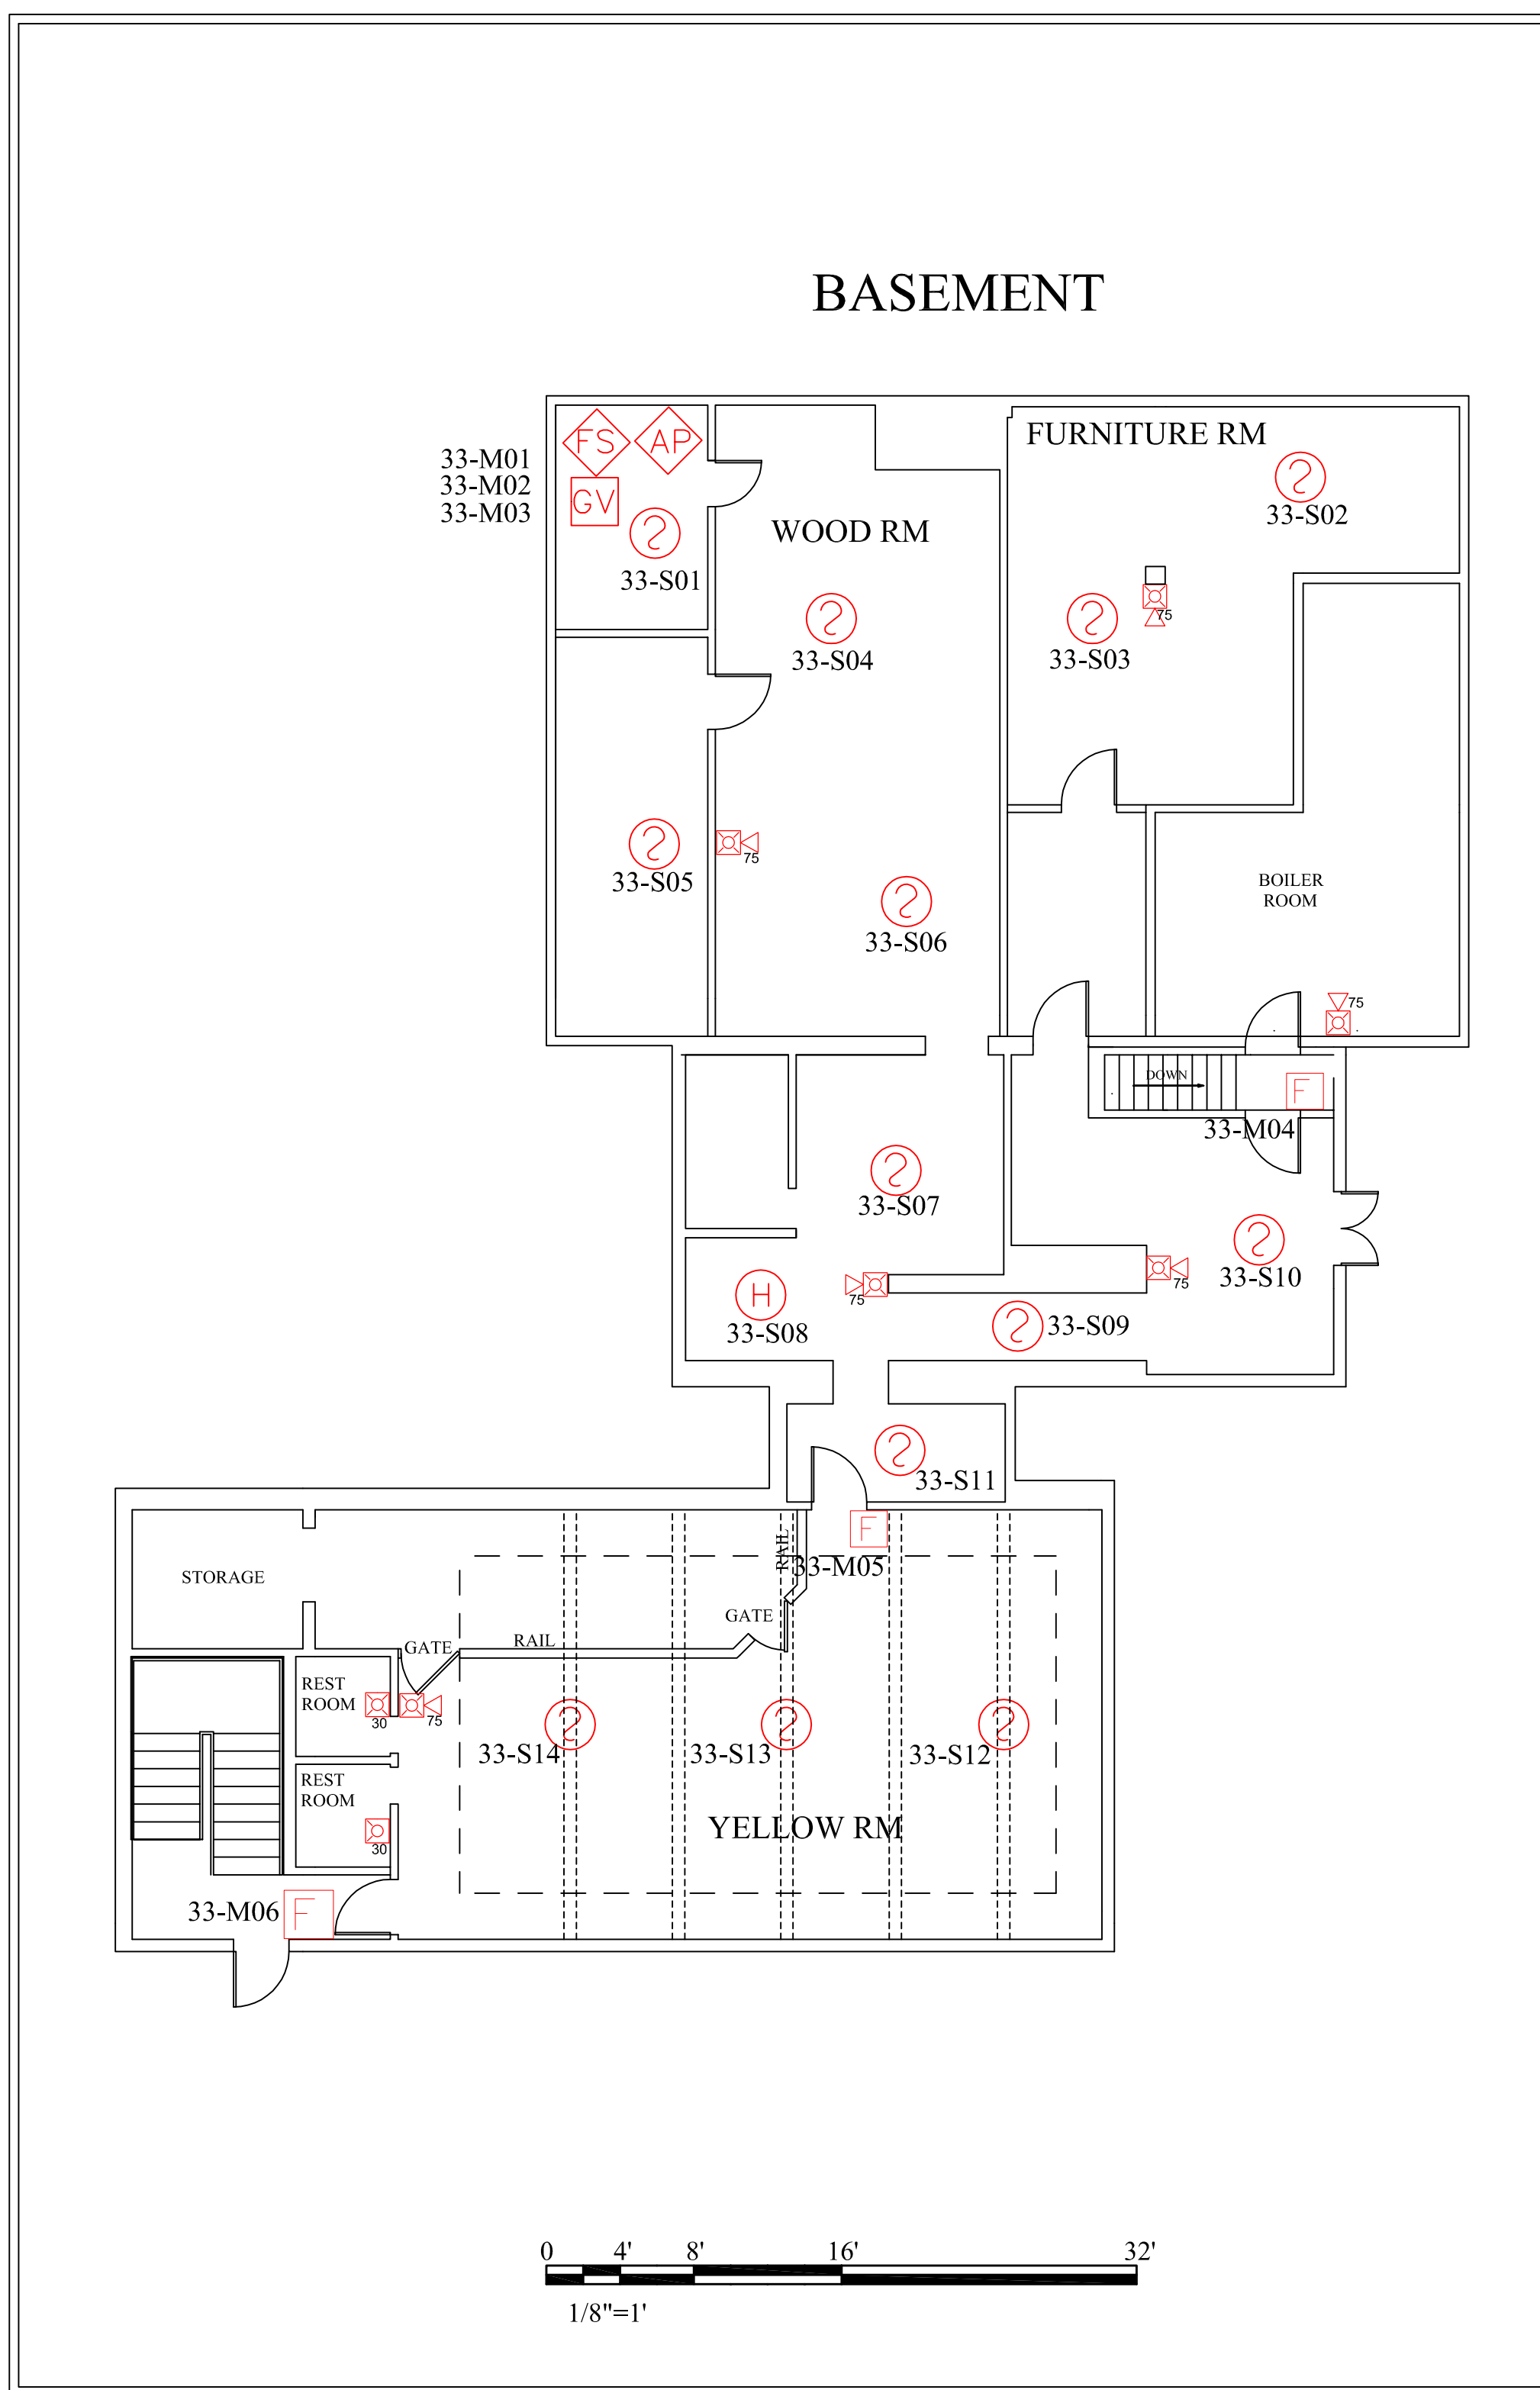


- LEGEND**
- SK-MONITOR MODULE (POINT NUMBER)
  - SK-PHOTO-T SMOKE DETECTOR (POINT NUMBER)
  - SK-PULL (POINT NUMBER)
  - SK-HEAT (POINT NUMBER)
  - FT Heat w/ SK Minimon (POINT NUMBER)
  - Ansul w/ SK Monitor (POINT NUMBER)
  - GATE VALVE TAMPER (POINT NUMBER)
  - WATER FLOW (POINT NUMBER)
  - AIR PRESSURE (POINT NUMBER)
  - HORN/STROBE (CANDELA RATING)
  - STROBE (CANDELA RATING)

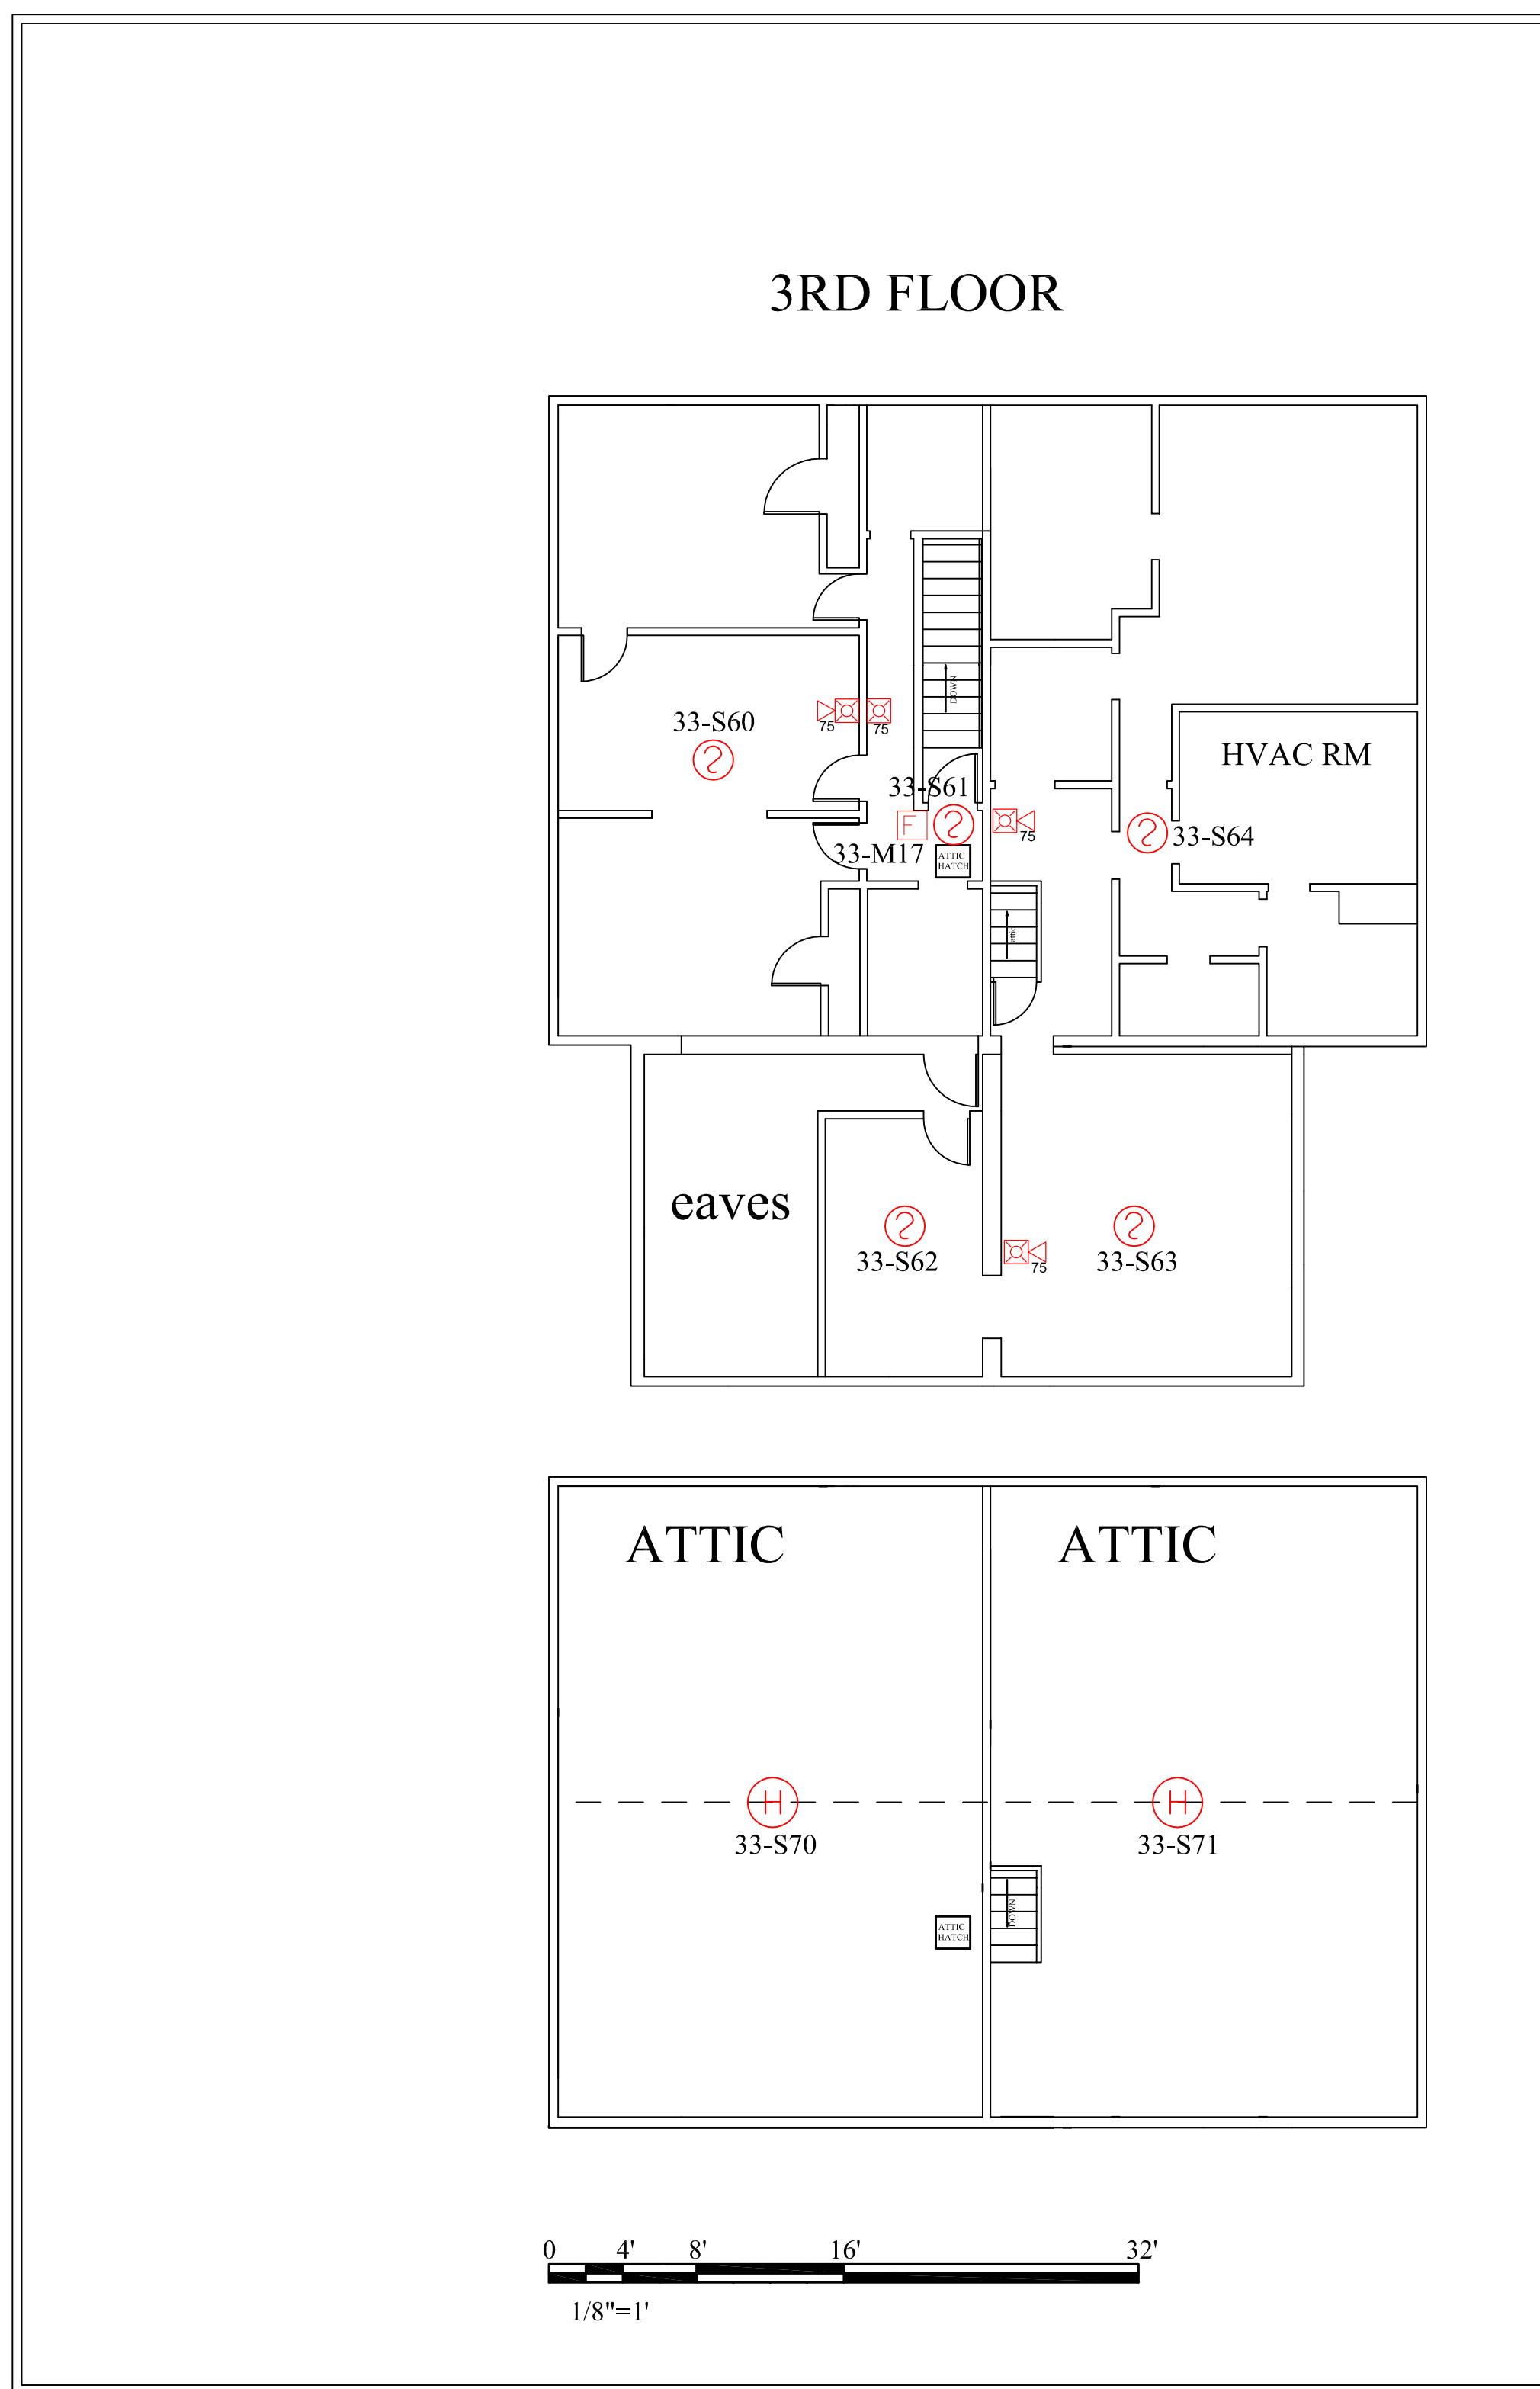

Note; All Alarm Initiating Devices to Sound All Notification Appliances Waterflow Radio Zone 1 Pulls and Detectors Radio Zone 2

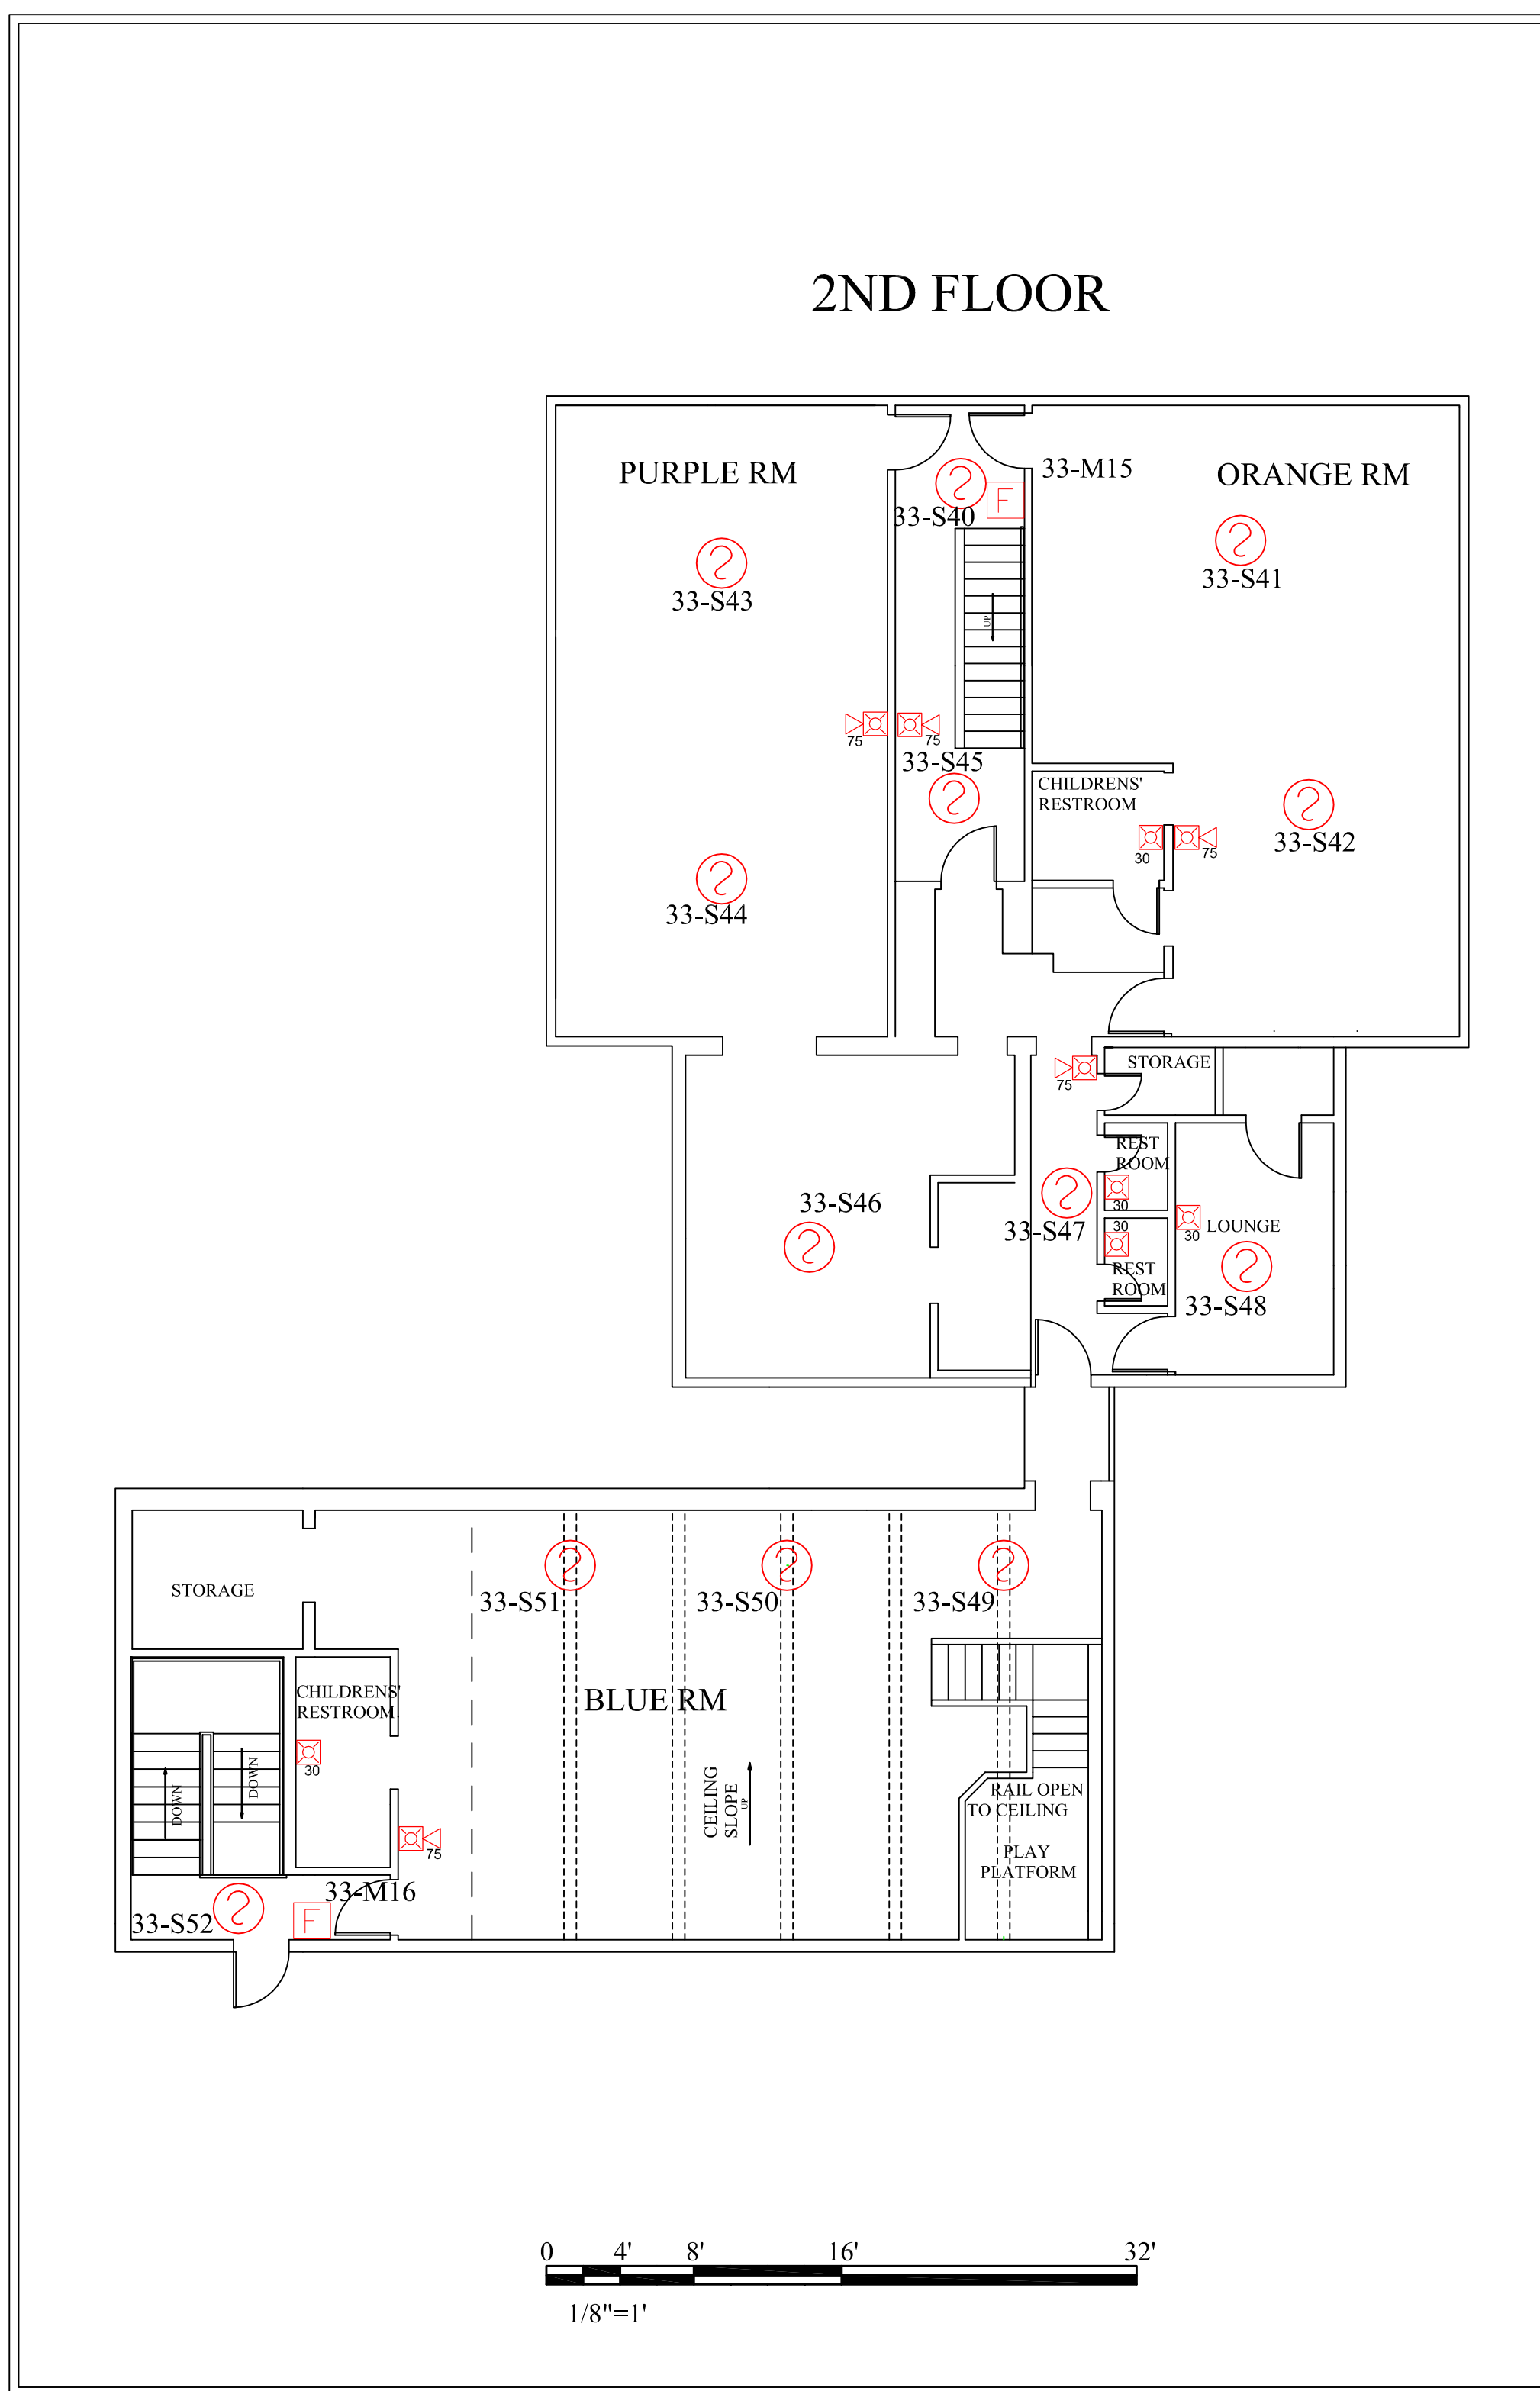


Note; No prints were available, drawing based on measurements taken on site and are reasonably close +/- Approx. 4 inches in floor spaces.

FA-1  
 SHEET NUMBER  
 FIRE ALARM SYSTEM PLAN  
 SHEET TITLE

**PROJECT TITLE**  
 CATHERINE MORRILL DAYCARE  
 DANFORTH ST  
 PORTLAND MAINE

NO	REVISIONS	DATE	BY
0	As-Built	09-13-16	SECURADYNE

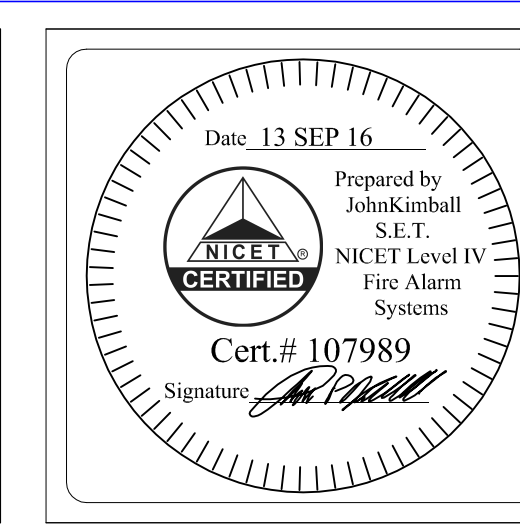

**securadyme systems**

600 Research Drive  
 NE Reg Portland, ME Office  
 1000 State Street  
 Westport, ME 04092  
 Tel: 207-898-3119  
 Fax: 207-898-3004  
 In State: 207-898-4444  
 In State: 207-898-0022

John Kinball NICET Certified Senior Engineering Technician  
 Certification # 107989