
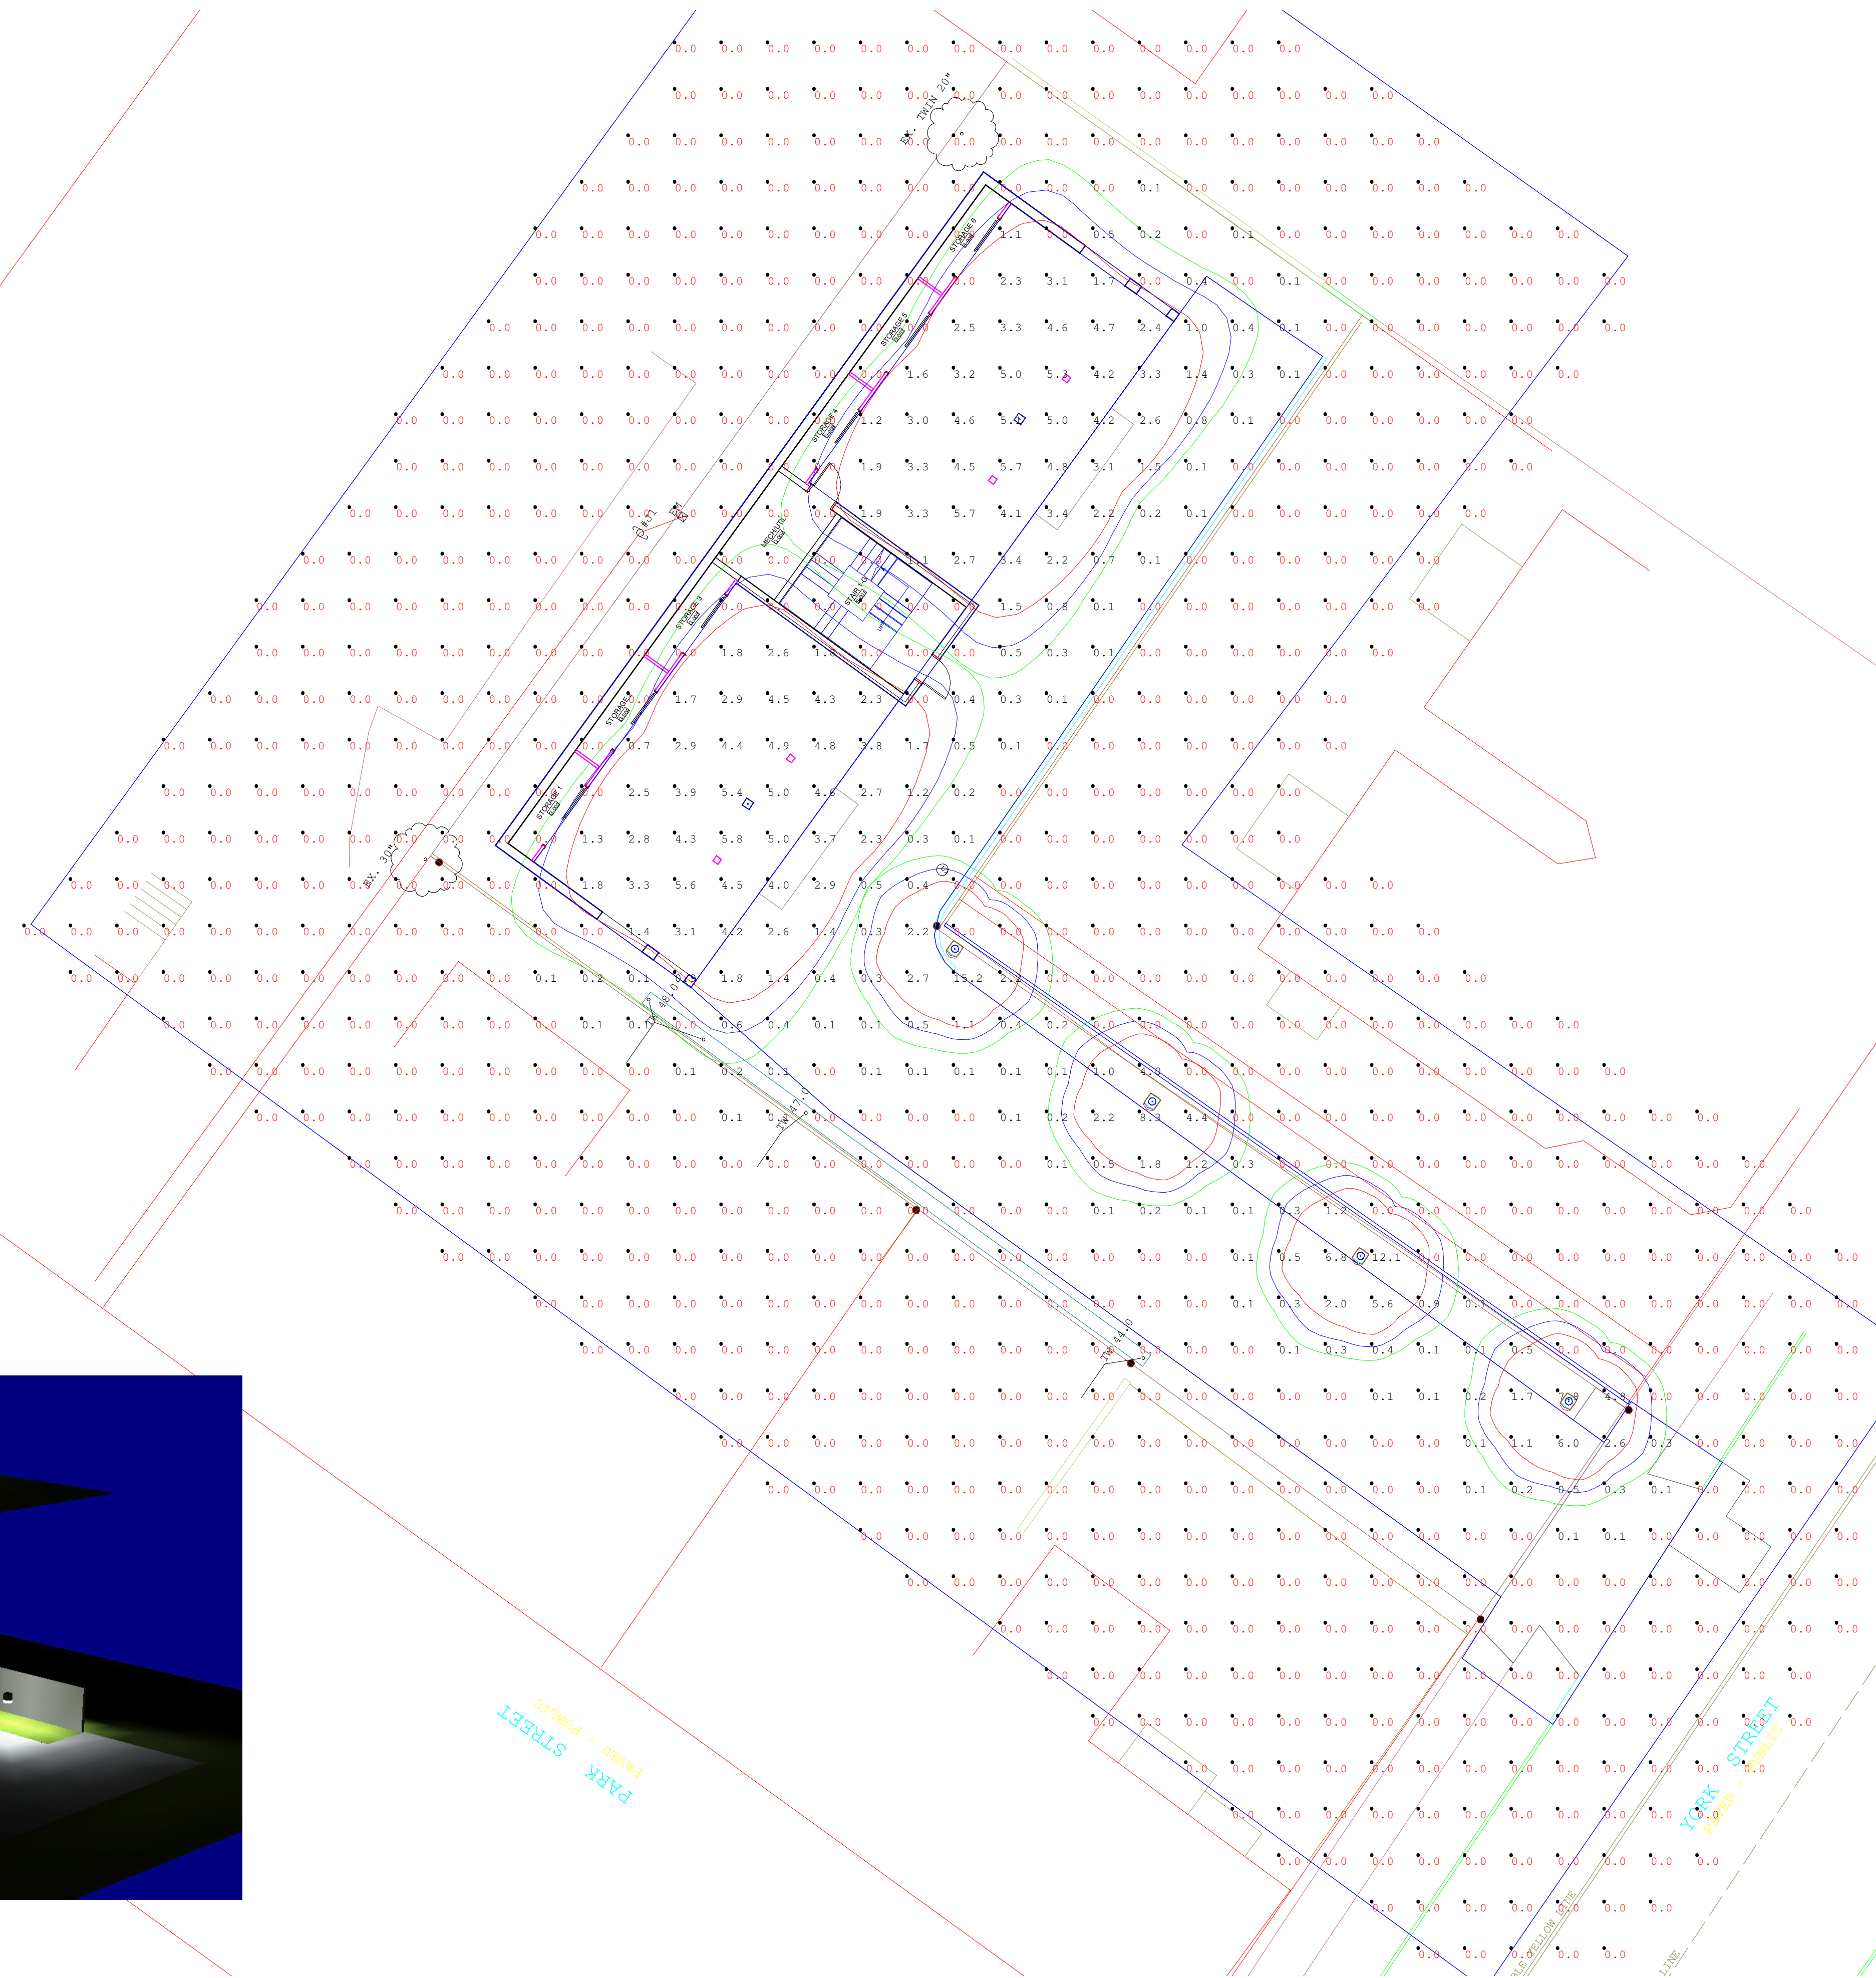


Beacon Products Endura Series LED

Luminaire Schedule			
Symbol	Qty	LLF	Description
⊙	4	0.900	GEM1-27LED-5100K
⊠	2	0.900	SCP-18LU-5K-5R-XX

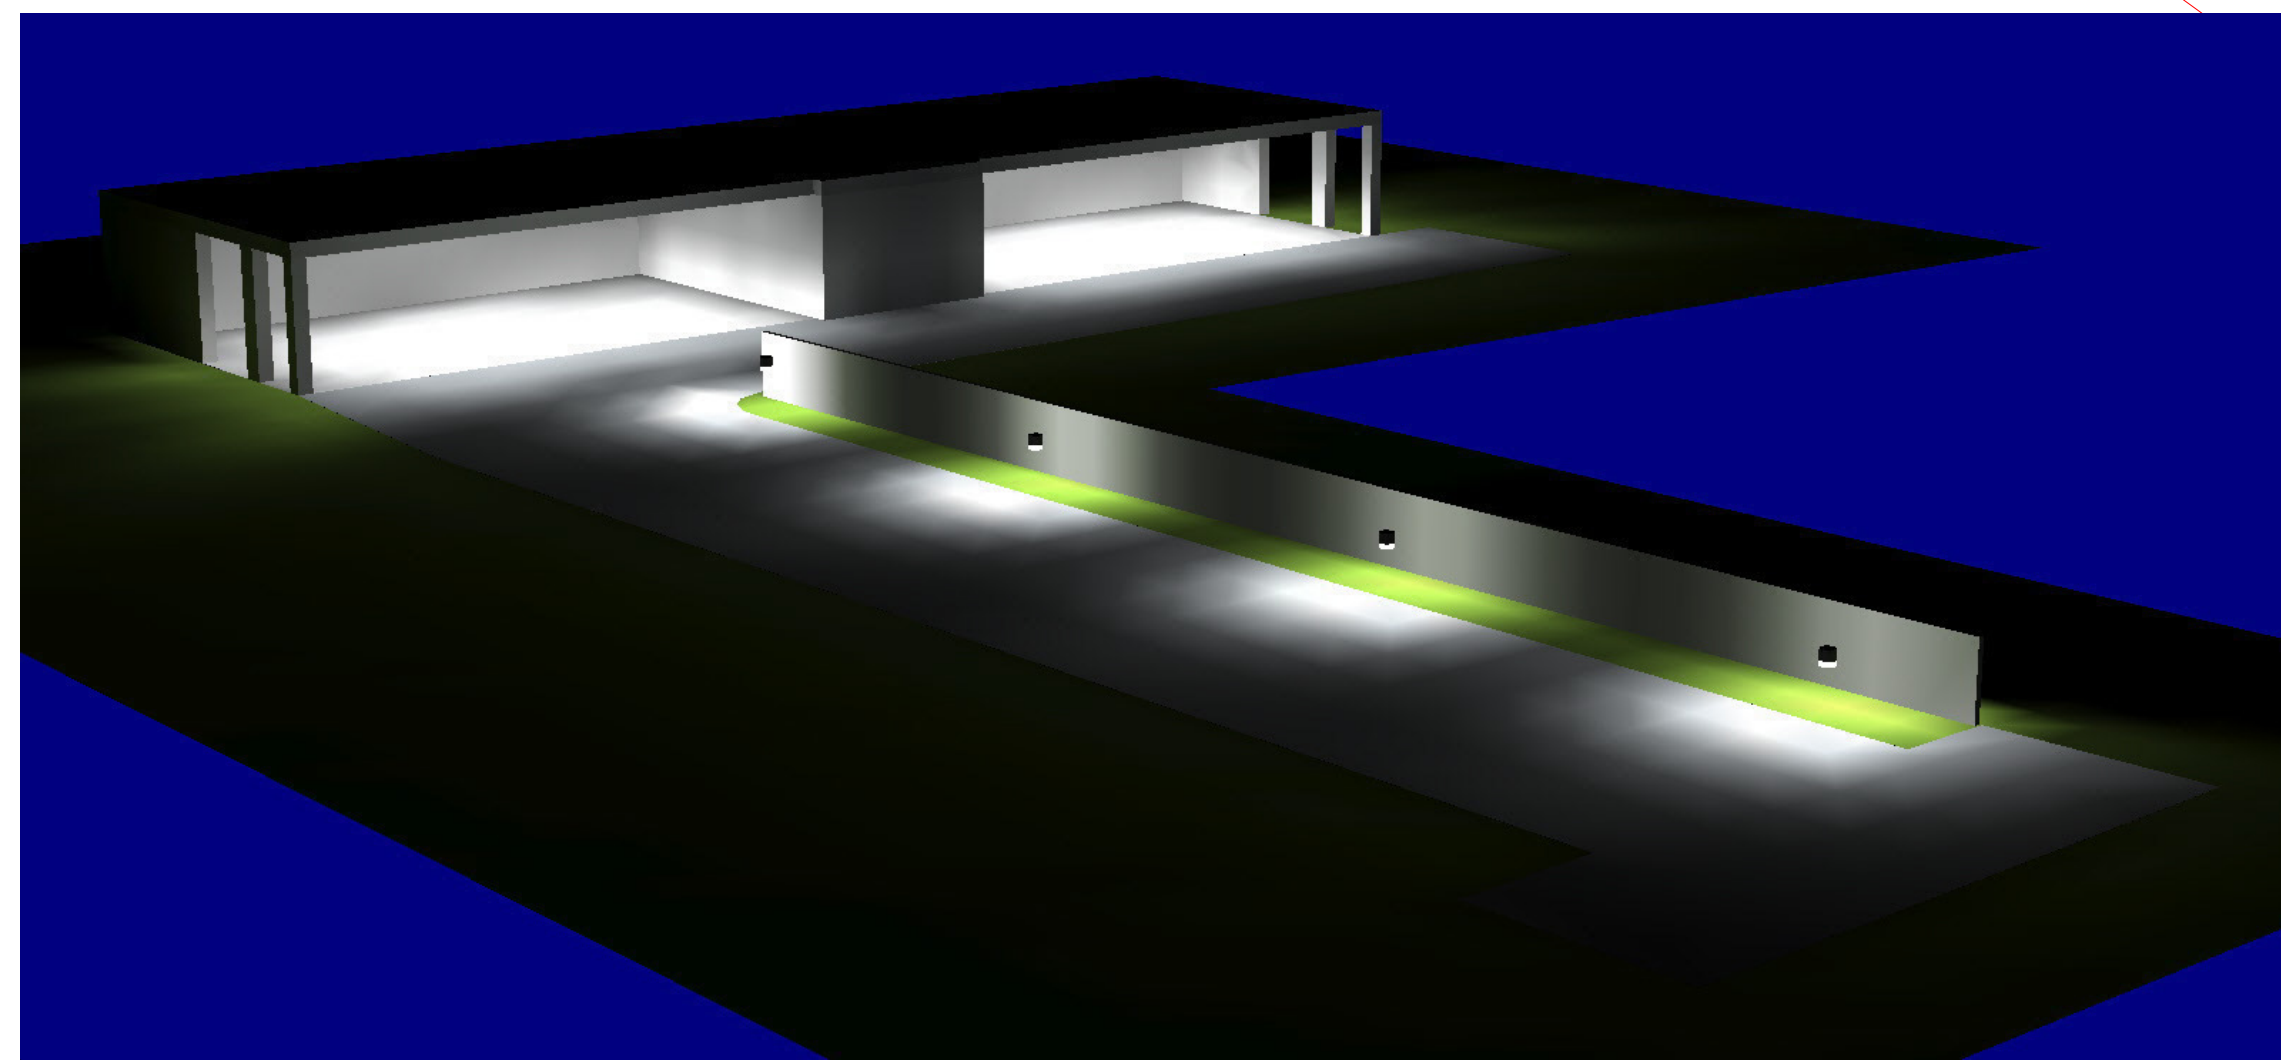

15 Pleasant Hill Rd
P.O. Box 1597
Scarborough, Maine 04070
email: swaneylighting.com
ph: 207-883-7100
fax: 207-885-9605

#	Date	Comments

Drawn By: Dave Charron
Date: 11/20/13

Revisions

York Street Townhouse

Not to Scale