
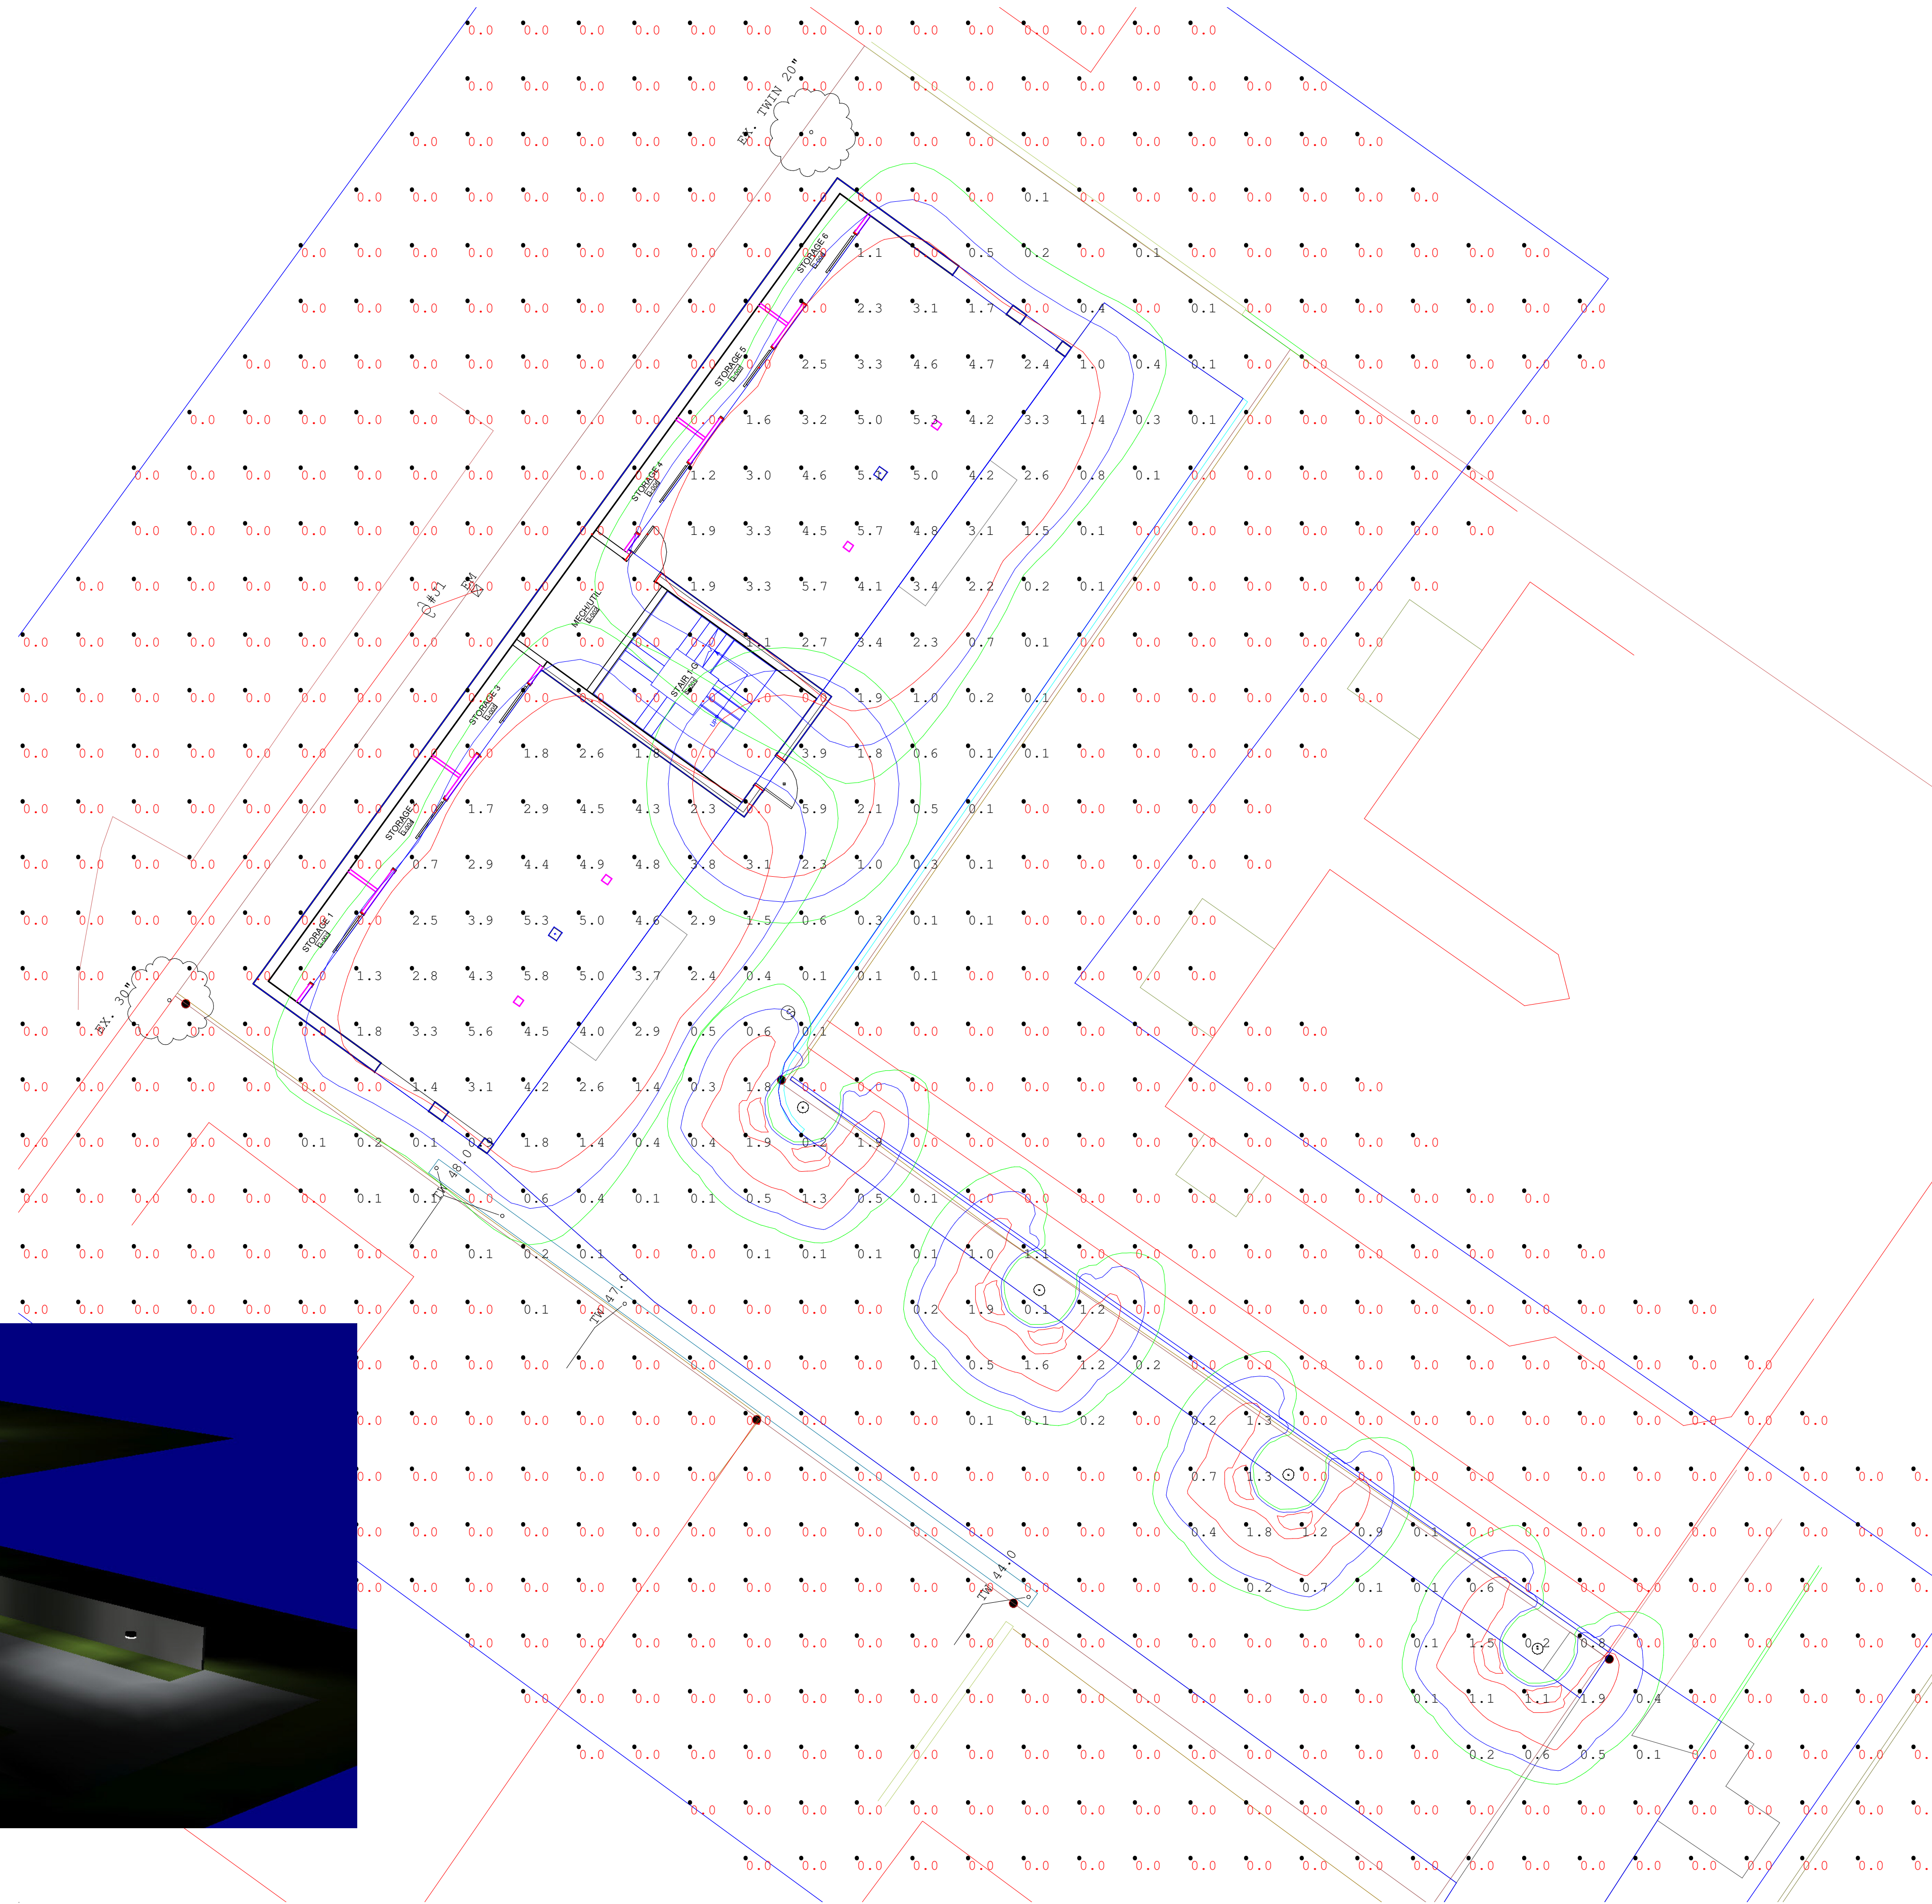


Hubbell Sedona LED Garage Kim VRB Bollard Prescolite Recessed Downlight

Luminaire Schedule			
Symbol	Qty	LLF	Description
⊕	4	0.900	VRB1-15LED-5100K
⊕	2	0.900	SCP-18LU-5K-5R-XX
⊕	1	0.900	LB6LED

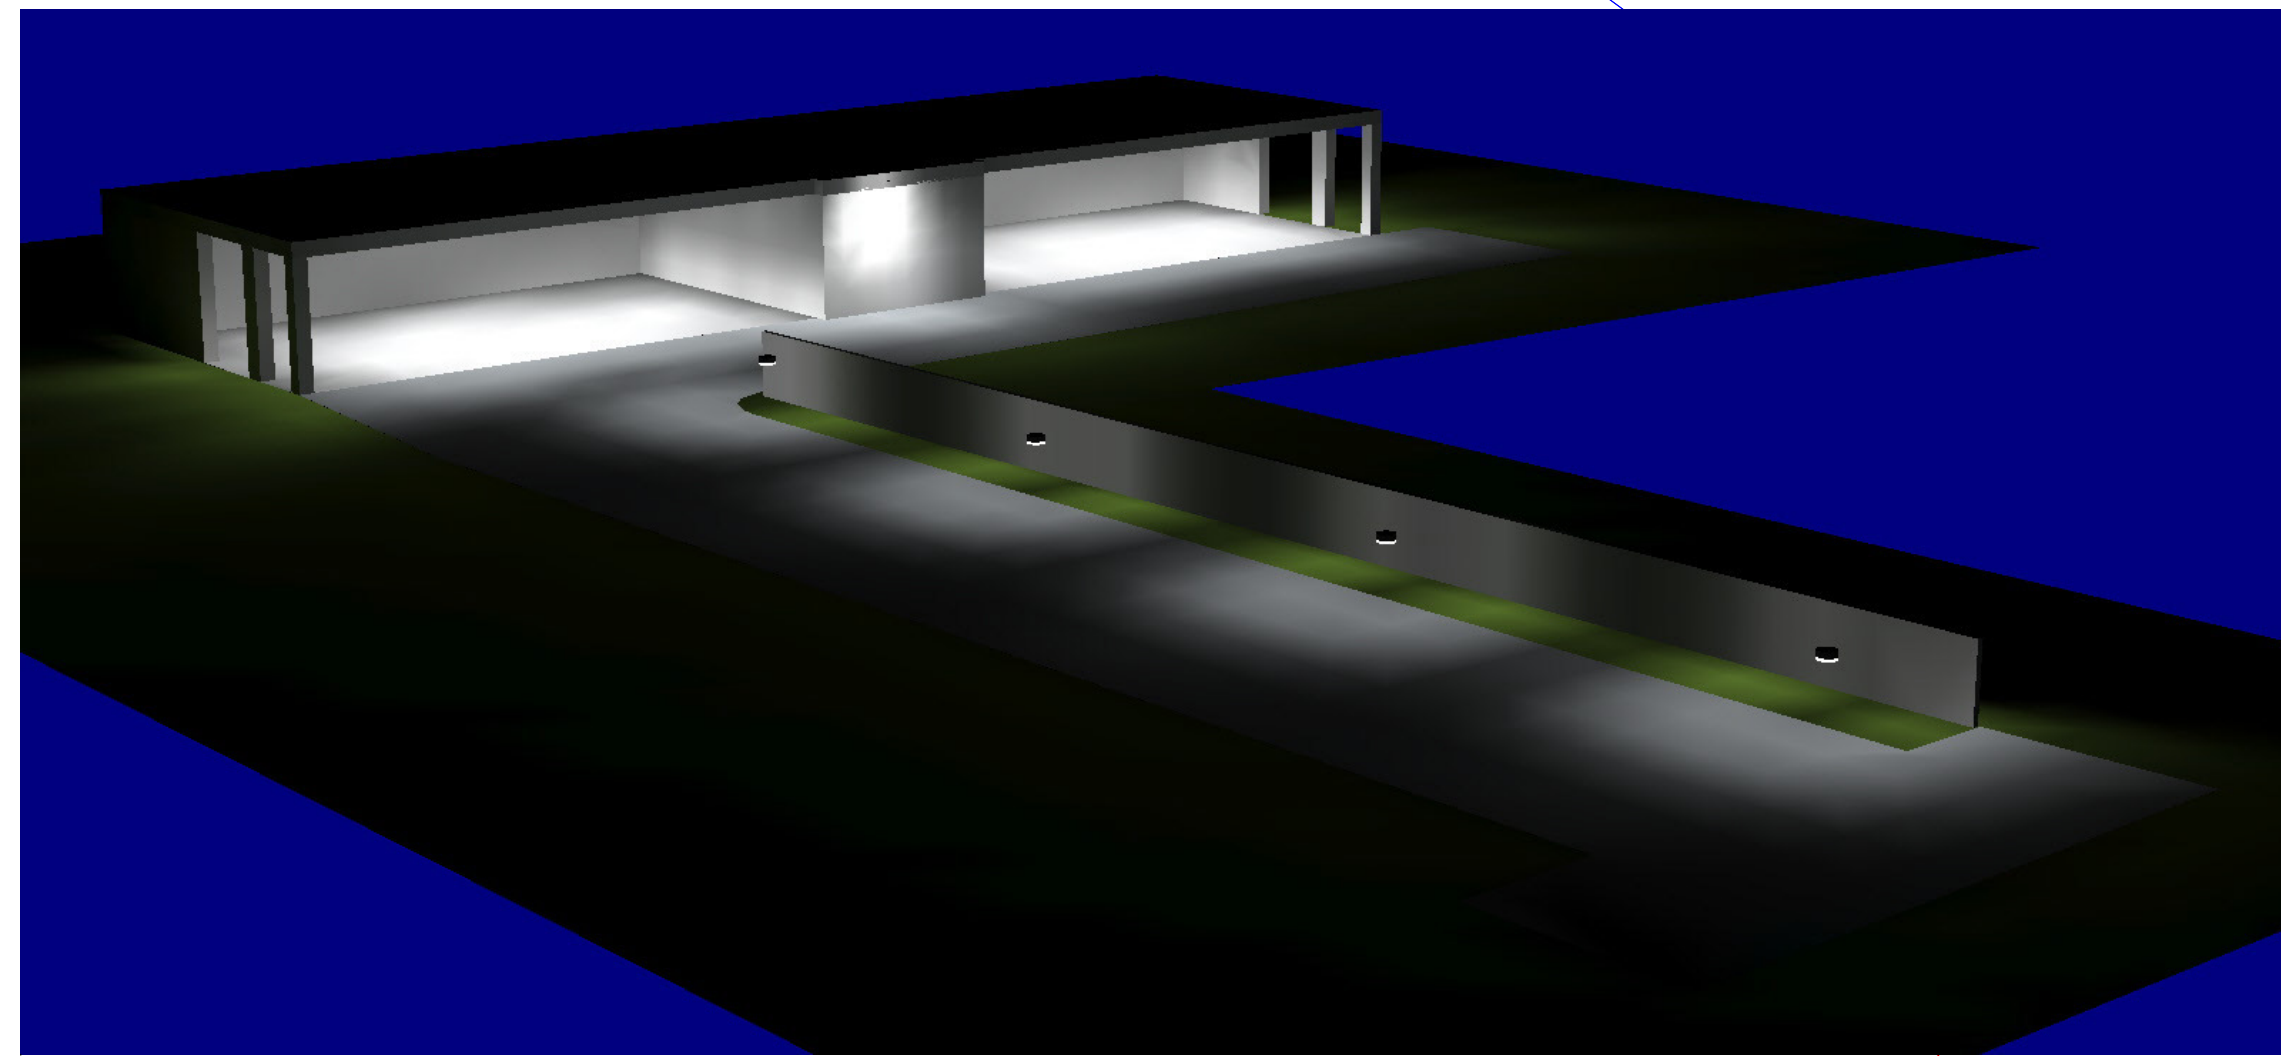

15 Pleasant Hill Rd
P.O. Box 1597
Scarborough, Maine 04070
email: swaneylighting.com
ph: 207-883-7100
fax: 207-885-9605

#	Date	Comments

Revisions

Drawn By: Dave Charron
Date: 1/29/14

Not to Scale

York Street Townhouse