


**1** FIRST FLOOR MECHANICAL PLAN  
 SCALE: 1/4" = 1'-0"

- NOTES  
 1. COORDINATE ALL PIPING AND RISER LOCATIONS WITH ARCHITECT PRIOR TO ROUGH-IN.  
 2. LOWER LEVEL MECHANICAL IS FUTURE FIT-UP SPACE.

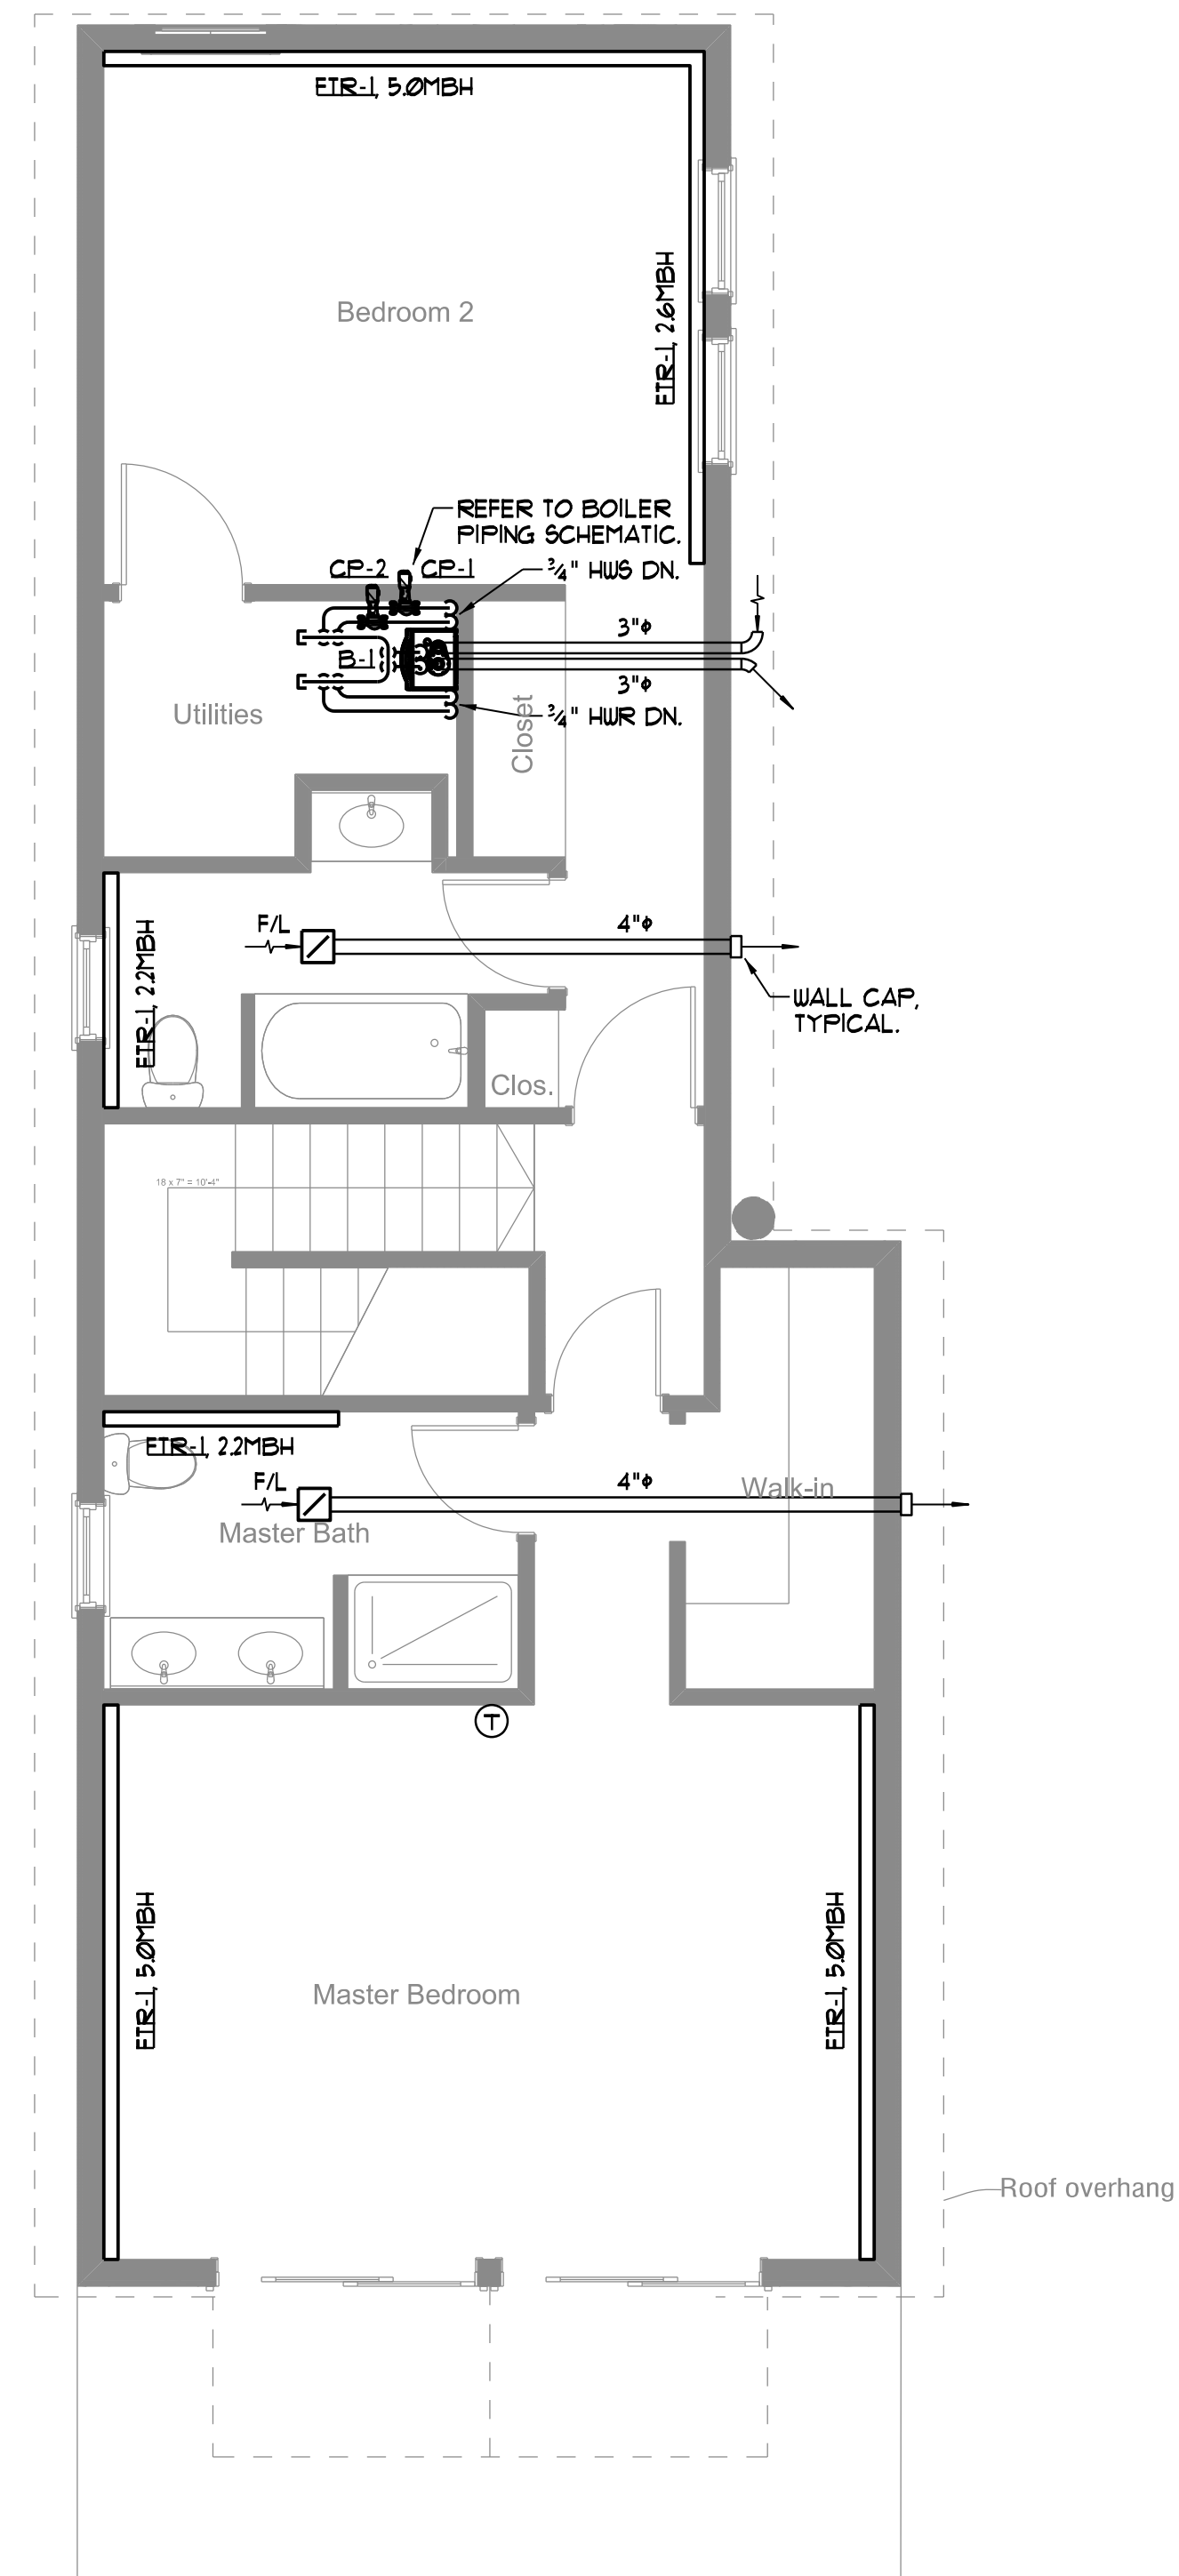

**2** SECOND FLOOR MECHANICAL PLAN  
 SCALE: 1/4" = 1'-0"

- NOTES  
 1. COORDINATE ALL PIPING AND RISER LOCATIONS WITH ARCHITECT PRIOR TO ROUGH-IN.


227 York Street  
 Residence - Portland, Maine

Architect:  
 Reiter Architecture & Design  
 PO Box 275 -- Brooklin, ME 04616  
 Tel. 207.359.2300

Structural & Civil Engineer:  
 Casco Bay Engineering  
 424 Fore Street -- Portland, ME 04101  
 Tel. 207.842.2800

Mechanical & Electrical Engineer:  
 Bennett Engineering  
 PO Box 297 -- Freeport, ME 04032  
 Tel. 207.865.9475

Drwg Date / Issued by / Drwg Issue
5/10/13 BEI For Bldg Dept Review & Bidding Only, Not For Construction

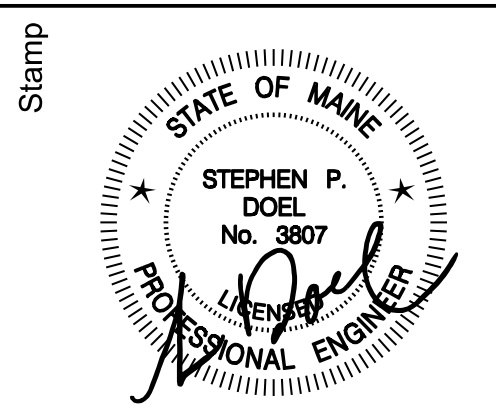

Drawing Title  
 RESIDENCE MECH. PLANS

Drawing Number

M1