


FLOOR AND CEILING PLAN

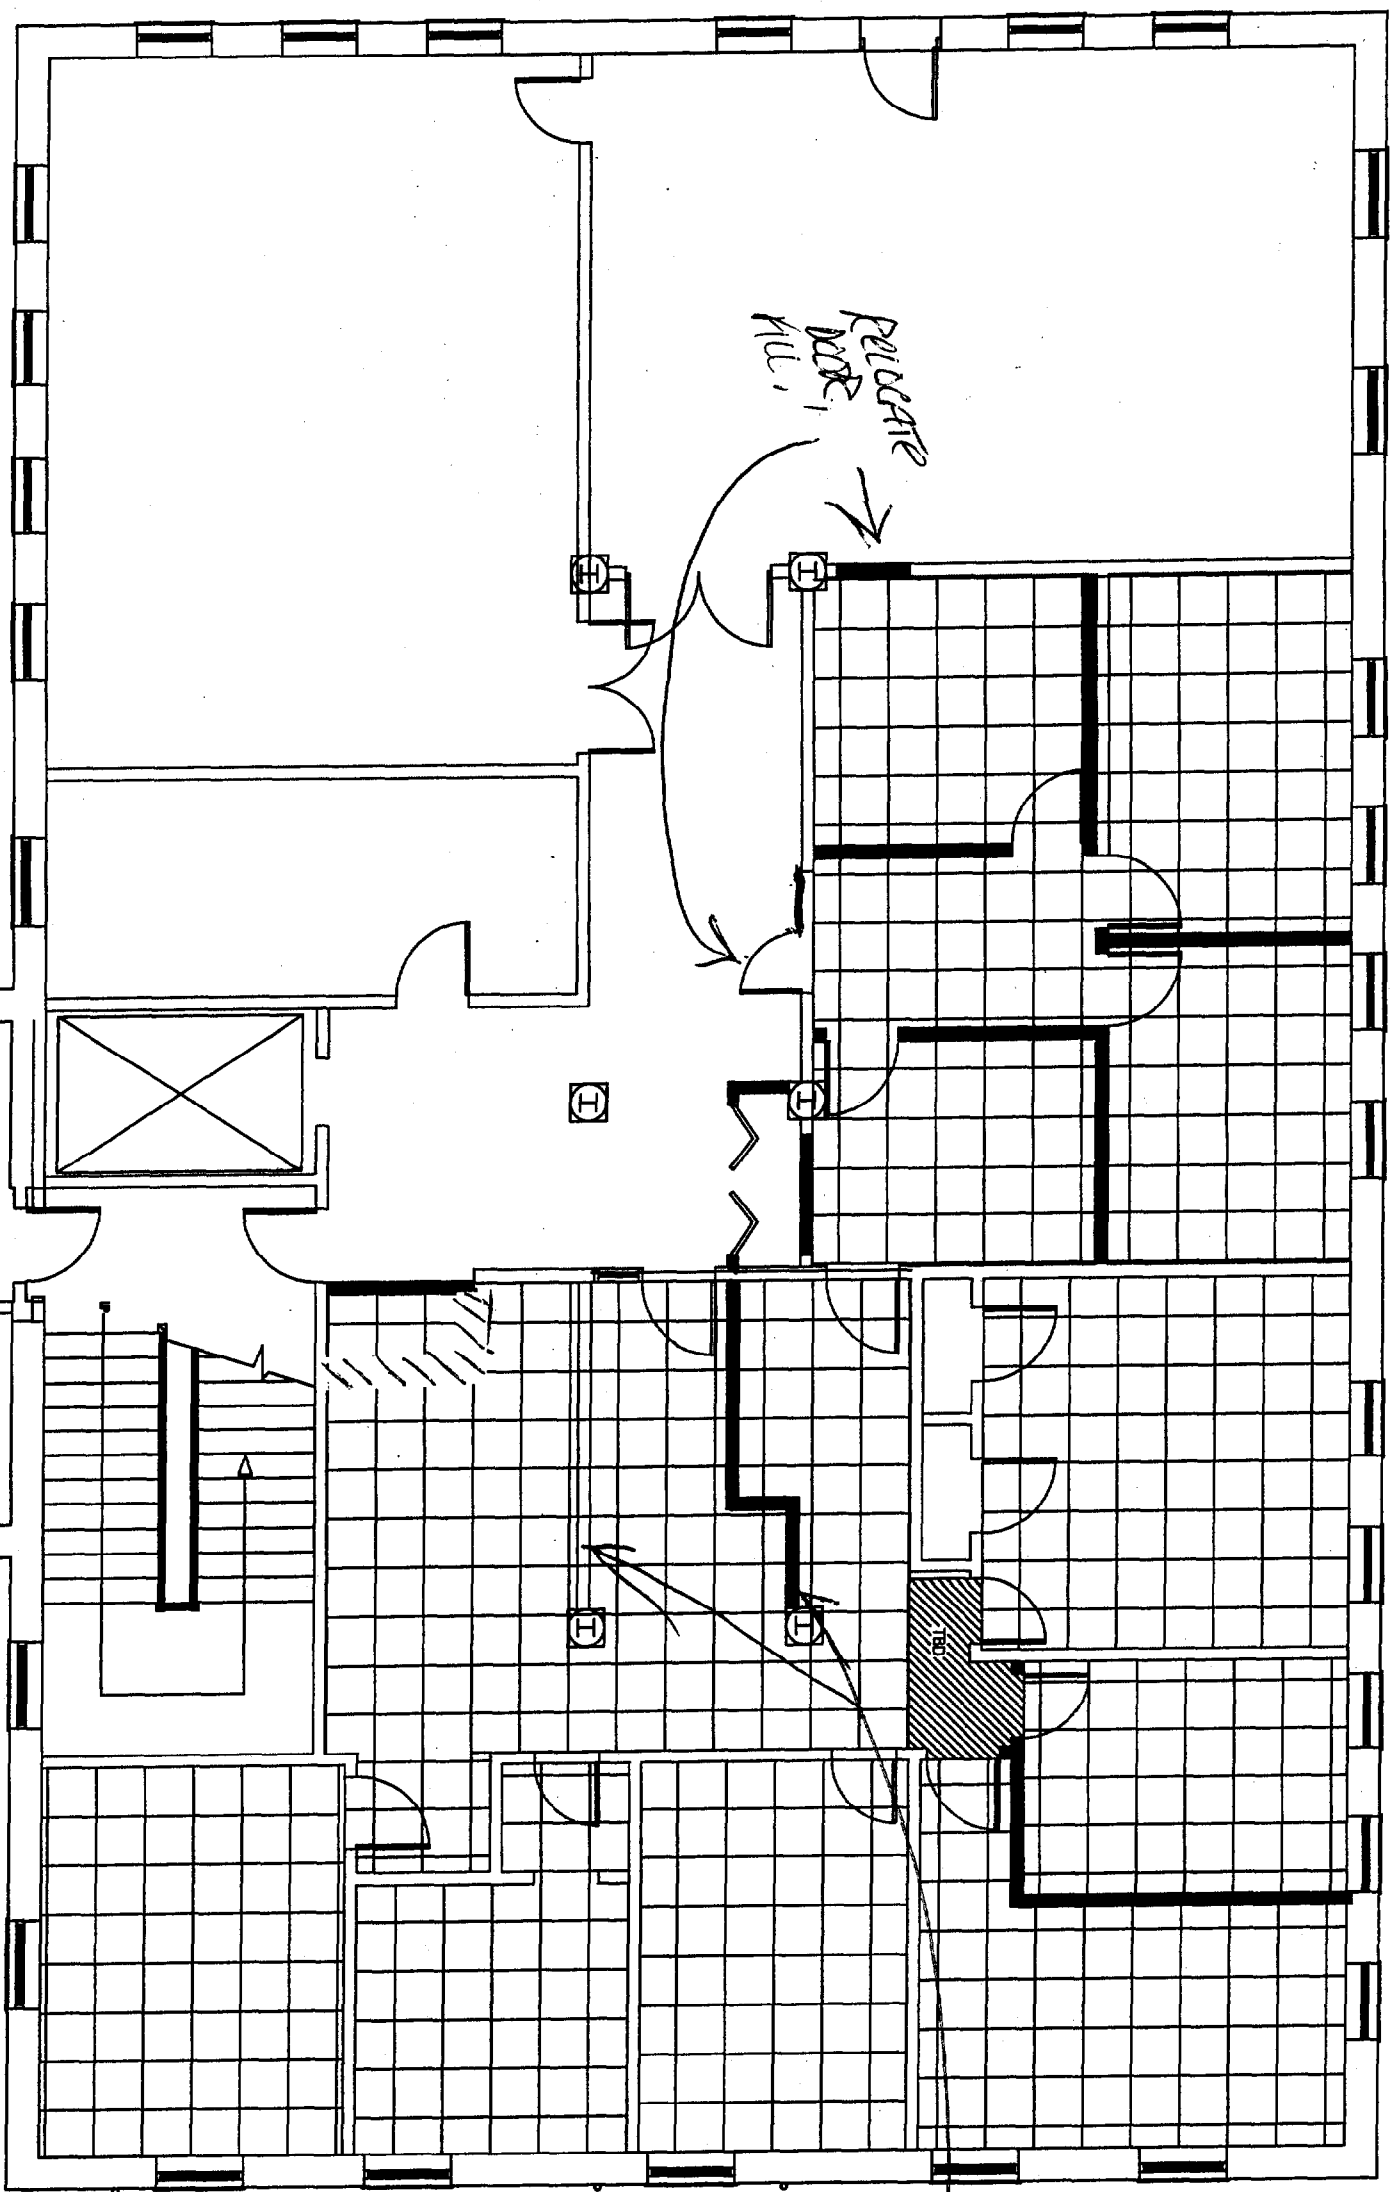

UNIVERSITY OF
Southern Maine

Portland Campus

Proposed Ceiling Second Floor 68 High St


Title:

Scale:
1/8" = 1'

09-20-02

Do not scale off drawing

2 of 2

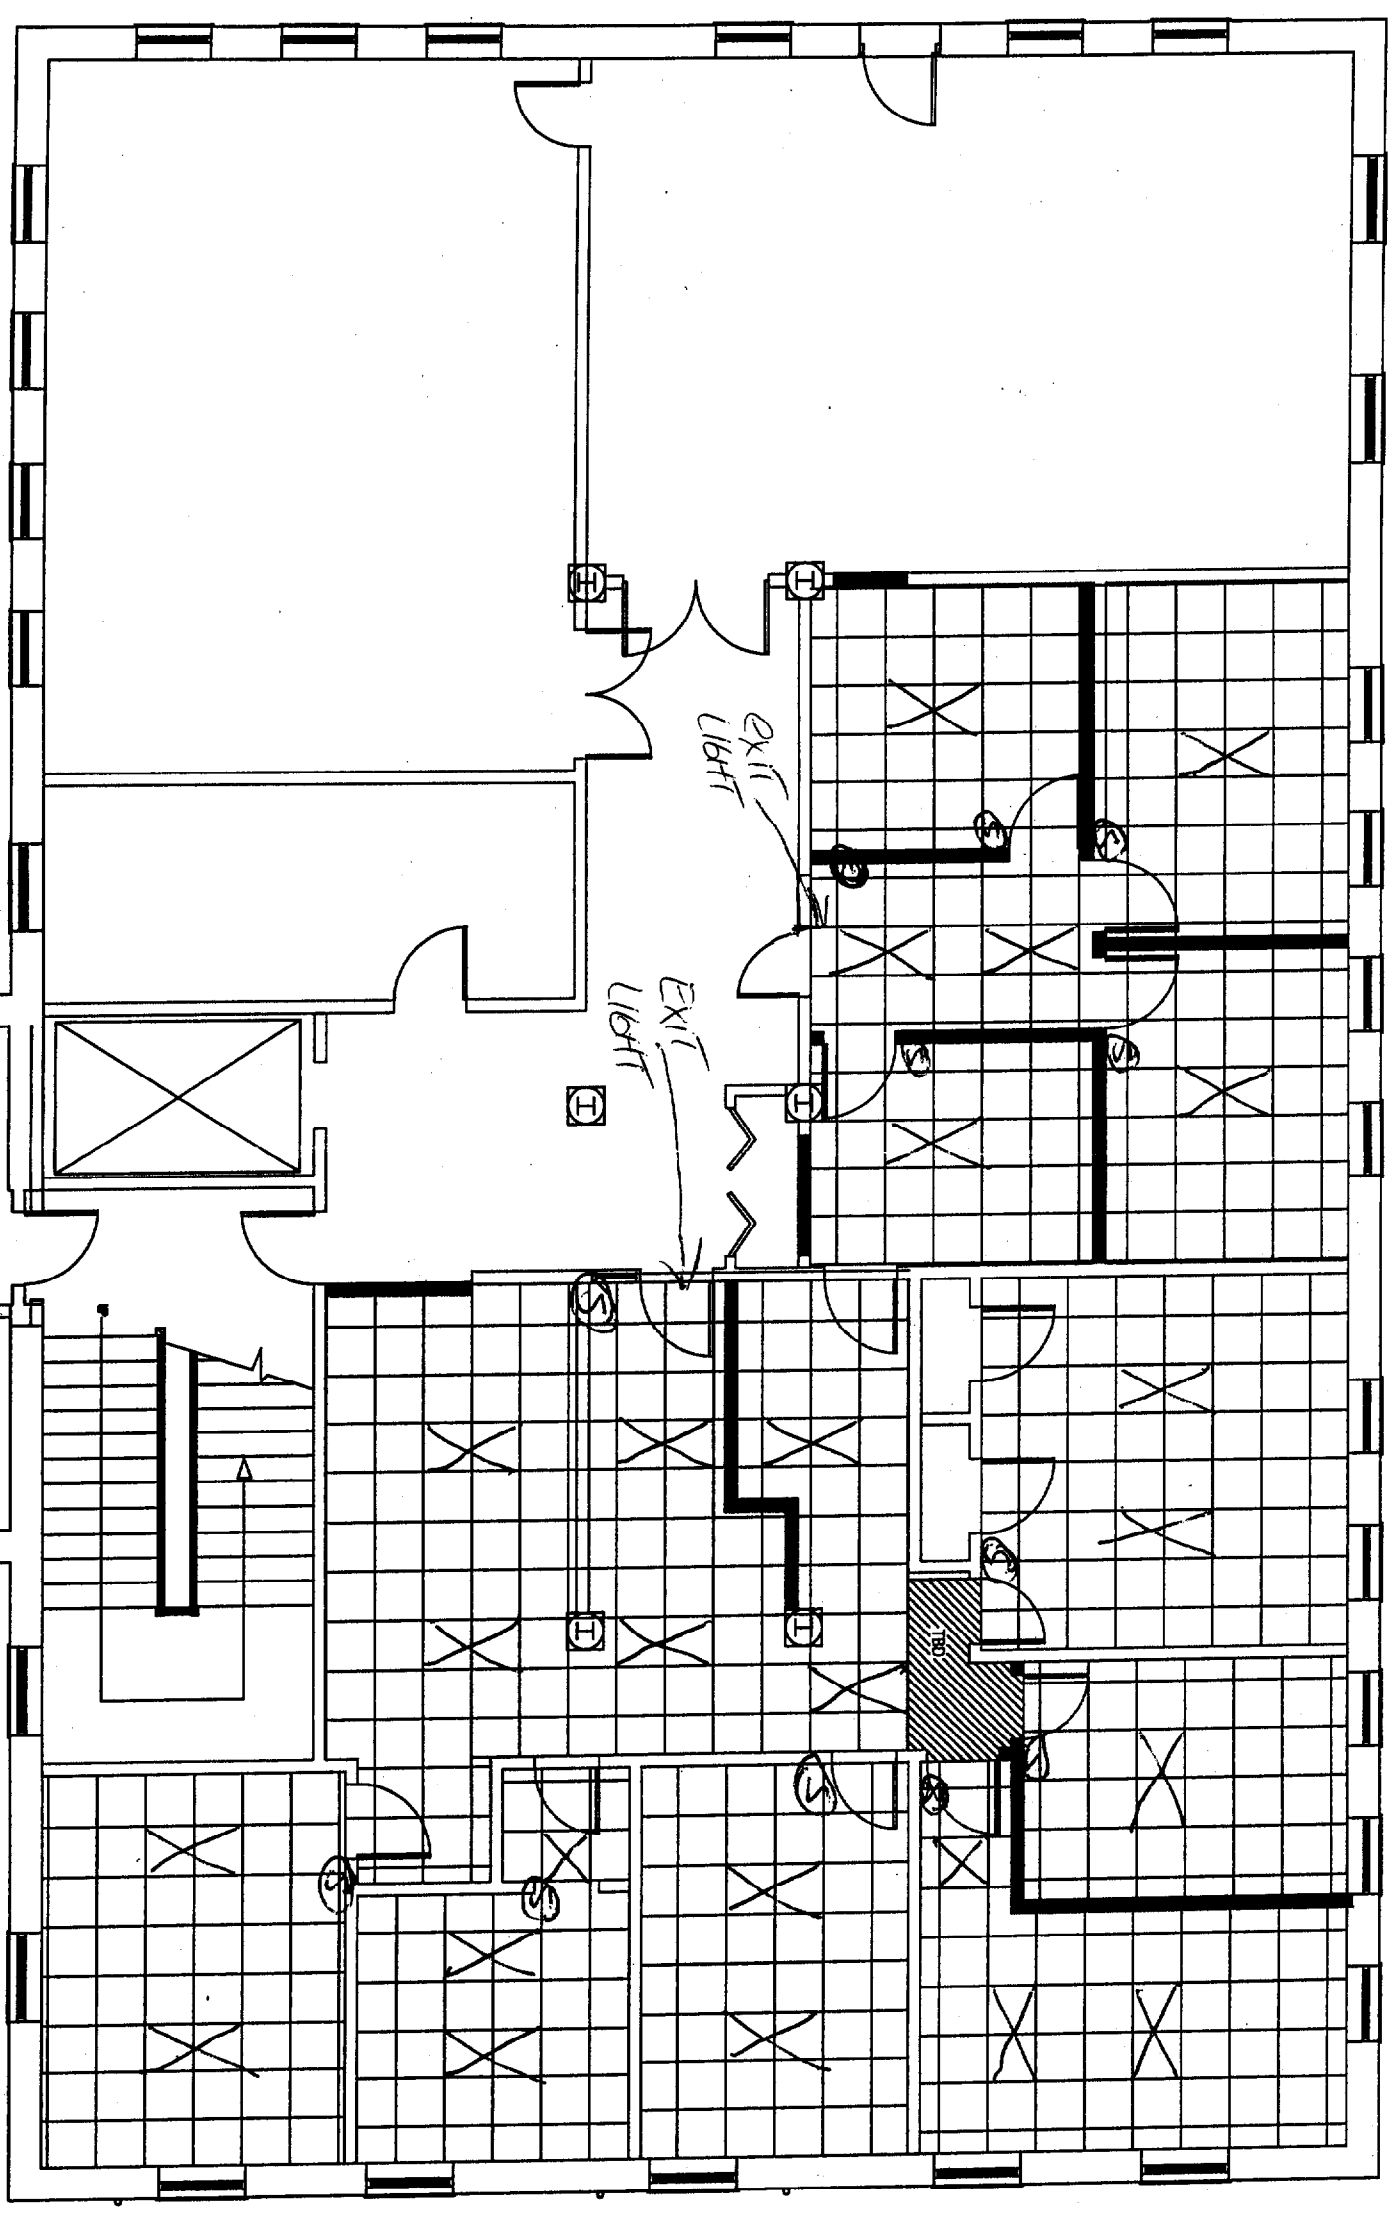

LIGHTING PLAN
S = SWITCH

2x4, 3 TUBE, ELECTRONIC
PARABOLIC, 23 TOTAL
2x2, 2 TUBE, ELECTRONIC
PARABOLIC - 2