


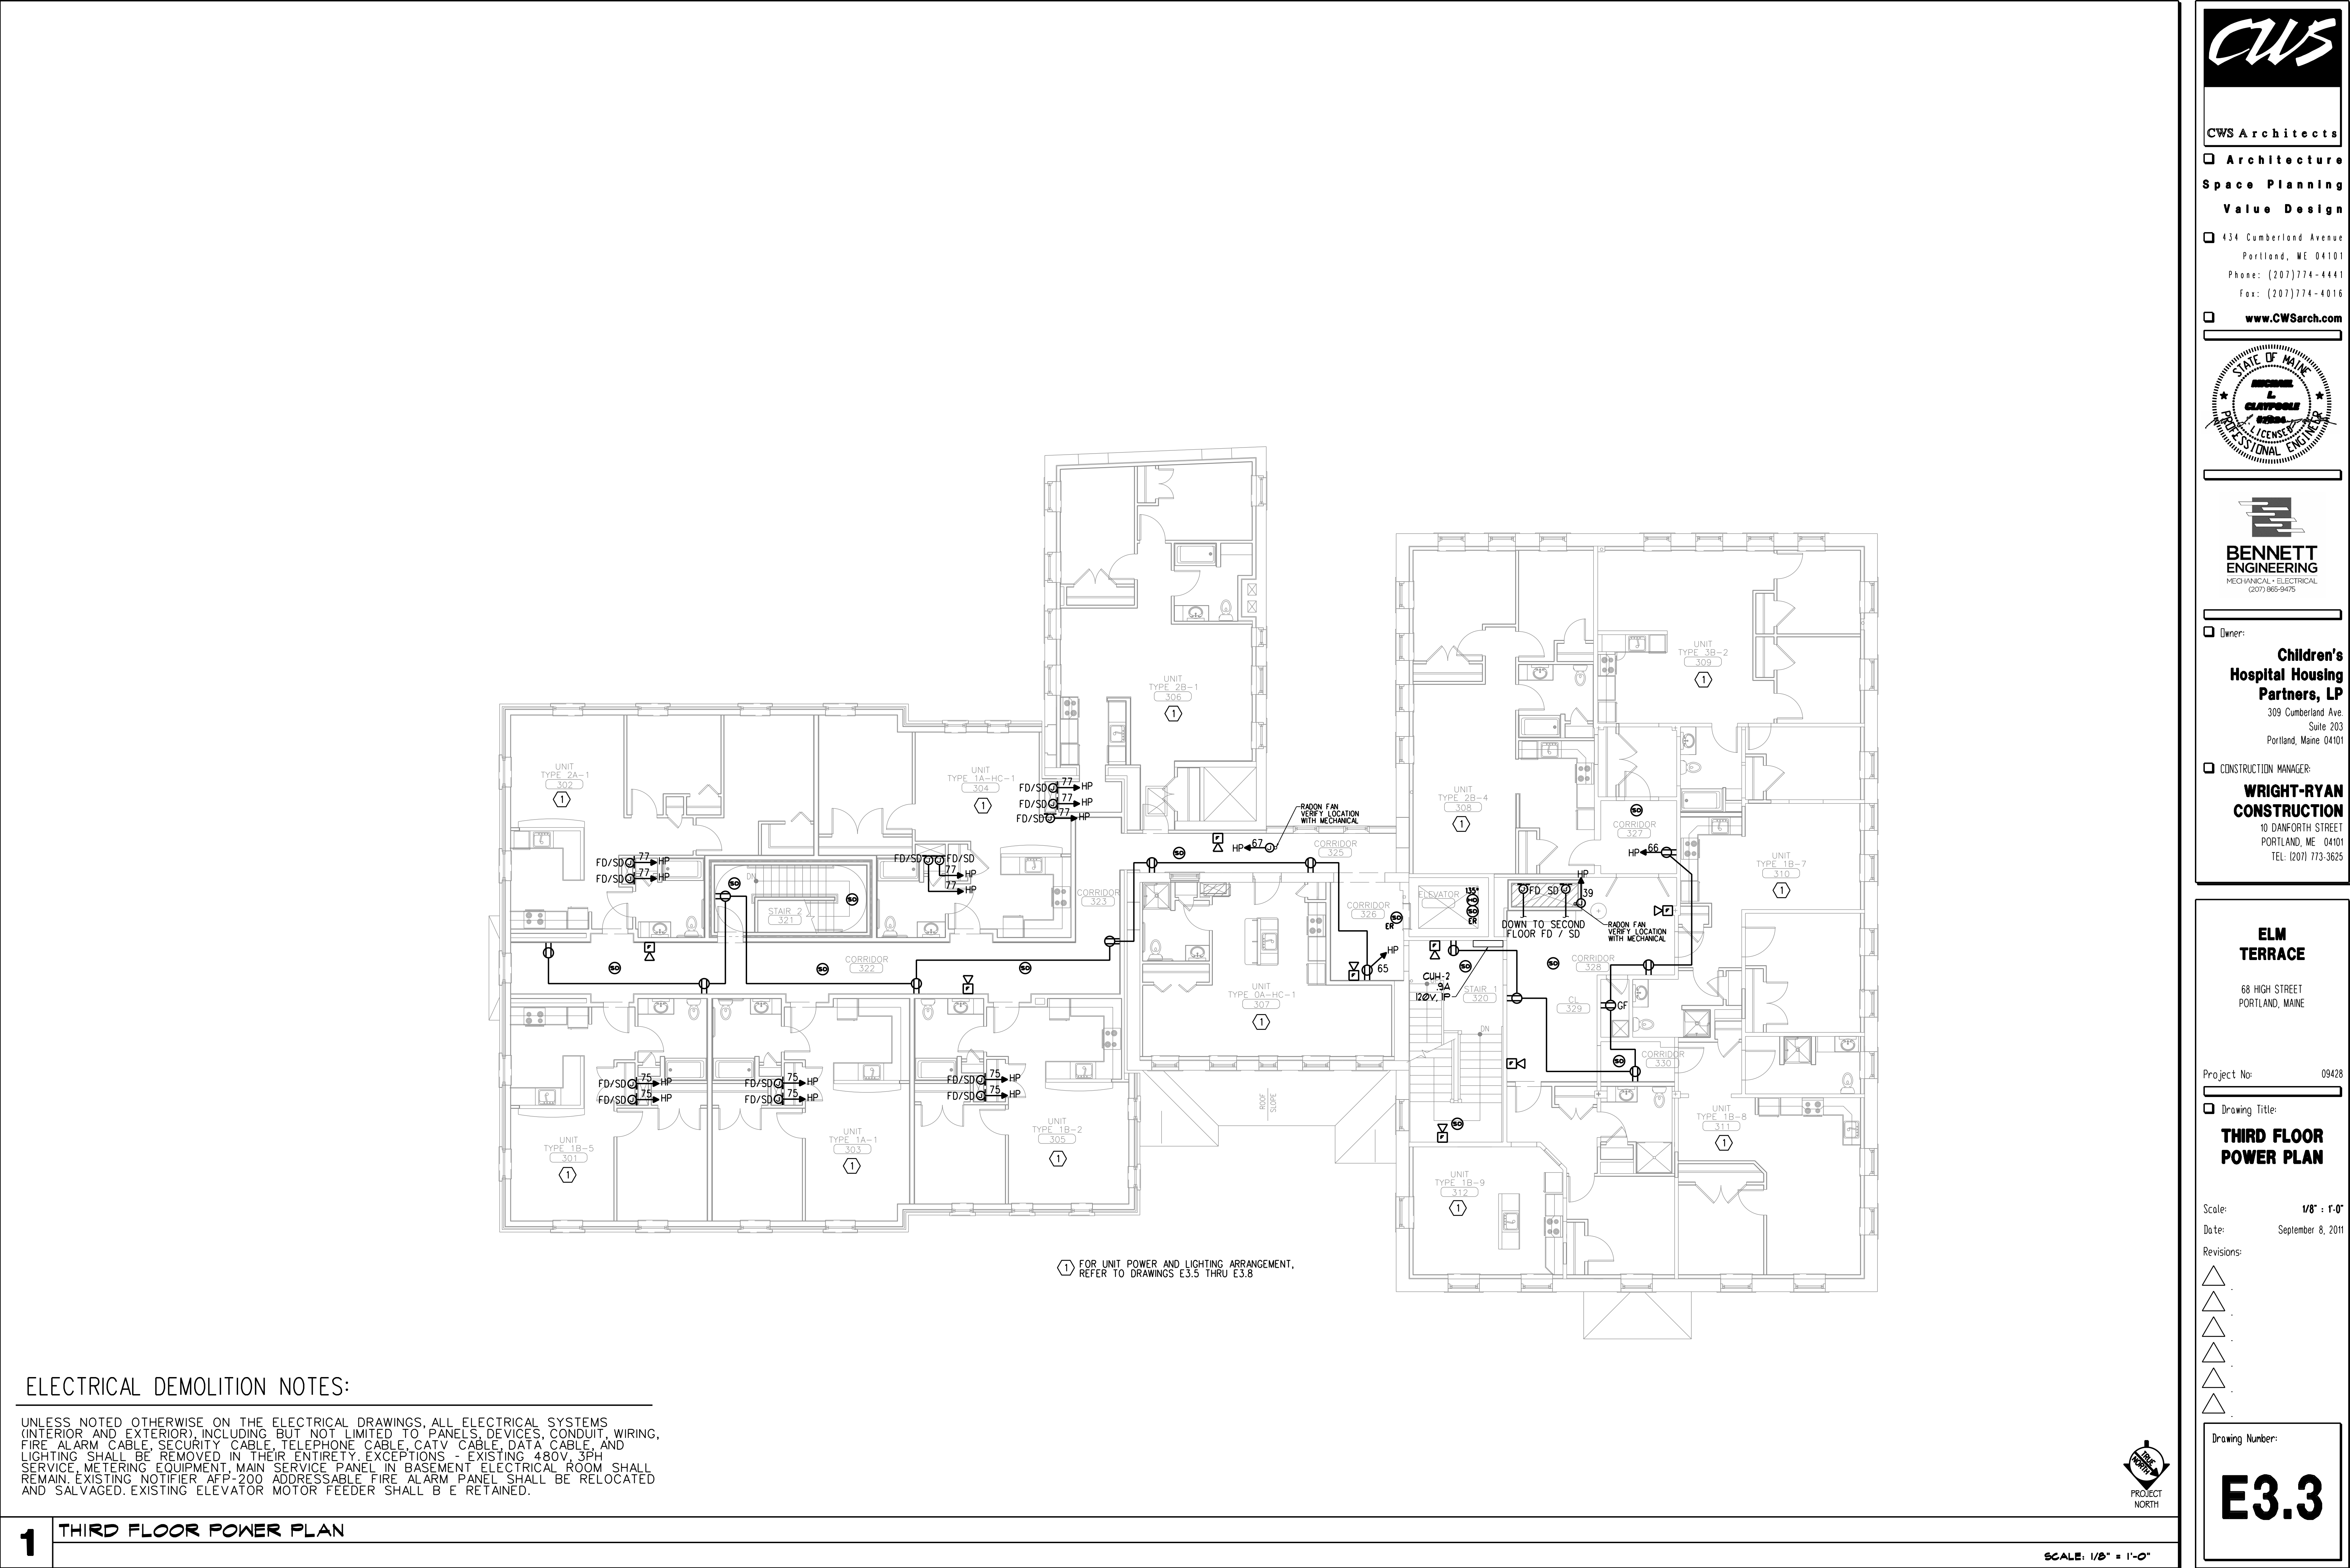

ELECTRICAL DEMOLITION NOTES:

UNLESS NOTED OTHERWISE ON THE ELECTRICAL DRAWINGS, ALL ELECTRICAL SYSTEMS (INTERIOR AND EXTERIOR), INCLUDING BUT NOT LIMITED TO: PANELS, DEVICES, CONDUIT, WIRING, FIRE ALARM CABLE, SECURITY CABLE, TELEPHONE CABLE, CATV CABLE, DATA CABLE, AND LIGHTING SHALL BE REMOVED IN THEIR ENTIRETY. EXCEPTIONS - EXISTING 480V, 3PH SERVICE, METERING EQUIPMENT, MAIN SERVICE PANEL IN BASEMENT ELECTRICAL ROOM SHALL REMAIN. EXISTING NOTIFIER AFP-200 ADDRESSABLE FIRE ALARM PANEL SHALL BE RELOCATED AND SALVAGED. EXISTING ELEVATOR MOTOR FEEDER SHALL B E RETAINED.


CWS

CWS Architects

Architecture  
Space Planning  
Value Design

434 Cumberland Avenue  
Portland, ME 04101  
Phone: (207)774-4441  
Fax: (207)774-4016

www.CWSarch.com

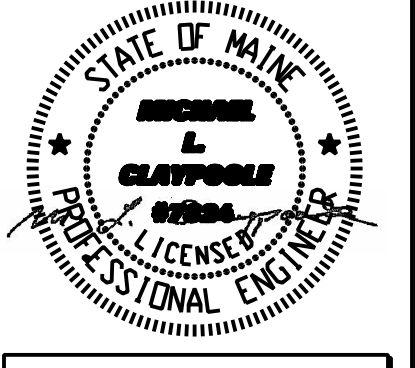

BENNETT  
ENGINEERING

MECHANICAL-ELECTRICAL  
(207) 865-9475

Owner:

Children's  
Hospital Housing  
Partners, LP  
309 Cumberland Ave.  
Suite 203  
Portland, Maine 04101

CONSTRUCTION MANAGER:

WRIGHT-RYAN  
CONSTRUCTION  
10 DANFORTH STREET  
PORTLAND, ME 04101  
TEL: (207) 773-3625

ELM  
TERRACE

68 HIGH STREET  
PORTLAND, MAINE

Project No: 09428

Drawing Title:  
THIRD FLOOR  
POWER PLAN

Scale: 1/8" = 1'-0"  
Date: September 8, 2011

- Revisions:
- 1
  - 2
  - 3
  - 4
  - 5
  - 6

Drawing Number:  
E3.3

