




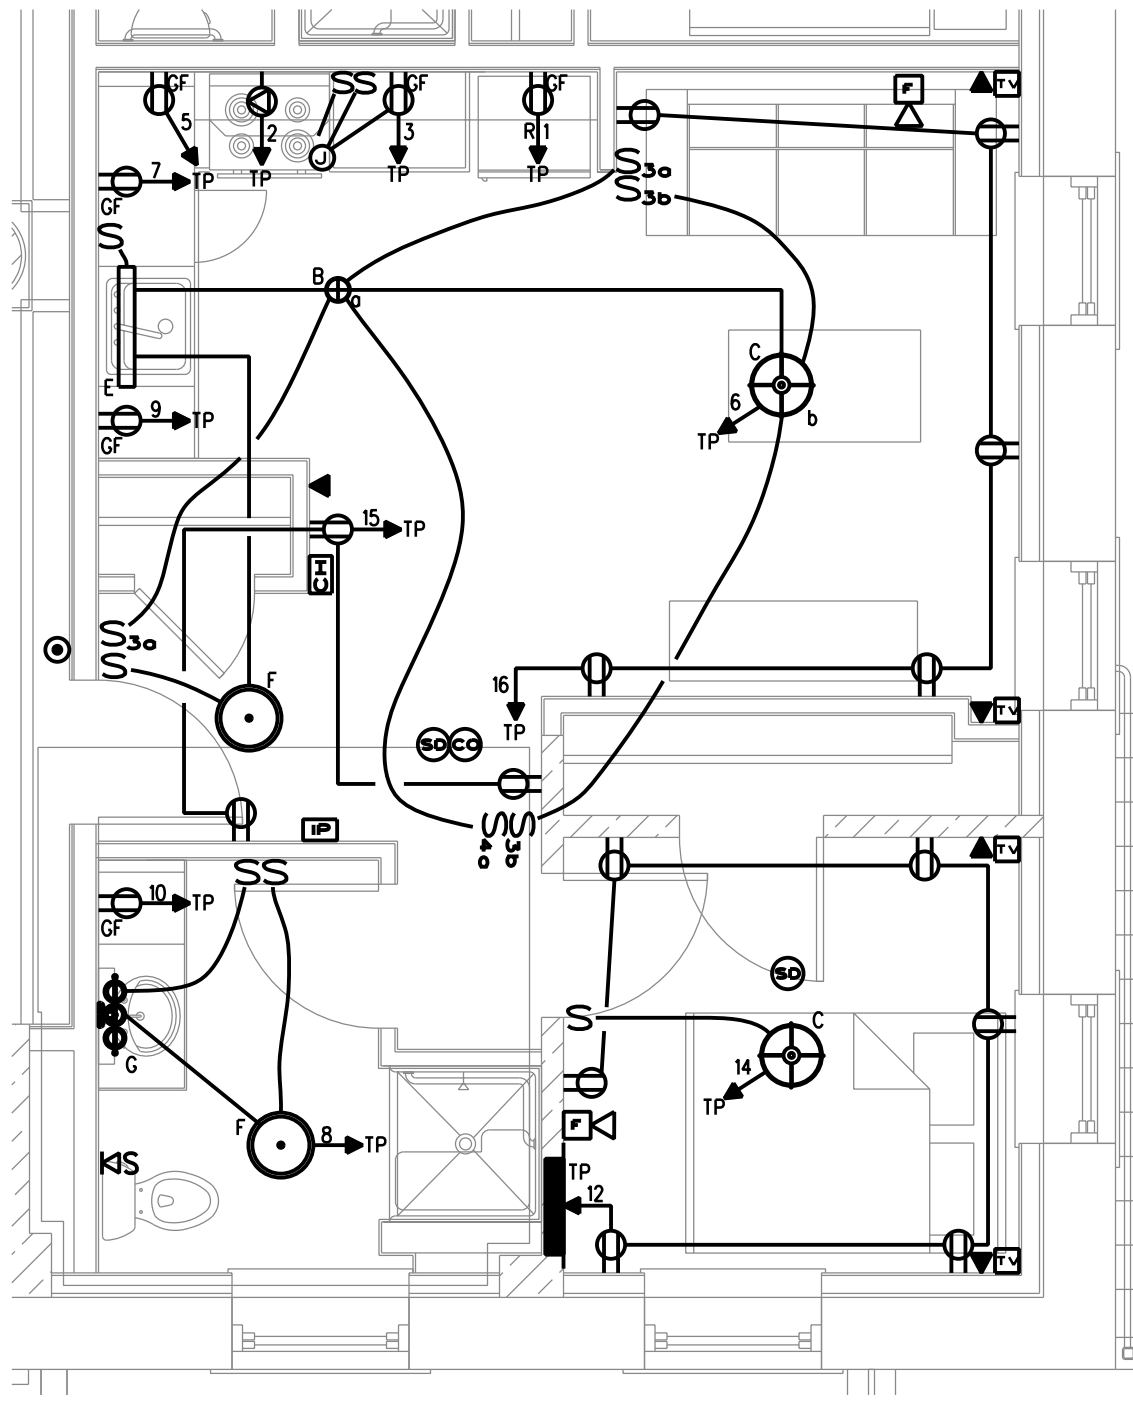


UNIT 111 1B-4
SCALE: 1/4" = 1'-0"

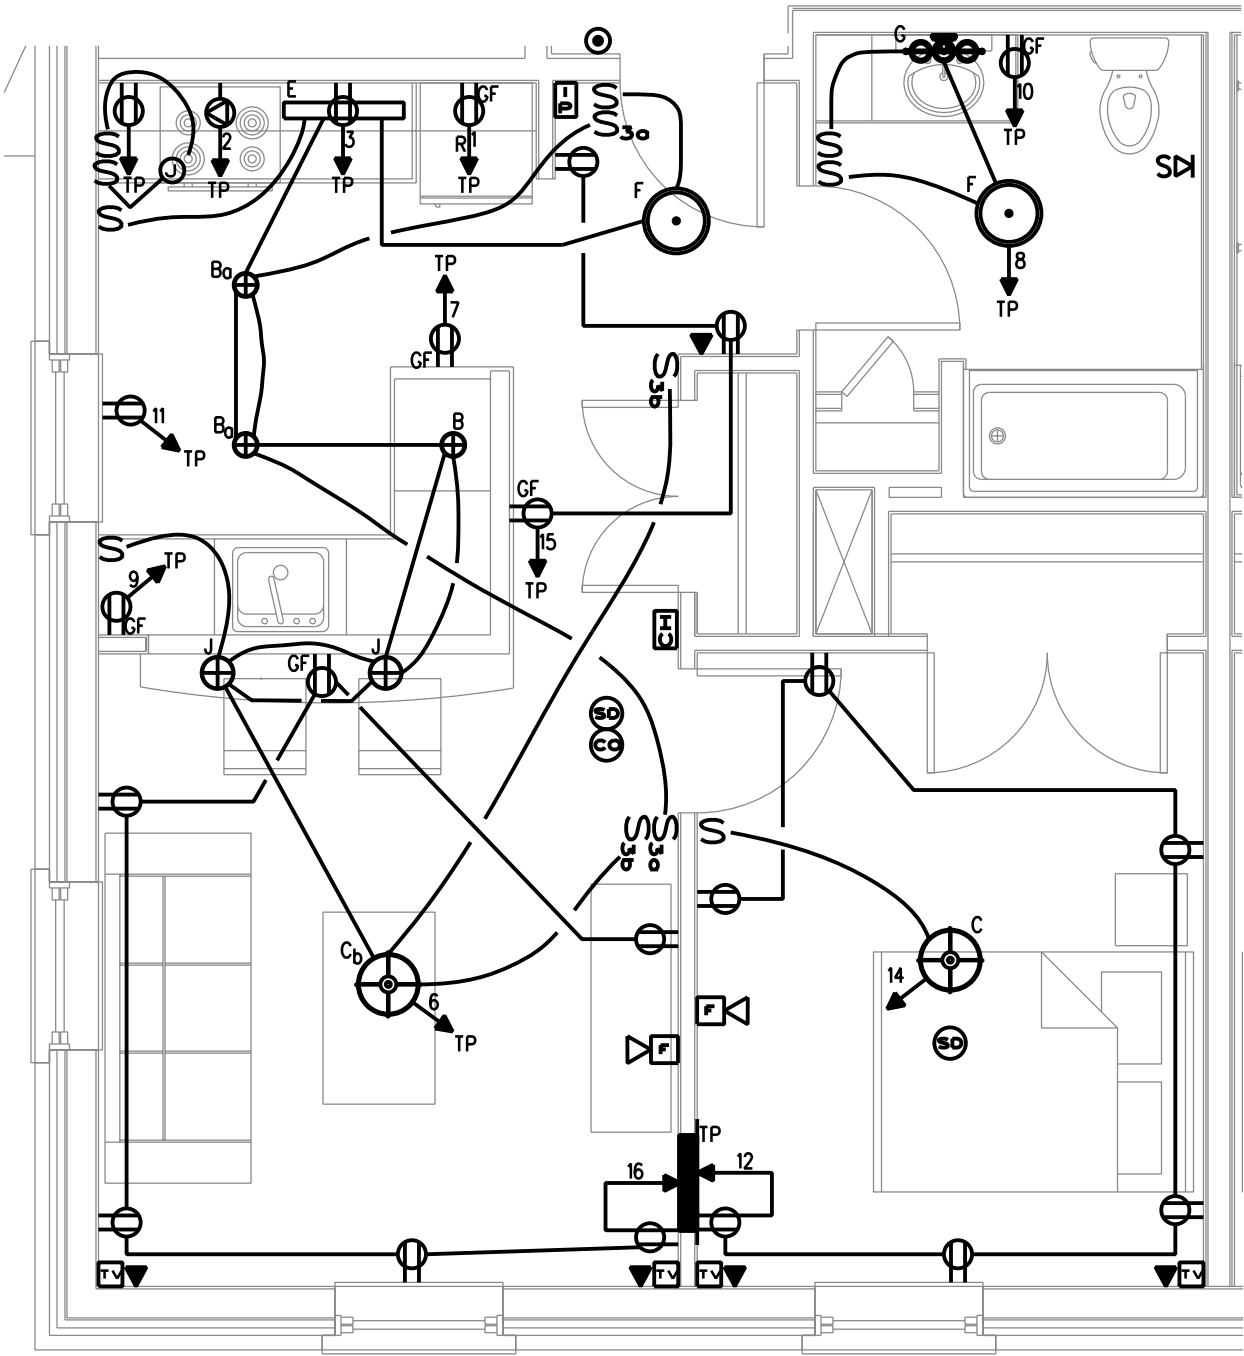


UNIT 201 1B-5
SCALE: 1/4" = 1'-0"
UNIT 301 SIMILAR

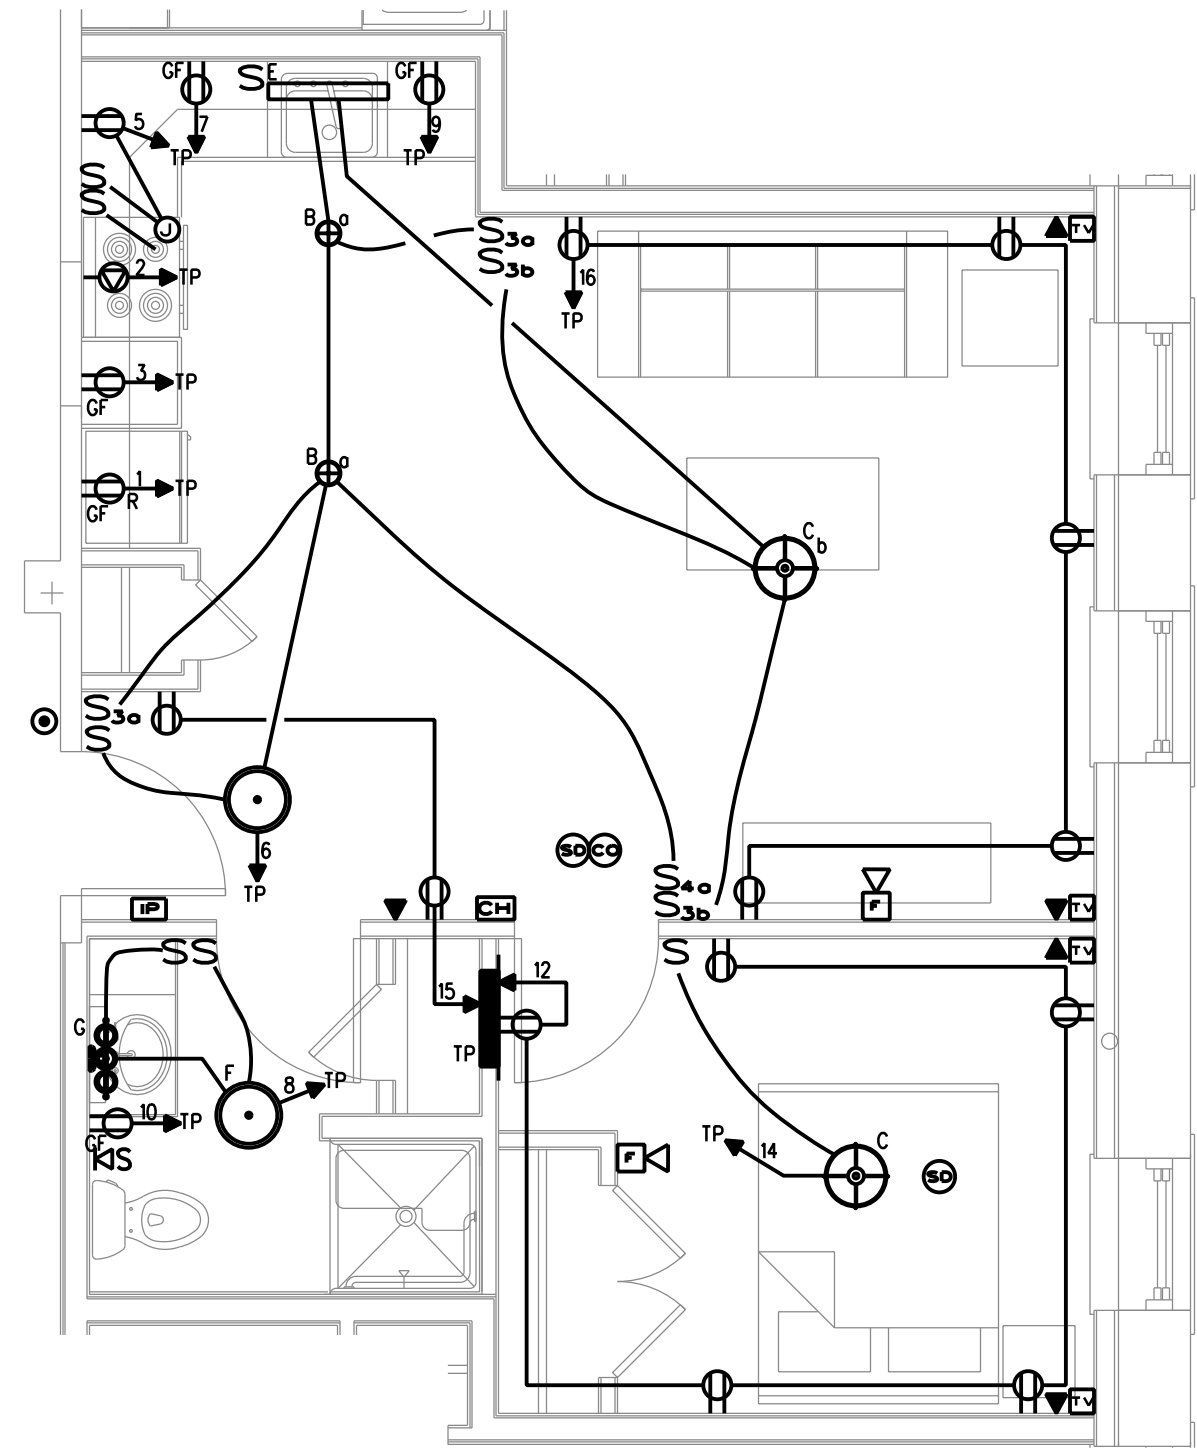


UNIT 210 1B-6
SCALE: 1/4" = 1'-0"

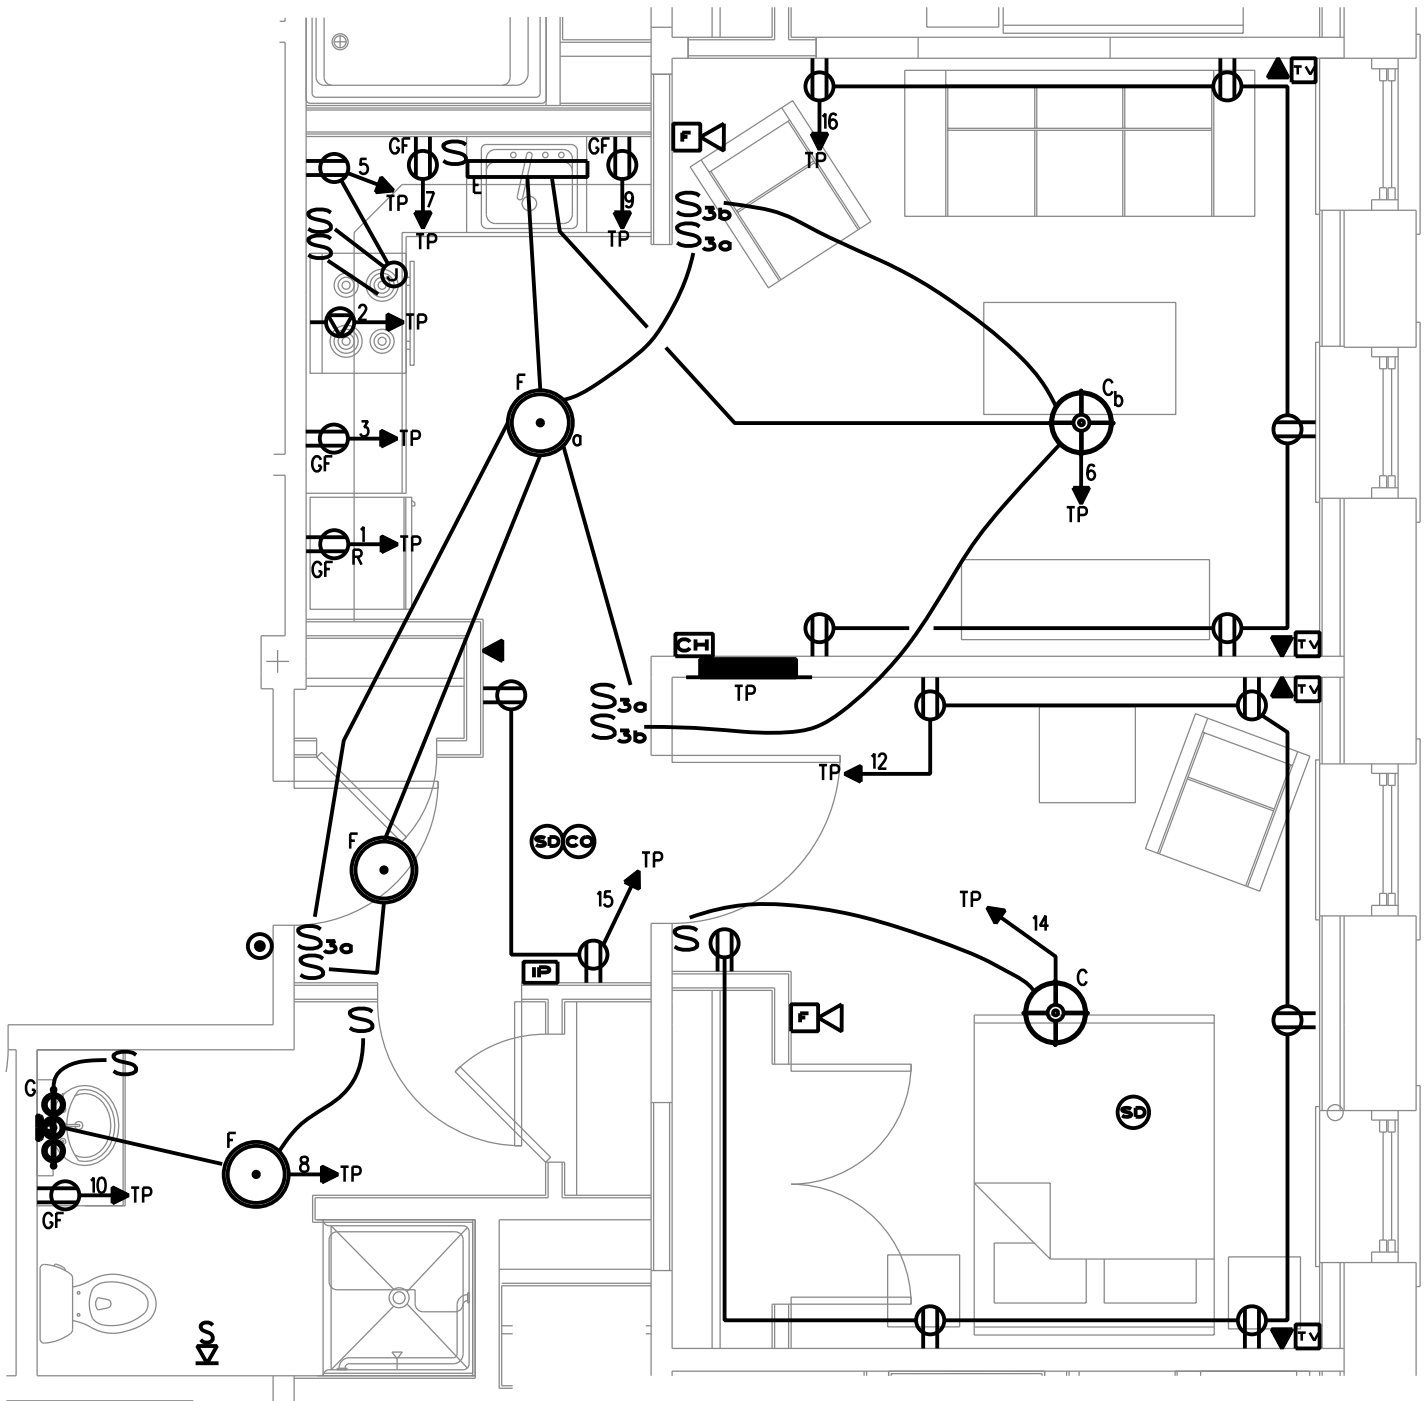

UNIT 310 1B-7
SCALE: 1/4" = 1'-0"

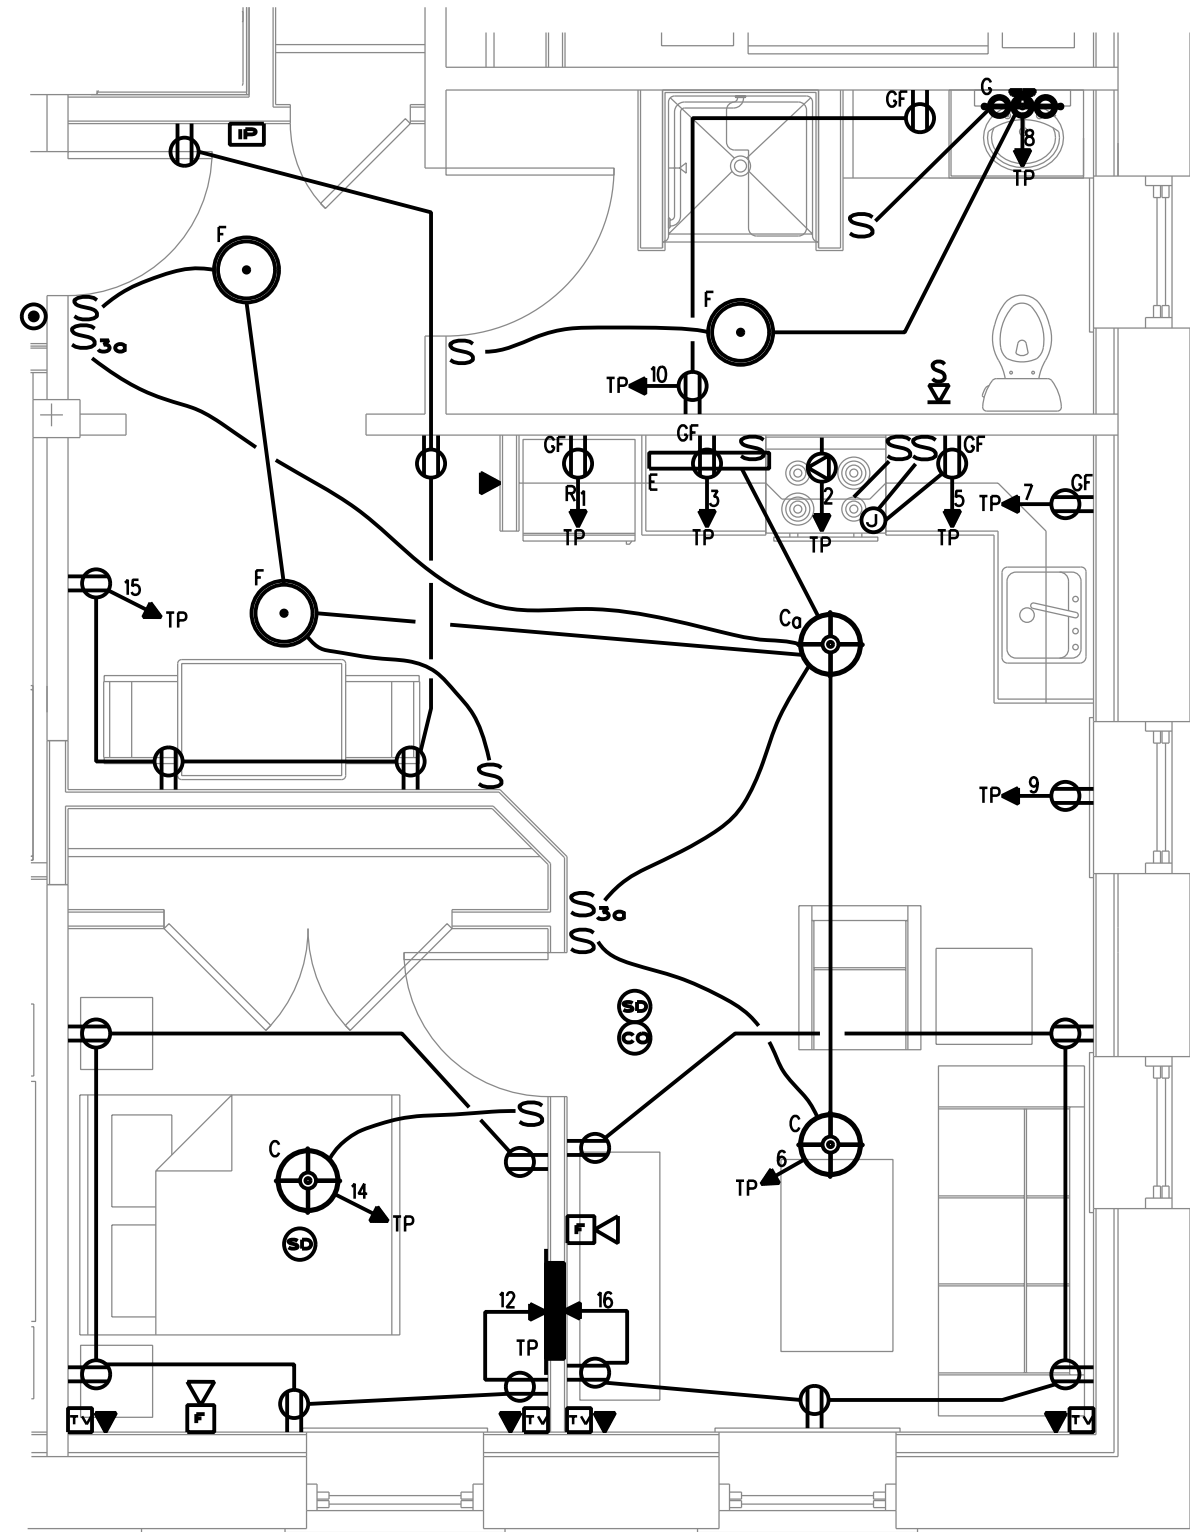

UNIT 311 1B-8
SCALE: 1/4" = 1'-0"

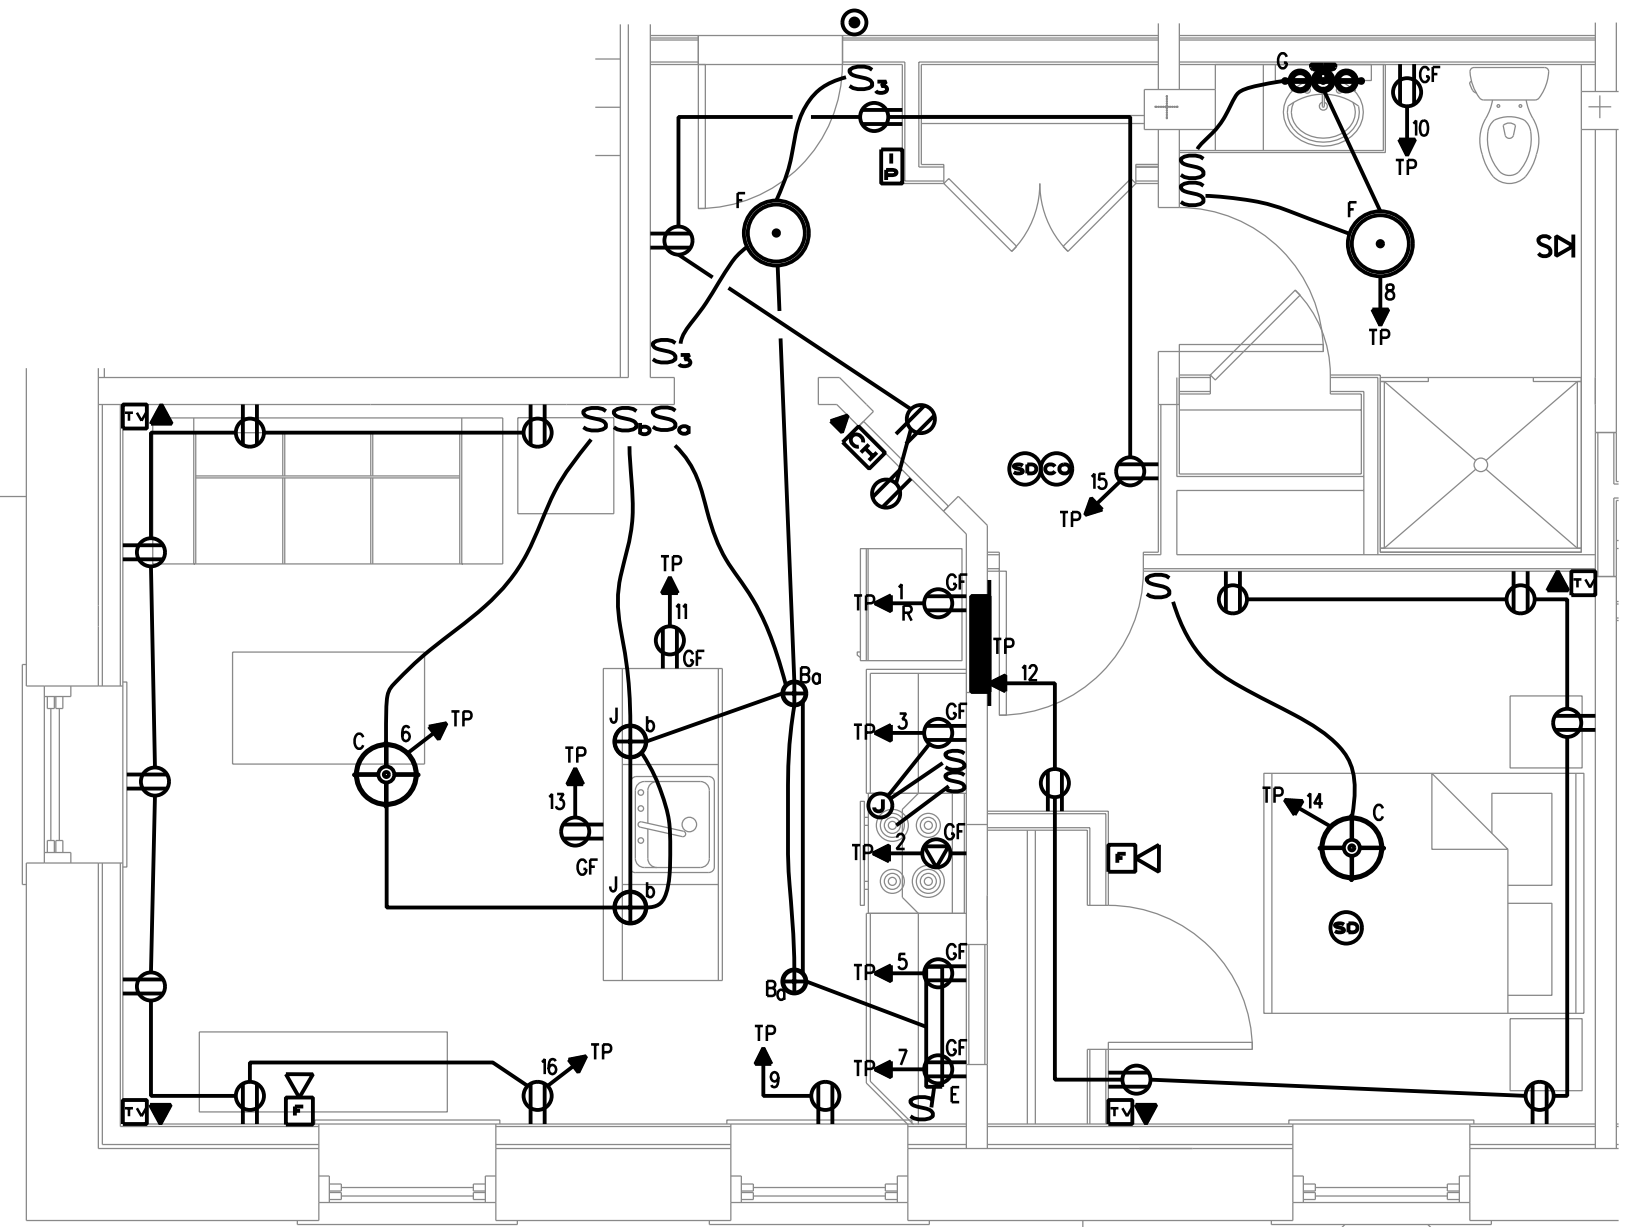

UNIT 312 1B-9
SCALE: 1/4" = 1'-0"

NOTE:
REFER TO DRAWING E4.1 FOR UNIT NOTES

ELECTRICAL DEMOLITION NOTES:

UNLESS NOTED OTHERWISE ON THE ELECTRICAL DRAWINGS, ALL ELECTRICAL SYSTEMS (INTERIOR AND EXTERIOR) INCLUDING BUT NOT LIMITED TO PANELS, DEVICES, CONDUIT, WIRING, FIRE ALARM CABLE, SECURITY CABLE, TELEPHONE CABLE, CATV CABLE, DATA CABLE, AND LIGHTING SHALL BE REMOVED IN THEIR ENTIRETY. EXCEPTIONS - EXISTING 480V, 3PH SERVICE, METERING EQUIPMENT, MAIN SERVICE PANEL IN BASEMENT ELECTRICAL ROOM SHALL REMAIN. EXISTING NOTIFIER AFP-200 ADDRESSABLE FIRE ALARM PANEL SHALL BE RELOCATED AND SALVAGED. EXISTING ELEVATOR MOTOR FEEDER SHALL BE RETAINED.



CWS

CWS Architects

Architecture
Space Planning
Value Design

434 Cumberland Avenue
Portland, ME 04101
Phone: (207) 774-4441
Fax: (207) 774-4016

www.CWSarch.com

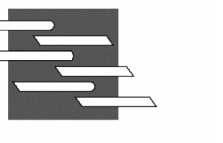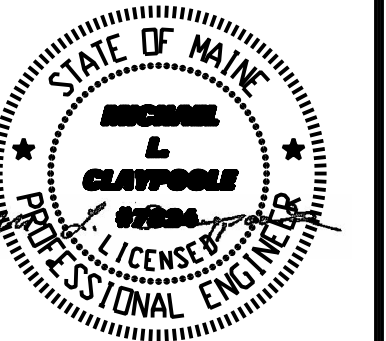

BENNETT
ENGINEERING
MECHANICAL-ELECTRICAL
(207) 865-9475

Owner:

Children's
Hospital Housing
Partners, LP

309 Cumberland Ave.
Suite 203
Portland, Maine 04101

CONSTRUCTION MANAGER:

WRIGHT-RYAN
CONSTRUCTION

10 DANFORTH STREET
PORTLAND, ME 04101
TEL: (207) 773-3625

ELM
TERRACE

68 HIGH STREET
PORTLAND, MAINE

Project No: 09428

Drawing Title:

UNIT POWER AND
LIGHTING PLANS

Scale: 1/8" = 1'-0"

Date: September 8, 2011

Revisions:



Drawing Number:

E3.6