

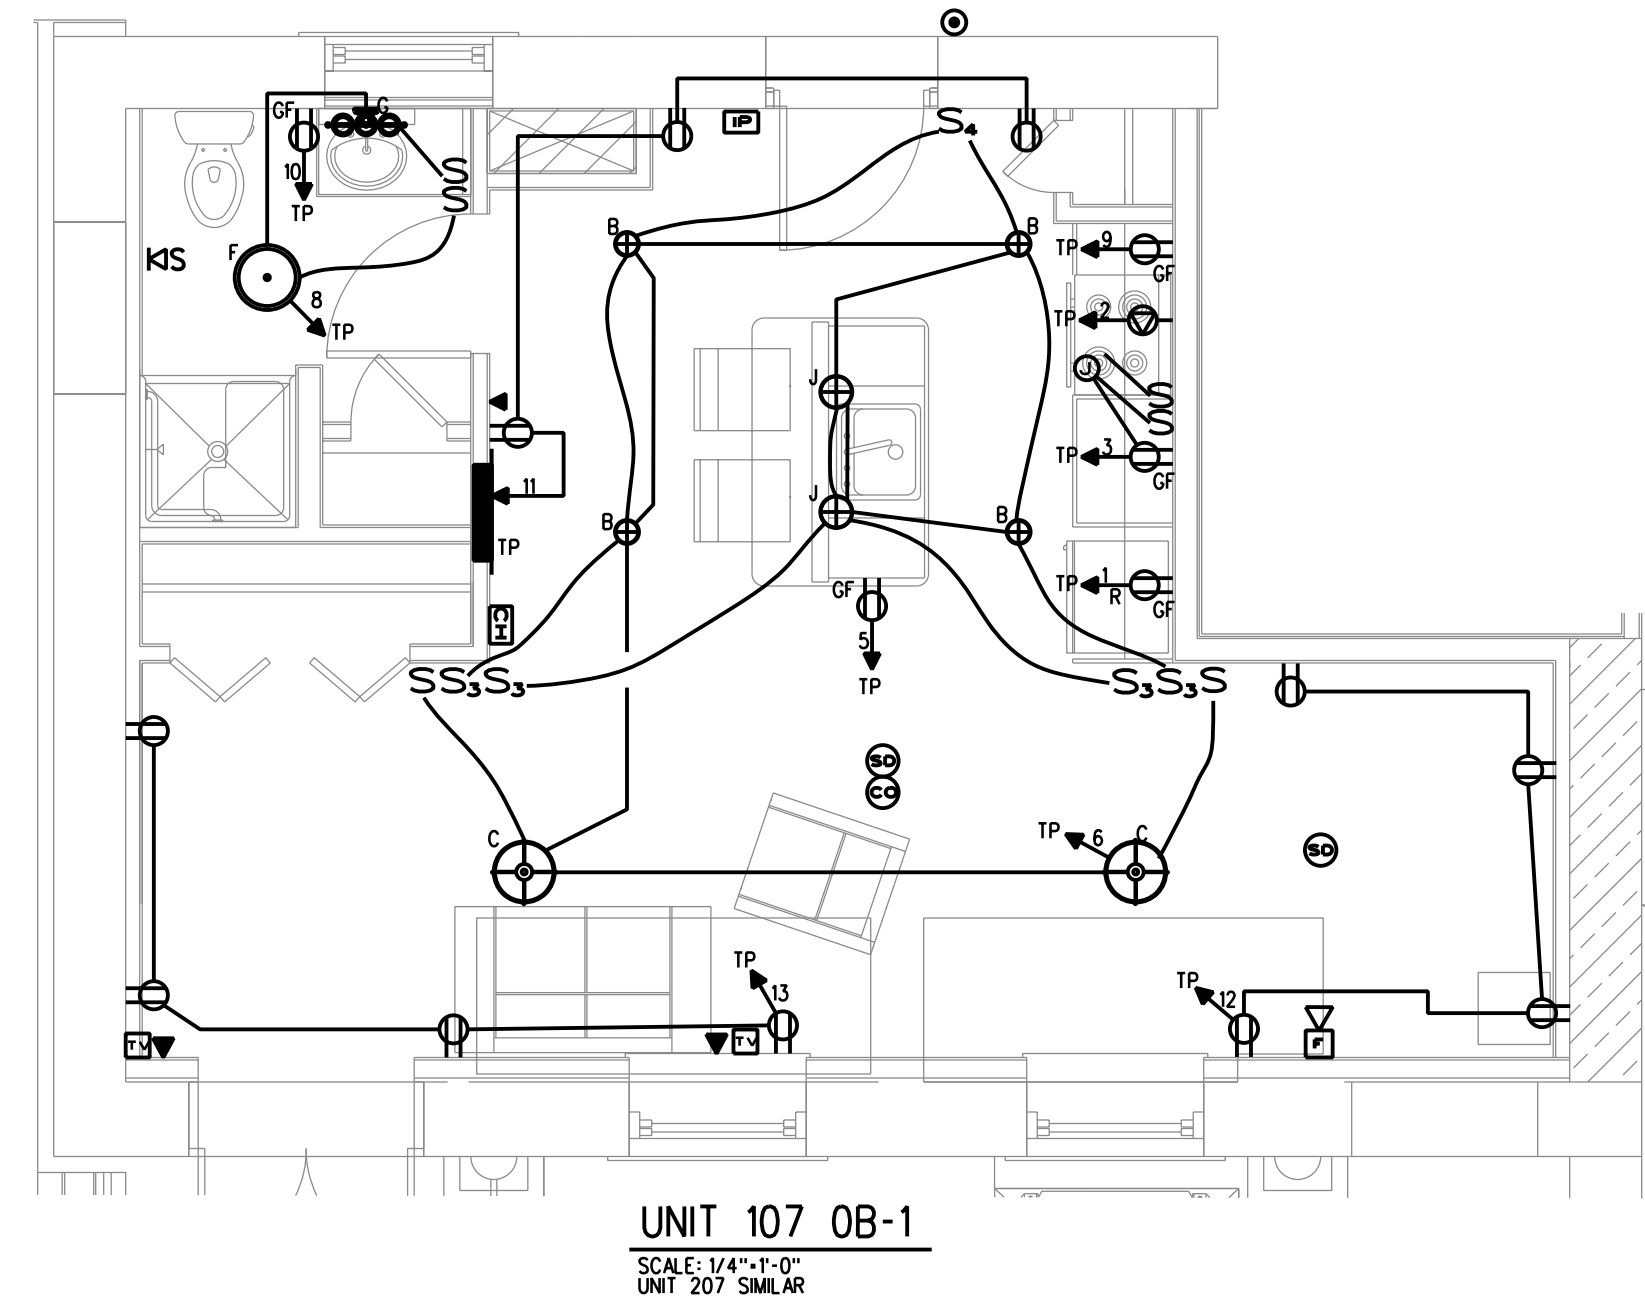
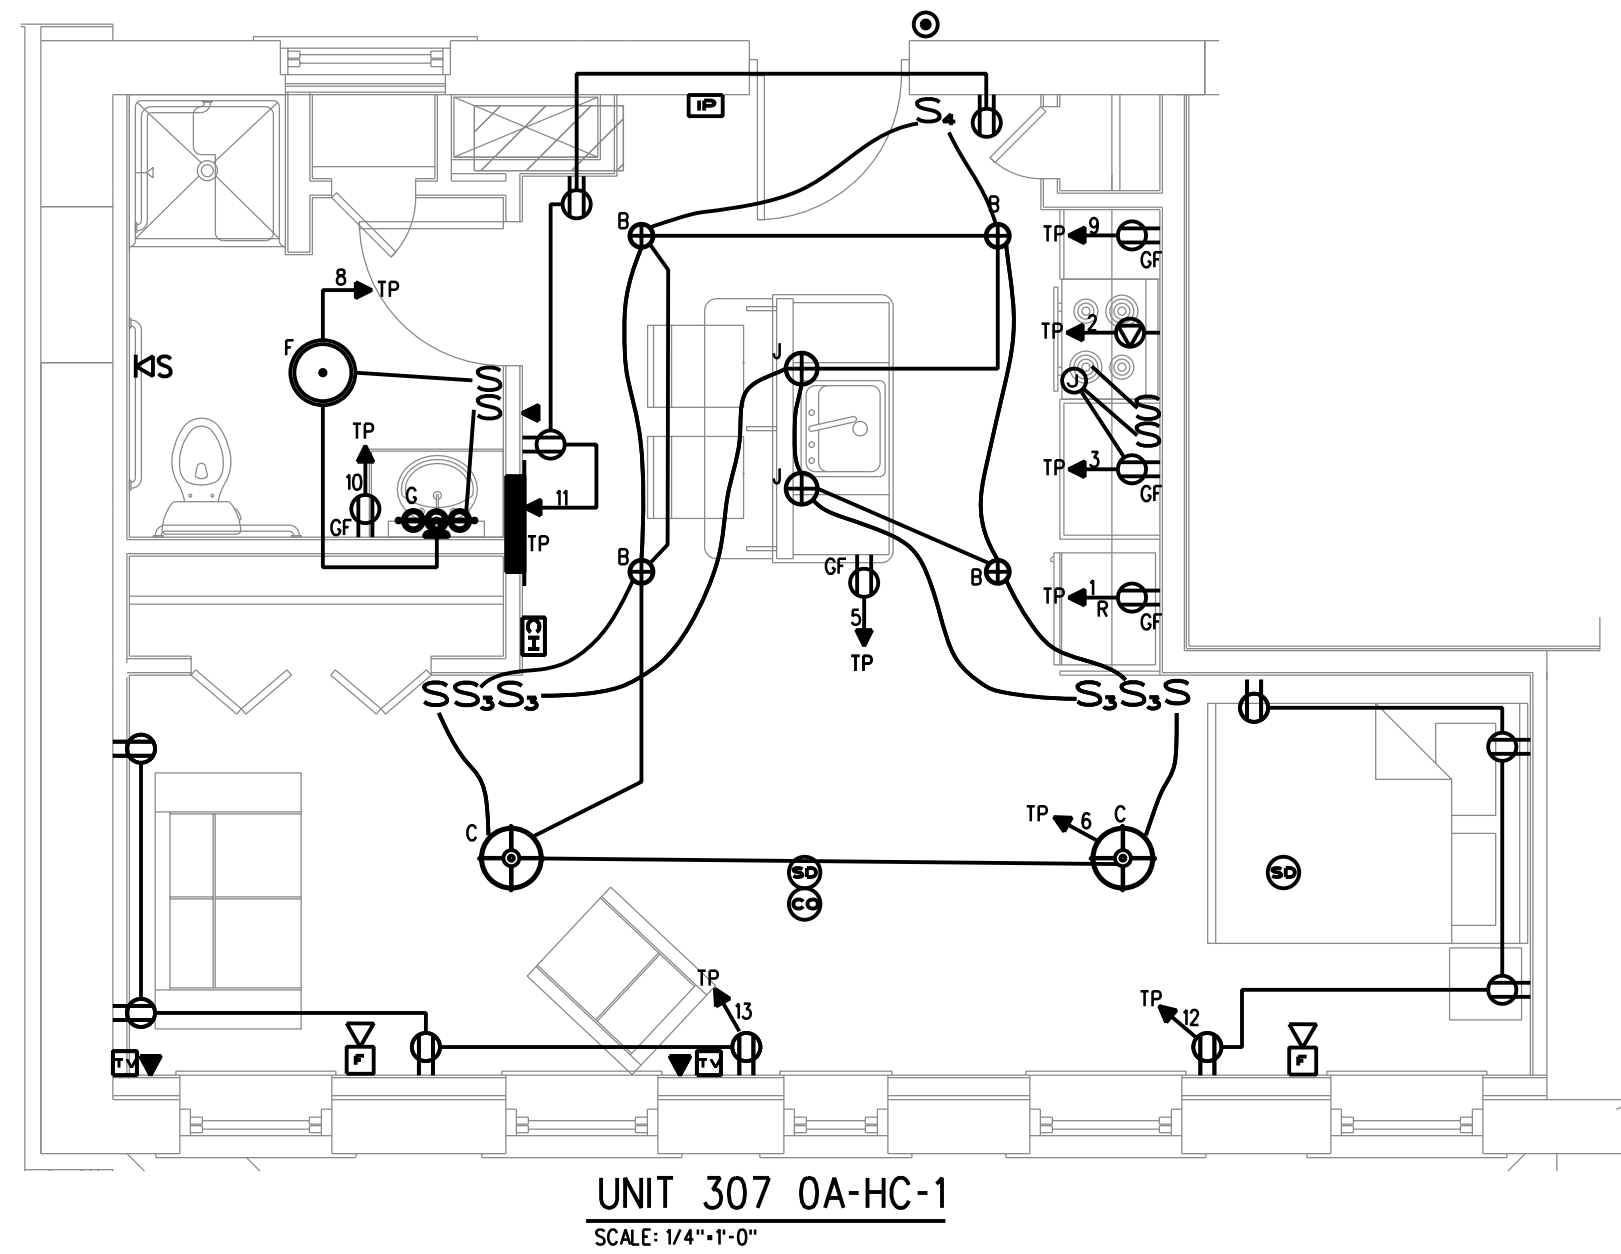
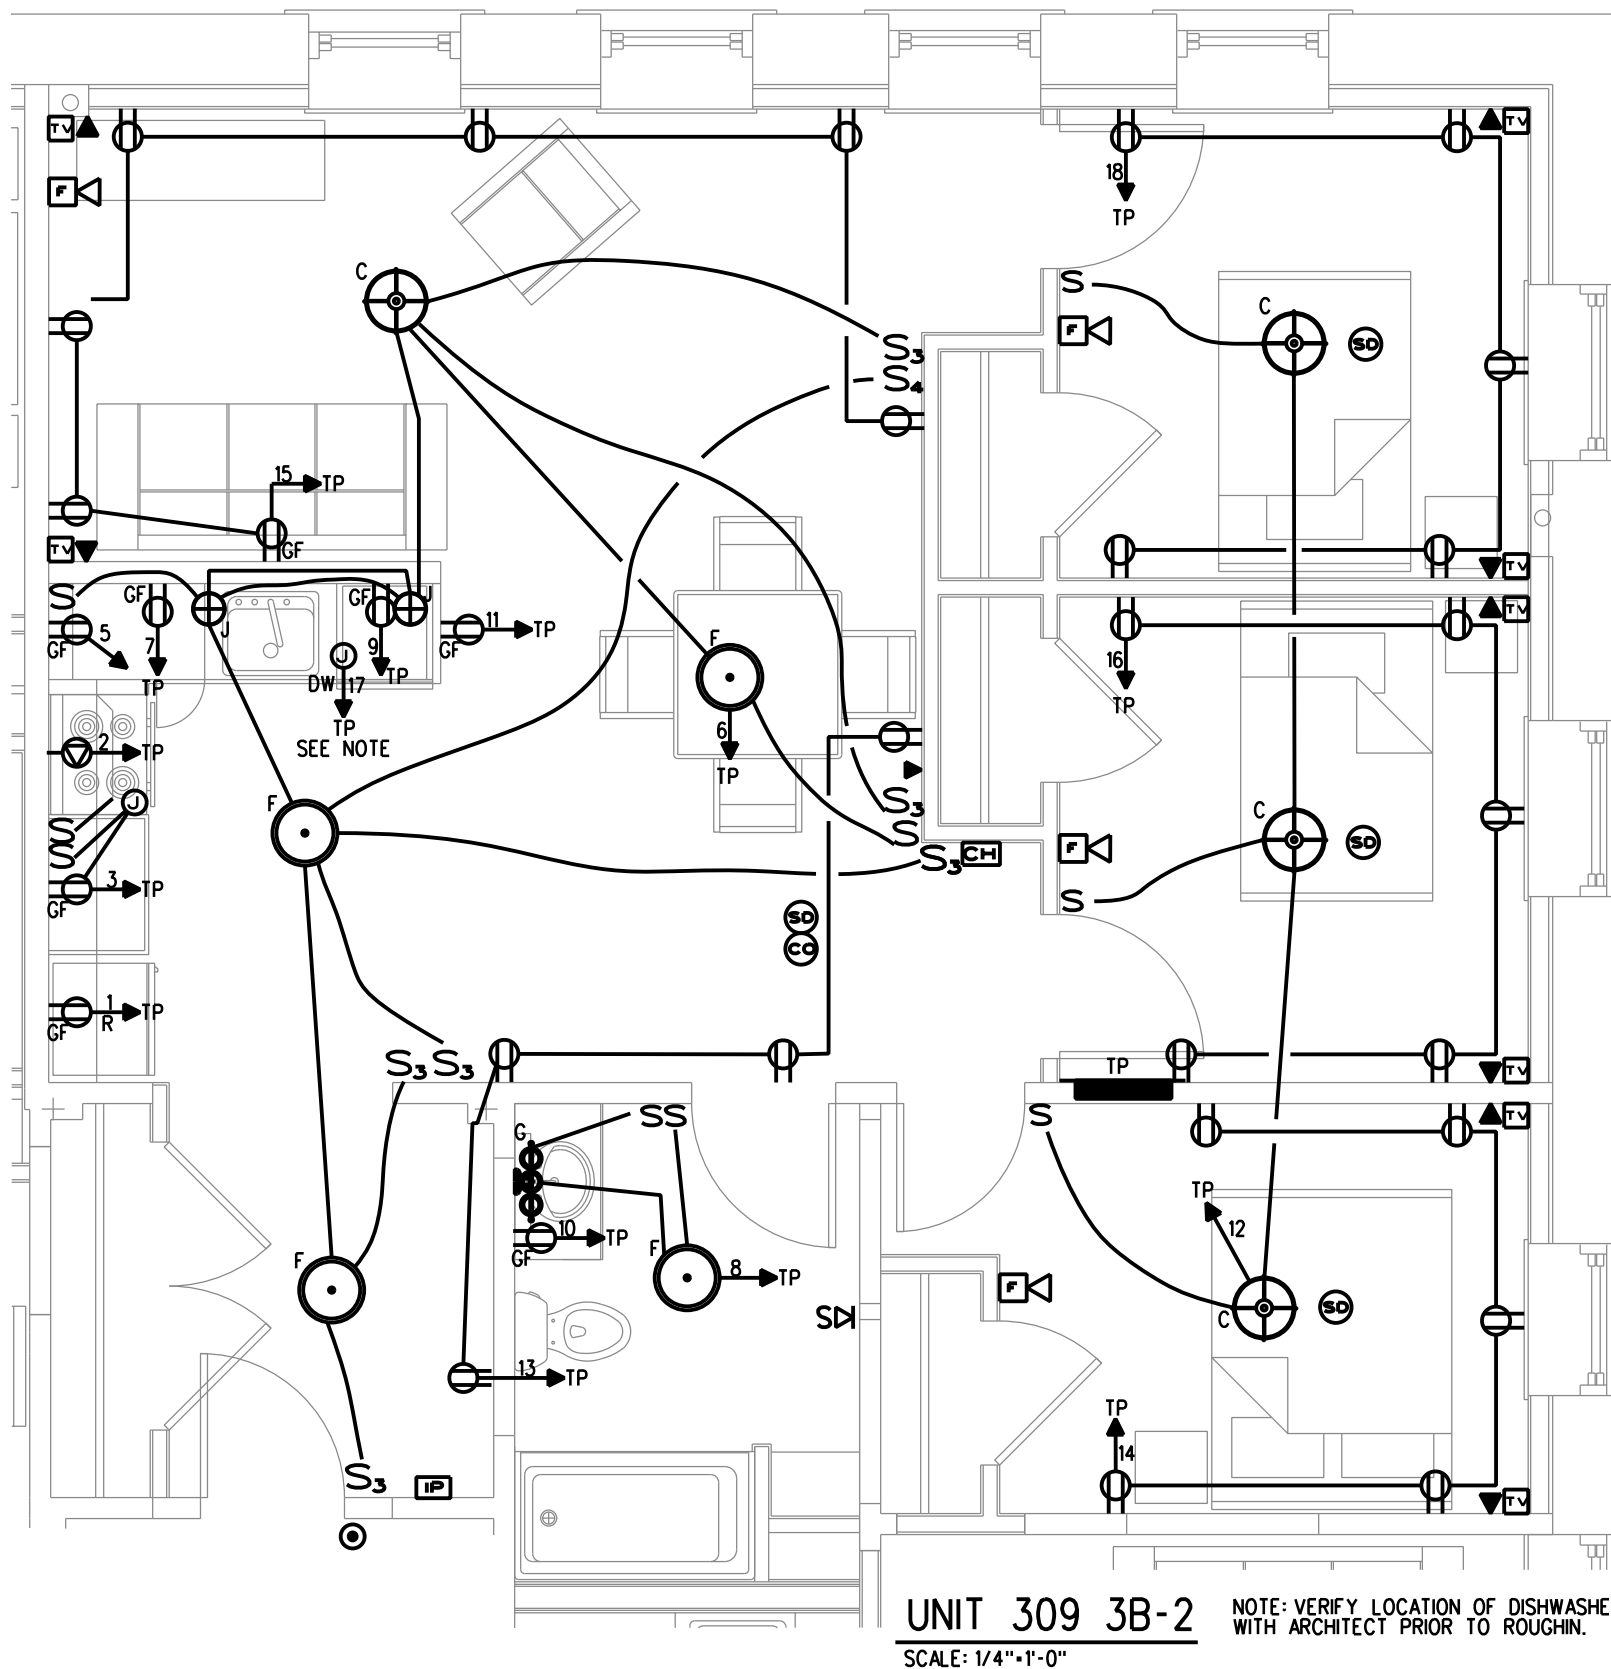
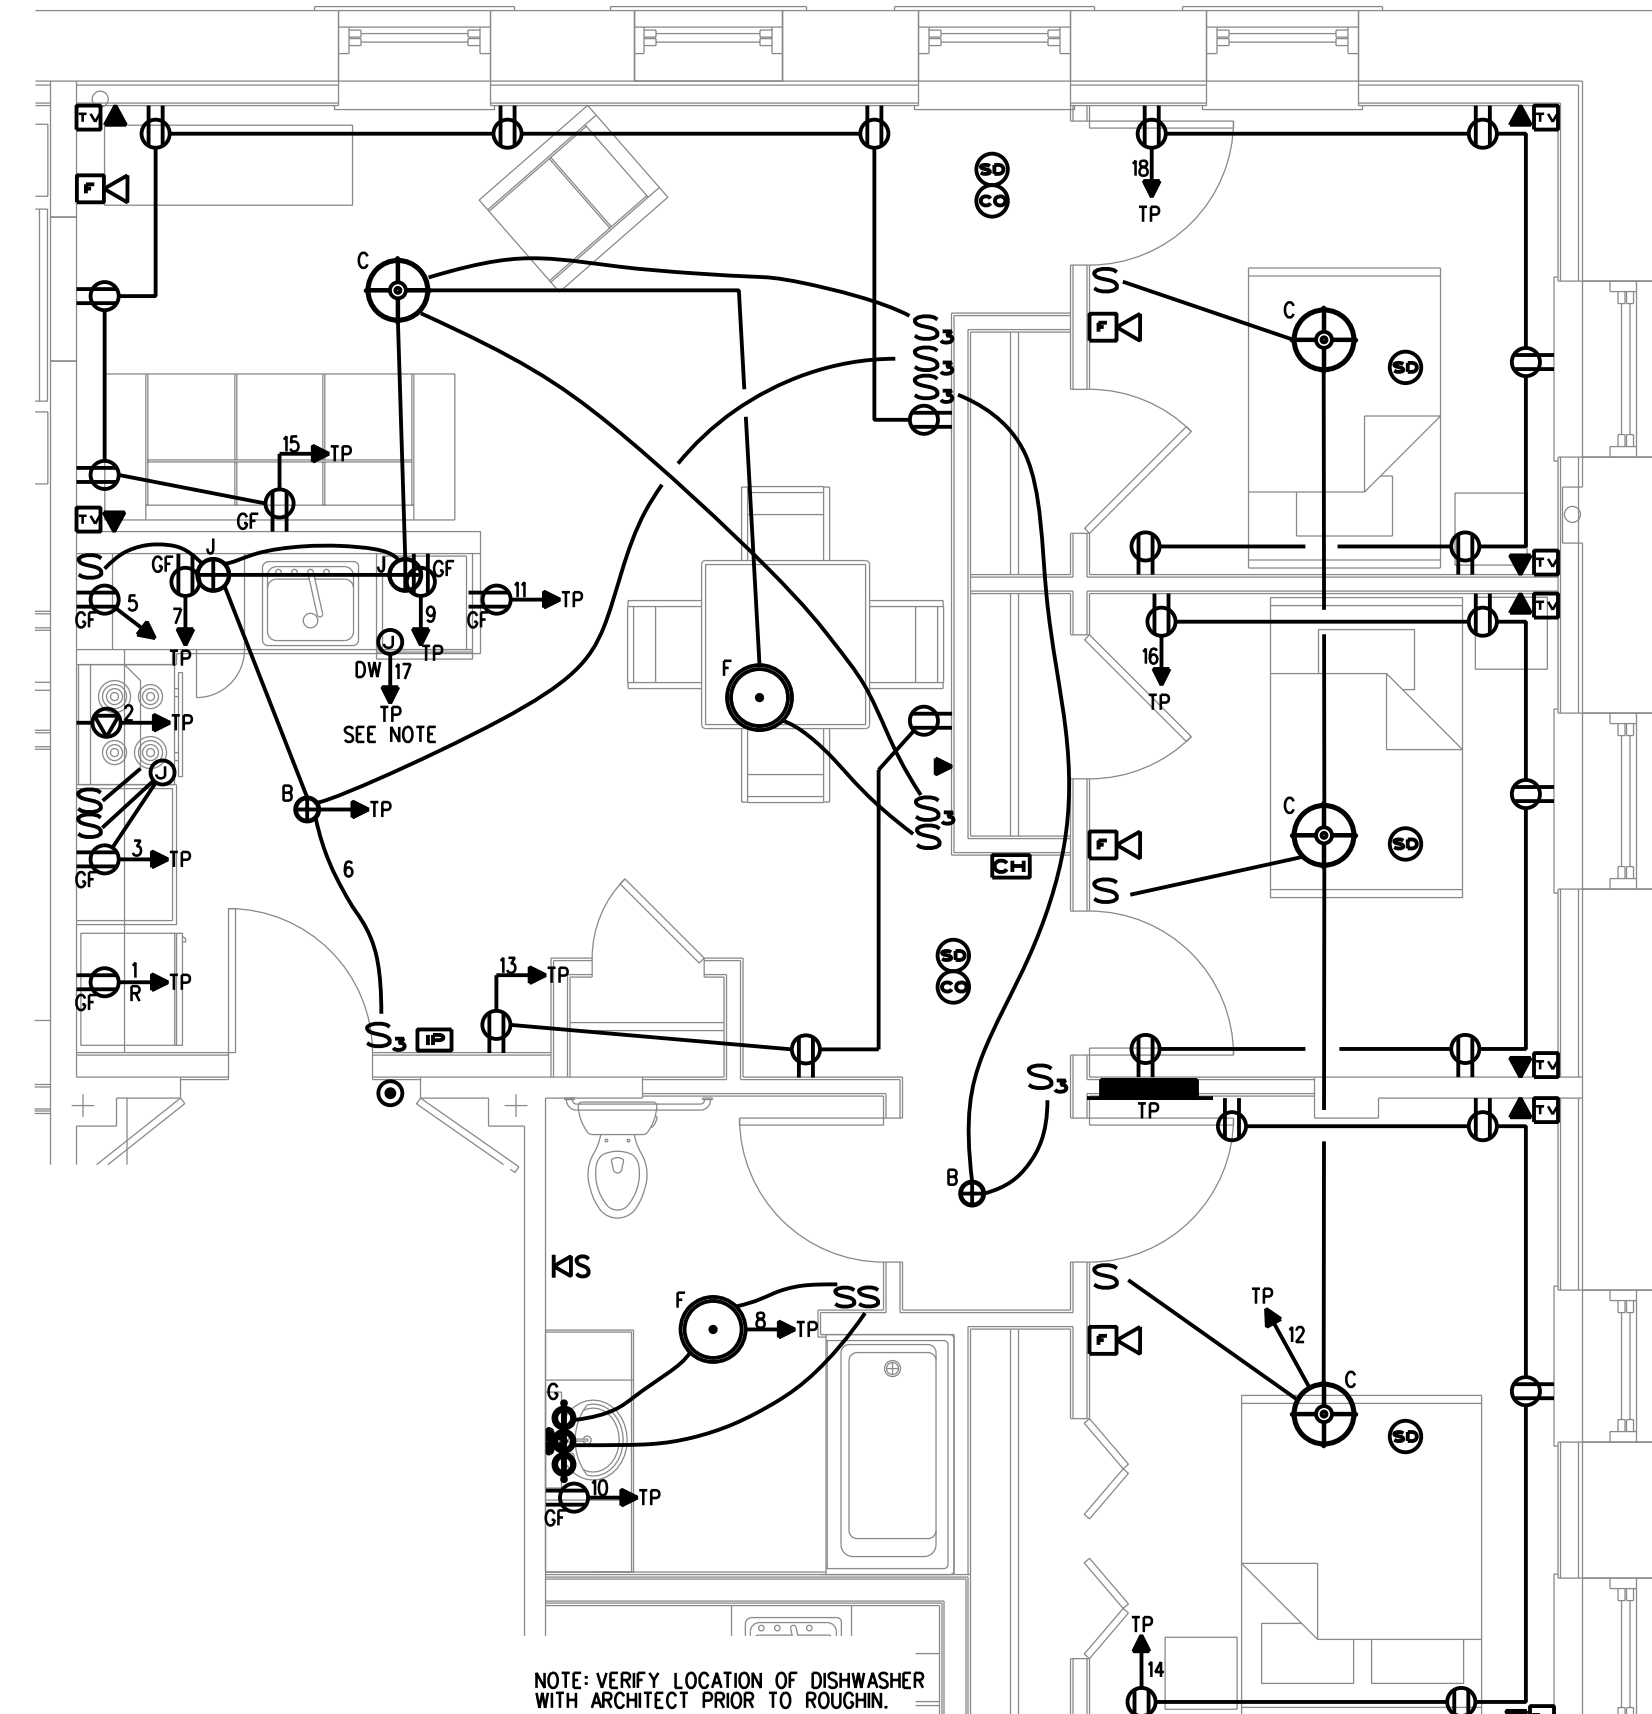


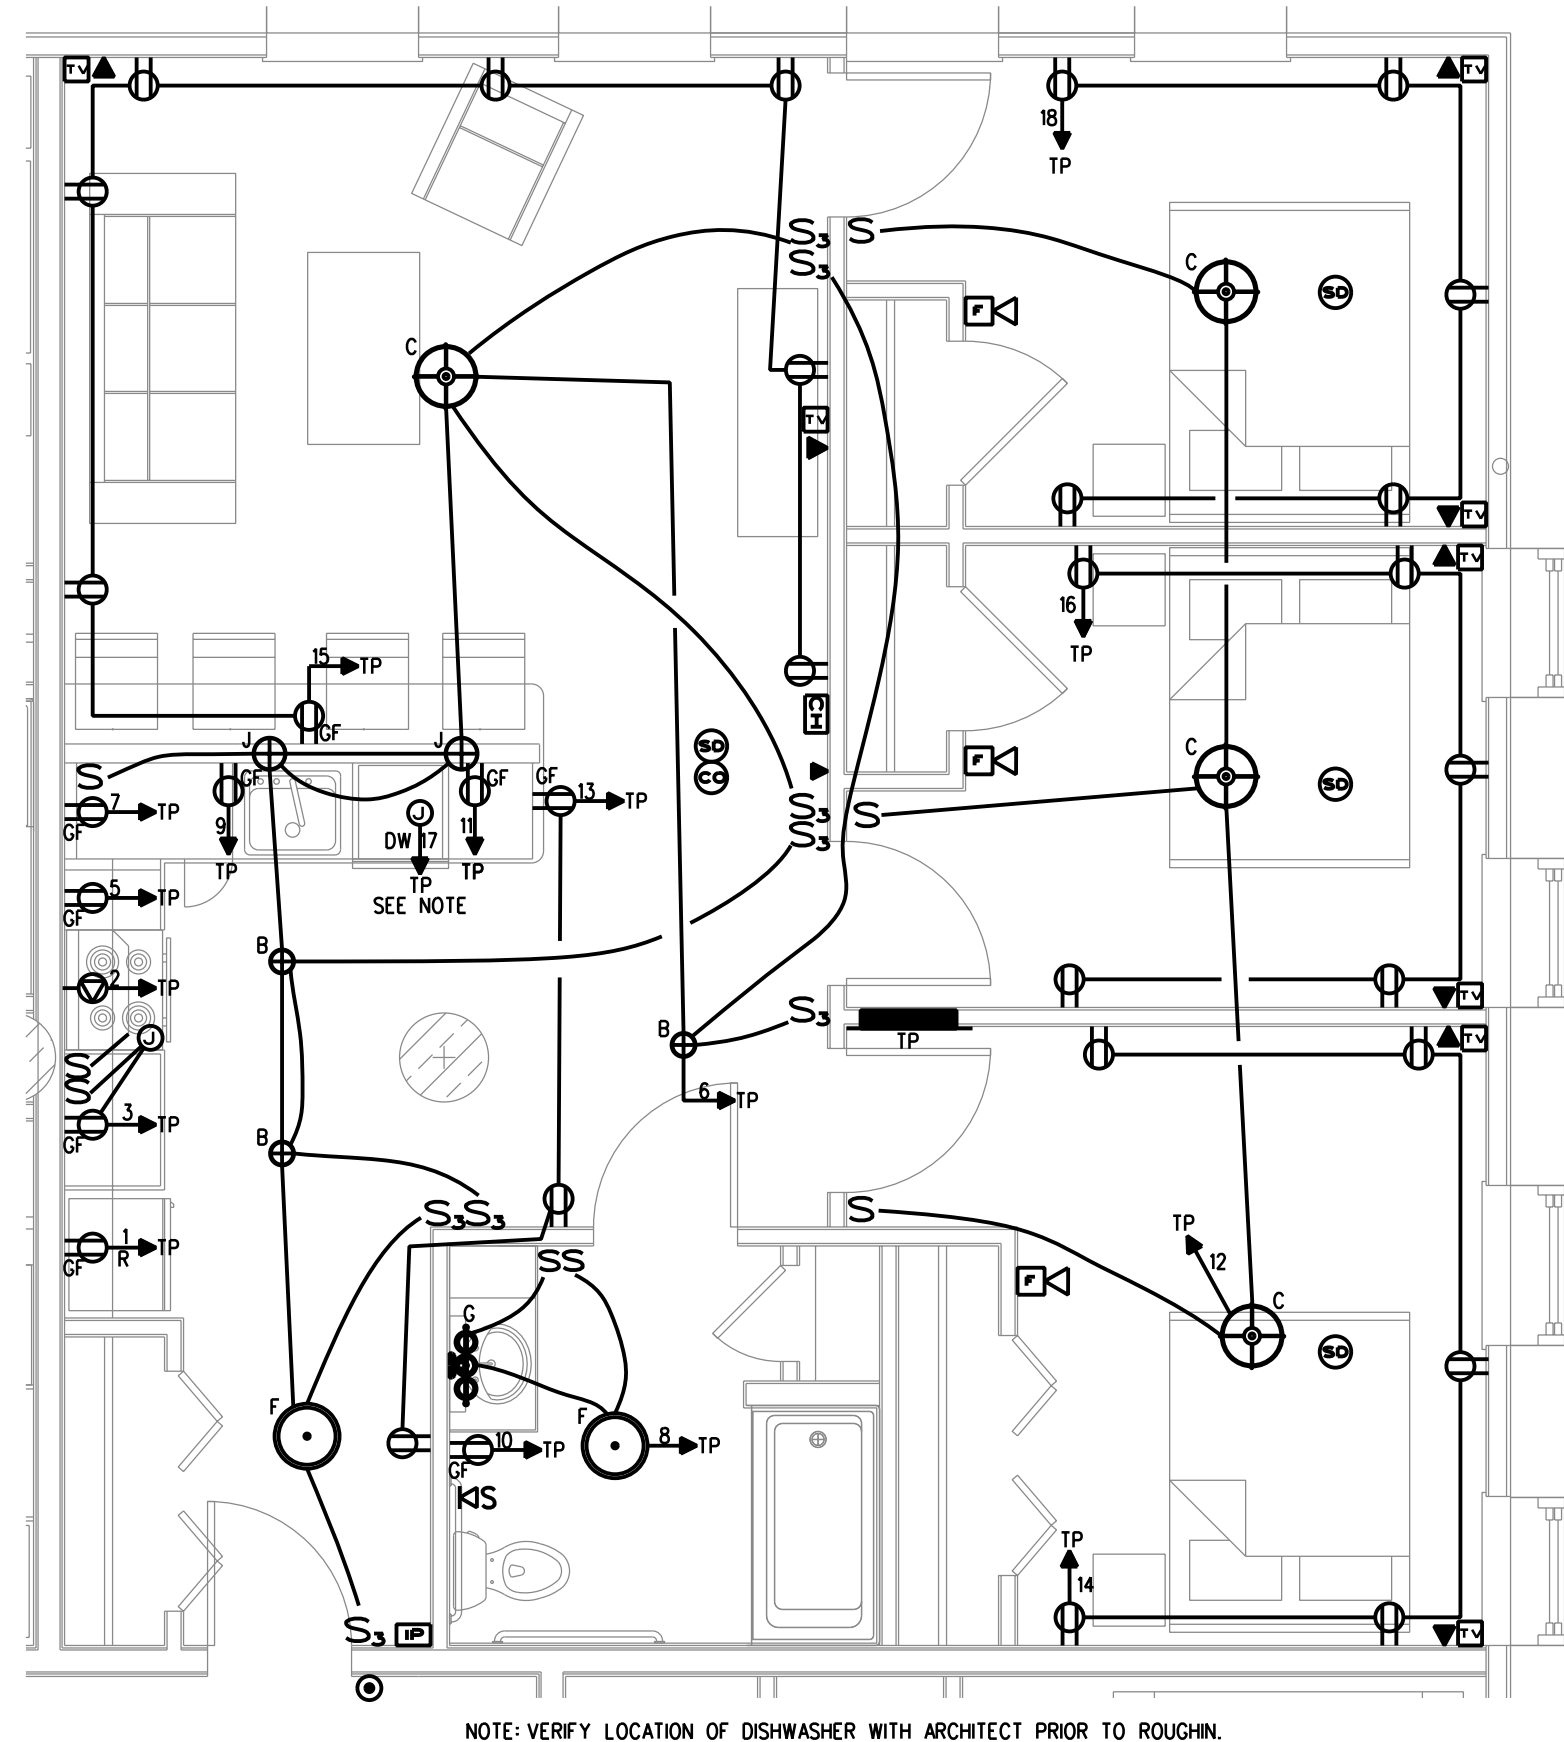


ELECTRICAL DEMOLITION NOTES:

UNLESS NOTED OTHERWISE ON THE ELECTRICAL DRAWINGS, ALL ELECTRICAL SYSTEMS (INTERIOR AND EXTERIOR), INCLUDING BUT NOT LIMITED TO PANELS, DEVICES, CONDUIT, WIRING, FIRE ALARM CABLE, SECURITY CABLE, TELEPHONE CABLE, CATV CABLE, DATA CABLE, AND LIGHTING SHALL BE REMOVED IN THEIR ENTIRETY. EXCEPTIONS - EXISTING 480V, 3PH SERVICE, METERING EQUIPMENT, MAIN SERVICE PANEL IN BASEMENT ELECTRICAL ROOM SHALL REMAIN. EXISTING NOTIFIER AFP-200 ADDRESSABLE FIRE ALARM PANEL SHALL BE RELOCATED AND SALVAGED. EXISTING ELEVATOR MOTOR FEEDER SHALL BE RETAINED.

NOTE:
REFER TO DRAWING E4.1 FOR UNIT NOTES

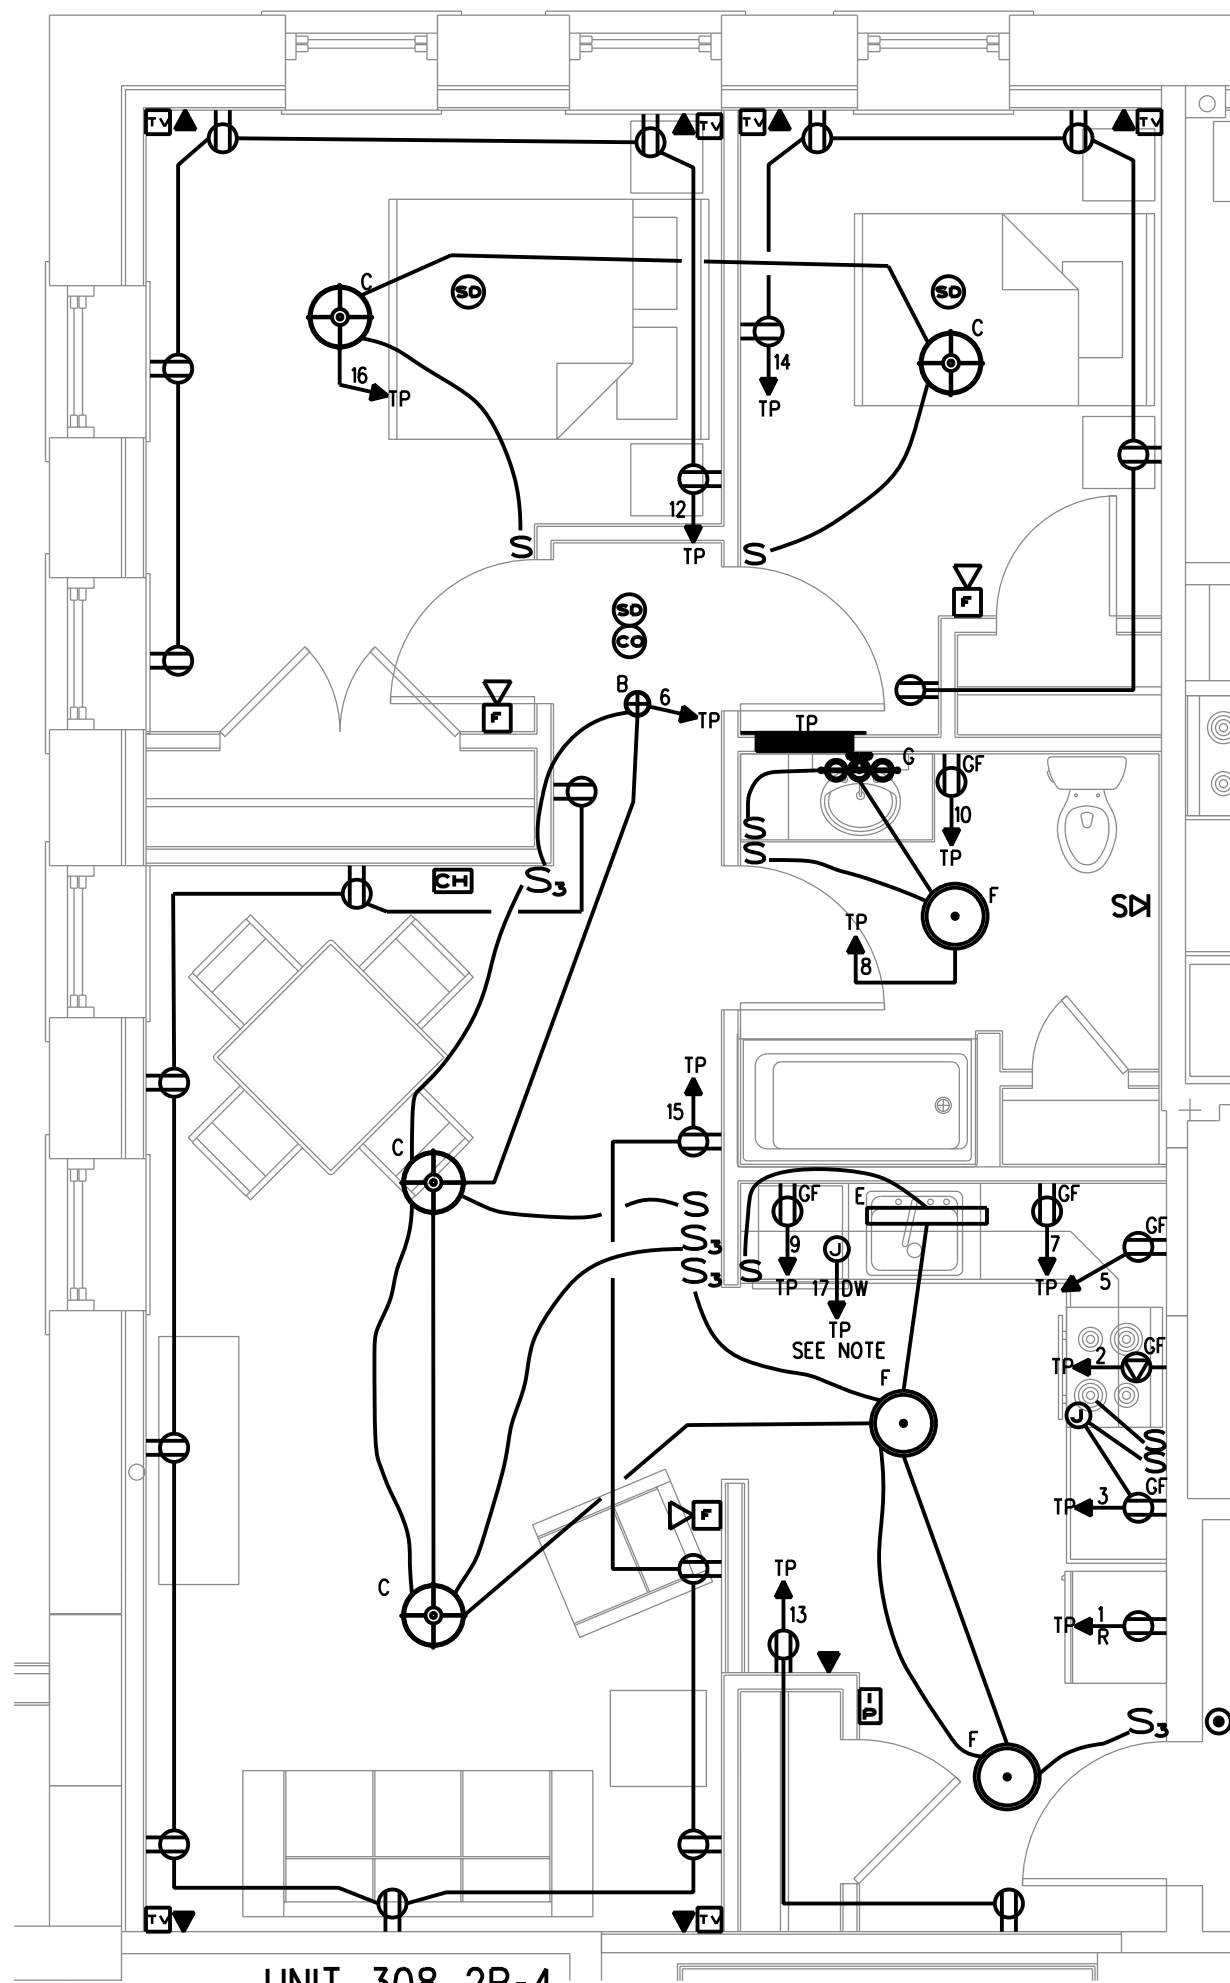

CWS Architects
Architecture
Space Planning
Value Design
434 Cumberland Avenue
Portland, ME 04101
Phone: (207) 774-4441
Fax: (207) 774-4016
www.CWSarch.com

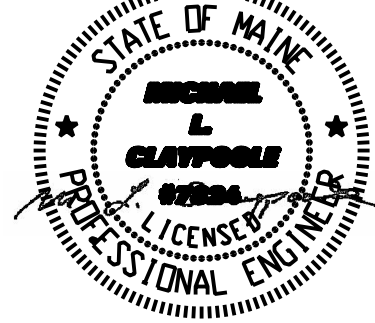

STATE OF MAINE
AARON L. PLATT
LICENSED PROFESSIONAL ENGINEER
MECHANICAL-ELECTRICAL
(207) 865-9475



BENNETT
ENGINEERING
MECHANICAL-ELECTRICAL
(207) 865-9475

Owner:
Children's Hospital Housing Partners, LP
309 Cumberland Ave.
Suite 203
Portland, Maine 04101

CONSTRUCTION MANAGER:
WRIGHT-RYAN CONSTRUCTION
10 DANFORTH STREET
PORTLAND, ME 04101
TEL: (207) 773-3625

ELM
TERRACE
68 HIGH STREET
PORTLAND, MAINE

Project No: 09428

Drawing Title:
UNIT POWER AND LIGHTING PLANS

Scale: 1/8" = 1'-0"
Date: September 8, 2011
Revisions:

- △
- △
- △
- △
- △
- △

Drawing Number:
E3.8