


DEMOLITION NOTE -
UNLESS NOTED OTHERWISE ON THE DRAWINGS, ALL MECHANICAL AND PLUMBING SYSTEMS INCLUDING BUT NOT LIMITED TO BOILERS, BREACHING, PUMPS, PIPING, DUCTWORK, FANS, INSULATION, CONTROLS, PLUMBING FIXTURES, WATER HEATERS, SPRINKLER VALVES AND HANGERS SHALL BE REMOVED IN THEIR ENTIRETY. ASBESTOS ABATEMENT WHERE APPLICABLE, SHALL BE BY OTHERS.

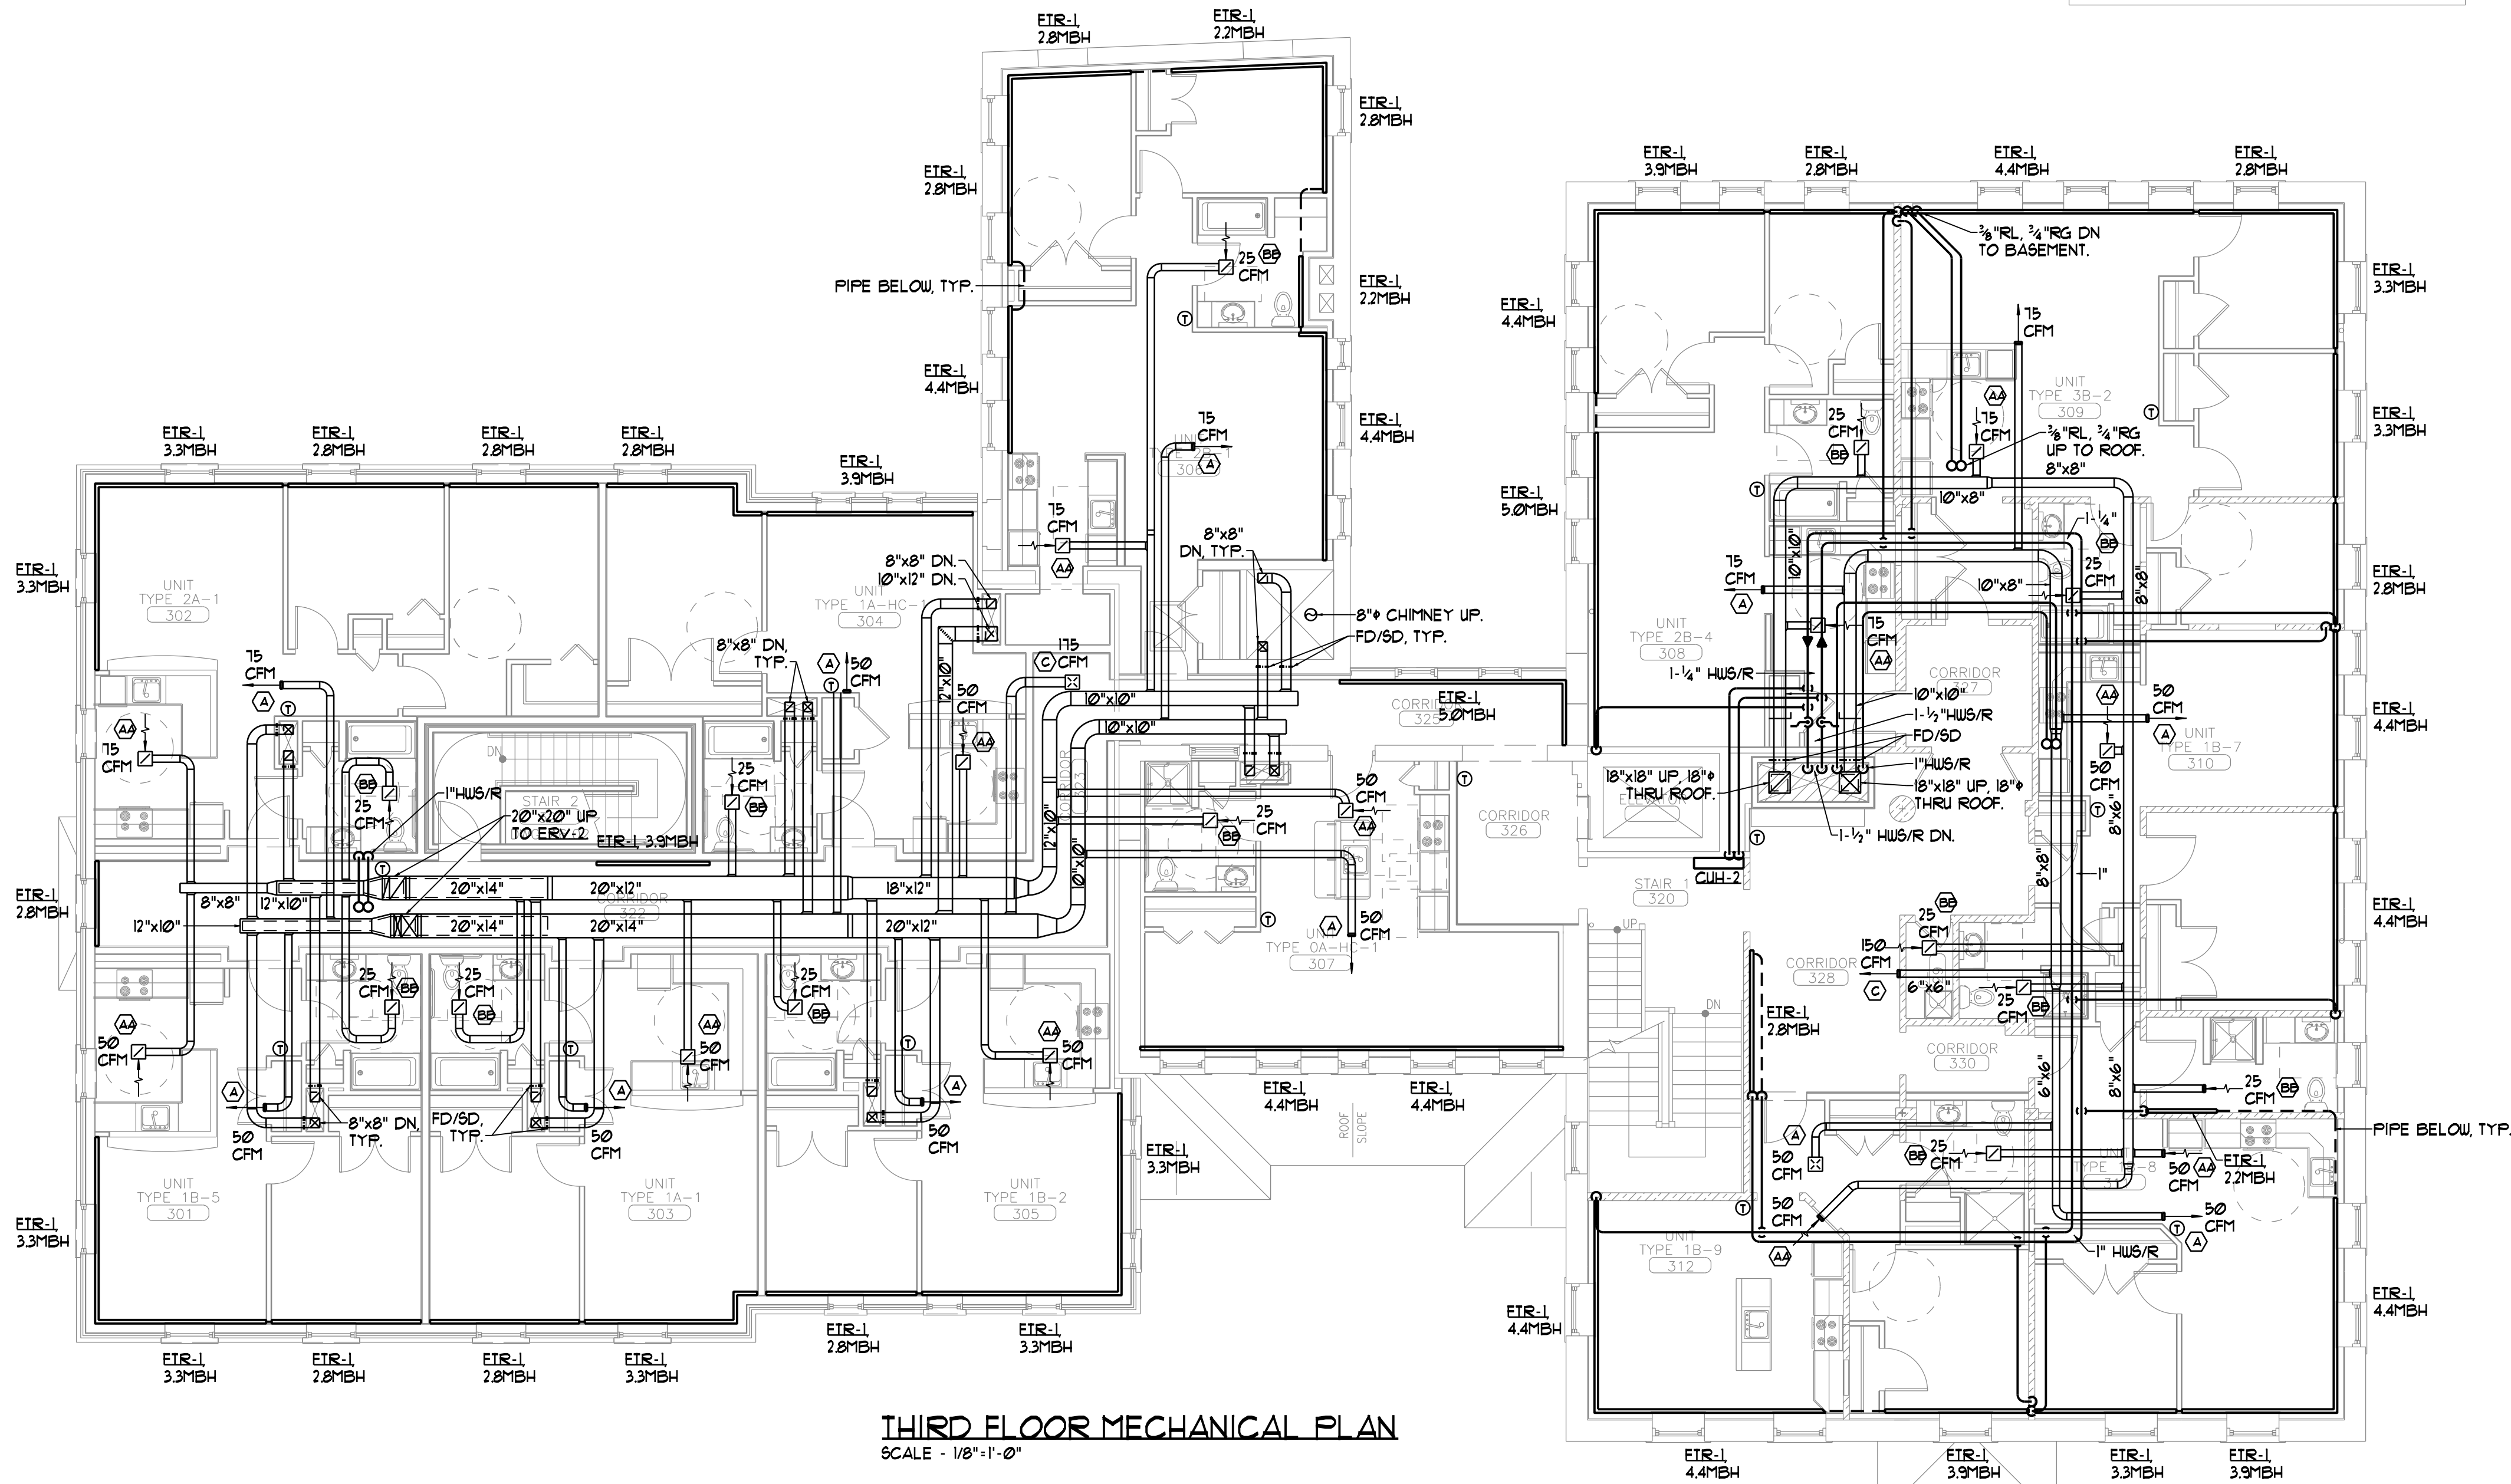

THIRD FLOOR MECHANICAL PLAN
SCALE - 1/8" = 1'-0"

- NOTES -
1. DUCTWORK SHALL BE 6"x4" UNLESS NOTED OTHERWISE.
 2. HUS/R PIPING SHALL BE 1/2" UNLESS NOTED OTHERWISE.




CWS Architects

Architecture
Space Planning
Value Design

434 Cumberland Avenue
Portland, ME 04101
Phone: (207) 774-4441
Fax: (207) 774-4016

www.CWSarch.com

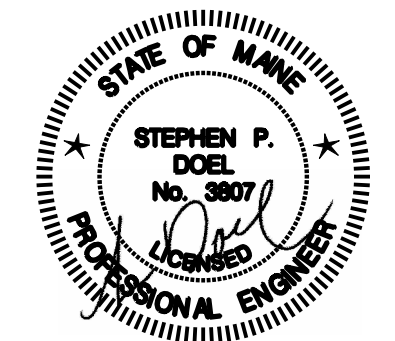

Owner:

Children's
Hospital Housing
Partners, LP
309 Cumberland Ave.
Suite 203
Portland, Maine 04101

CONSTRUCTION MANAGER:

WRIGHT-RYAN
CONSTRUCTION
10 DANFORTH STREET
PORTLAND, ME 04101
TEL: (207) 773-3625

ELM
TERRACE

68 HIGH STREET
PORTLAND, MAINE

Project No: 09428

Drawing Title:

THIRD FLOOR
MECHANICAL
PLAN

Scale: 1/8" = 1'-0"

Date: September 8, 2011

Revisions:

- 1.
- 2.
- 3.
- 4.
- 5.
- 6.
- 7.
- 8.
- 9.
- 10.

Drawing Number:

M1.3

