


UNLESS NOTED OTHERWISE ON THE DRAWINGS, ALL MECHANICAL AND PLUMBING SYSTEMS INCLUDING BUT NOT LIMITED TO BOILERS, BREECING, PUMPS, PIPING, DUCTWORK, FANS, INSULATION, CONTROLS, PLUMBING FIXTURES, WATER HEATERS, SPRINKLER VALVES AND HANGERS SHALL BE REMOVED IN THEIR ENTIRETY. ASBESTOS ABATEMENT WHERE APPLICABLE, SHALL BE BY OTHERS.


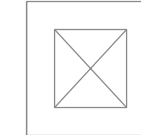


WS Architects

Architecture
Space Planning
Value Design

434 Cumberland Avenue
Portland, ME 04101
Phone: (207) 774-4441
Fax: (207) 774-4016

www.CWSarch.com

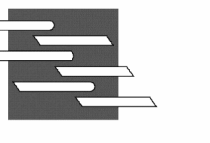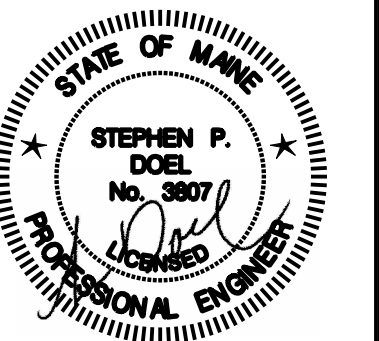

BENNETT
ENGINEERING
MECHANICAL • ELECTRICAL
(207) 865-9475

Owner:

**Children's
Hospital Housing
Partners, LP**

09 Cumberland Ave.
Suite 203
Portland, Maine 04101

CONSTRUCTION MANAGER:

**WRIGHT-RYAN
CONSTRUCTION**
10 DANFORTH STREET
PORTLAND, ME 04101
TEL: (207) 773-3625

ELM TERRACE

HIGH STREET
PORTLAND, MAINE

Project No: 09428

Drawing Title:

THIRD FLOOR SANITARY PLUMBING PLAN

Scale: 1/8" = 1'-0"


Date: September 8, 2011

visions:



Drawing Number:

M3.3

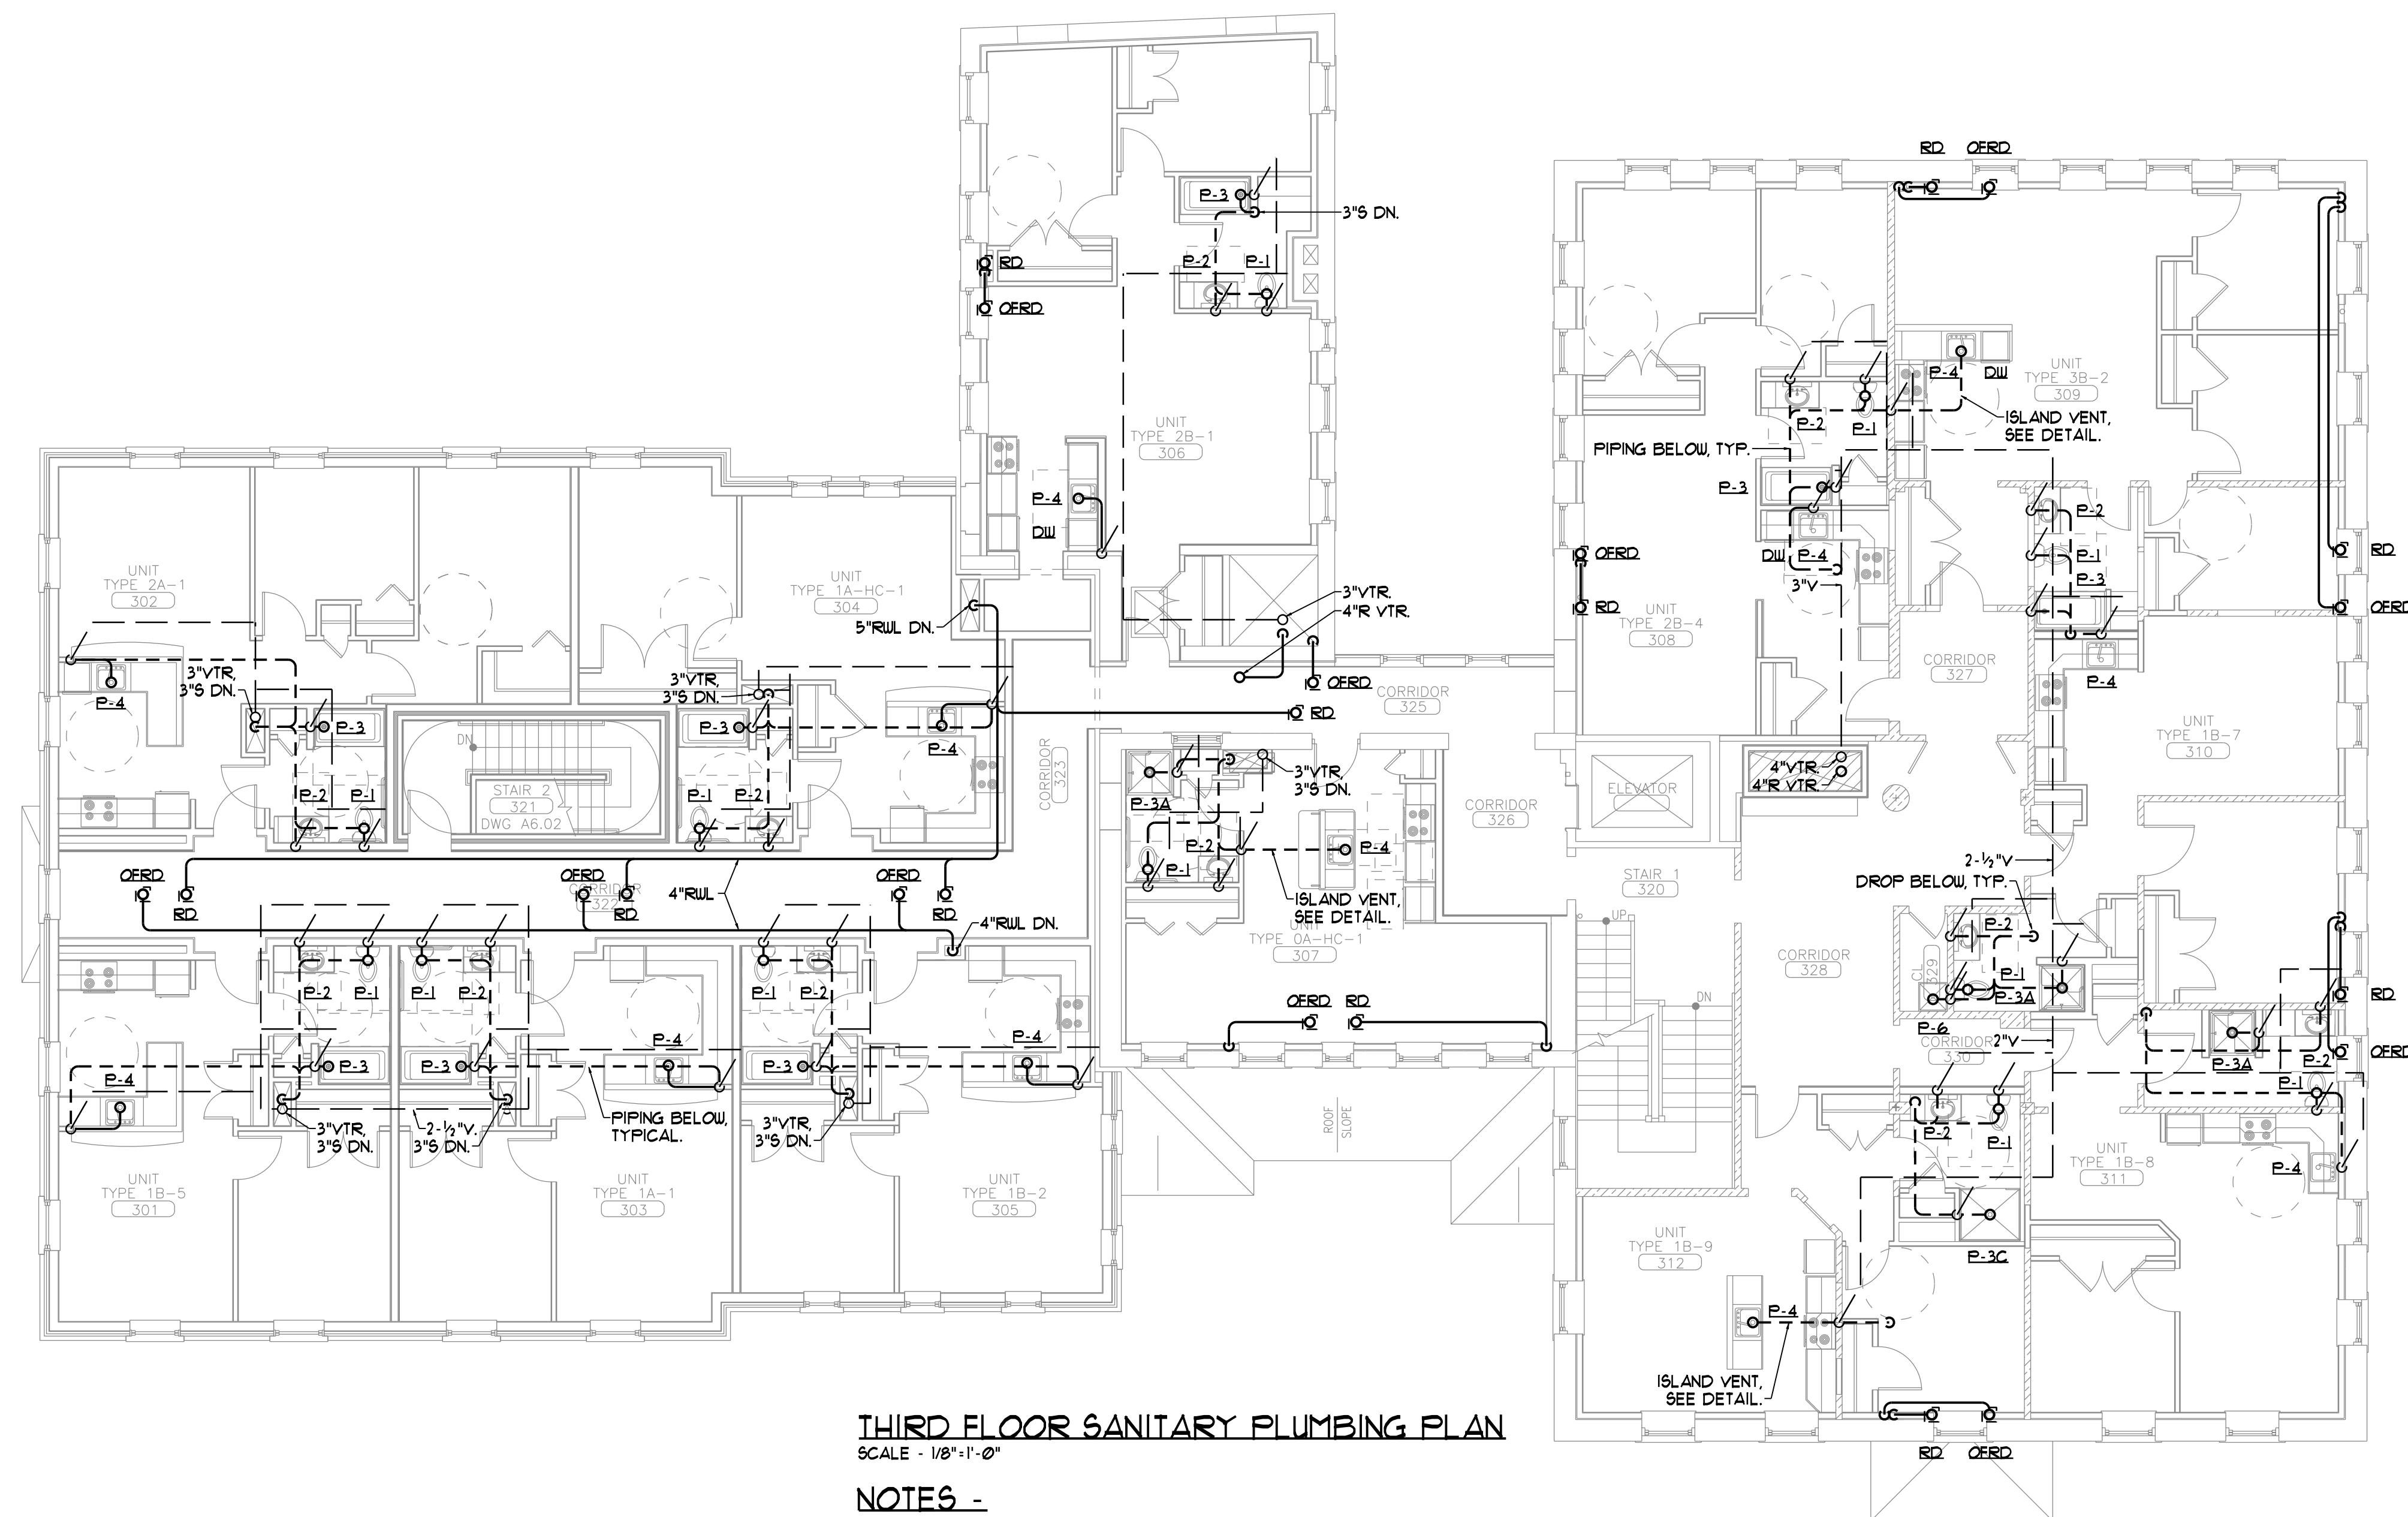

THIRD FLOOR SANITARY PLUMBING PLAN
SCALE - 1/8"=1'-0"

NOTES -

1. UNLESS NOTED OTHERWISE, VENT PIPING SHALL BE 2", SAN PIPING 3" AND RUL 3".
2. SEE PLUMBING FIXTURE CONNECTION SCHEDULE FOR INDIVIDUAL FIXTURE PIPE SIZES.

