

**GAWRON
TURGEON
ARCHITECTS**

29 Black Point Road
Scarborough, ME 04074
www.gawronturgeon.com
Tel. 207. 883. 6307
Fax. 207. 883. 0361

CUTTER HOUSE RENOVATION
PORTLAND MAINE



REVISIONS		
#	DATE	DESCRIPTION

DATE:	2/20/07
PROJECT #	060905
DRAWN BY:	SPD
CHECKED BY:	WSBR
DRAWING SCALE	NONE



SHEET TITLE
PANEL SCHEDULES

E-202




© COPYRIGHT 1985-2003
REPRODUCTION OR USE OF
THIS DOCUMENT WITHOUT
WRITTEN PERMISSION OF
GAWRON ARCHITECTS IS PROHIBITED

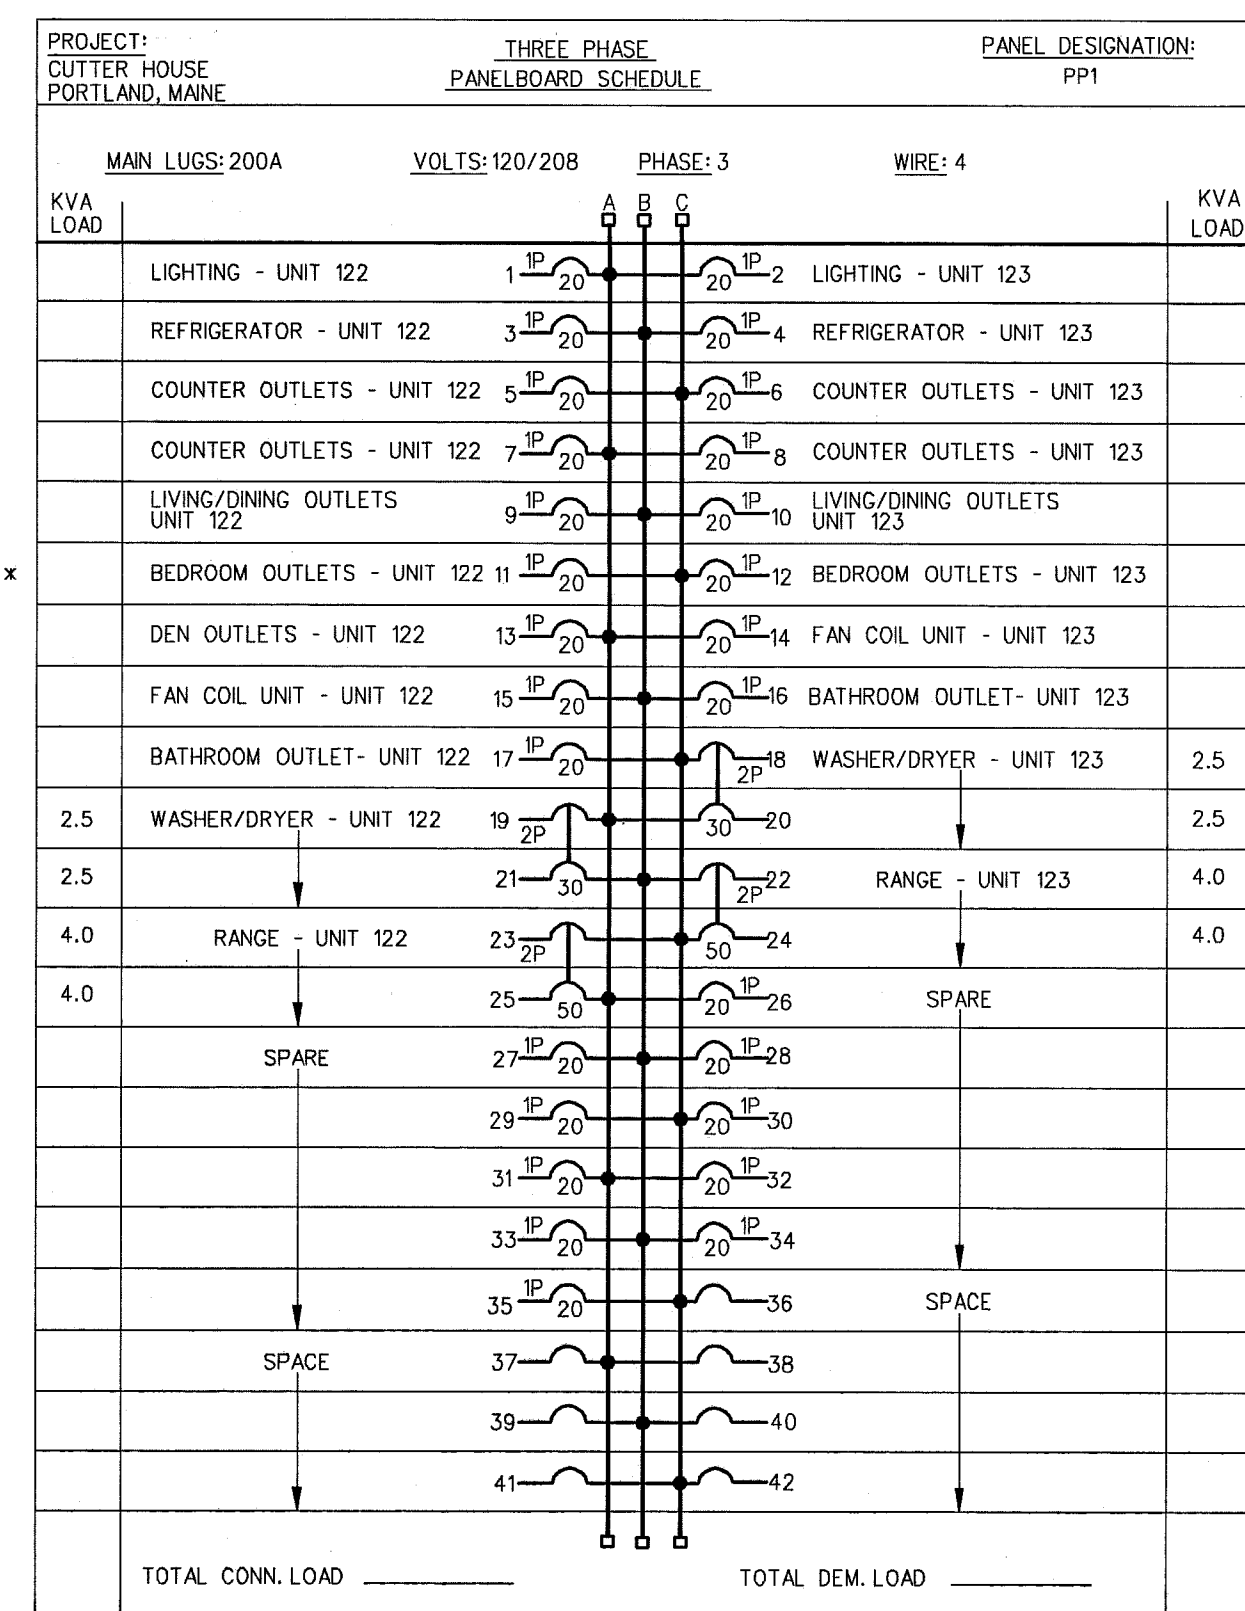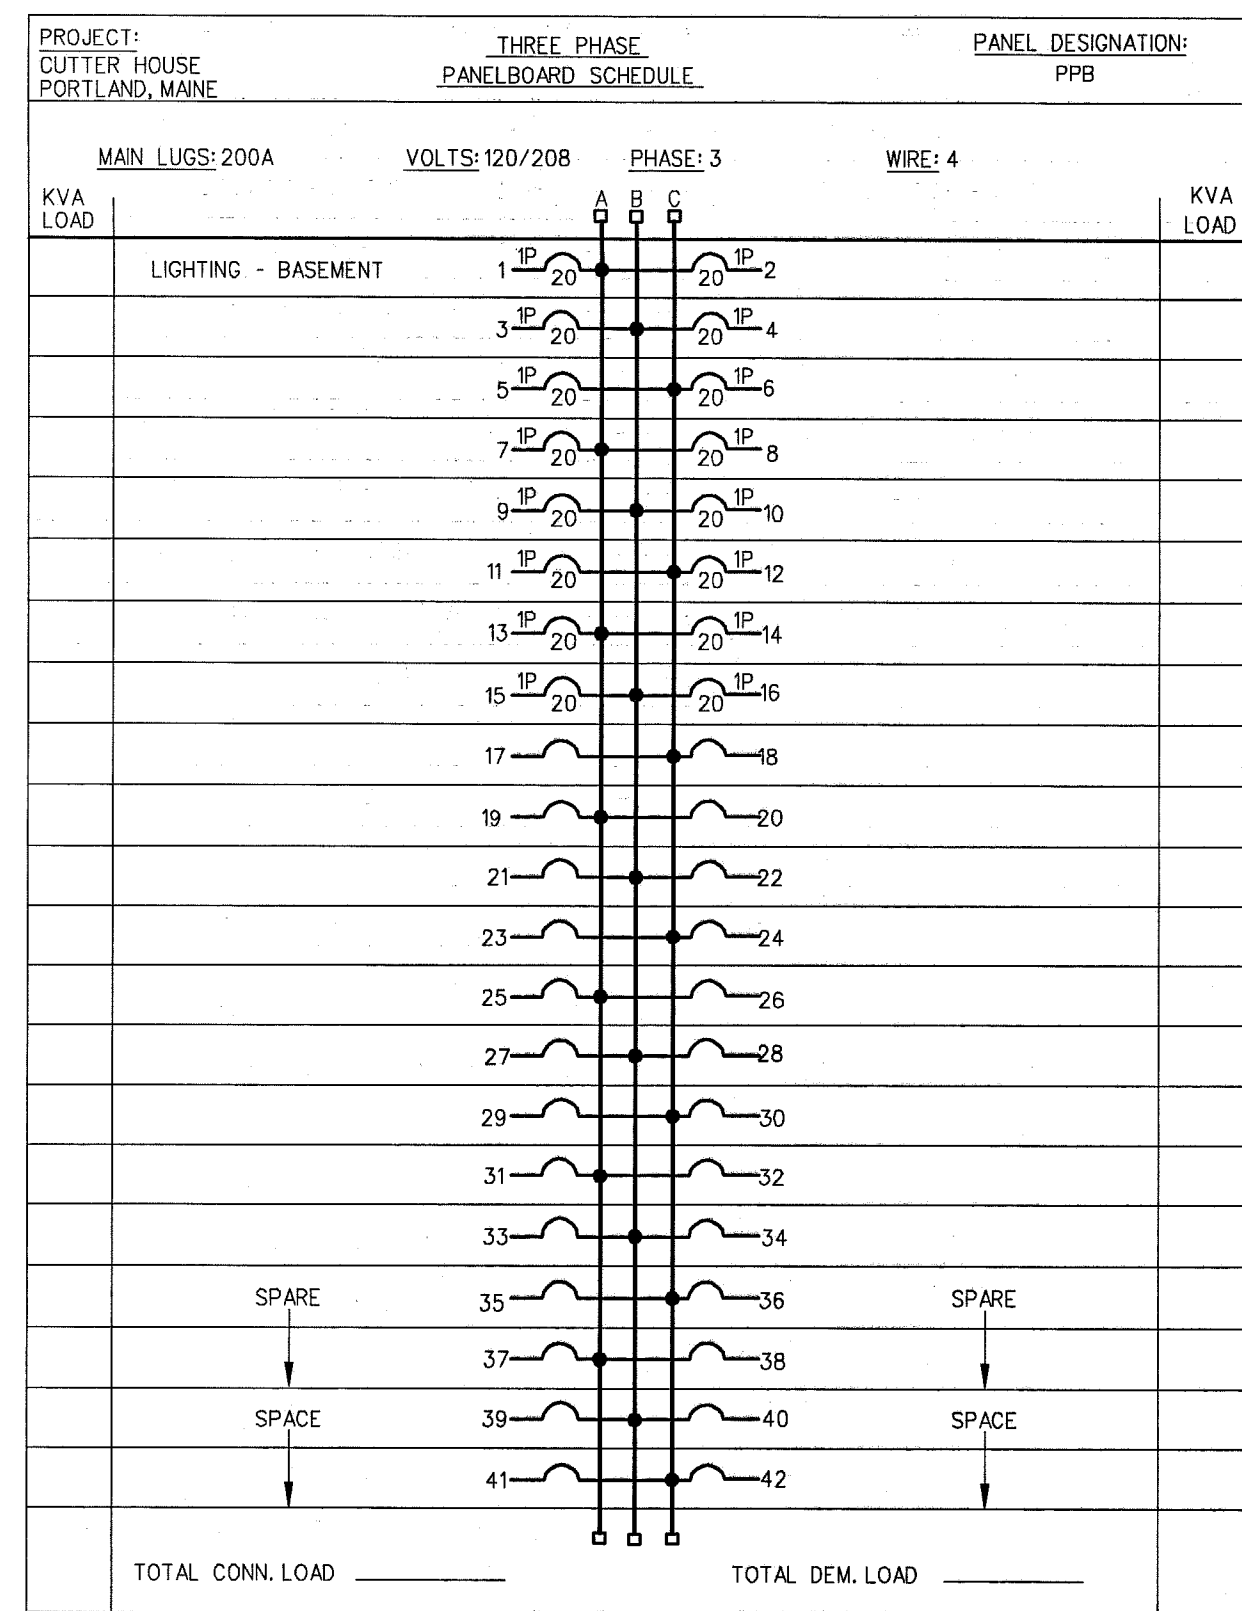

* PROVIDE ARC FAULT TYPE CIRCUIT BREAKER

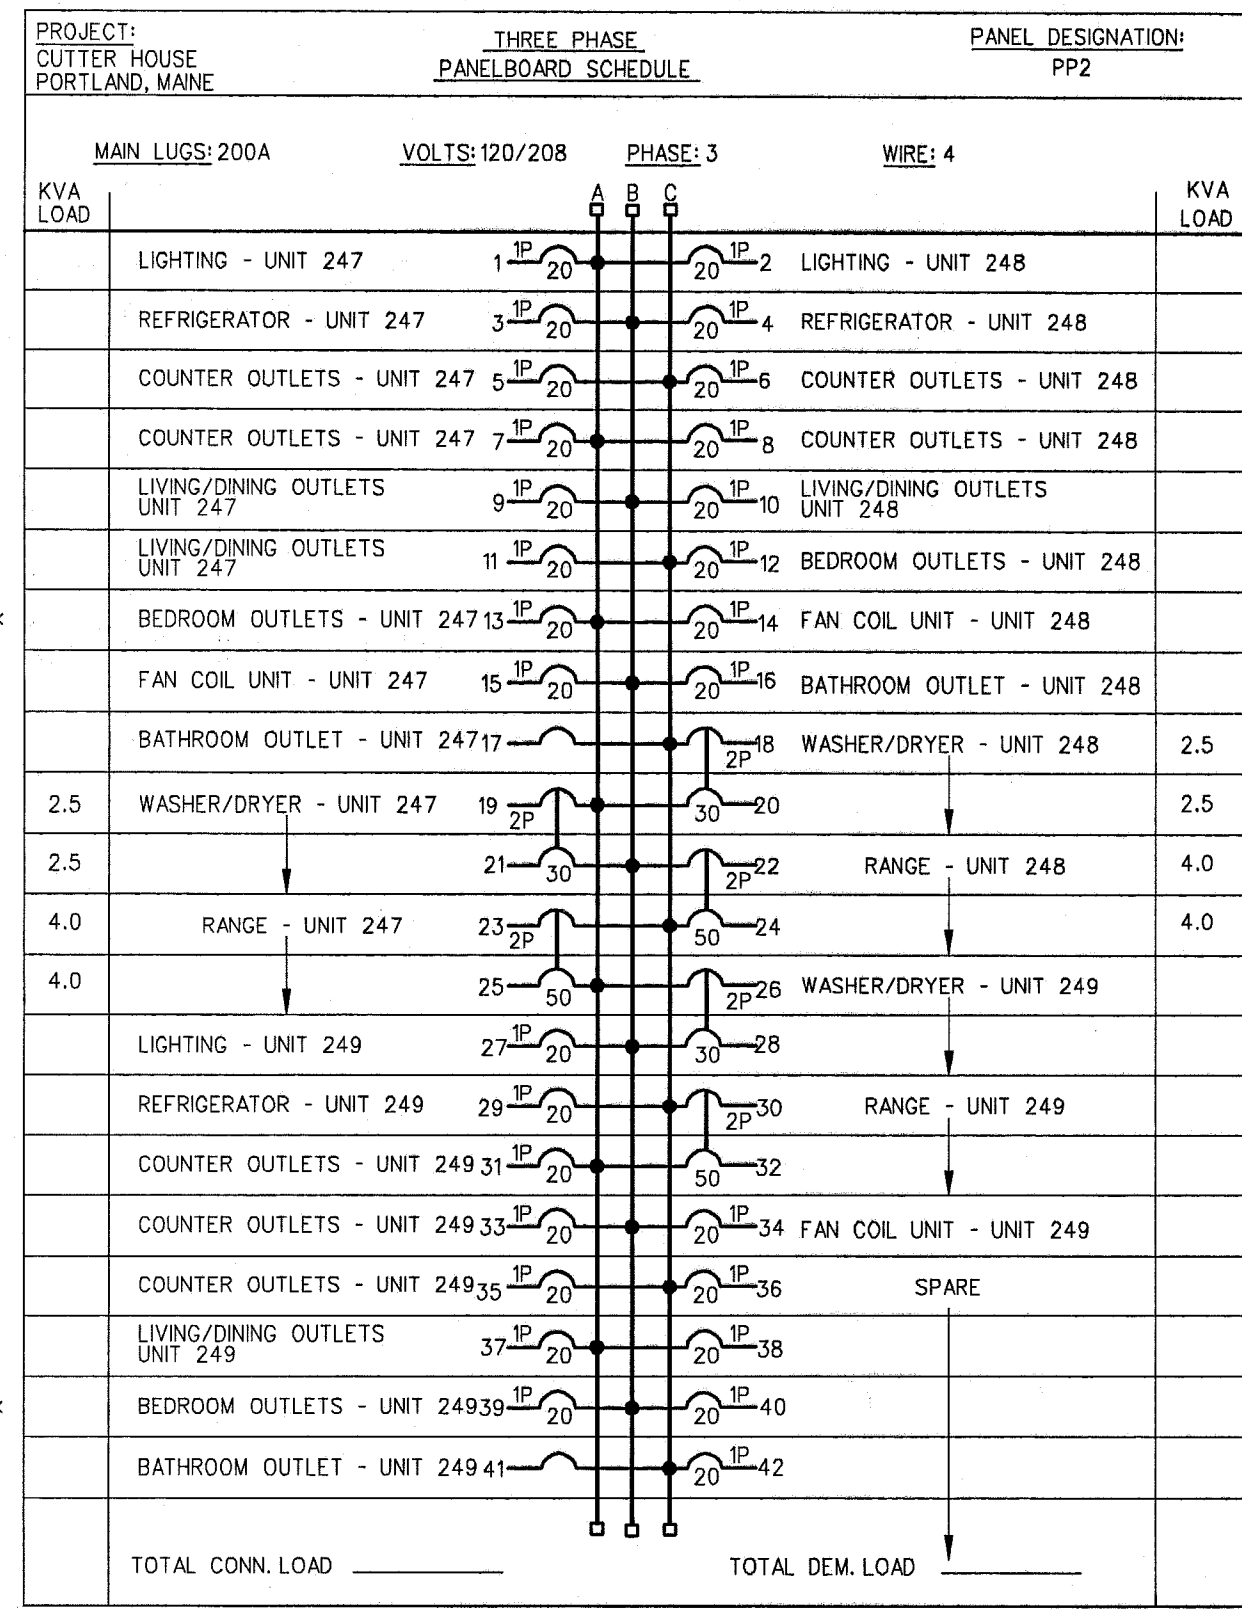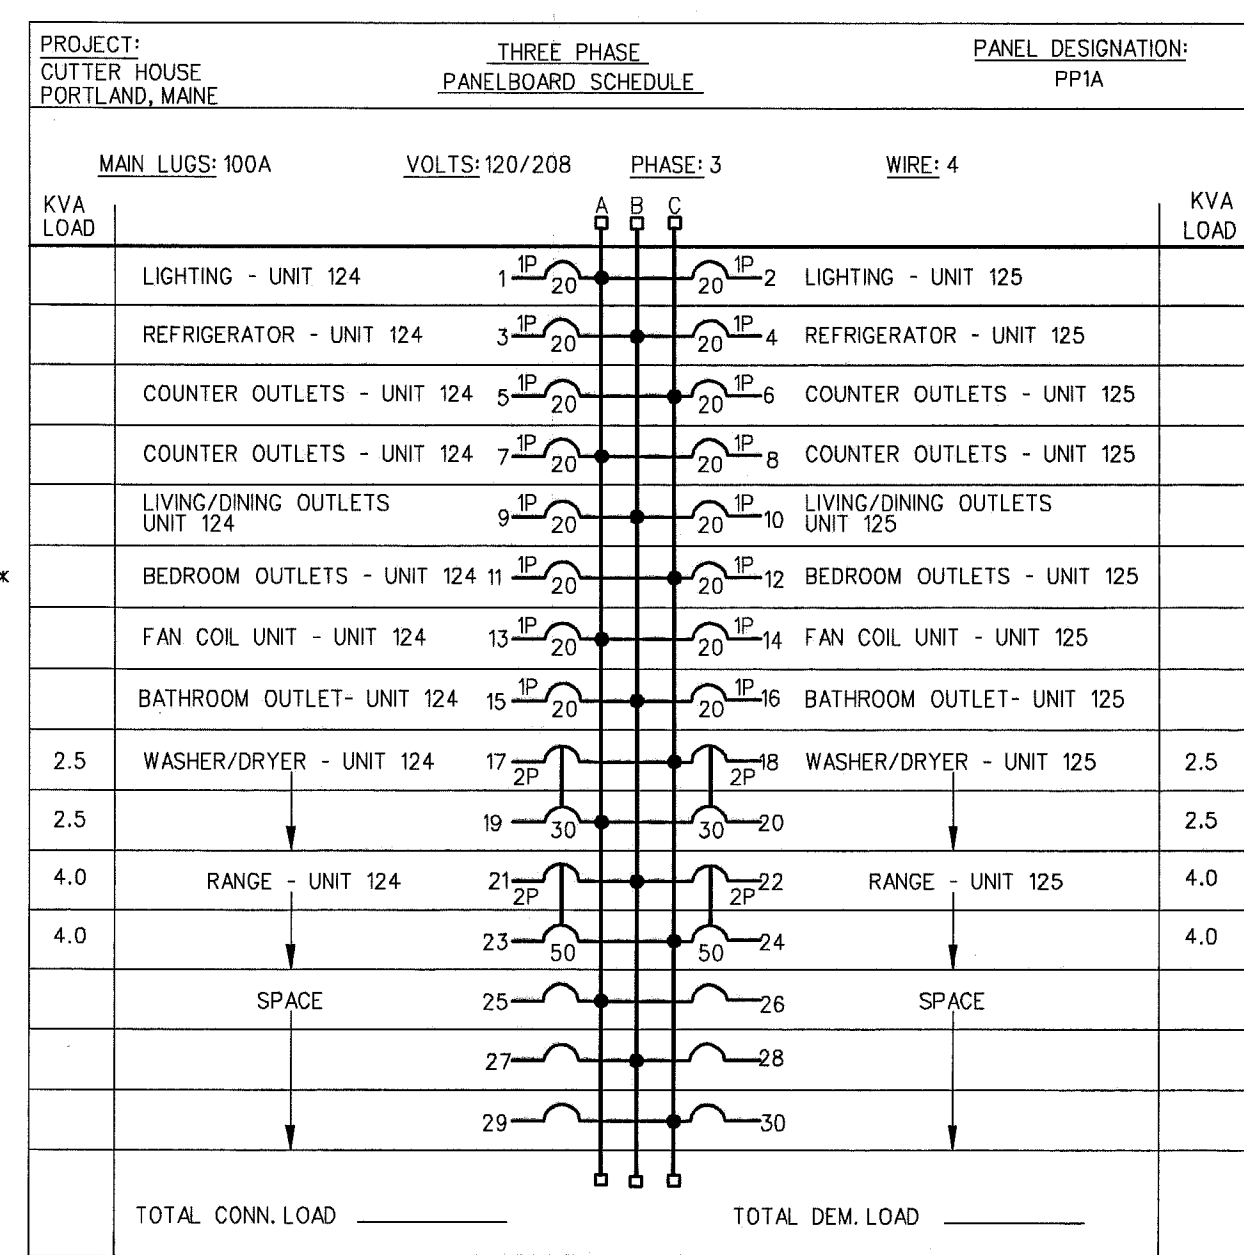

* PROVIDE ARC FAULT TYPE CIRCUIT BREAKER

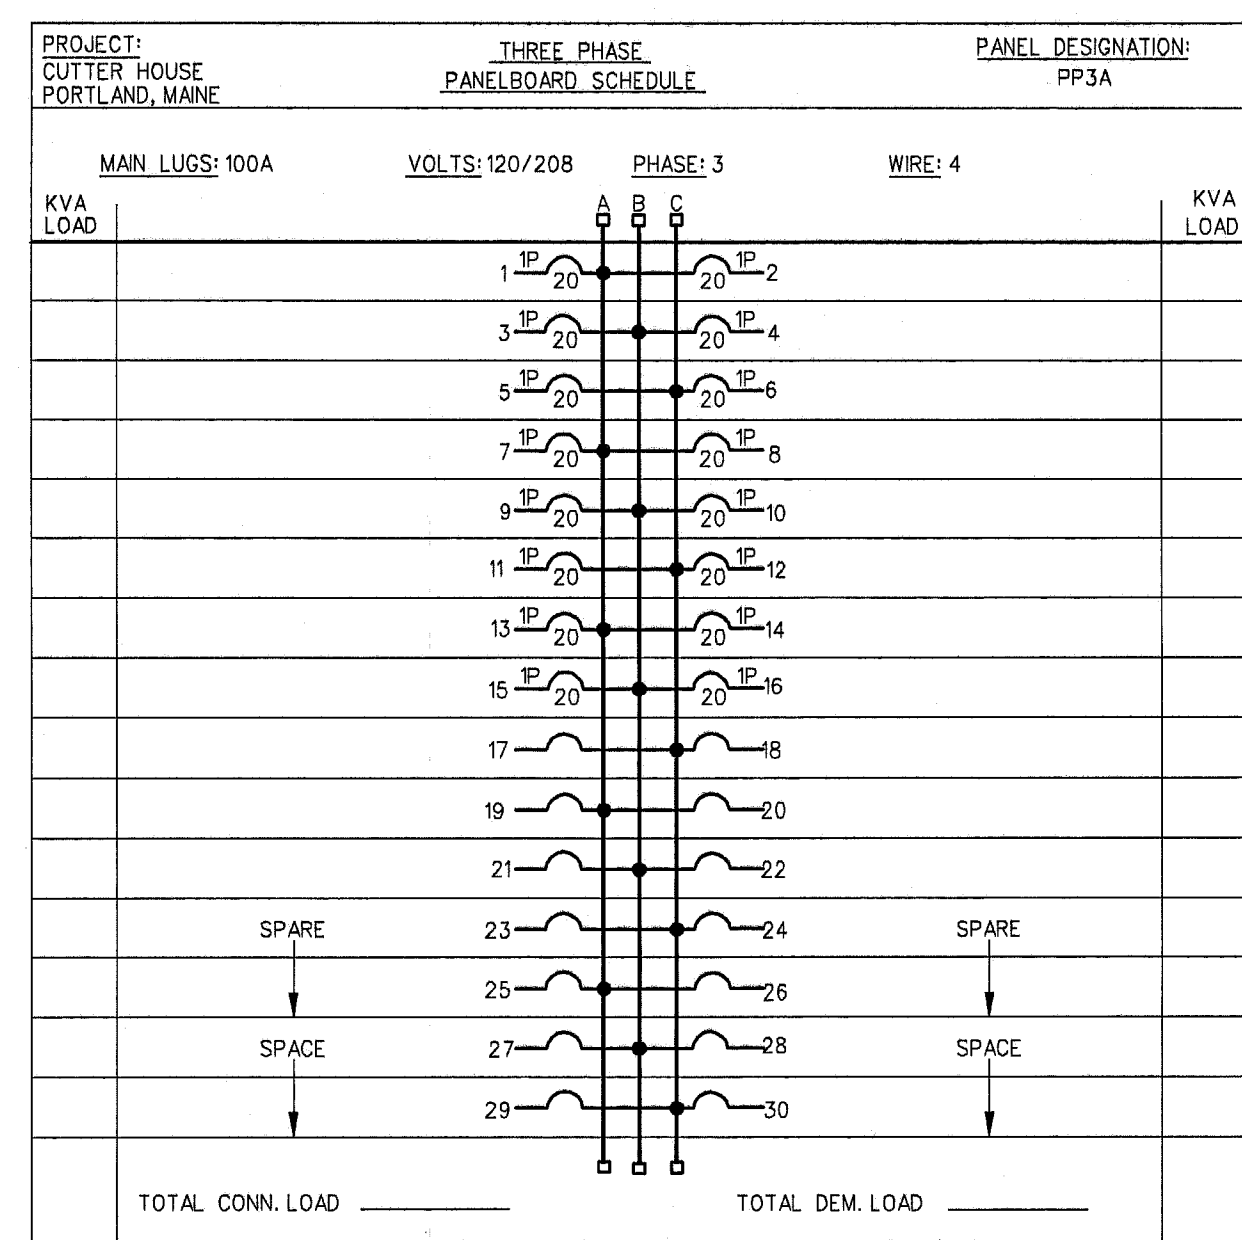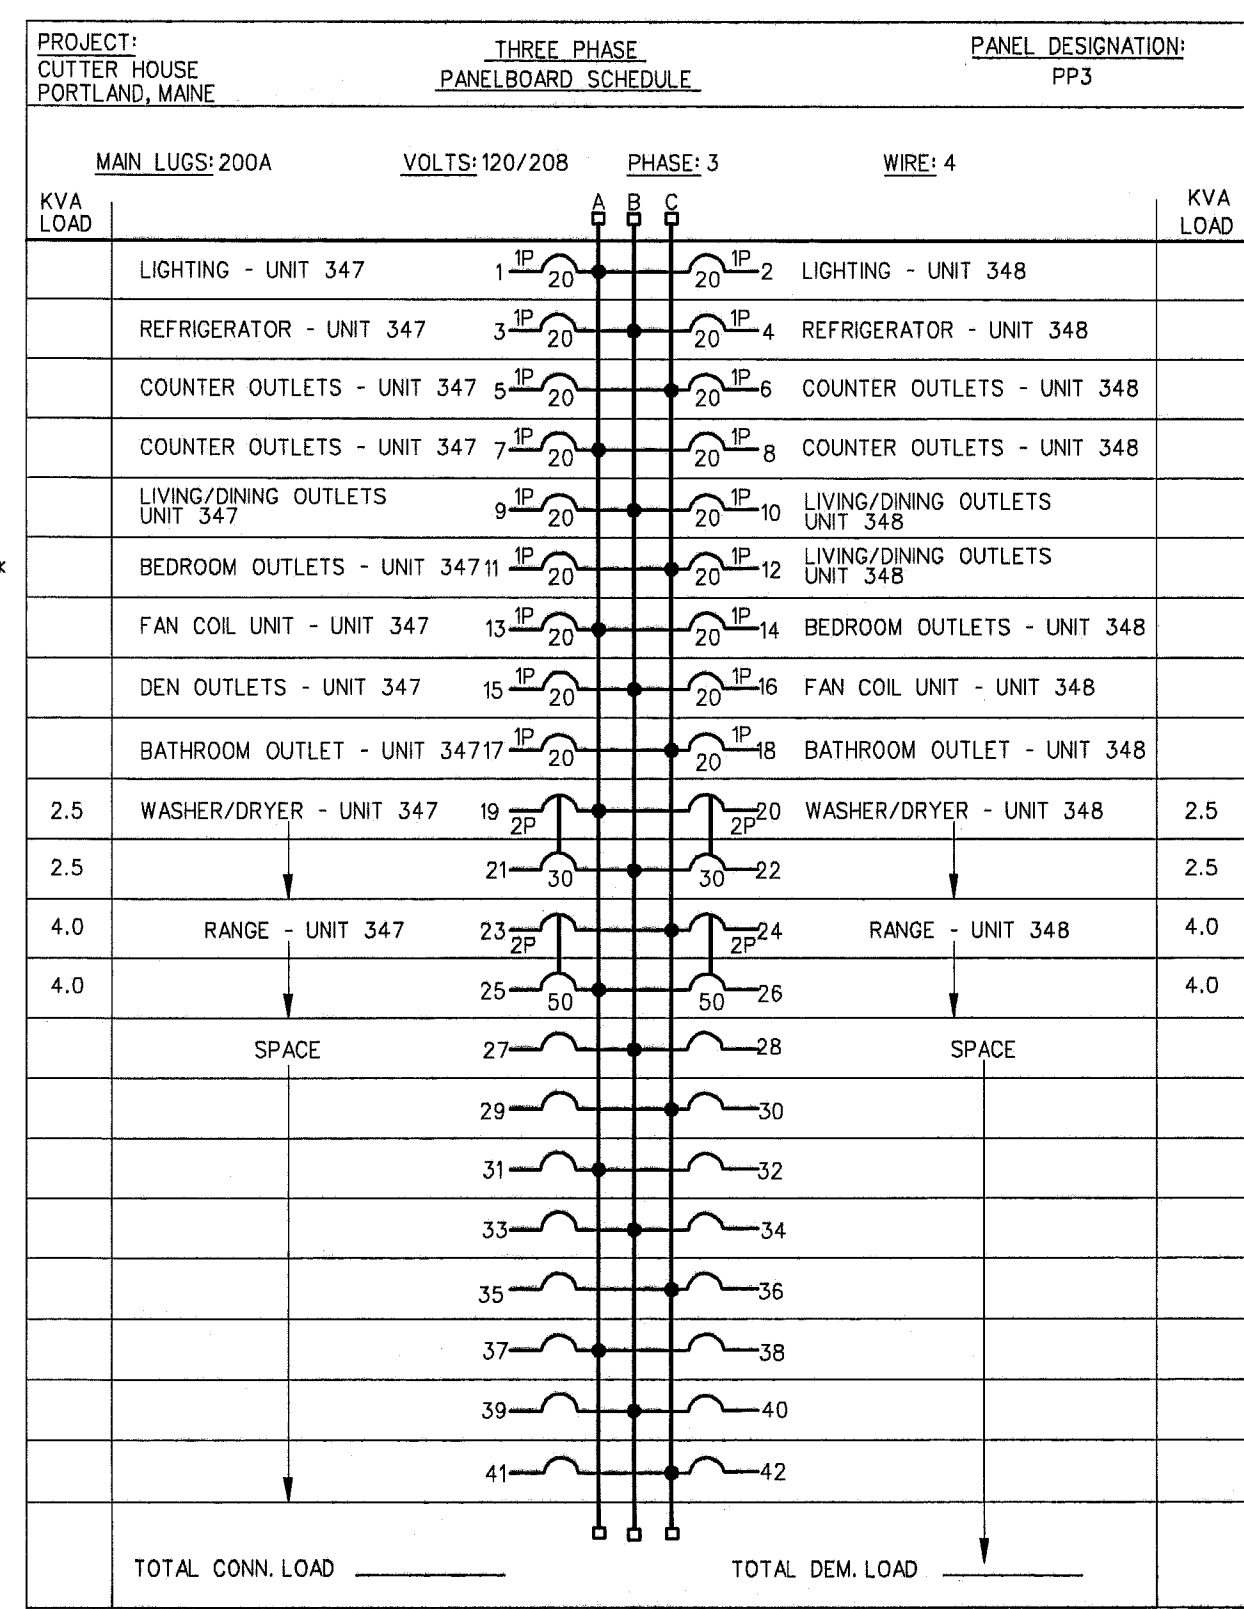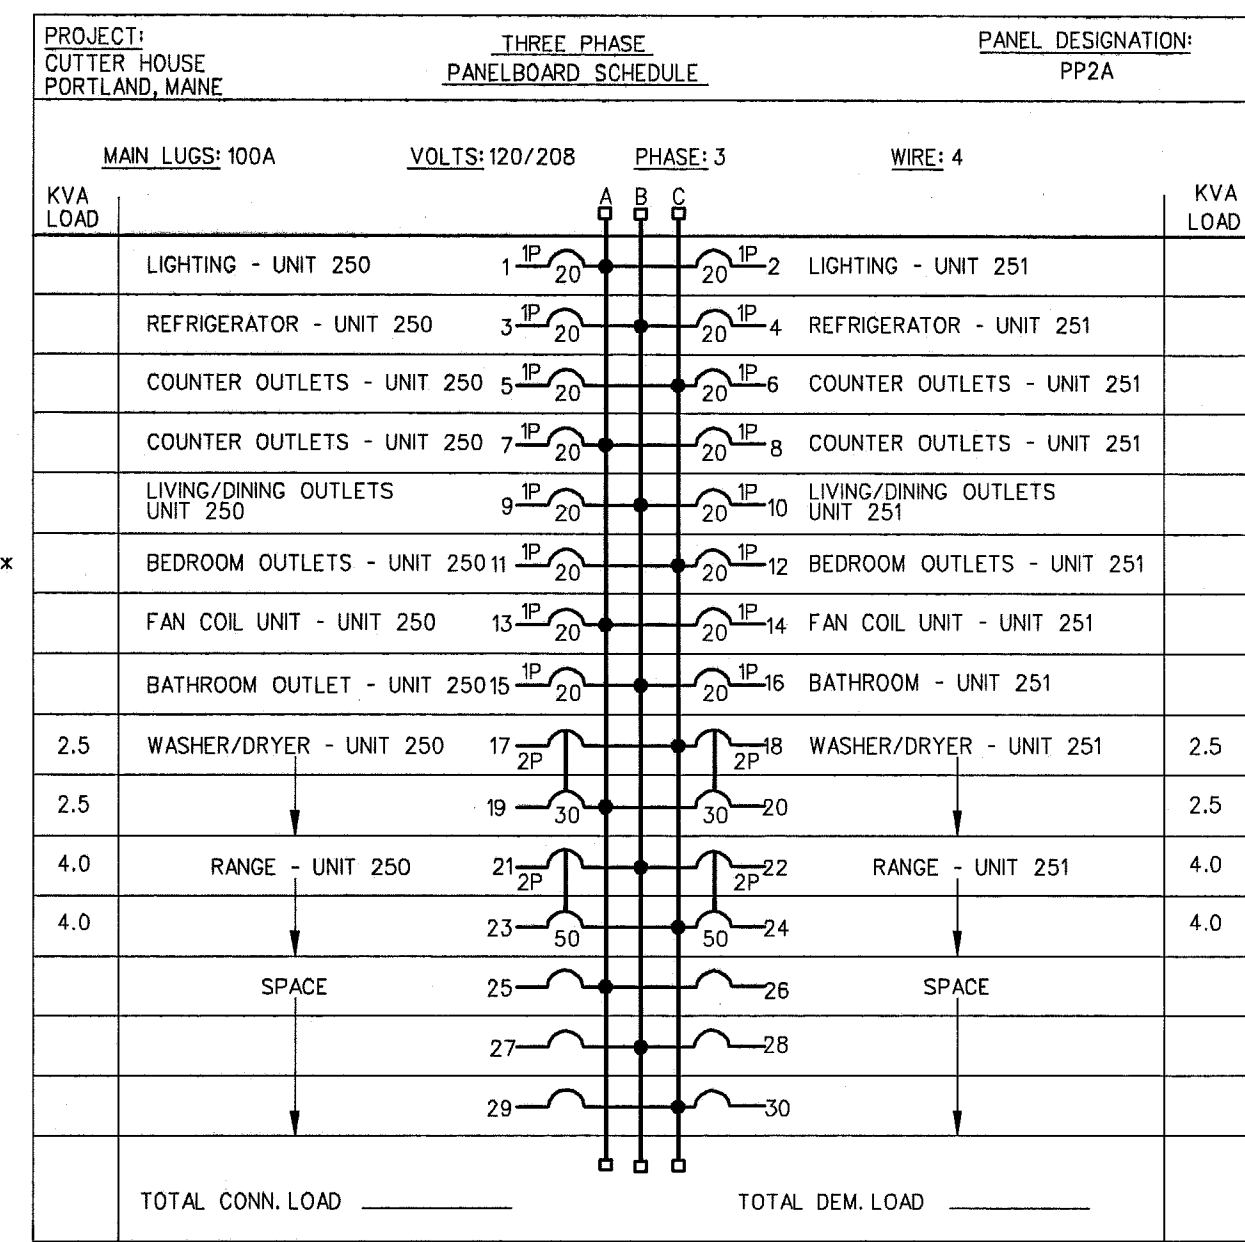

2/20/07 PERMIT SET