



PERMIT SET

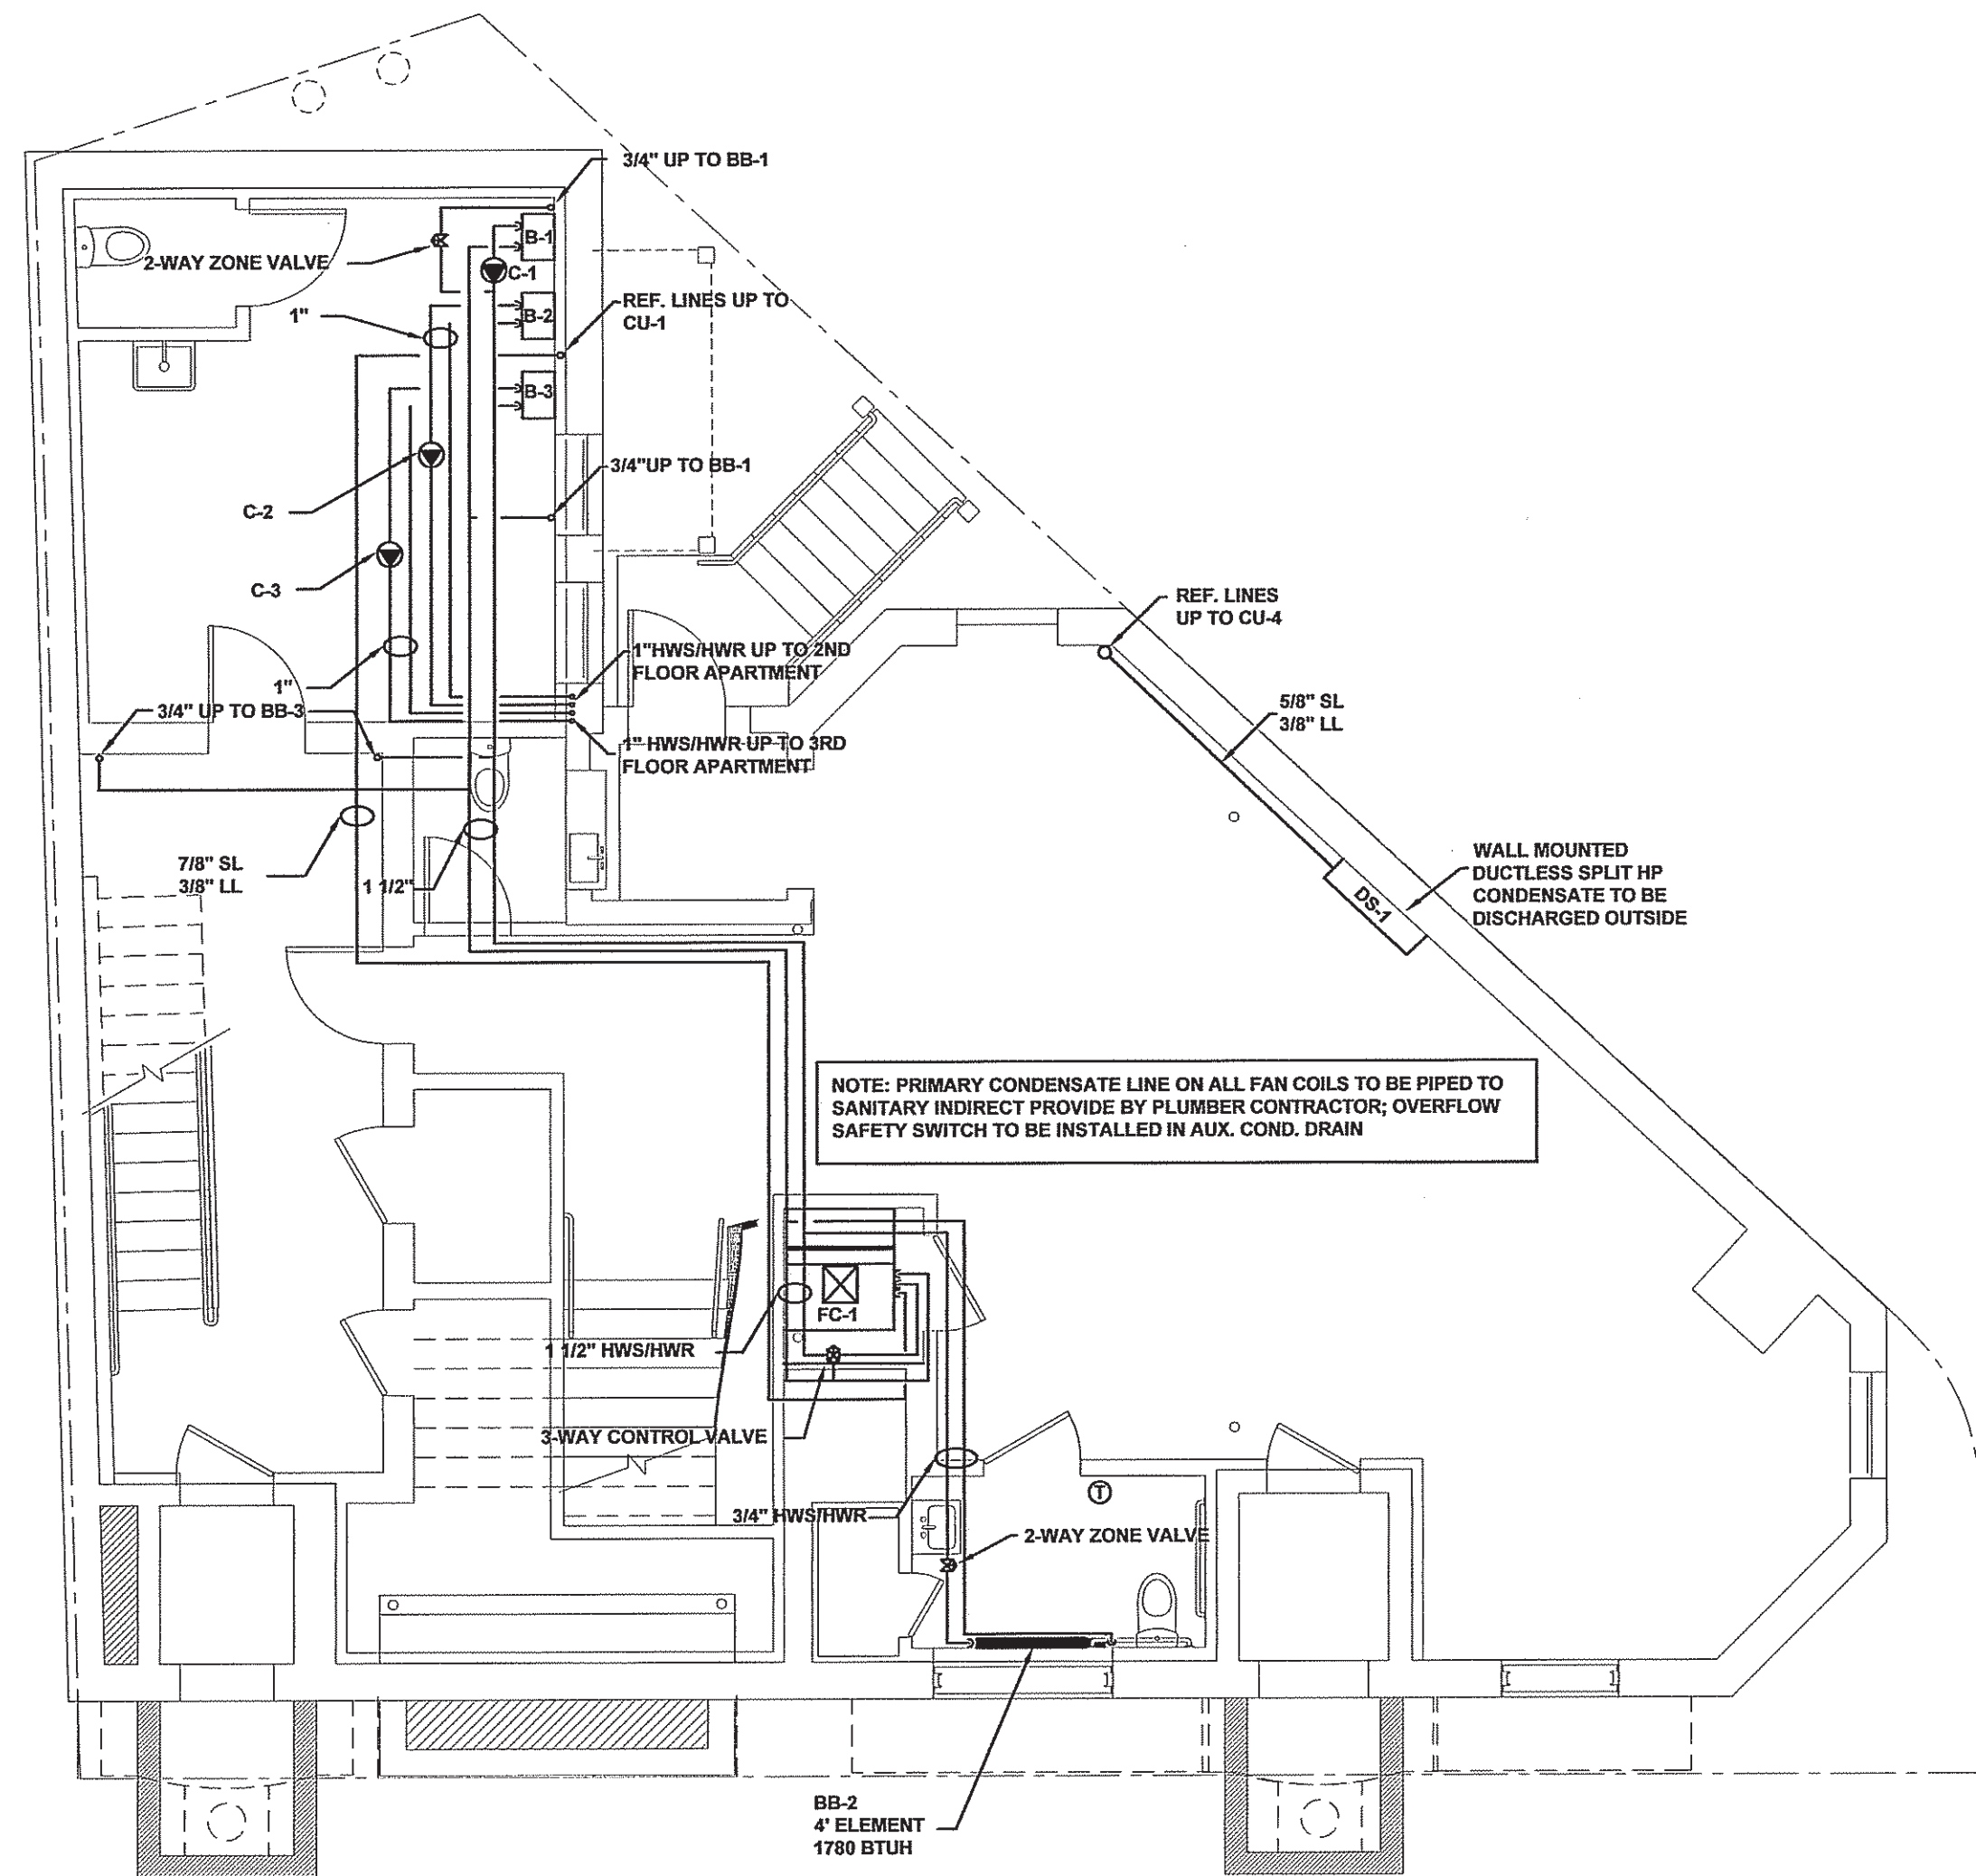

BASEMENT PIPING PLAN
SCALE: 3/16"=1'-0

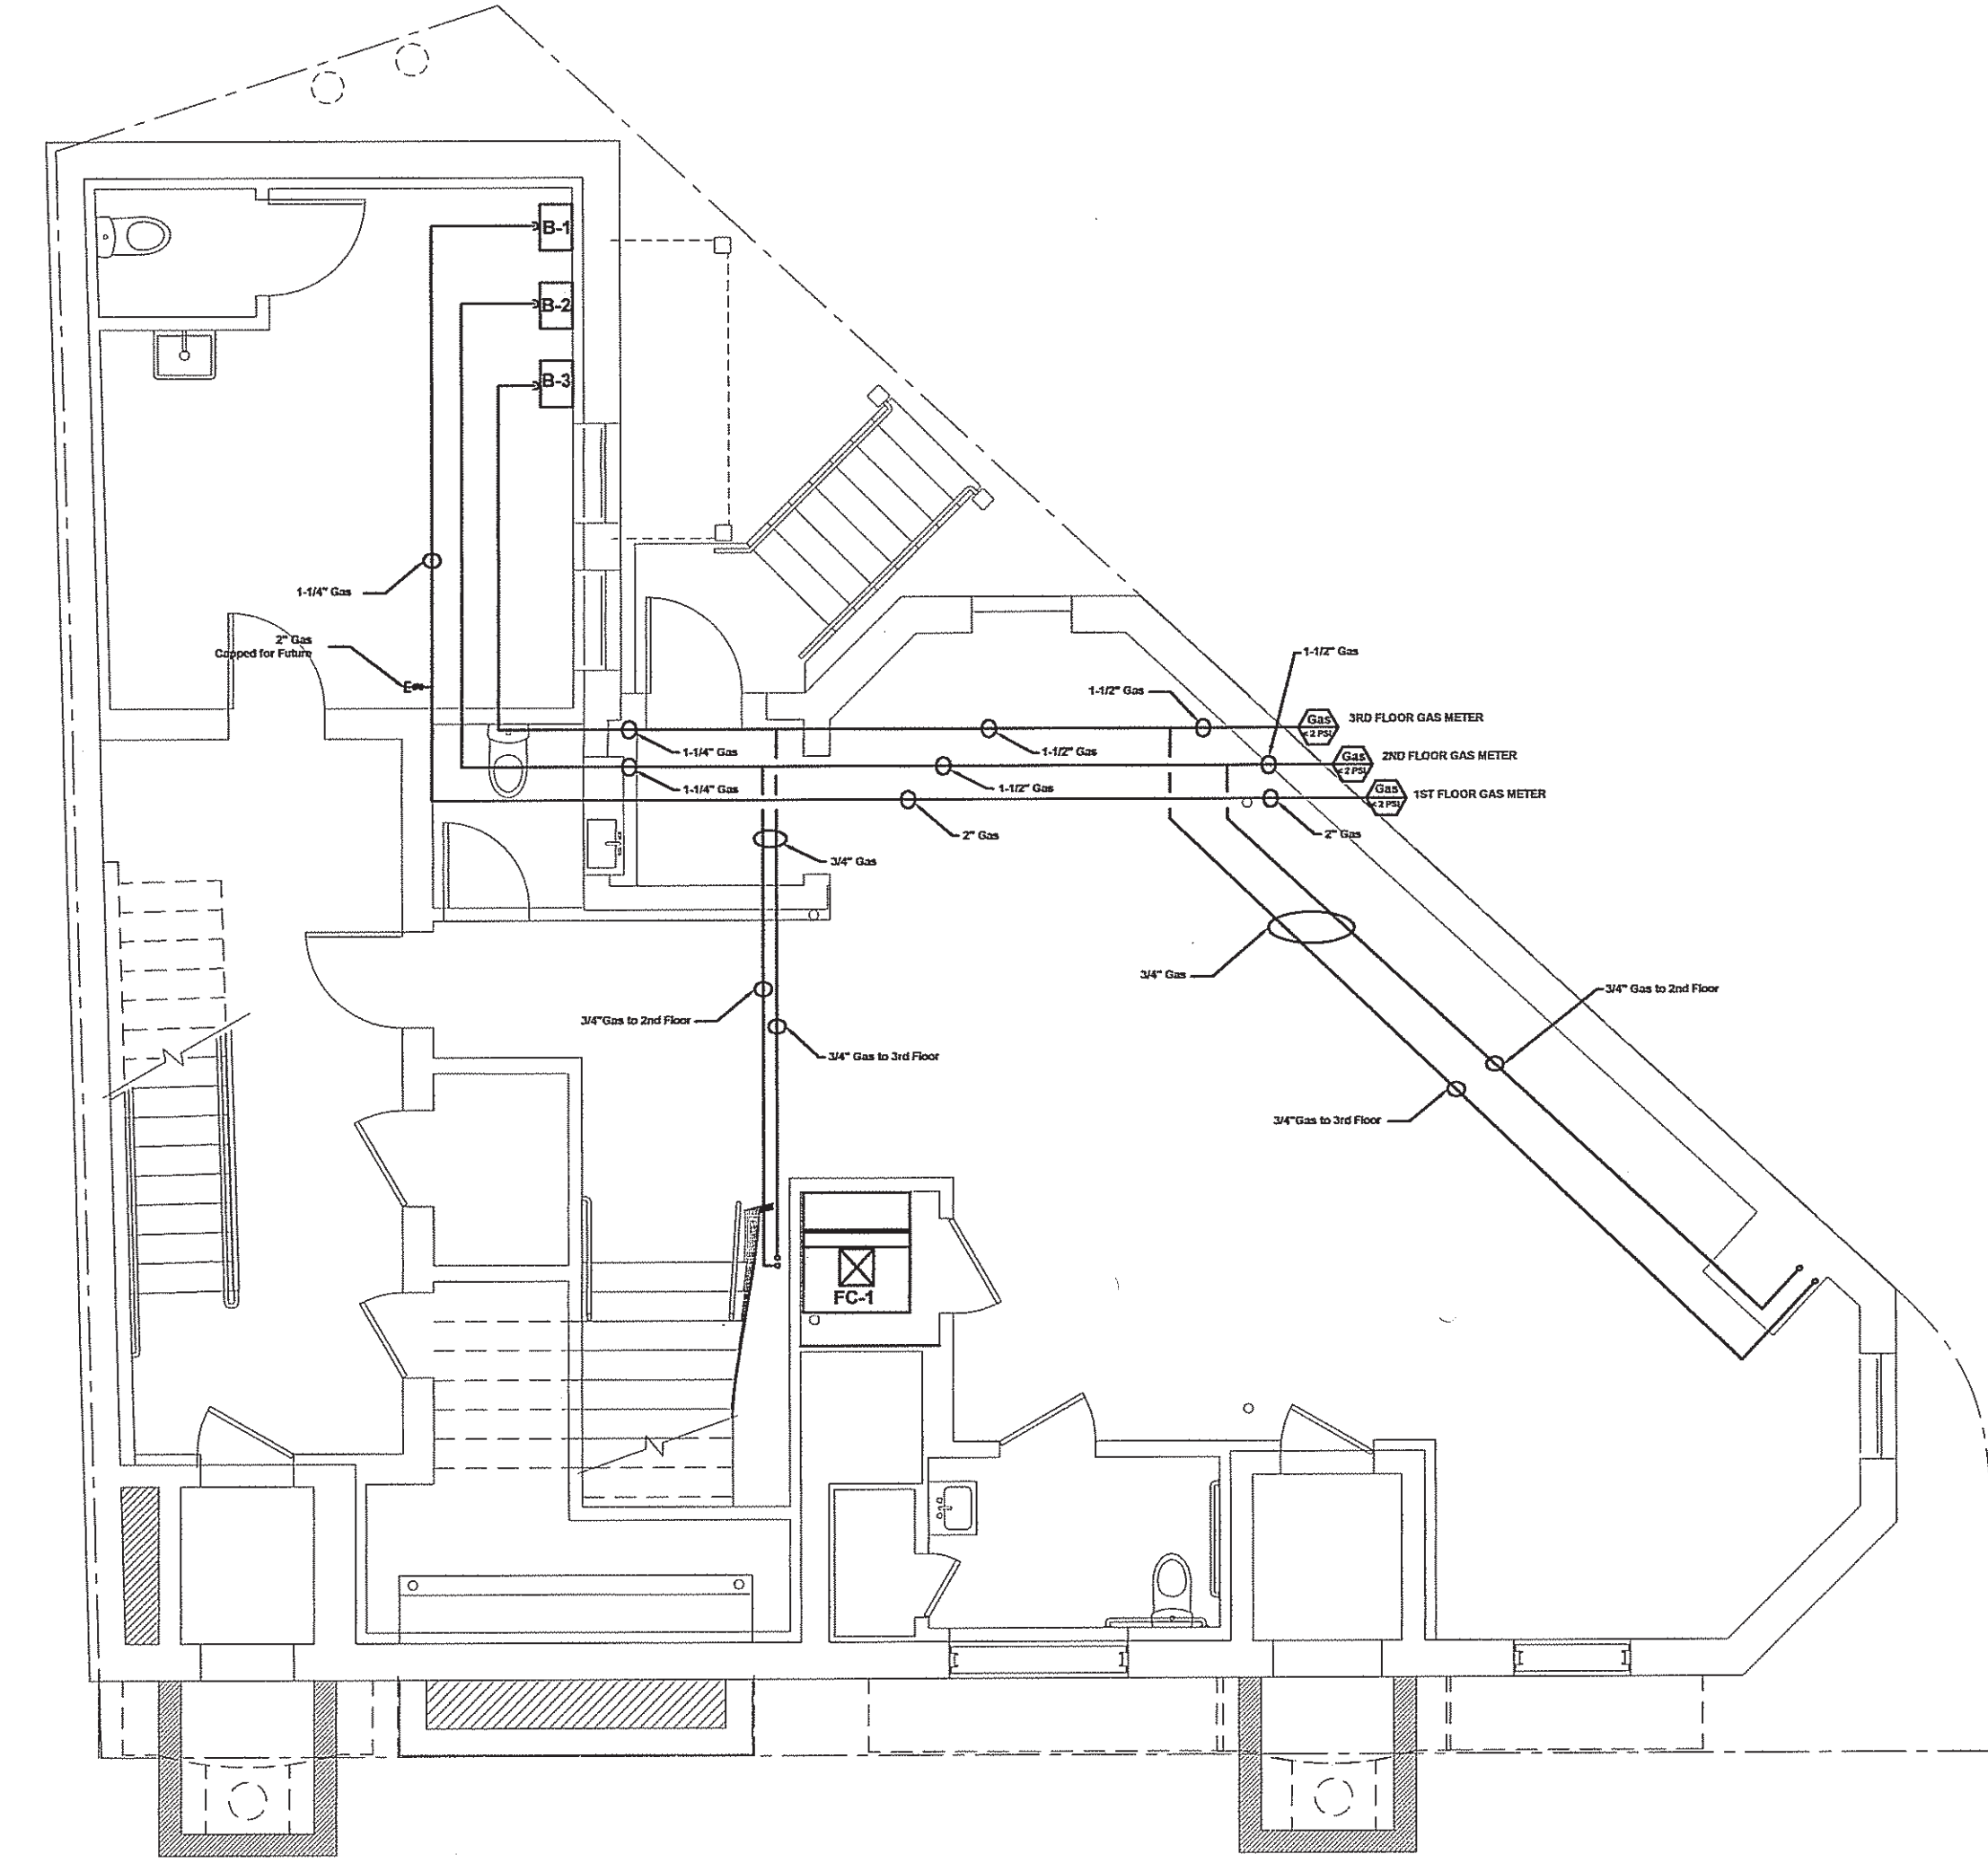

BASEMENT GAS PIPING PLAN
SCALE: 3/16"=1'-0

660 CONGRESS STREET
PORTLAND, ME

BASEMENT PIPING PLAN

PROJECT NUMBER:	57708
ISSUED:	8.26.14
DRAWN BY:	JLR/MGR/ASG
CHECKED BY:	DWM
FILENAME:	.DWG

THESE DRAWINGS AND PLANS ARE THE PROPERTY OF WH DEMMONS INC. AND ARE AN INSTRUMENT OF SERVICE FOR THE OWNER'S USE FOR THIS PROJECT ON THIS SITE ONLY