


PERMIT SET

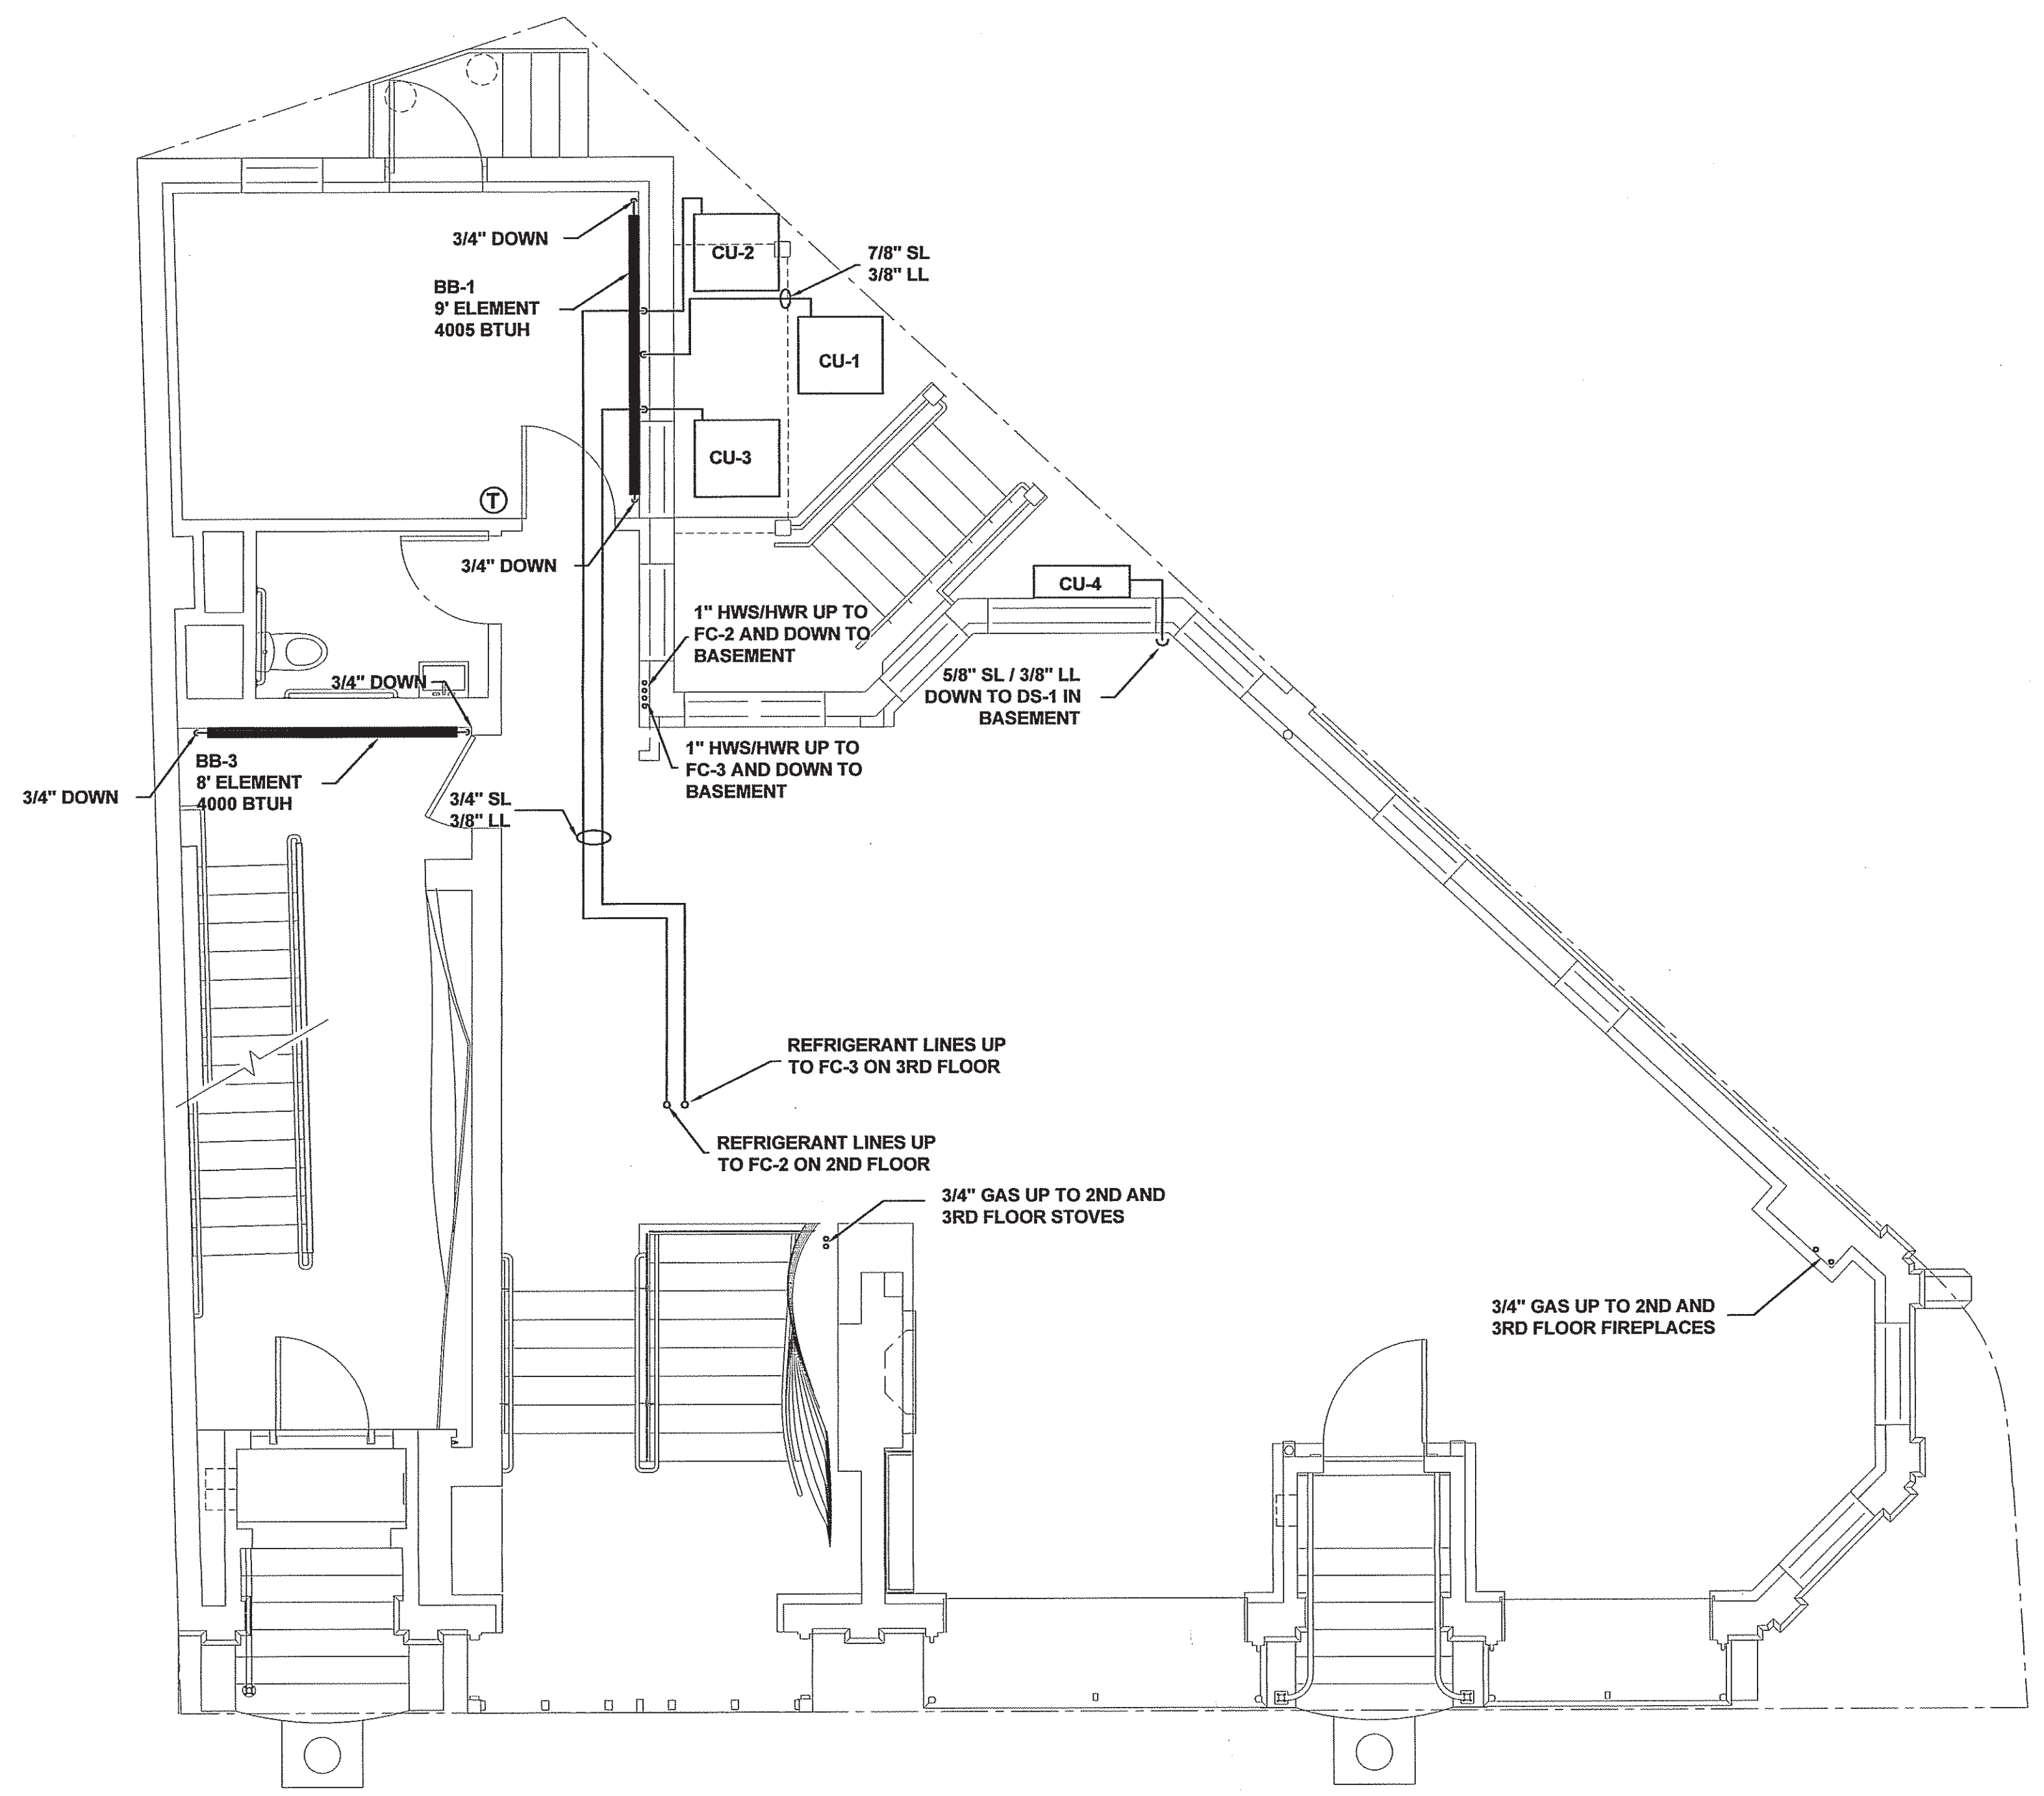

FIRST FLOOR PIPING PLAN
SCALE: 1/4"=1'-0

660 CONGRESS STREET
PORTLAND, ME

FIRST FLOOR PIPING PLAN

PROJECT NUMBER:	57708
ISSUED:	8.26.14
DRAWN BY:	JLR/MGR/ASG
CHECKED BY:	DWM
FILENAME:	.DWG

THESE DRAWINGS AND PLANS ARE THE PROPERTY OF WH DEMMONS INC.
AND ARE AN INSTRUMENT OF SERVICE FOR THE OWNER'S USE FOR THIS
PROJECT ON THIS SITE ONLY

M-6