


PERMIT SET

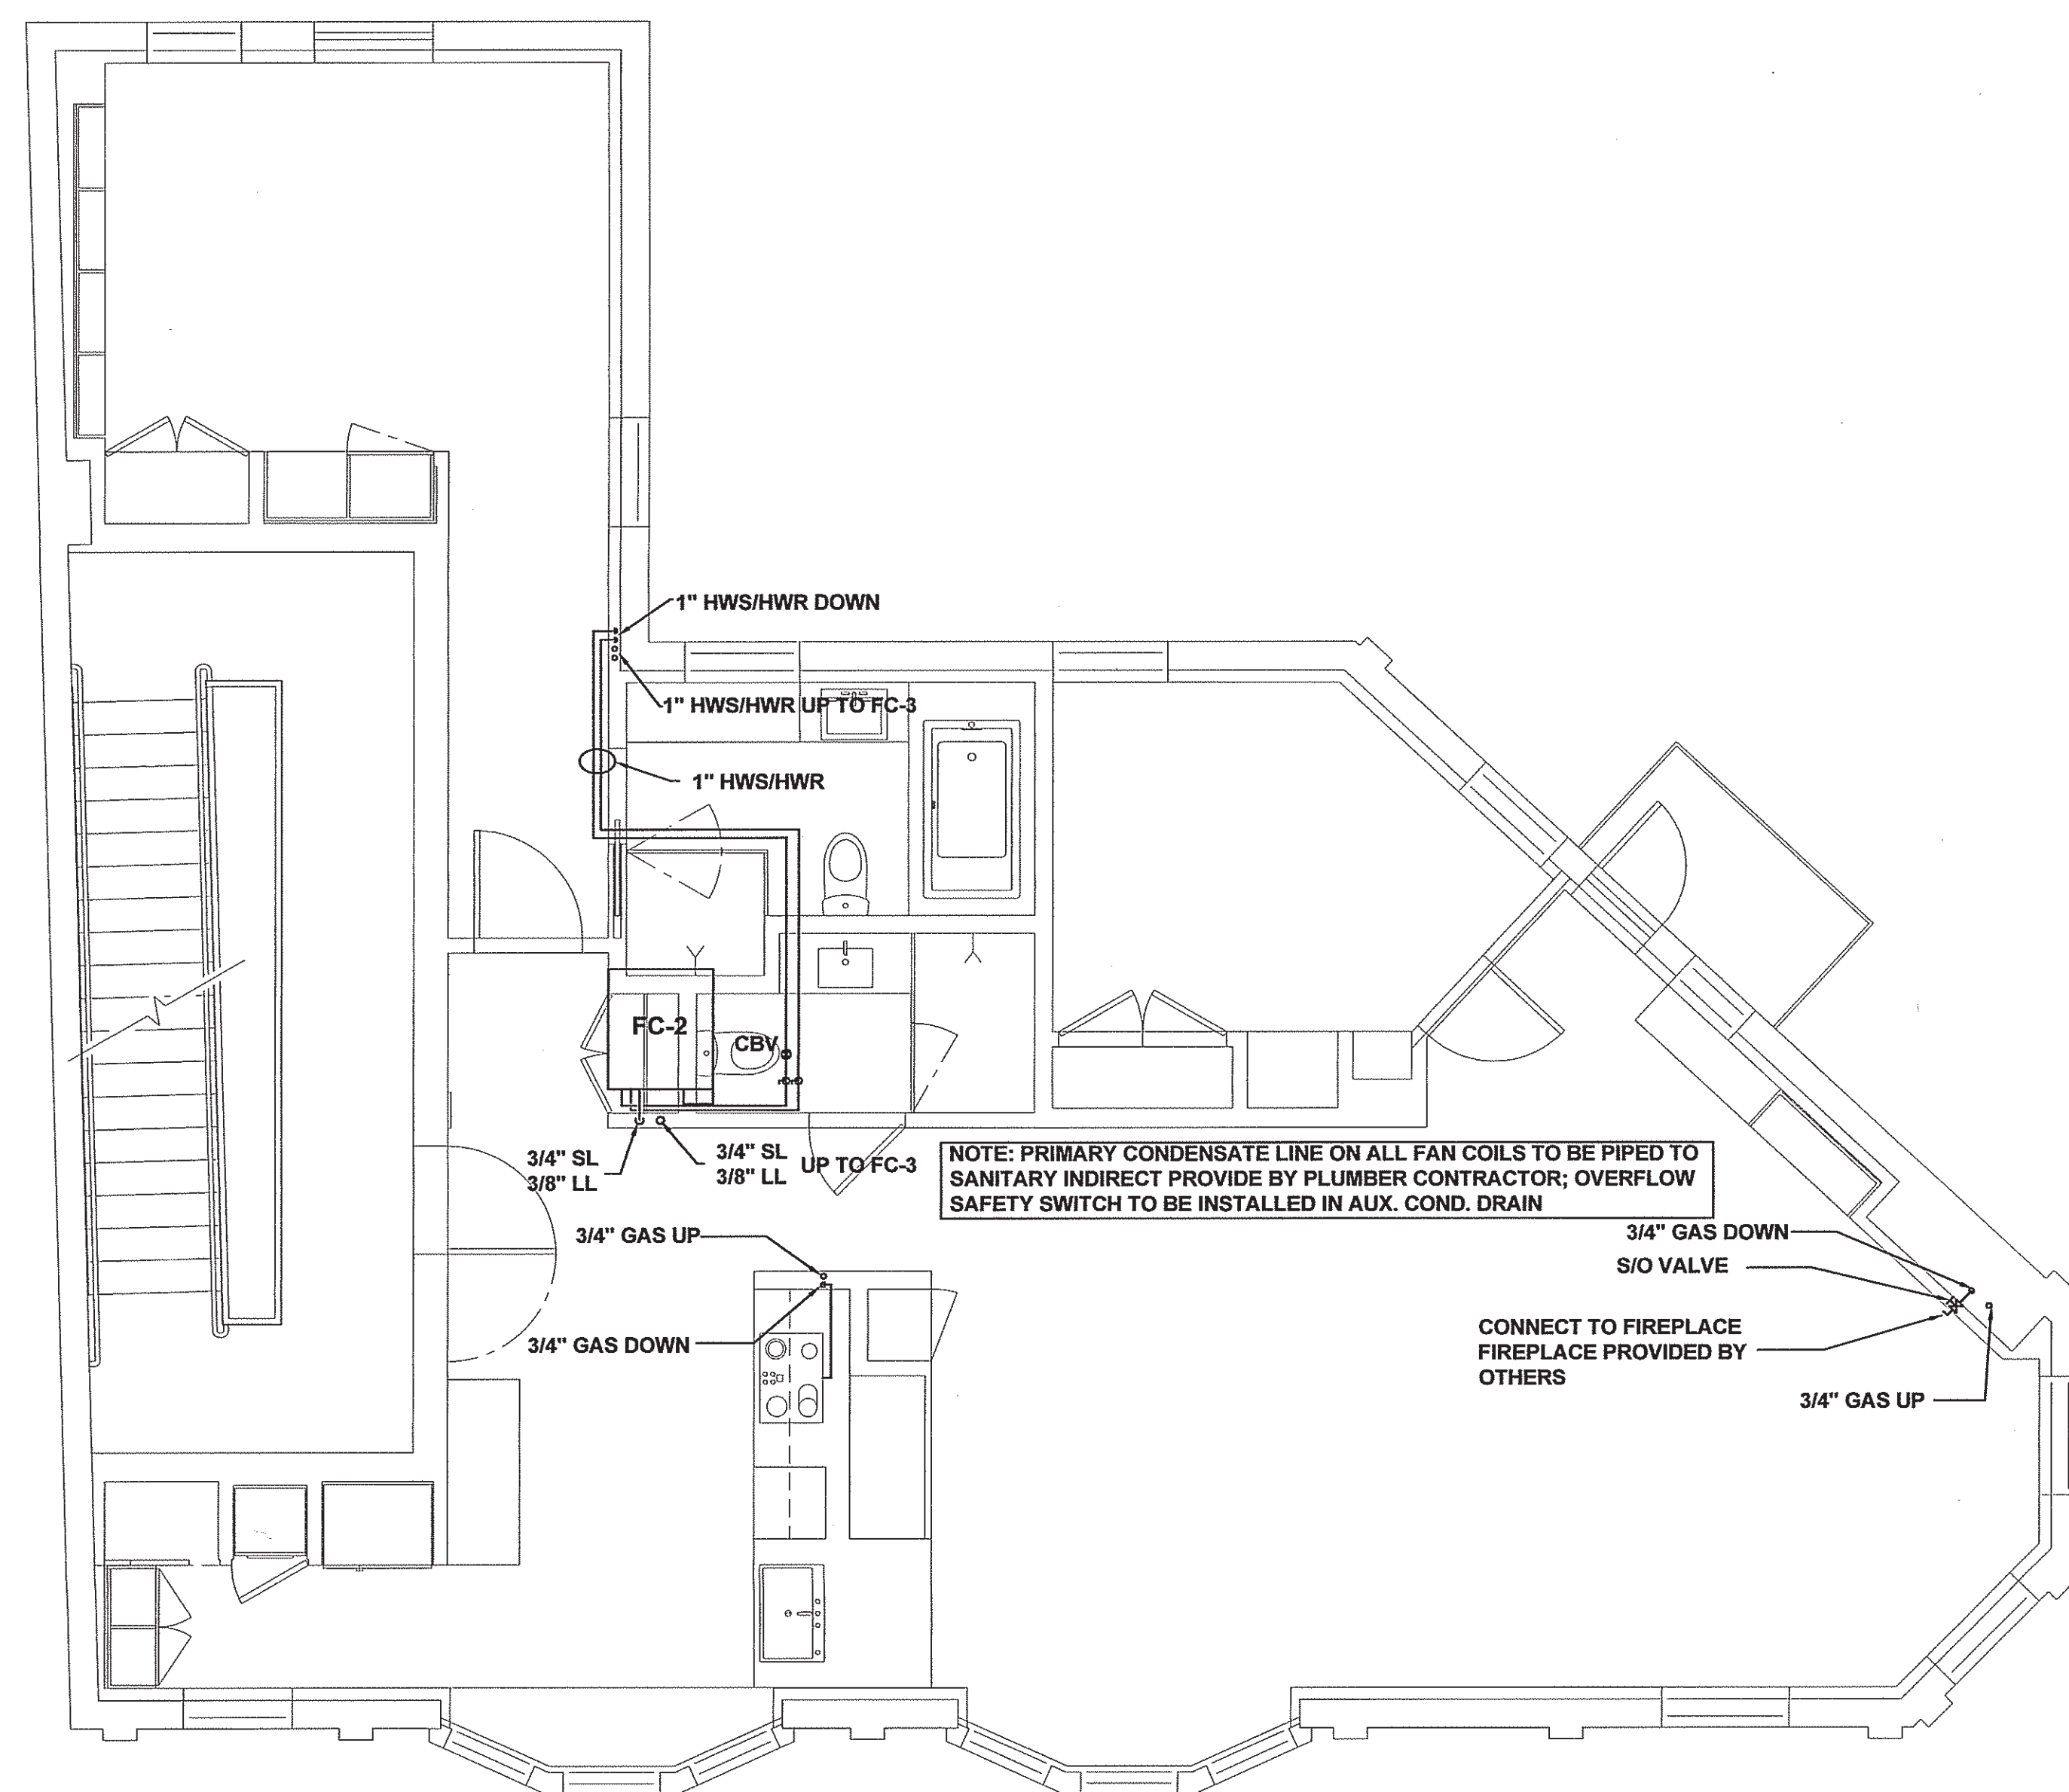

NOTE: PRIMARY CONDENSATE LINE ON ALL FAN COILS TO BE PIPED TO SANITARY INDIRECT PROVIDE BY PLUMBER CONTRACTOR; OVERFLOW SAFETY SWITCH TO BE INSTALLED IN AUX. COND. DRAIN

SECOND FLOOR PIPING PLAN
SCALE: 1/4"=1'-0

660 CONGRESS STREET
PORTLAND, ME

SECOND FLOOR PIPING PLAN

PROJECT NUMBER:	57708
ISSUED:	8.26.14
DRAWN BY:	JLR/MGR/ASG
CHECKED BY:	DWM
FILENAME:	.DWG

THESE DRAWINGS AND PLANS ARE THE PROPERTY OF WH DEMMONS INC. AND ARE AN INSTRUMENT OF SERVICE FOR THE OWNER'S USE FOR THIS PROJECT ON THIS SITE ONLY

M-7