

PLUMBING SCHEDULE									
ROOM	NO.	QUANT.	SYM.	ITEM	MANUFACTURER	MODEL	COLOR/FINISH	SIZE	COMMENTS
BASEMENT RESTROOM	B02	1	P-1	TOILET	--	--	--	--	--
		1	P-2	SINK	--	--	--	--	--
		1	P-3	LAV SPOUT	--	--	--	--	--
BASEMENT RESTROOM	B03	1	P-4	TOILET	--	--	--	--	--
		1	P-5	SINK	--	--	--	--	--
		1	P-6	LAV SPOUT	--	--	--	--	--
BASEMENT RESTROOM	B11	1	P-7	TOILET	--	--	--	--	ADA COMPLIANT
		1	P-8	SINK	--	--	--	--	ADA COMPLIANT
		1	P-9	LAV SPOUT	--	--	--	--	ADA COMPLIANT
1ST FLOOR RESTROOM	102	1	P-10	TOILET	--	--	--	--	ADA COMPLIANT
		1	P-11	SINK	--	--	--	--	ADA COMPLIANT
		1	P-12	LAV SPOUT	--	--	--	--	ADA COMPLIANT
2ND FLOOR RESTROOM	204	1	P-13	TOILET	--	--	--	--	--
		1	P-14	SINK	--	--	--	--	--
		1	P-15	LAV SPOUT	--	--	--	--	--
		1	P-16	TUB	--	--	--	--	--
		1	P-17	SHOWER HEAD	--	--	--	--	--
		1	P-18	VOLUME CONTROL	--	--	--	--	--
		1	P-19	TUB SPOUT	--	--	--	--	--
2ND FLOOR RESTROOM	206	1	P-20	TOILET	--	--	--	--	--
		1	P-21	SINK	--	--	--	--	--
		1	P-22	LAV SPOUT	--	--	--	--	--
		1	P-23	VOLUME CONTROL	--	--	--	--	--
		1	P-24	SHOWER HEAD	--	--	--	--	--
2ND FLOOR KITCHEN	210	1	P-25	SINK	--	--	--	--	--
		1	P-26	FAUCET	--	--	--	--	--
		1	P-27	SOUP DISPENSER	--	--	--	--	--
3RD FLOOR RESTROOM	304	1	P-28	TOILET	--	--	--	--	--
		2	P-29	SINK	--	--	--	--	--
		2	P-30	LAV SPOUT	--	--	--	--	--
		1	P-31	TUB	--	--	--	--	--
		1	P-32	SHOWER HEAD	--	--	--	--	--
		1	P-33	VOLUME CONTROL	--	--	--	--	--
		1	P-34	TUB SPOUT	--	--	--	--	--
3RD FLOOR RESTROOM	306	1	P-35	TOILET	--	--	--	--	--
		1	P-36	SINK	--	--	--	--	--
		1	P-37	LAV SPOUT	--	--	--	--	--
		1	P-38	SHOWER HEAD	--	--	--	--	--
		1	P-39	VOLUME CONTROL	--	--	--	--	--
3RD FLOOR KITCHEN	310	1	P-25	SINK	--	--	--	--	--
		1	P-26	FAUCET	--	--	--	--	--
		1	P-27	SOUP DISPENSER	--	--	--	--	--

APPLIANCE SCHEDULE										
ROOM	NO.	QUANT.	SYM.	ITEM	MANUFACTURER	MODEL	V	COLOR/FINISH	SIZE	COMMENTS
2ND FLOOR KITCHEN	210	1	AP-1	GAS RANGE	--	--		--	--	--
		1	AP-2	DISH WASHER	--	--		--	--	--
		1	AP-3	REF/FREEZER COMBO	--	--		--	--	--
		1	AP-4	MICRO/HOOD COMBO	--	--		--	--	--
		1	AP-5	WINE REF	--	--		--	--	--
3RD FLOOR KITCHEN	310	1	AP-1	GAS RANGE	--	--		--	--	--
		1	AP-2	DISH WASHER	--	--		--	--	--
		1	AP-3	REF/FREEZER COMBO	--	--		--	--	--
		1	AP-4	MICRO/HOOD COMBO	--	--		--	--	--
		1	AP-5	WINE REF	--	--		--	--	--

BATHROOM ACCESSORIES					
FIXT.	TYPE	DESCRIPTION	COLOR/SPEC	DIMENSION	COMMENTS
1	HAND TOWEL DISPENSER	--	--	--	ADA COMPLIANT
2	SOAP DISPENSER	--	--	--	ADA COMPLIANT
3	TOILET PAPER DISPENSER	--	--	--	ADA COMPLIANT
4	GRAB BAR	--	--	--	ADA COMPLIANT
5	BATHROOM PARTITION	--	--	--	--
6	TOWEL HOOK	--	--	--	--
7	SHOWER CURTAIN ROD	--	--	--	--
8	SOAP DISH	--	--	--	--
9	MEDICINE CABINET	--	--	--	--
10	SURFACE MOUNTED SHELF	--	--	--	--
11	--	--	--	--	--
12	--	--	--	--	--

**660-662
CONGRESS
STREET**
PORTLAND, MAINE


ARCHITECT:
PRESENT ARCHITECTURE PLLC
66 WEST BROADWAY, SUITE 306
NEW YORK, NY, 10007
T: (207) 449-8515

CONTRACTOR:
BAYHILL BUILDING & DESIGN
P.O. BOX 178
SOUTH FREEPORT, ME 04078
T: (207) 865-9351

STRUCTURAL ENGINEER:
ENGINEERING DESIGN PROFESSIONALS
P.O. BOX 575
FREEPORT, ME 04032
T: (207) 865-9505

OWNER:
A.K. LONGFELLOW LLC
660 CONGRESS STREET
PORTLAND, ME 04101

NO.	DATE	ISSUE
4	7/18/2014	PHASE 2 PERMIT ISSUE
3	1/15/2014	FIRE MARSHAL ISSUE
2	5/15/2013	PHASE 1 PERMIT ISSUE
1	3/28/2013	HPCA SET

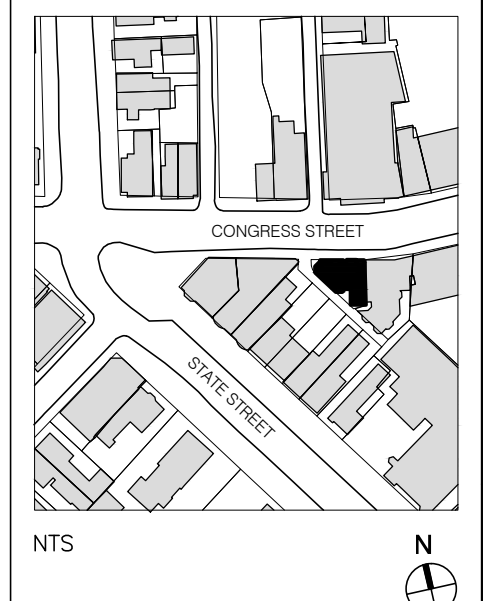

B-SCAN:

DWG CONTENTS:
**PLUMBING &
APPLIANCE SCHEDULES**

DATE: September 5, 2014
SCALE: N.T.S.
DWG. BY:
PROJECT NO.: 008

DWG. NO.: **P-800**

SHEET NO.: