


SHEET NOTES:
 ◇ ADDRESSABLE MINI MONITOR MODULE PROVIDED TO MONITOR PULL STATION.
 INSTALLING CONTRACTOR SHALL FIELD VERIFY EXACT MOUNTING, CIRCUITING AND
 PROGRAMMING REQUIREMENTS. FIELD VERIFY EXACT QUANTITY AND LOCATION(S).

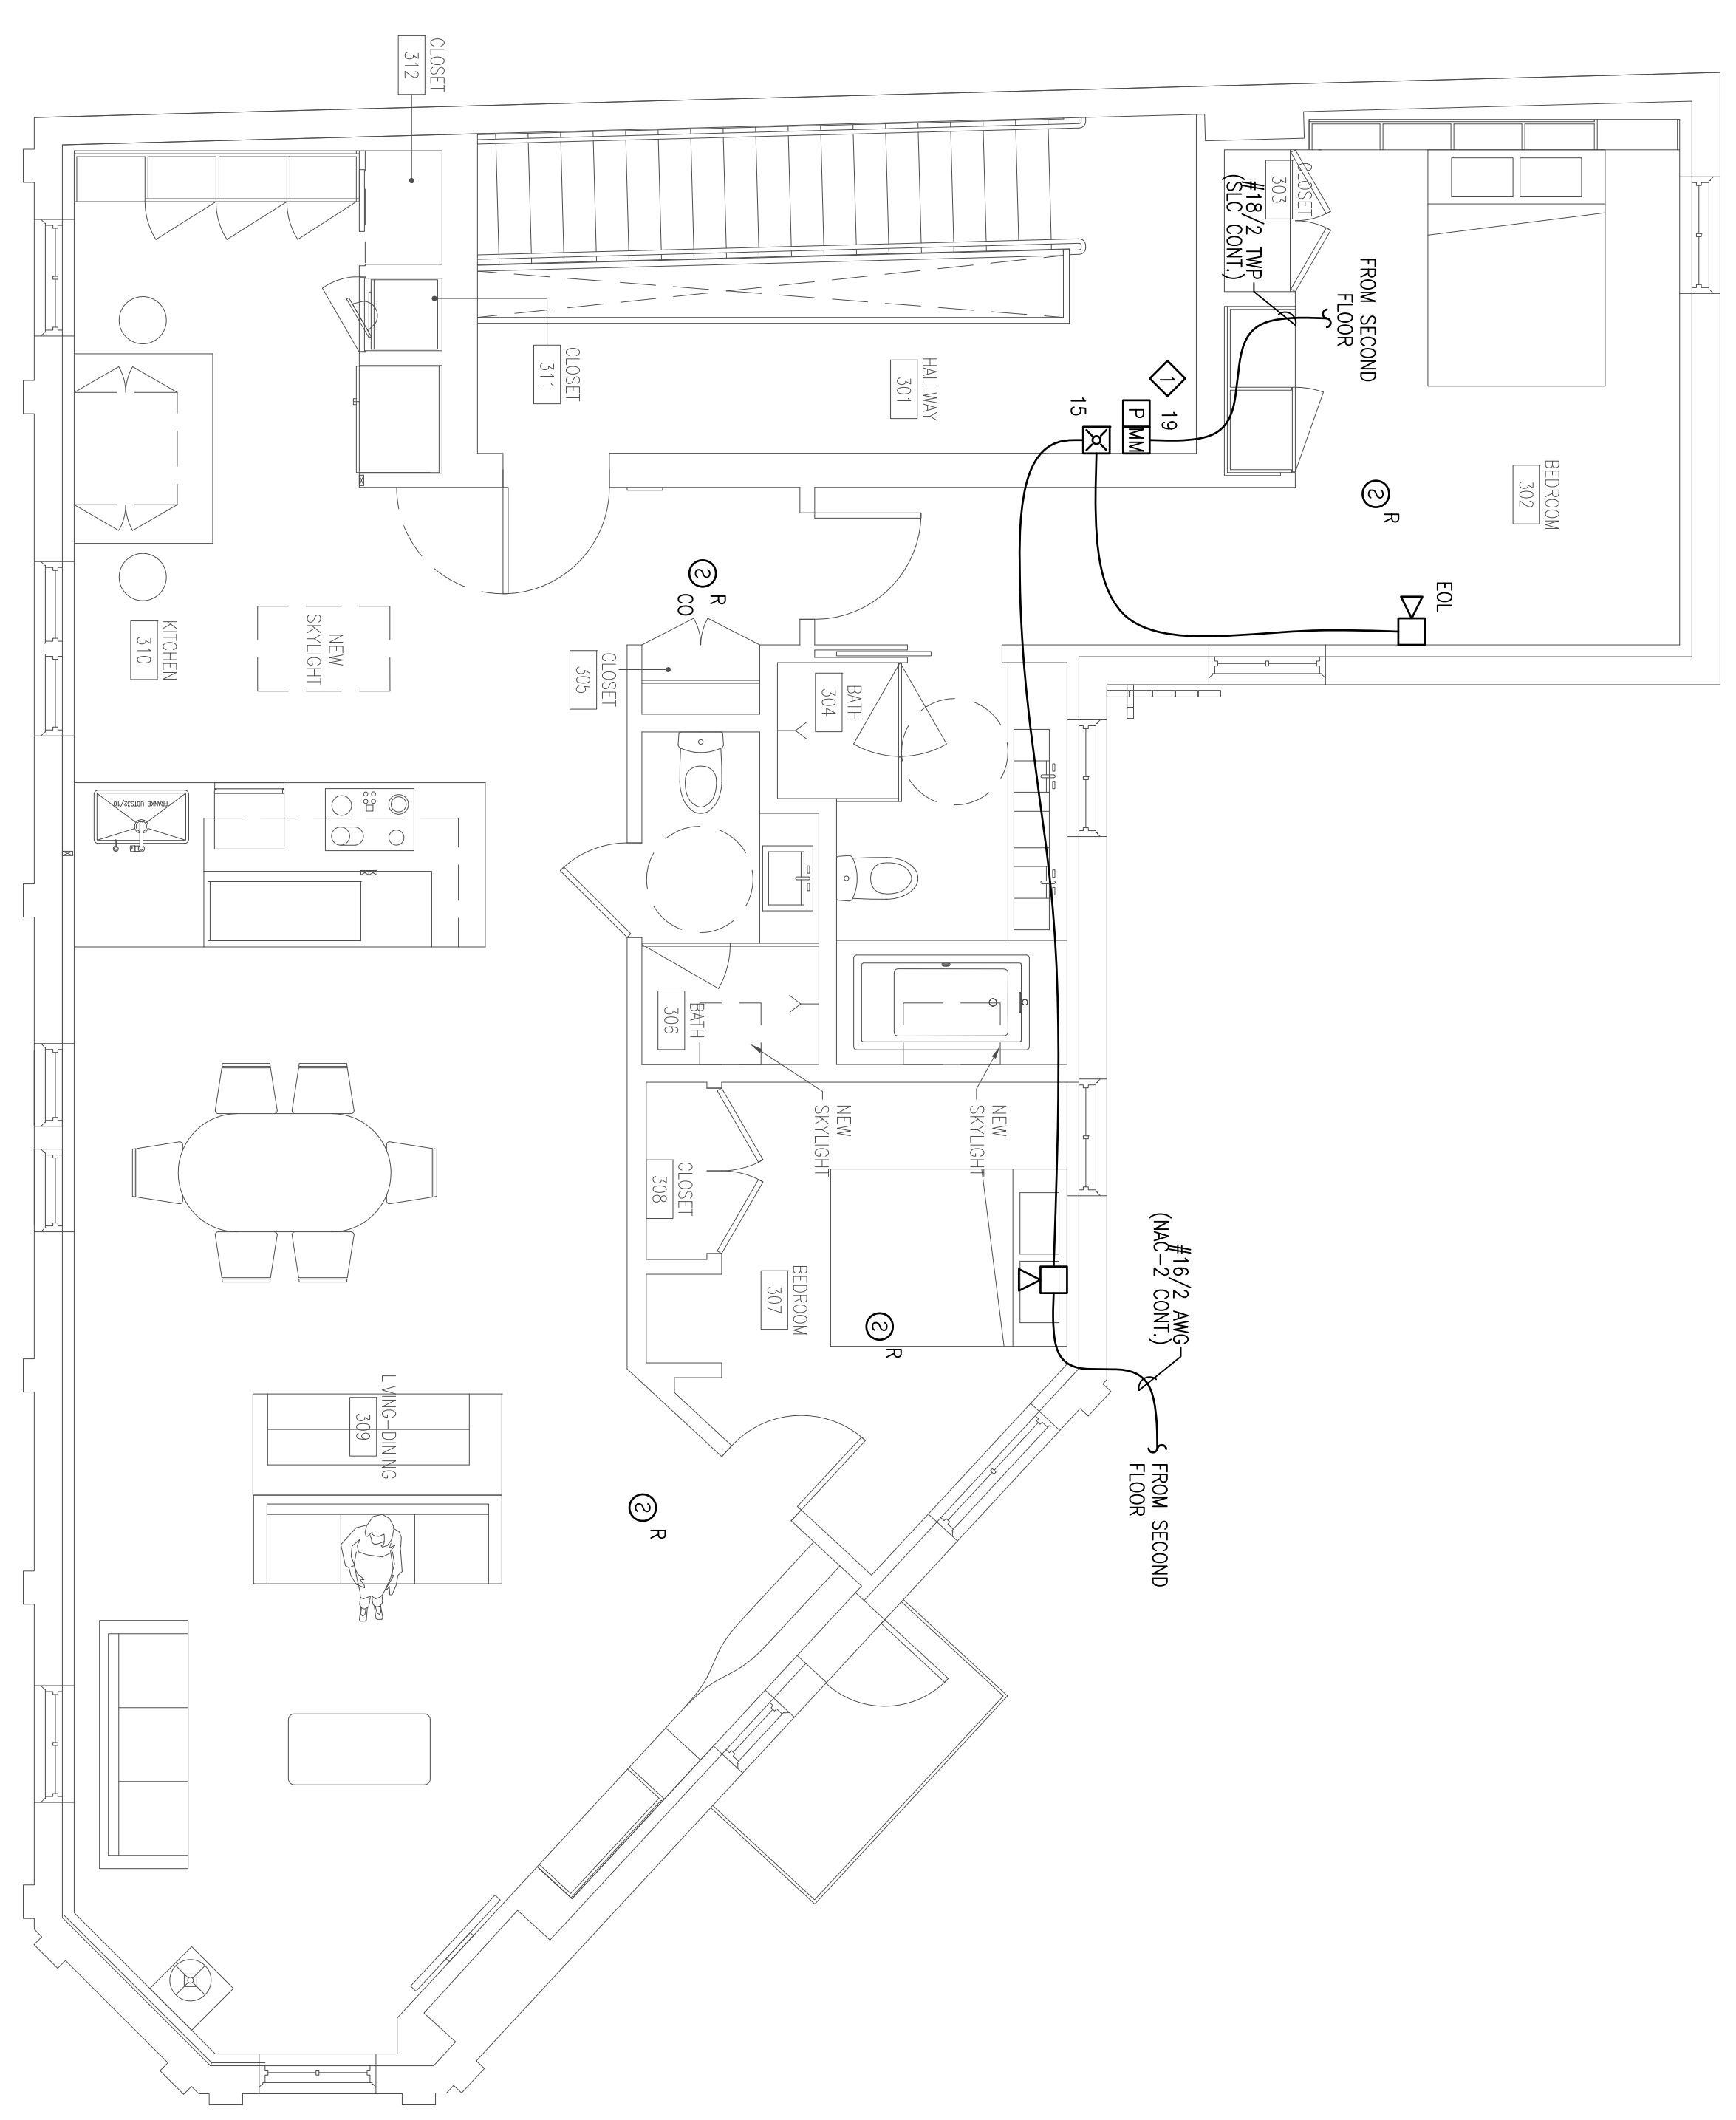

THIRD FLOOR FIRE ALARM PLAN
 SCALE: 1/4"=1'-0"

RESERVED FOR CITY STAMP

REVISION	DESCRIPTION	DATE
0	ISSUED FOR REVIEW & APPROVAL	2/19/2015
1	WIRE REVISION	2/26/2015
2	FLOOR PLAN, SPRINKLR/GATE VALVE REVS	6/22/2015



4 Summer Street • Freeport, Maine 04032
 Office: (207) 706-3369 • Fax: (207) 865-0852

MIXED USE BUILDING
 660 CONGRESS STREET
 PORTLAND, MAINE 04101
 THIRD FLOOR FIRE ALARM PLAN

UNIGAD Inc.
 Fire Alarm Design & Drafting Services
 578 W. 40th St.
 Portland, ME 04102
 Office: 800.856.6110
 www.unigad.net

FA-5

DRAWN	JPB	UNIGAD JOB #14578
CHECKED	WYNNE B. HAWES	NICET # 90496
DATE	2/19/2015	
REVISION	2	
SCALE	1/4" = 1'-0"	