


**SHEET NOTES:**

- ◇ ADDRESSABLE MINI MONITOR MODULE PROVIDED TO MONITOR KNOX BOX TAMPER. INSTALLING CONTRACTOR SHALL FIELD VERIFY EXACT MOUNTING, CIRCUITING AND PROGRAMMING REQUIREMENTS. FIELD VERIFY EXACT QUANTITY AND LOCATION(S).
- ◇ ADDRESSABLE MINI MONITOR MODULE PROVIDED TO MONITOR PULL STATION. INSTALLING CONTRACTOR SHALL FIELD VERIFY EXACT MOUNTING, CIRCUITING AND PROGRAMMING REQUIREMENTS. FIELD VERIFY EXACT QUANTITY AND LOCATION(S).

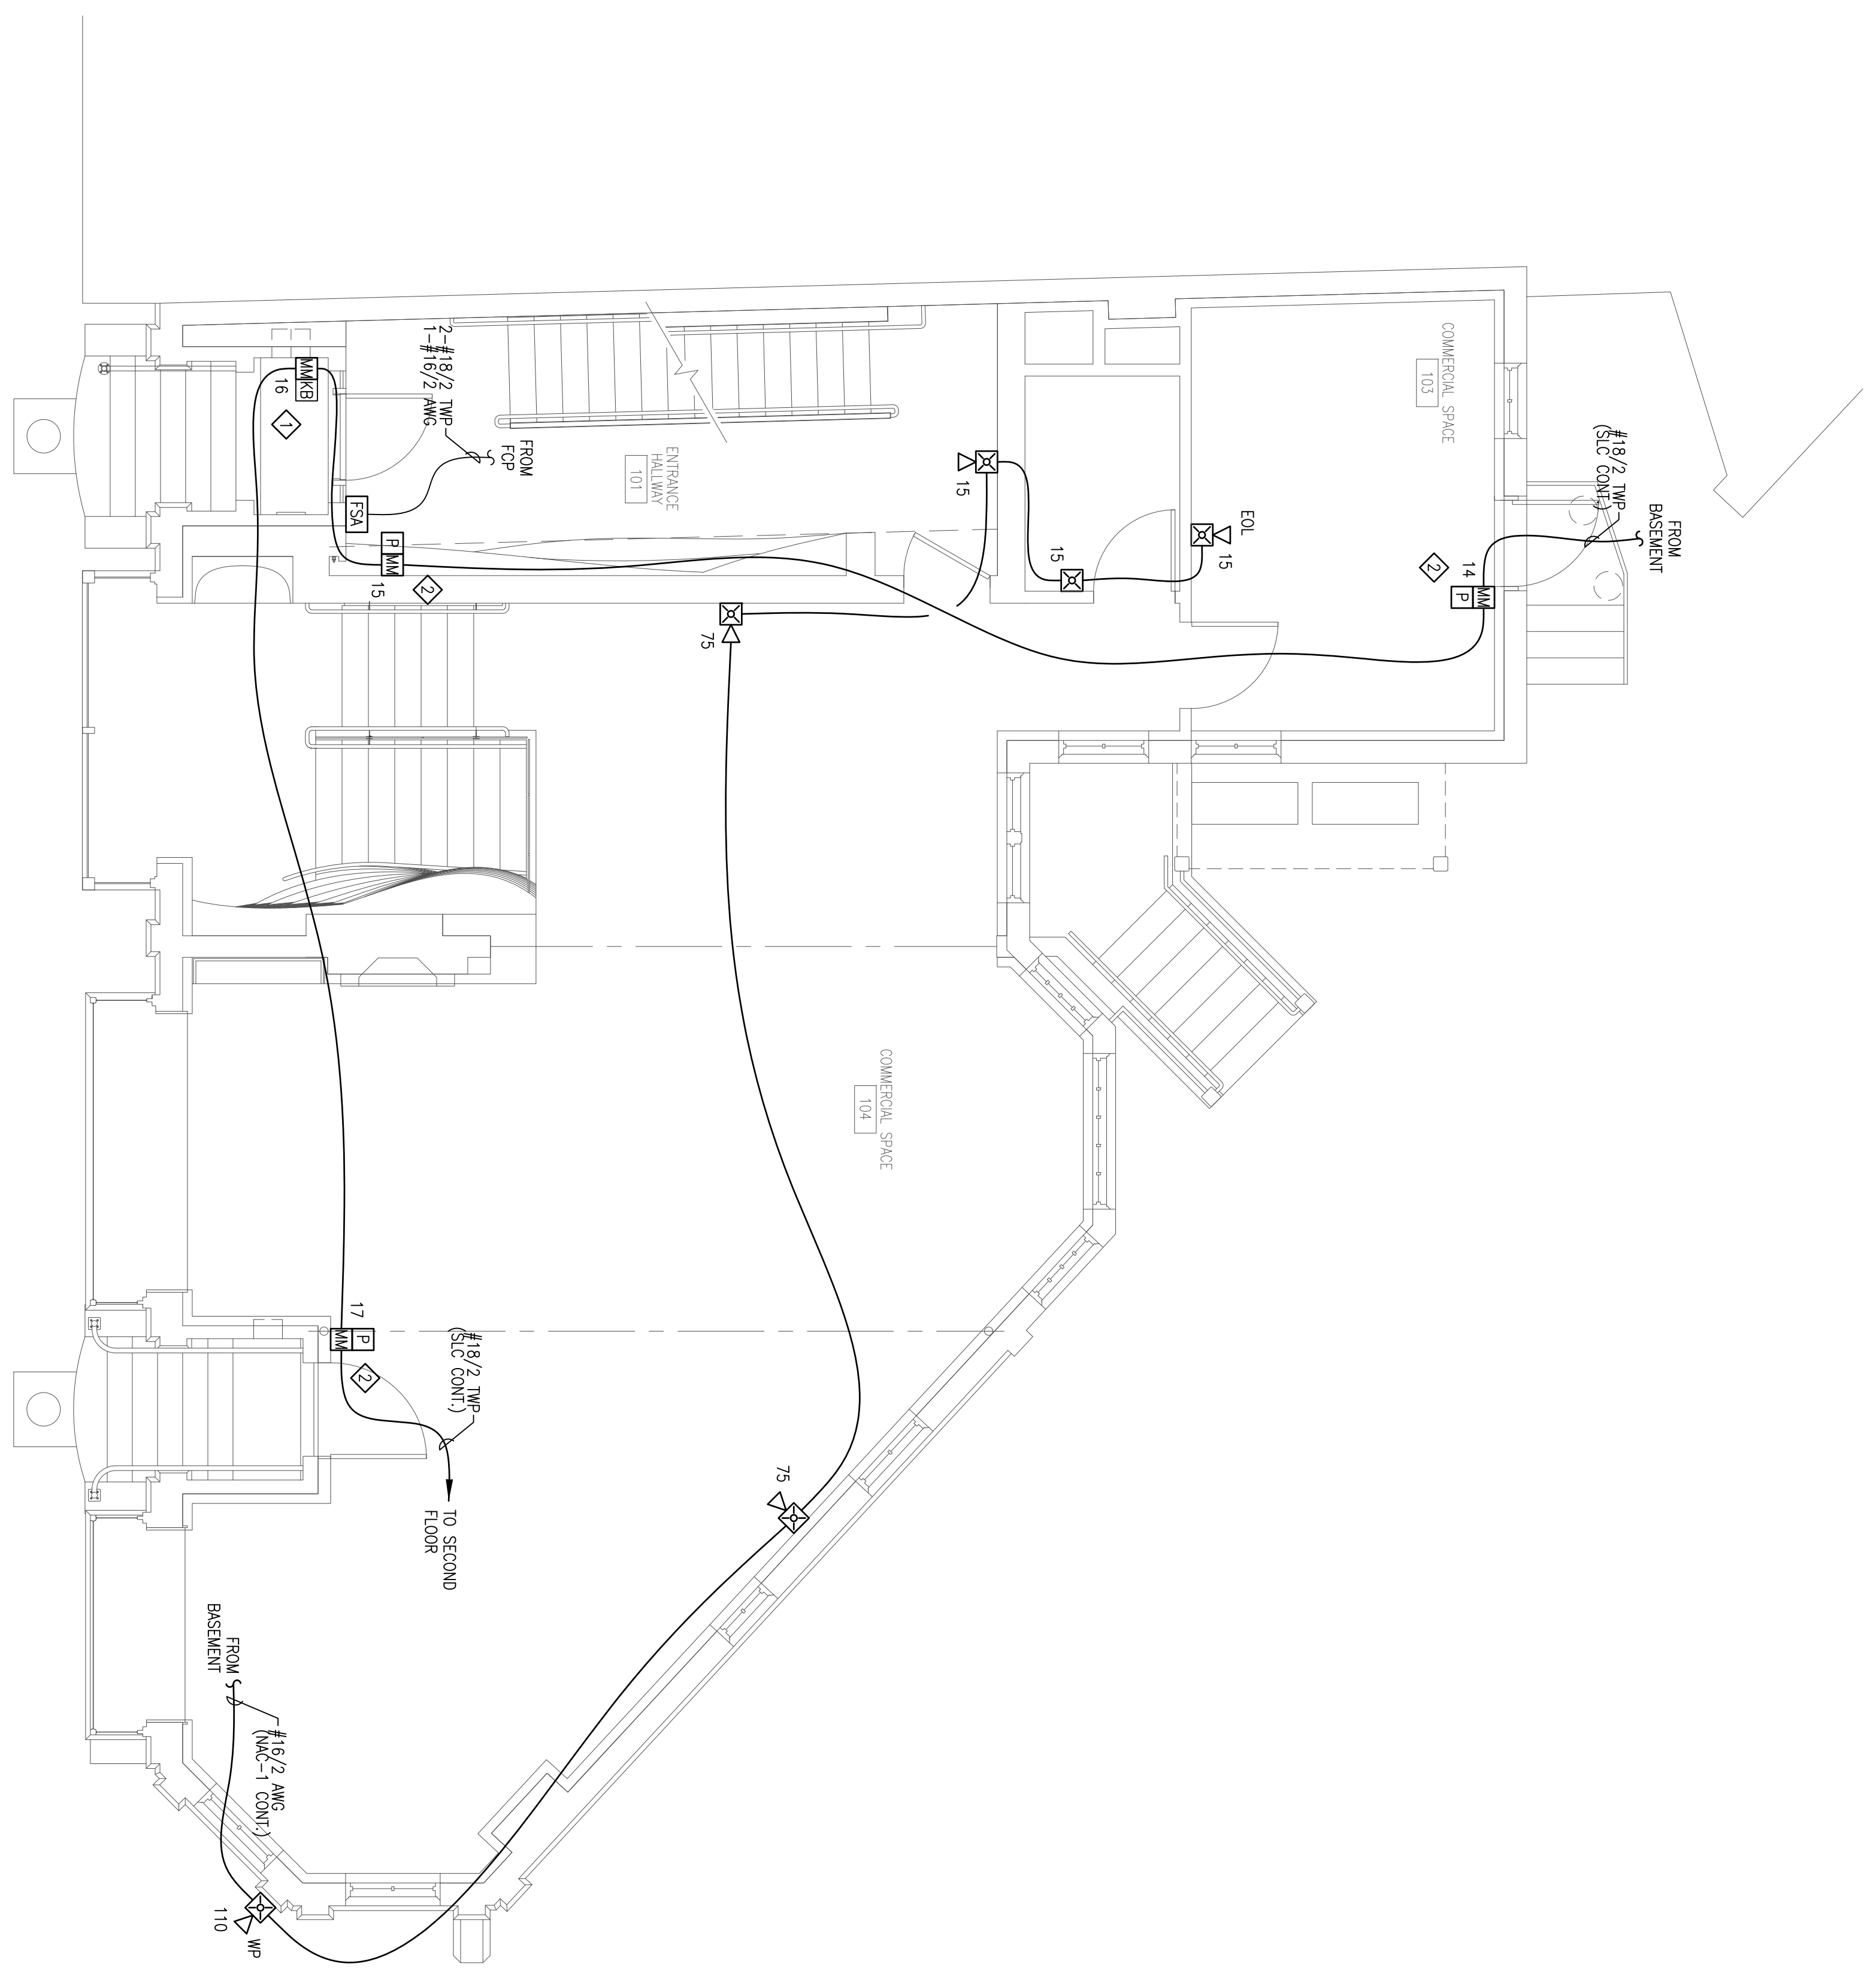


**FIRST FLOOR FIRE ALARM PLAN**  
SCALE: 1/4" = 1'-0"

RESERVED FOR CITY STAMP

REVISION	DESCRIPTION	DATE
0	ISSUED FOR REVIEW & APPROVAL	2/19/2015
1	WIRE REVISION	2/26/2015
2	FLOOR PLAN, SPRINKLR/GATE VALVE REVS	6/22/2015


**SEACOAST SECURITY**  
 4 Summer Street • Freeport, Maine 04032  
 Office: (207) 706-3369 • Fax: (207) 865-0852

**MIXED USE BUILDING**  
**660 CONGRESS STREET**  
**PORTLAND, MAINE 04101**  
**FIRST FLOOR FIRE ALARM PLAN**

  
**UNIGAD**  
 Inc.  
 Fire Alarm Design & Drafting Services  
 574 W. 40th St.  
 Portland, ME 04102  
 Office: 800.852.6110  
 www.unigad.me

DRAWN	JPB
UNIGAD JOB #14578	
CHECKED	WYNNE B. HAWES
DATE	2/19/2015
REVISION	2
SCALE	1/4" = 1'-0"

**FA-3**