


**SHEET NOTES:**

- ◇ ADDRESSABLE MINI MONITOR MODULE(S) PROVIDED TO MONITOR ALL WATER FLOW, PRESSURE SWITCHES, TAMPER SWITCHES AND POST INDICATING VALVES ASSOCIATED WITH THE FIRE SPRINKLER SYSTEM. INSTALLING CONTRACTOR SHALL FIELD VERIFY EXACT MOUNTING, GROUTING AND PROGRAMMING REQUIREMENTS. FIELD VERIFY EXACT QUANTITY AND LOCATION(S).
- ◇ ADDRESSABLE MINI MONITOR MODULE PROVIDED TO MONITOR PULL STATION. INSTALLING CONTRACTOR SHALL FIELD VERIFY EXACT MOUNTING, GROUTING AND PROGRAMMING REQUIREMENTS. FIELD VERIFY EXACT QUANTITY AND LOCATION(S).
- ◇ ADDRESSABLE MINI MONITOR MODULE PROVIDED TO MONITOR AFS ANTENNA CUT. INSTALLING CONTRACTOR SHALL FIELD VERIFY EXACT MOUNTING, GROUTING AND PROGRAMMING REQUIREMENTS. FIELD VERIFY EXACT QUANTITY AND LOCATION(S).
- ◇ ADDRESSABLE RELAY MODULE PROVIDED FOR CONNECTION TO INTERCOM DOOR STRIKE. INSTALLING CONTRACTOR SHALL FIELD VERIFY EXACT MOUNTING, GROUTING AND PROGRAMMING REQUIREMENTS. FIELD VERIFY EXACT QUANTITY AND LOCATION(S).
- ◇ ADDRESSABLE MINI MONITOR MODULE PROVIDED TO MONITOR GATE VALVE(S). INSTALLING CONTRACTOR SHALL FIELD VERIFY EXACT MOUNTING, GROUTING AND PROGRAMMING REQUIREMENTS. FIELD VERIFY EXACT QUANTITY AND LOCATION(S).

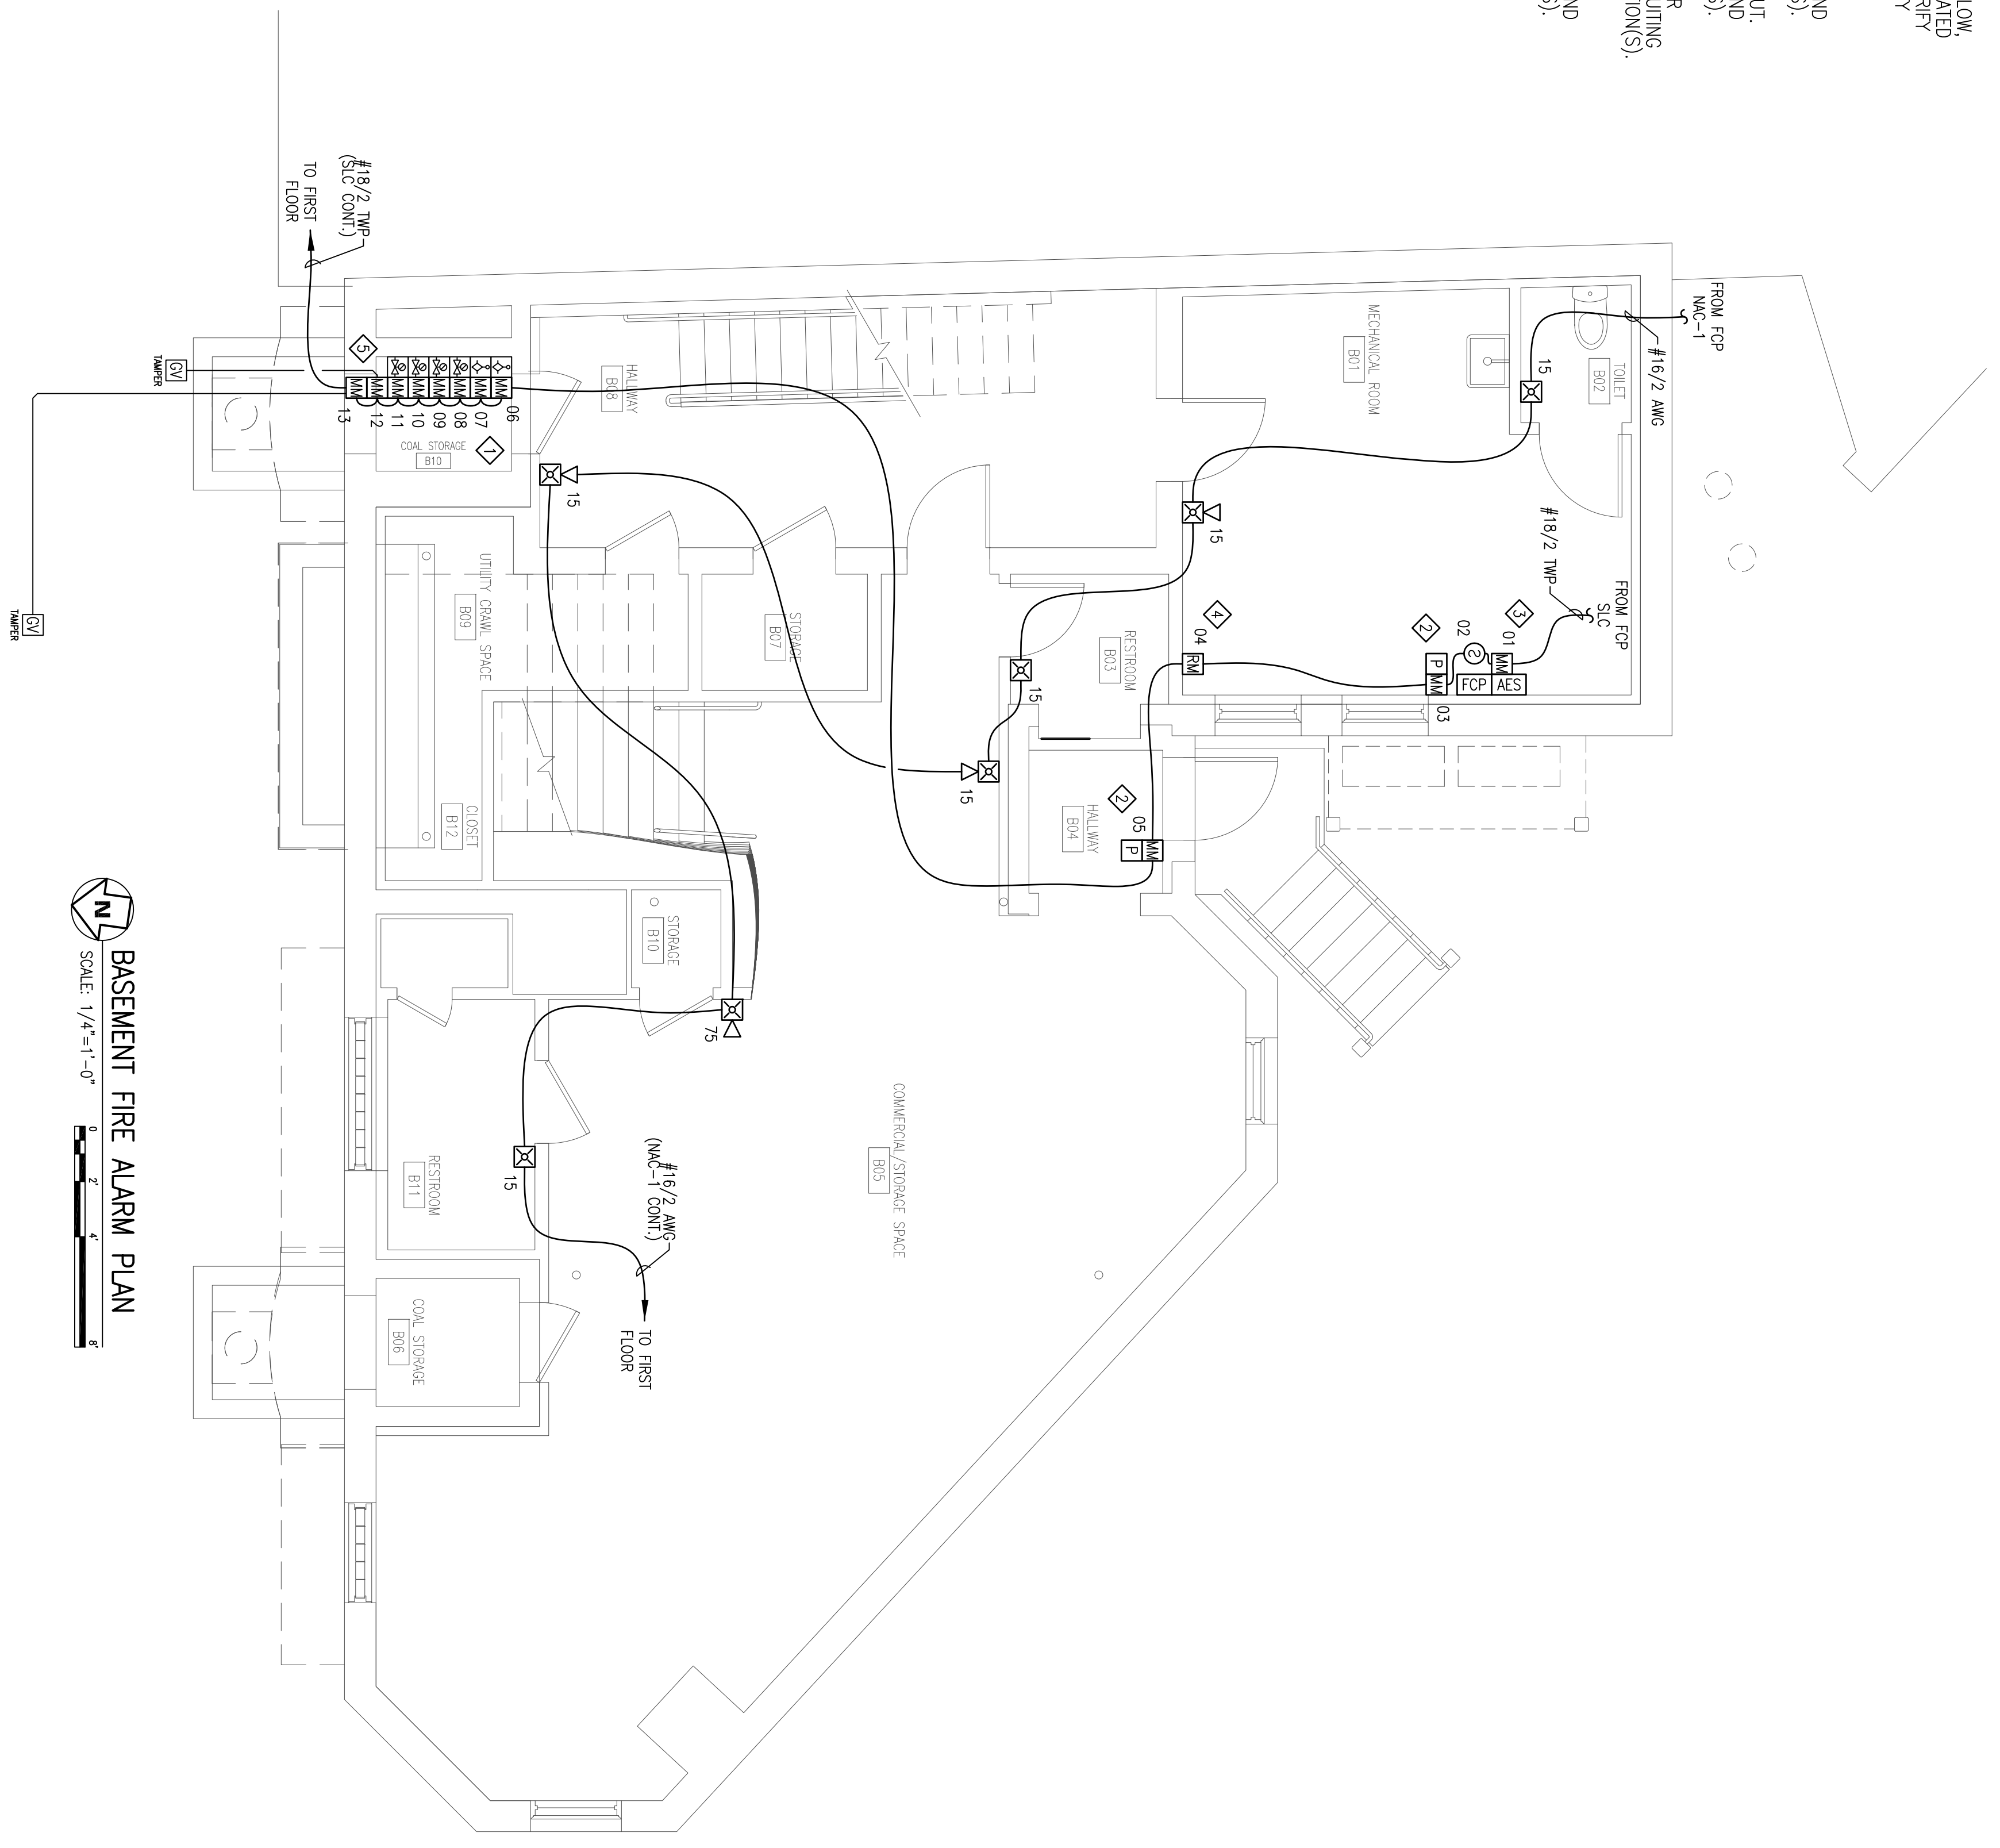

**BASEMENT FIRE ALARM PLAN**  
SCALE: 1/4" = 1'-0"

RESERVED FOR CITY STAMP

REVISION	DESCRIPTION	DATE
0	ISSUED FOR REVIEW & APPROVAL	2/19/2015
1	WIRE REVISION	2/26/2015
2	FLOOR PLAN, SPRINKLR/GATE VALVE REVS	6/22/2015



**SEACOAST SECURITY**

4 Summer Street • Freeport, Maine 04032  
Office: (207) 706-3369 • Fax: (207) 865-0852

**MIXED USE BUILDING**  
**660 CONGRESS STREET**  
**PORTLAND, MAINE 04101**  
**BASEMENT FIRE ALARM PLAN**

DRAWN	JPB UNICAD JOB #14578
CHECKED	WAYNE B. HAWK NICET IV 90496
DATE	2/19/2015
REVISION	2
SCALE	1/4" = 1'-0"