




CONSULTANTS:

REVISIONS:

DATE: SEPTEMBER 29, 2016
 PROJECT No. 1621
 DRAWN BY: RJS, RRT
 CHECKED BY: RJS
 SCALE: AS NOTED



SHEET TITLE:
 BASEMENT FLOOR PLAN

A1-0

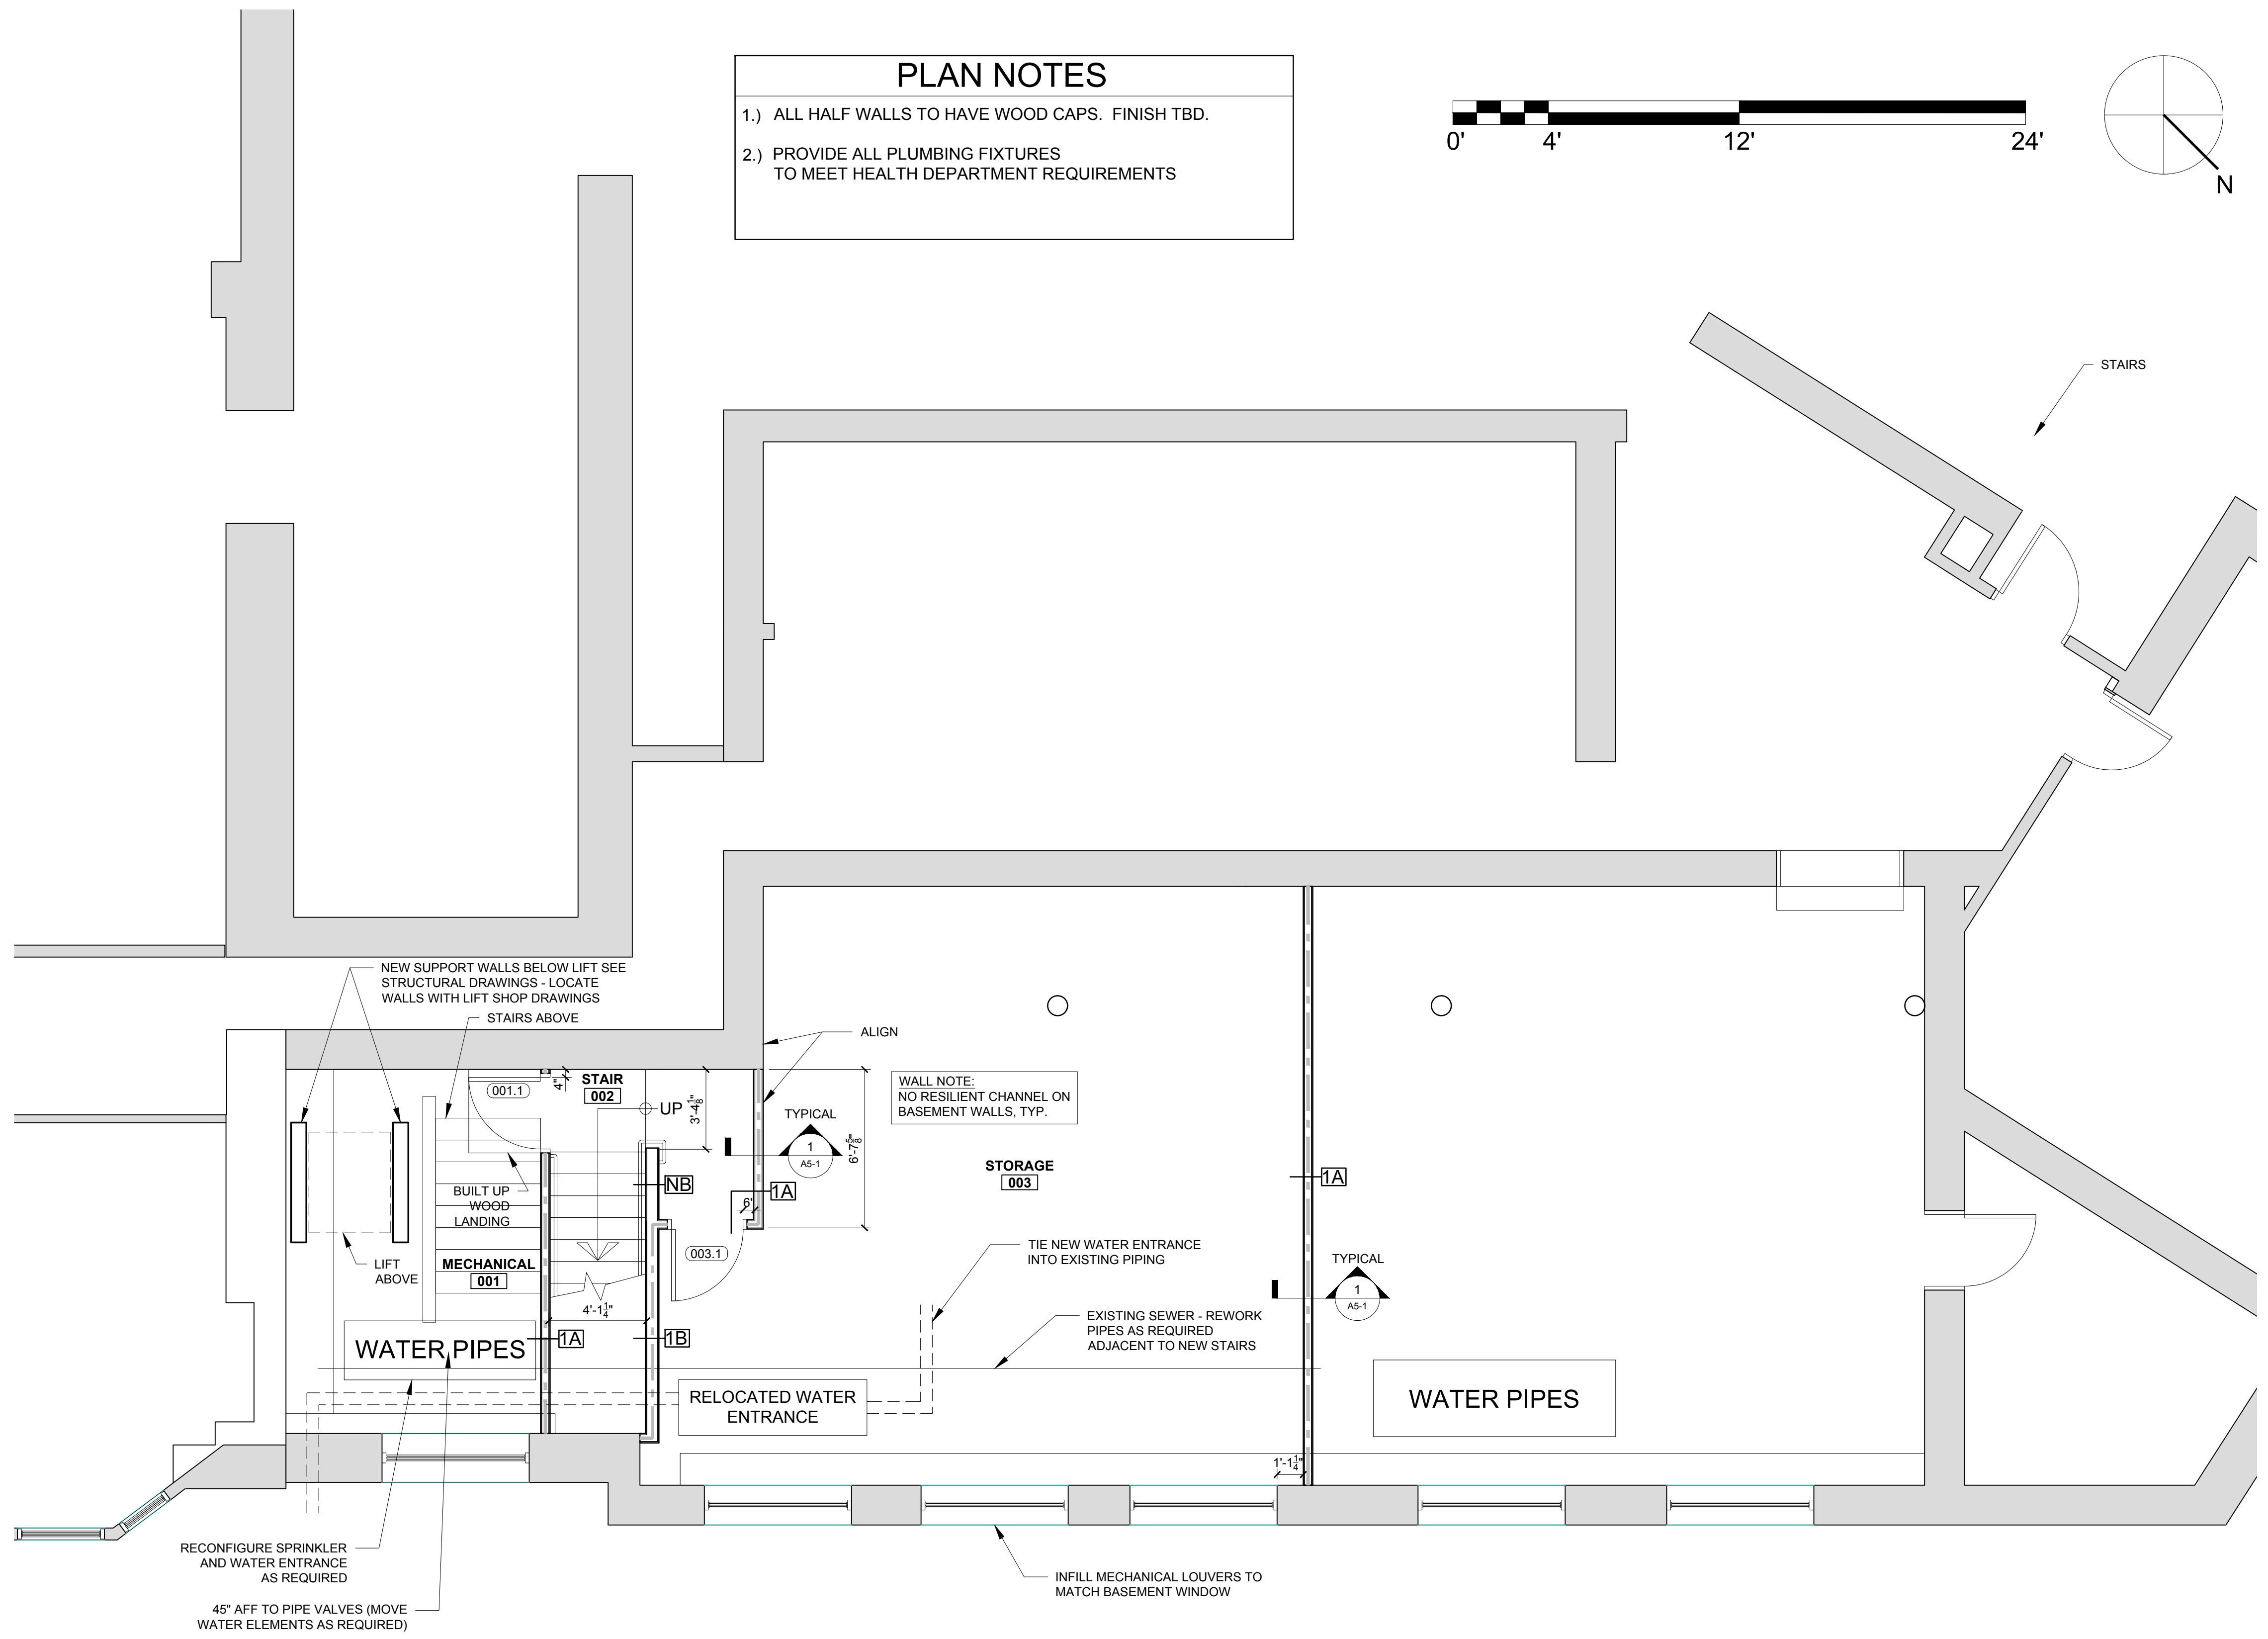

PLAN NOTES

- 1.) ALL HALF WALLS TO HAVE WOOD CAPS. FINISH TBD.
- 2.) PROVIDE ALL PLUMBING FIXTURES TO MEET HEALTH DEPARTMENT REQUIREMENTS

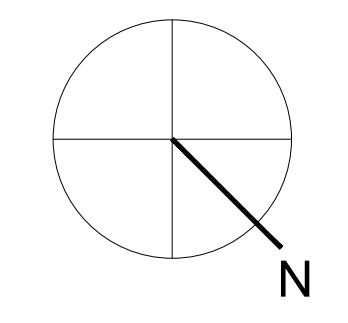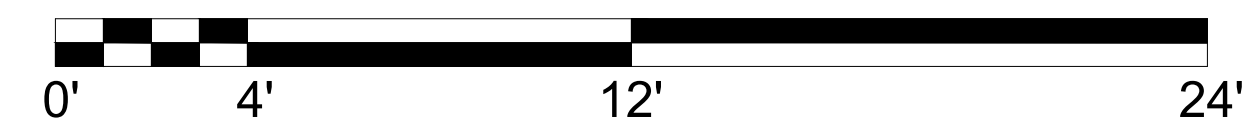

1 BASEMENT FLOOR PLAN
 1/4" = 1'-0"