
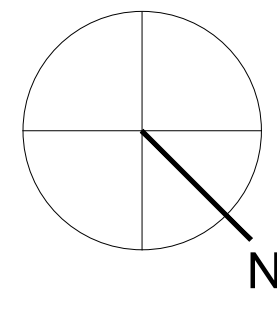


- RCP NOTES**
- 1.) REMOVE ANY UNUSED AND ABANDONED ELEMENTS ON CEILING IN WORK AREA
  - 2.) AT NEW FIRE RATED CEILING, PROVIDE STRAPPING ON EXISTING CEILING, LEVEL AND SHIM FOR NEW GWB.
  - 3.) ADJUST SPRINKLER HEAD LOCATIONS AS REQUIRED FOR NEW WORK
  - 4.) ALL RECESSED LIGHTING FIXTURES TO HAVE IC-FIRE RATED HOUSING TO MEET CEILING FIRE RATING REQUIREMENTS

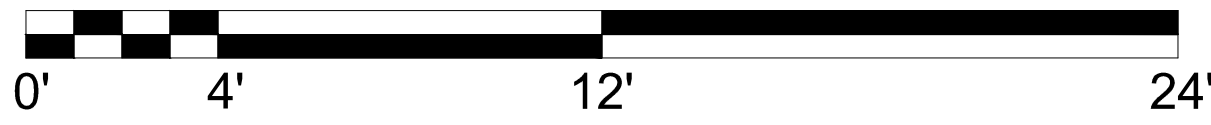

© 2016 RYAN SENATORE ARCHITECTURE

**LAYFAYETTE BUILDING RENOVATION**  
 PARK STREET  
 PORTLAND, MAINE

**RSA**  
 RYAN SENATORE  
 ARCHITECTURE  
 565 CONGRESS STREET  
 PORTLAND, MAINE 04101  
 207-747-5159  
 senatorearchitecture.com

CONSULTANTS:  
 REVISIONS:

DATE: SEPTEMBER 29, 2016  
 PROJECT No. 1621  
 DRAWN BY: RJS, RRT  
 CHECKED BY: RJS  
 SCALE: AS NOTED

SHEET TITLE:  
**BASEMENT REFLECTED CEILING PLAN**

1 BASEMENT REFLECTED CEILING PLAN  
 1/4" = 1'-0"

A1-3