
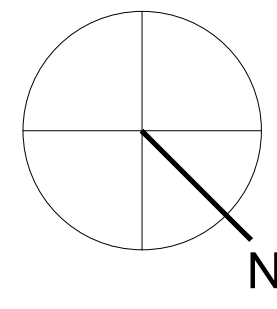


- RCP NOTES**
- 1.) REMOVE ANY UNUSED AND ABANDONED ELEMENTS ON CEILING IN WORK AREA
 - 2.) AT NEW FIRE RATED CEILING, PROVIDE STRAPPING ON EXISTING CEILING, LEVEL AND SHIM FOR NEW GWB.
 - 3.) ADJUST SPRINKLER HEAD LOCATIONS AS REQUIRED FOR NEW WORK
 - 4.) ALL RECESSED LIGHTING FIXTURES TO HAVE IC-FIRE RATED HOUSING TO MEET CEILING FIRE RATING REQUIREMENTS

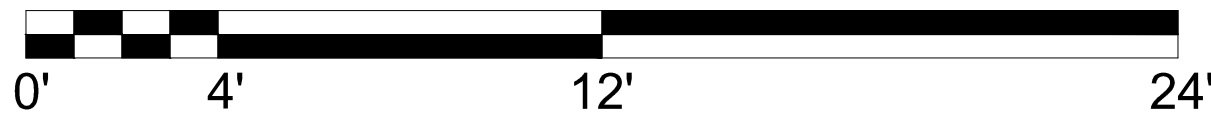

REGISTERED ARCHITECT
 RYAN J. SENATORE
 No. 3322
 STATE OF MAINE
 © 2016 RYAN SENATORE ARCHITECTURE

LAYFAYETTE BUILDING RENOVATION
 PARK STREET
 PORTLAND, MAINE

RSA
 RYAN SENATORE ARCHITECTURE
 565 CONGRESS STREET
 PORTLAND, MAINE 04101
 207-747-5159
 senatorearchitecture.com

CONSULTANTS:
 REVISION #1 - 8/2/17

REVISIONS:

DATE: SEPTEMBER 29, 2016
 PROJECT No. 1621
 DRAWN BY: RJS, RRT
 CHECKED BY: RJS
 SCALE: AS NOTED

SHEET TITLE:
BASEMENT REFLECTED CEILING PLAN

A1-3

1 BASEMENT REFLECTED CEILING PLAN
 1/4" = 1'-0"