


REVISION	DESCRIPTION	DATE
0	ISSUED FOR REVIEW & APPROVAL	3/12/2016


  
**SEACOAST SECURITY**

4 Summer Street - Freeport, Maine 04022  
 Office: (207) 706-3369 • Fax: (207) 865-0852

**ROSA TRUE APARTMENTS**  
**140 PARK ST.**  
**PORTLAND, ME**  
**FIRE ALARM PLAN 1st & 2nd FLOORS**

DRAWN	JS	UNICAD JOB #16131
CHECKED	WAYNE B. HAWES	NCET # 90496
DATE		
REVISION	0	
SCALE	1/8"=1'-0"	


FA-2

UNICAD


INC.  
 574 W. 40TH ST.  
 PORTLAND, ME 04107  
 PHONE: 857.865.5410  
 WWW.UNICAD.COM

Fire Alarm Design & Drafting Services

- SHEET NOTES:**
- ◆ REPLACE EXISTING DEVICE WITH NEW AND REUSE EXISTING WIRING IF COMPATIBLE WITH NEW DEVICE AND MEETS ALL NFPA CODE REQUIREMENTS FOR CLASS "B" CIRCUIT WIRING.
  - ◆ SLC CKT. CONTINUE TO ALL NEW ADDRESSABLE INITIATING DEVICES. SPLICE INTO EXISTING WIRING IF WIRE MEETS ALL MANUFACTURERS REQUIREMENTS FOR ADDRESSABLE DEVICES.
  - ◆ PENDING CHANGE ORDER, DO NOT INSTALL UNTIL APPROVAL FROM OWNER. VERIFY ADA LOCATION WITH OWNER.

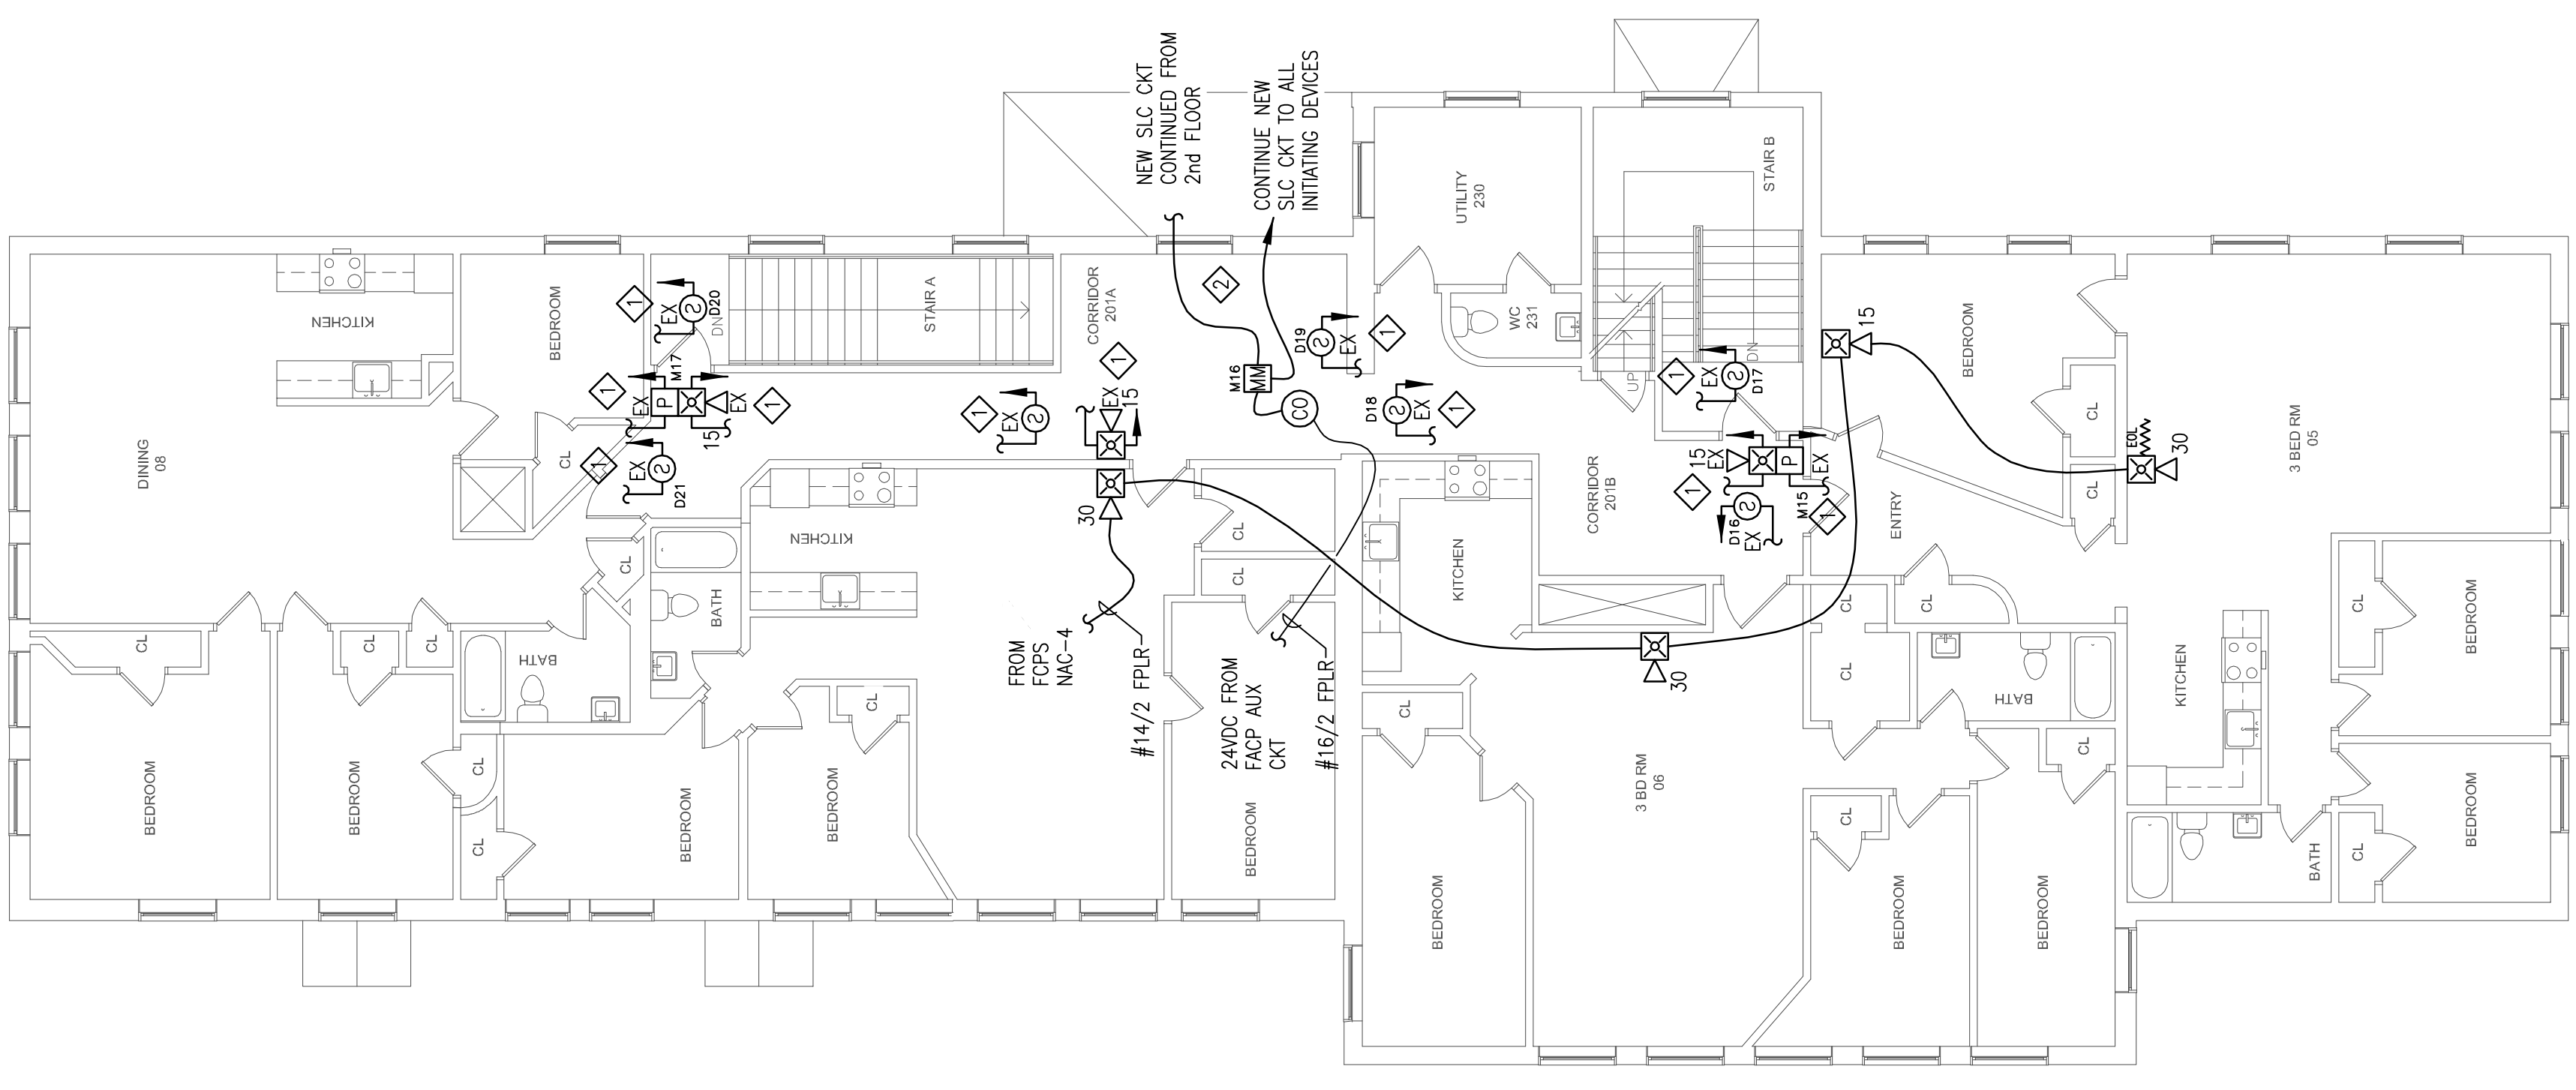

**2ND FLOOR**  
**FIRE ALARM PLAN**  
 SCALE: 1/8"=1'-0"

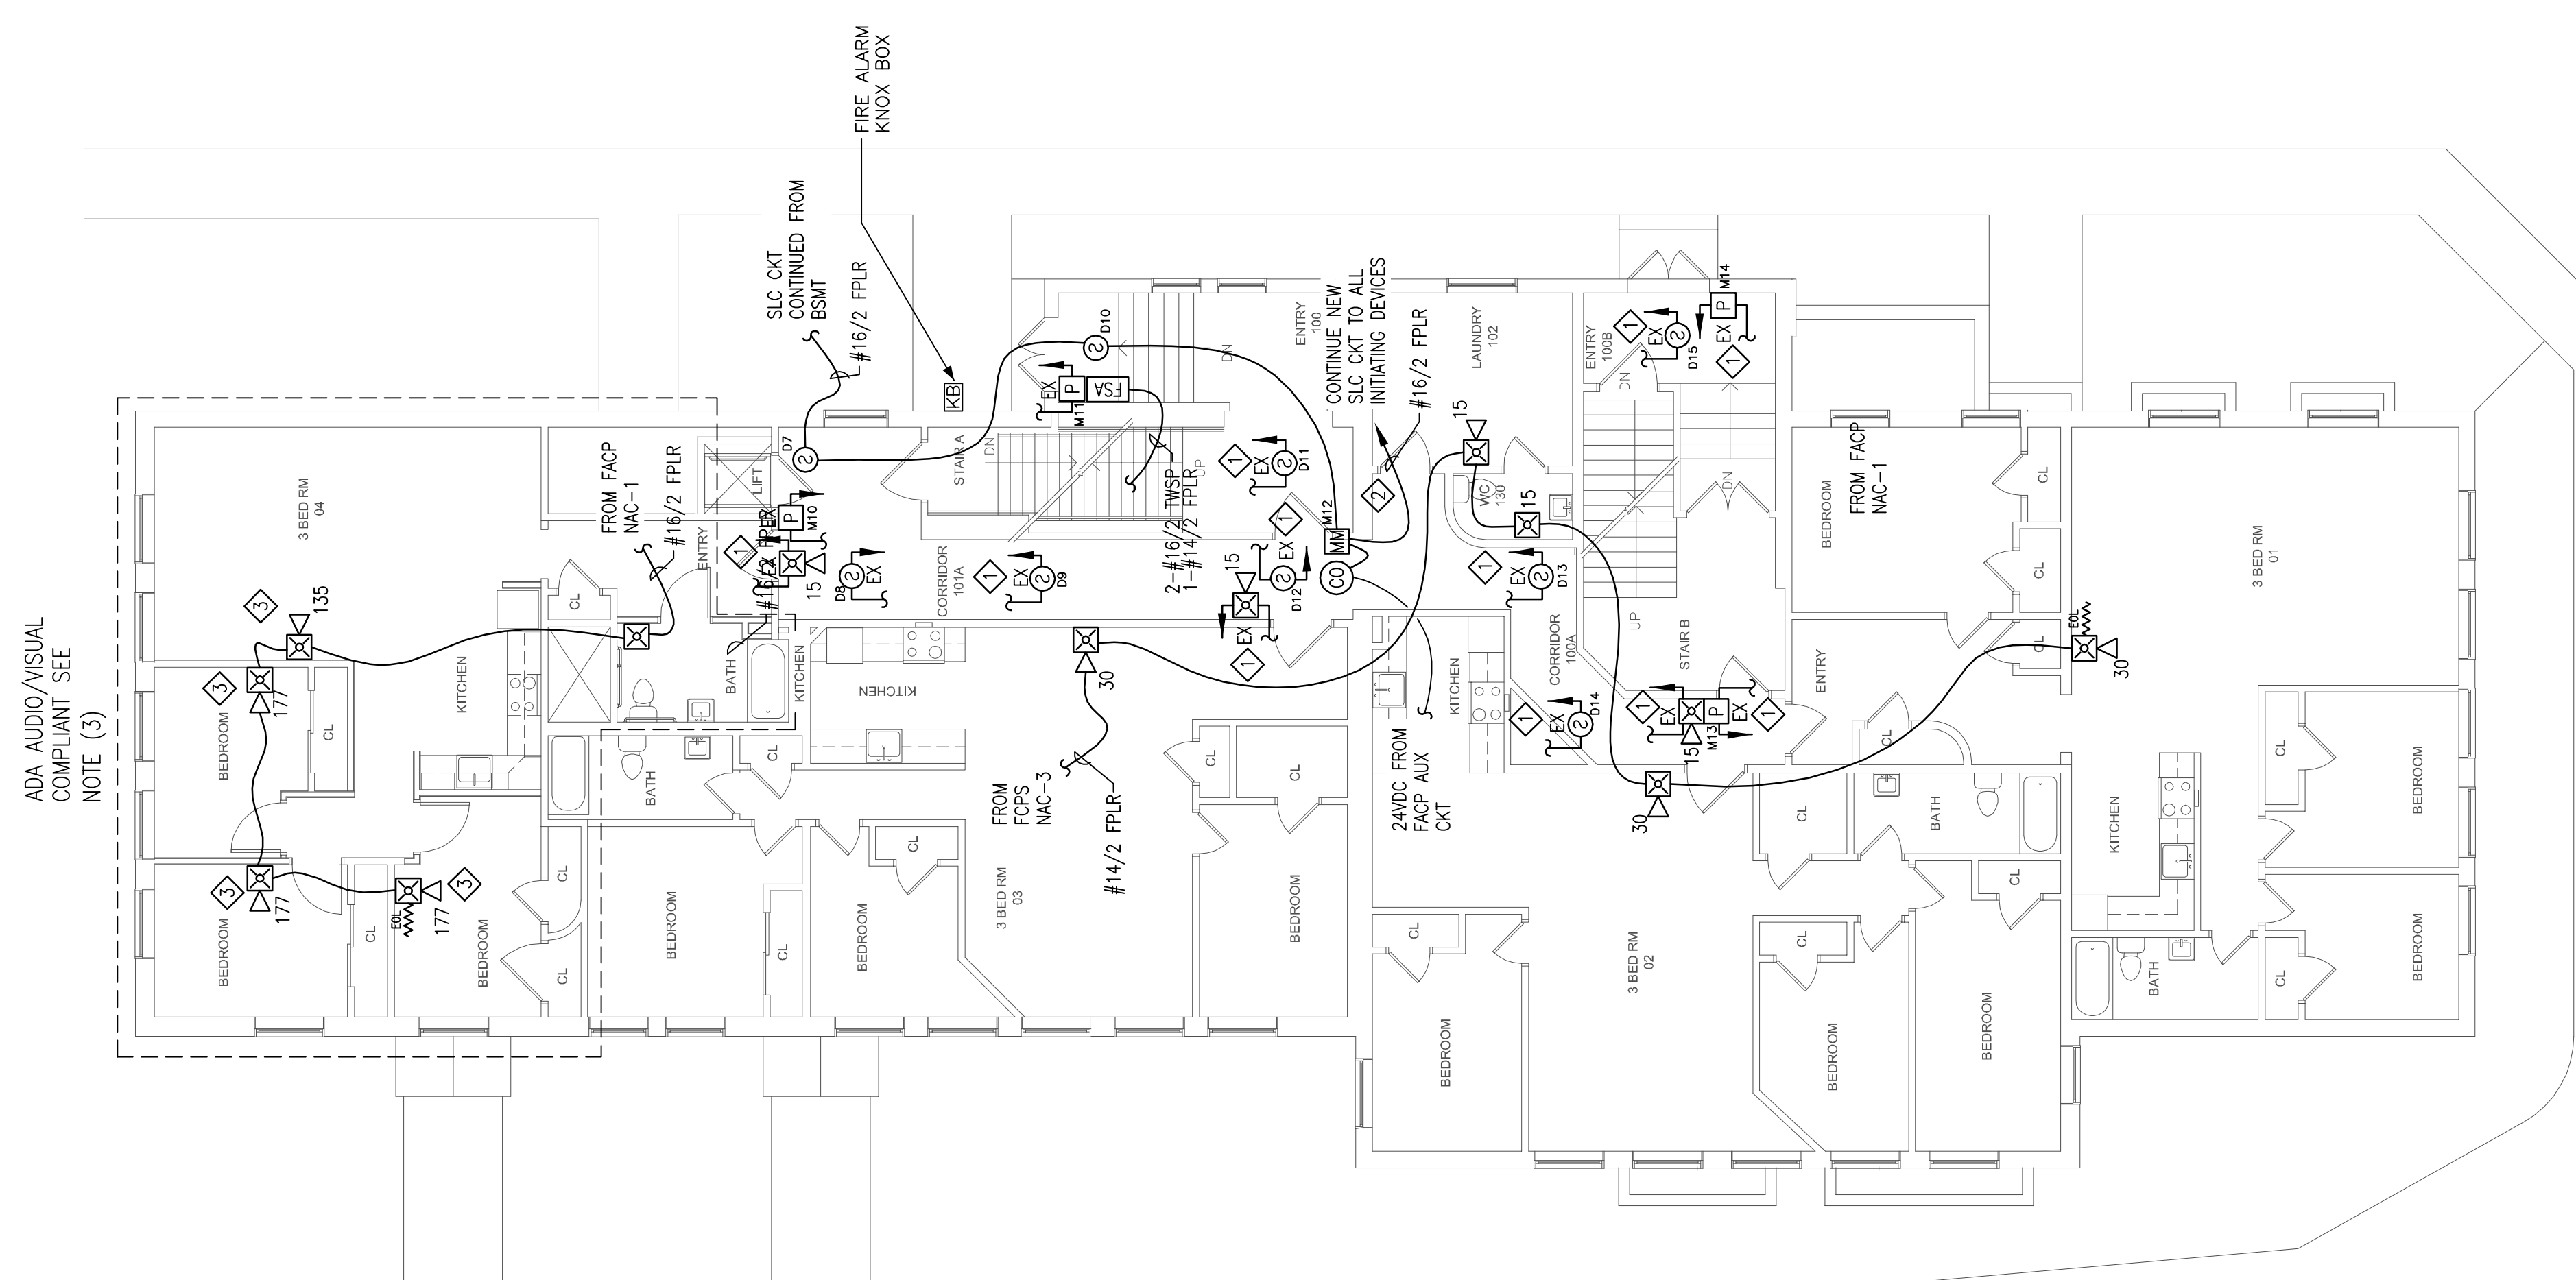

**1ST FLOOR**  
**FIRE ALARM PLAN**  
 SCALE: 1/8"=1'-0"