




FIRE ALARM SYSTEM LAYOUT – BASEMENT

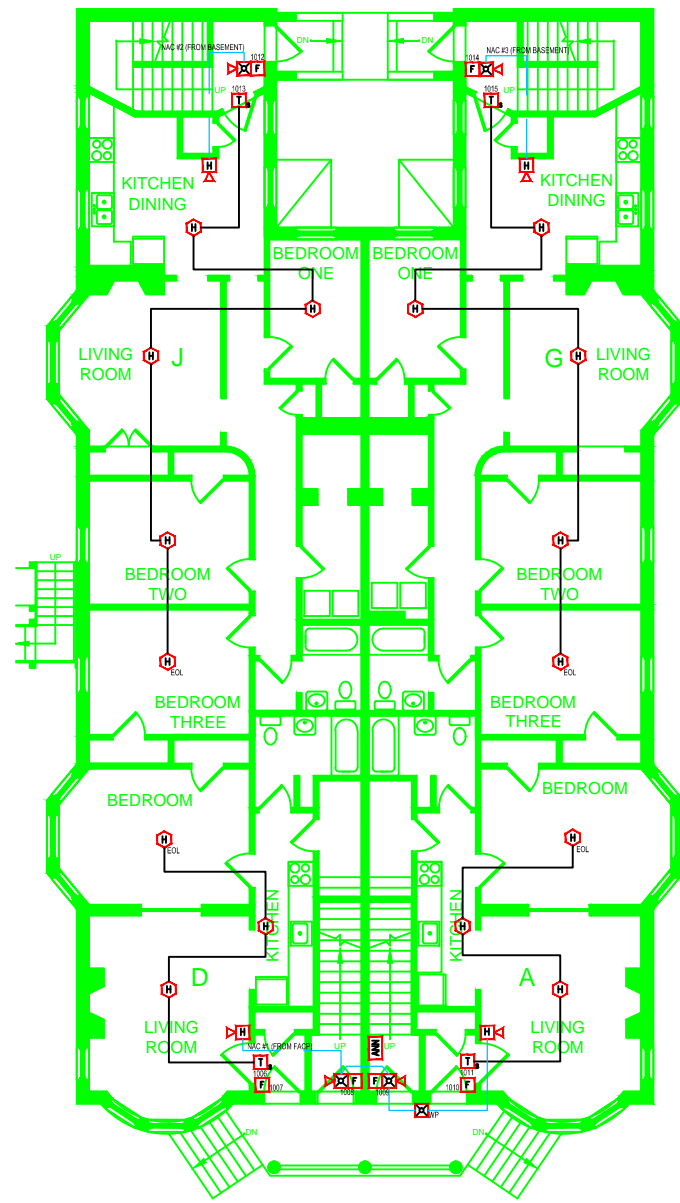

FIRE ALARM SYSTEM LAYOUT – FIRST FLOOR

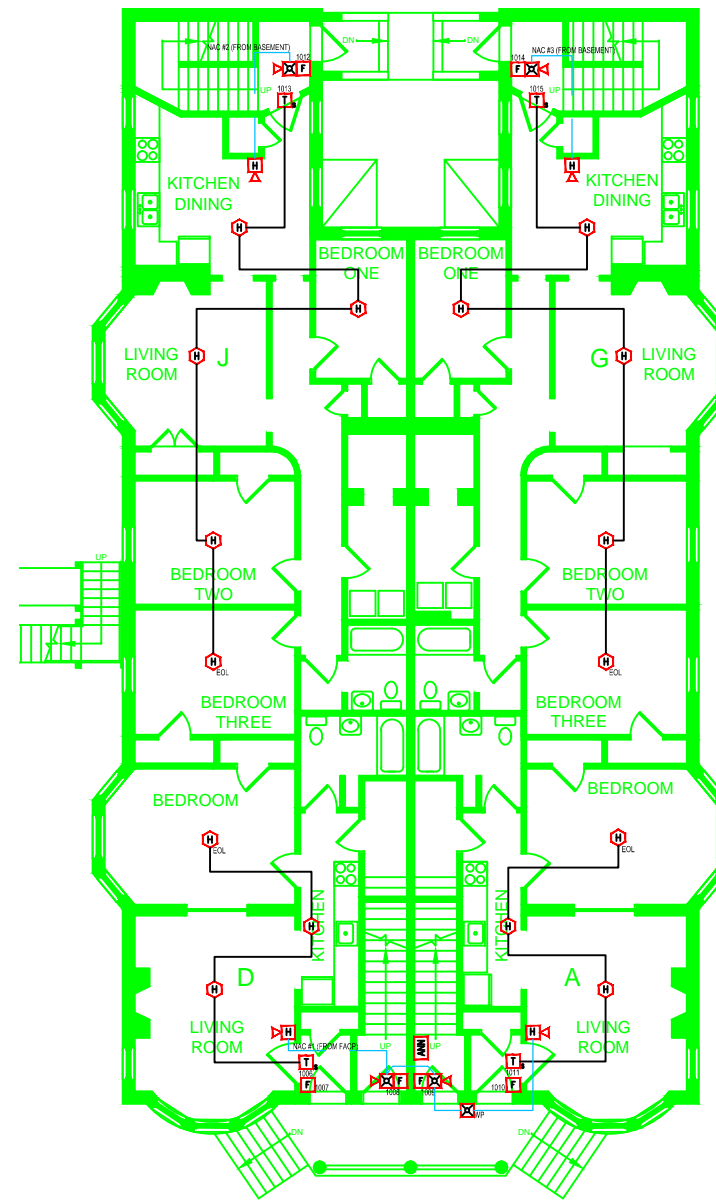

FIRE ALARM SYSTEM LAYOUT – FIRST FLOOR

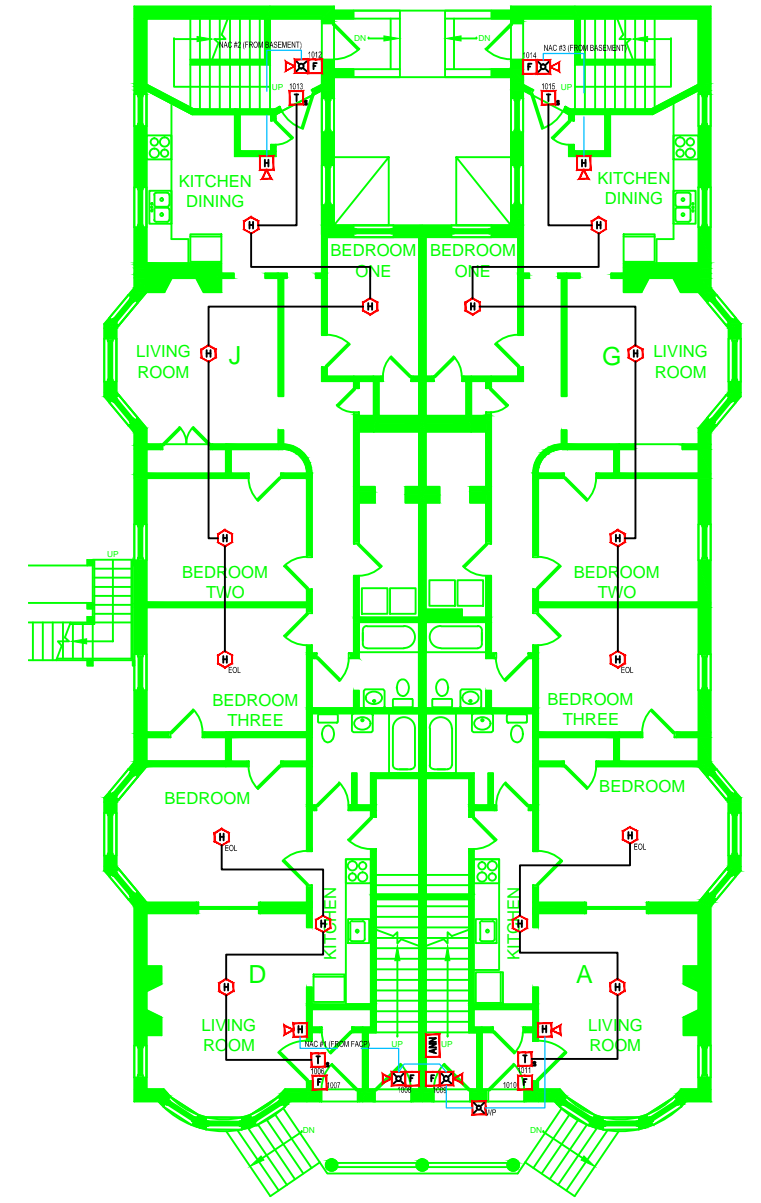

FIRE ALARM SYSTEM LAYOUT – FIRST FLOOR

GENERAL NOTES	DATE	REVISIONS	REQUIRED APPROVALS	CARLTON COURT 145 SPRING ST. PORTLAND, ME CONTRACT WITH: 	FIRE ALARM SYSTEM	
-SCOPE OF WORK: INSTALL NEW ADDRESSABLE FIRE ALARM SYSTEM. ALL INSTALLATION PRACTICES SHALL COMPLY WITH NFPA 70, 72 PHASE I: REPLACE CONTROL PANEL PHASE II: INSTALL NEW DEVICES PHASE II TO BE COMPLETED IMMEDIATELY AFTER PHASE I			OWNER			PLANS & DETAILS
			PORTLAND FIRE DEPARTMENT			DWG. NO. 1 OF 2
			DRAWN BY CRM CHECKED BY MLT CONTRACTOR LICENSE #			JOB NUMBER
					SCALE 1/16" = 1'	
					DATE 1/2/13	