


FIRE ALARM SYSTEM LAYOUT - BASEMENT
SCALE: 1/8"=1'

FIRE ALARM SYSTEM LAYOUT - FIRST FLOOR
SCALE: 1/8"=1'

FIRE ALARM SYSTEM LAYOUT - SECOND FLOOR
SCALE: 1/8"=1'



FIRE ALARM SYSTEM LAYOUT - THIRD FLOOR
SCALE: 1/8"=1'

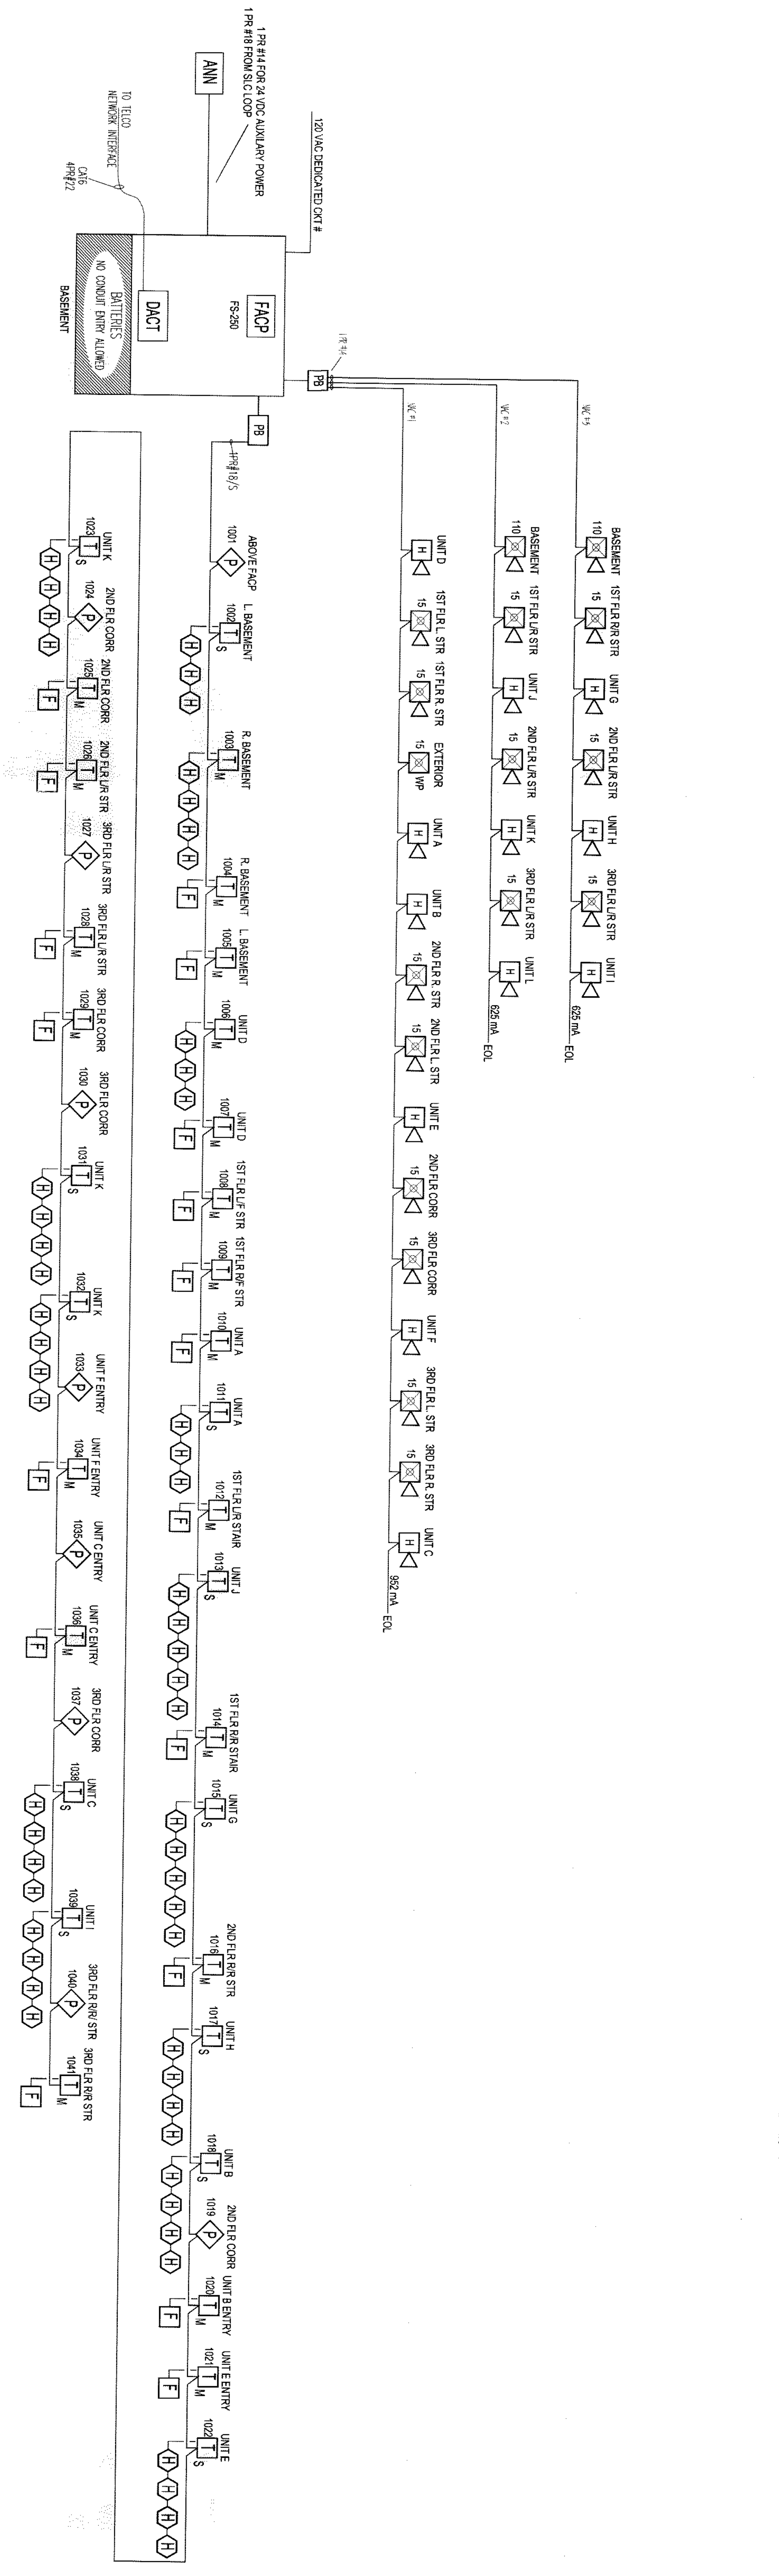

FIRE ALARM RISER DETAIL
SCALE: NTS

SYMBOL LEGEND

QUANT	SYMB	DESCRIPTION	MODEL	BACK BOX
1	1	FIRE ALARM CONTROL PANEL	FS-250	FACP
1	2	DIGITAL COMMUNICATOR	FS-DAC1	INCLUDED
1	3	REMOTE ANNUNCIATOR PANEL	FS-RO2	INCLUDED
5	4	CEILING SMOKE DETECTOR/BASE	D1-135F/HIR-M	SINGLE CANOE OR SMOKE BOX OR OCTAGON BOX
16	5	135 DEGREE THERMAL DETECTOR/BASE	MSW-HD/HIR-M	5 1/2" DEEP SINGLE GANG
12	6	MANUAL PULL STATION	HRM-S	4" SQUARE BOX
18	7	SINGLE INPUT MONITOR MODULE	HRM-M	4" SQUARE BOX
12	8	MINI MONITOR MODULE	HRM-M	4" SQUARE BOX
16	9	FIRE ALARM HORN	ZH-R	4" SQUARE
16	10	FIRE ALARM MULTI CANDELLA HORN/SIROBE	ZH-MC-R	4" SQUARE
1	11	EXTERIOR SIROBE		

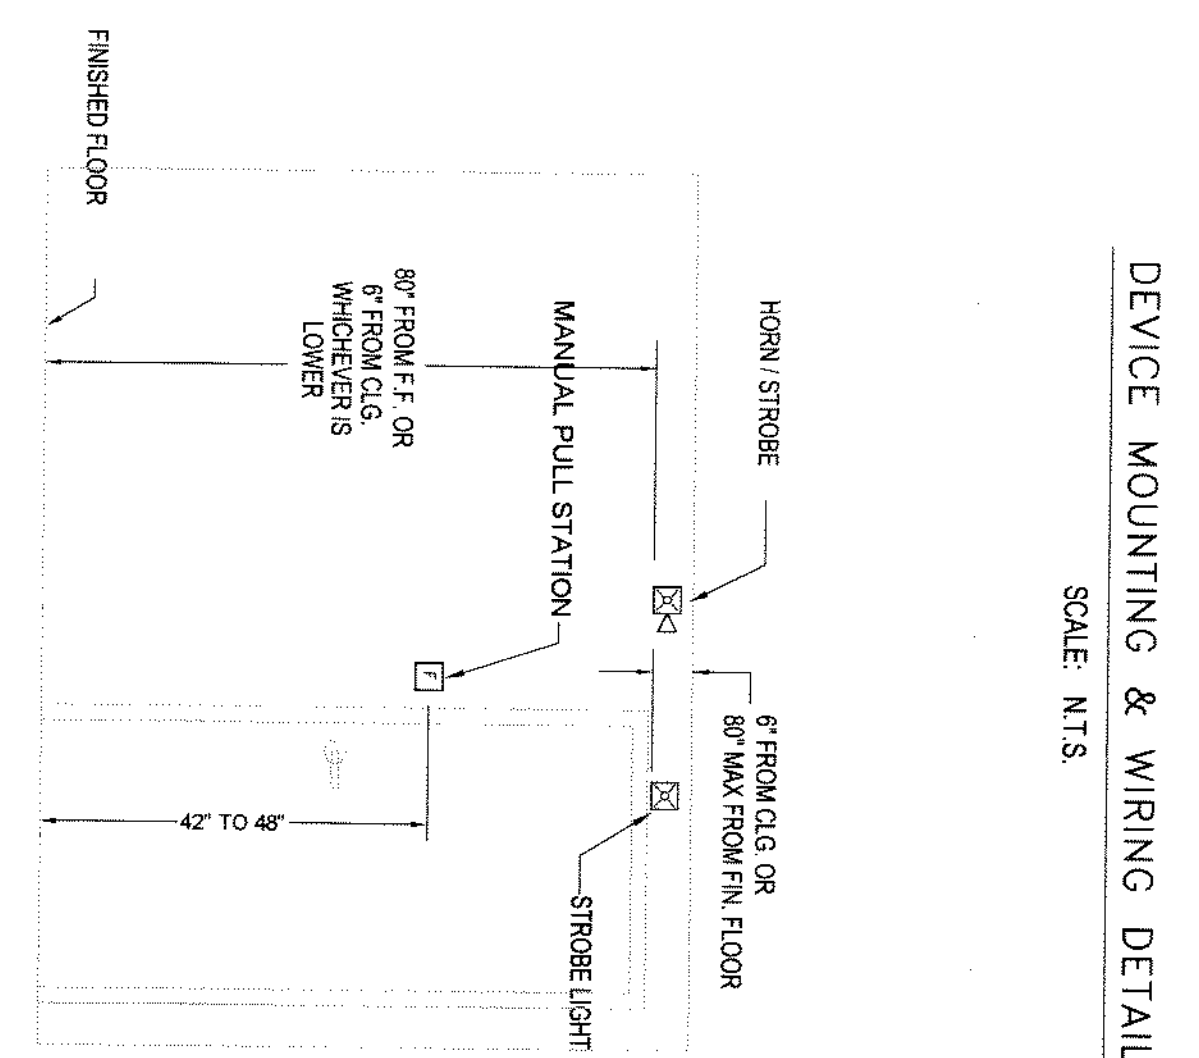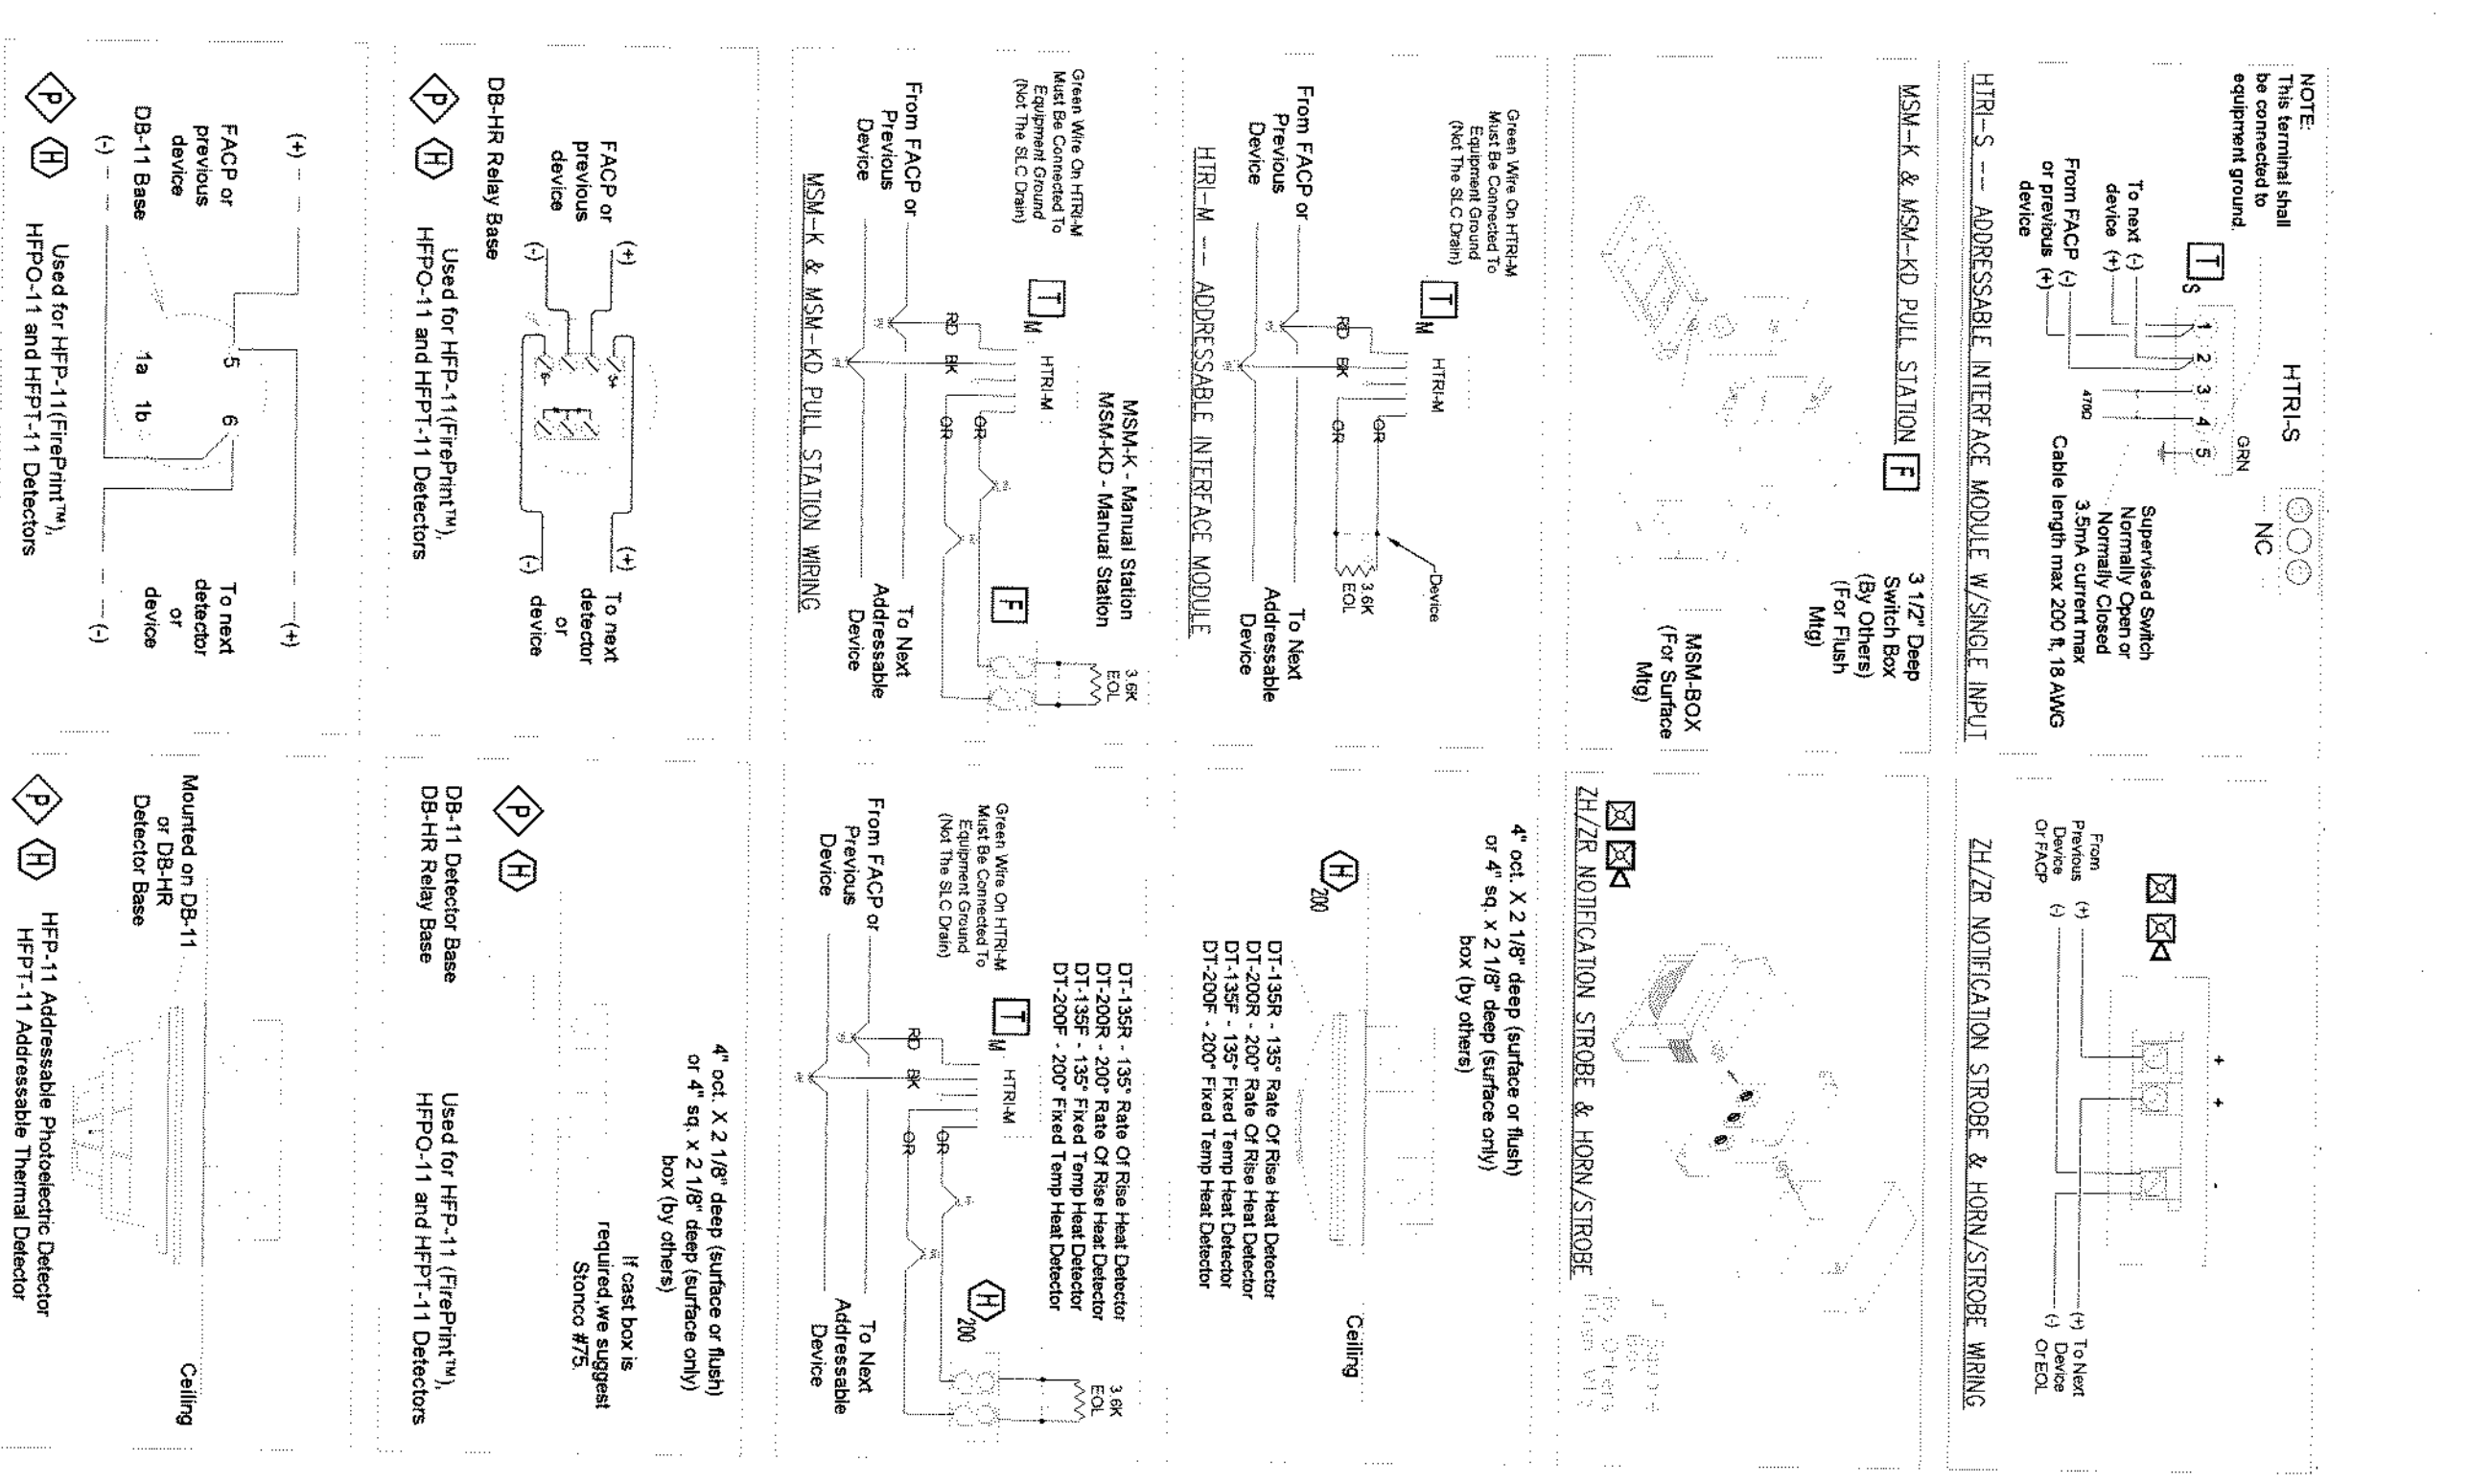

GENERAL NOTES

SCOPE OF WORK: INSTALL NEW ADDRESSABLE FIRE ALARM SYSTEM. ALL INSTALLATION PRACTICES SHALL COMPLY WITH NFPA 70, 72.

PHASE I: REPLACE CONTROL PANEL.

PHASE II: INSTALL NEW DEVICES.

PHASE III TO BE COMPLETED IMMEDIATELY AFTER PHASE I.

DATE	REVISIONS

REQUIRED APPROVALS

OWNER: CARLTON COURT
PORTLAND FIRE DEPARTMENT

DESIGNED BY: [Signature]
CHECKED BY: M.T.

CONTRACT WITH: EASTERN FIRE SERVICES, INC.

CONTRACT NO.: 146 SPRING ST
PORTLAND, ME

SCALE: AS SHOWN

