
 



APT. 1

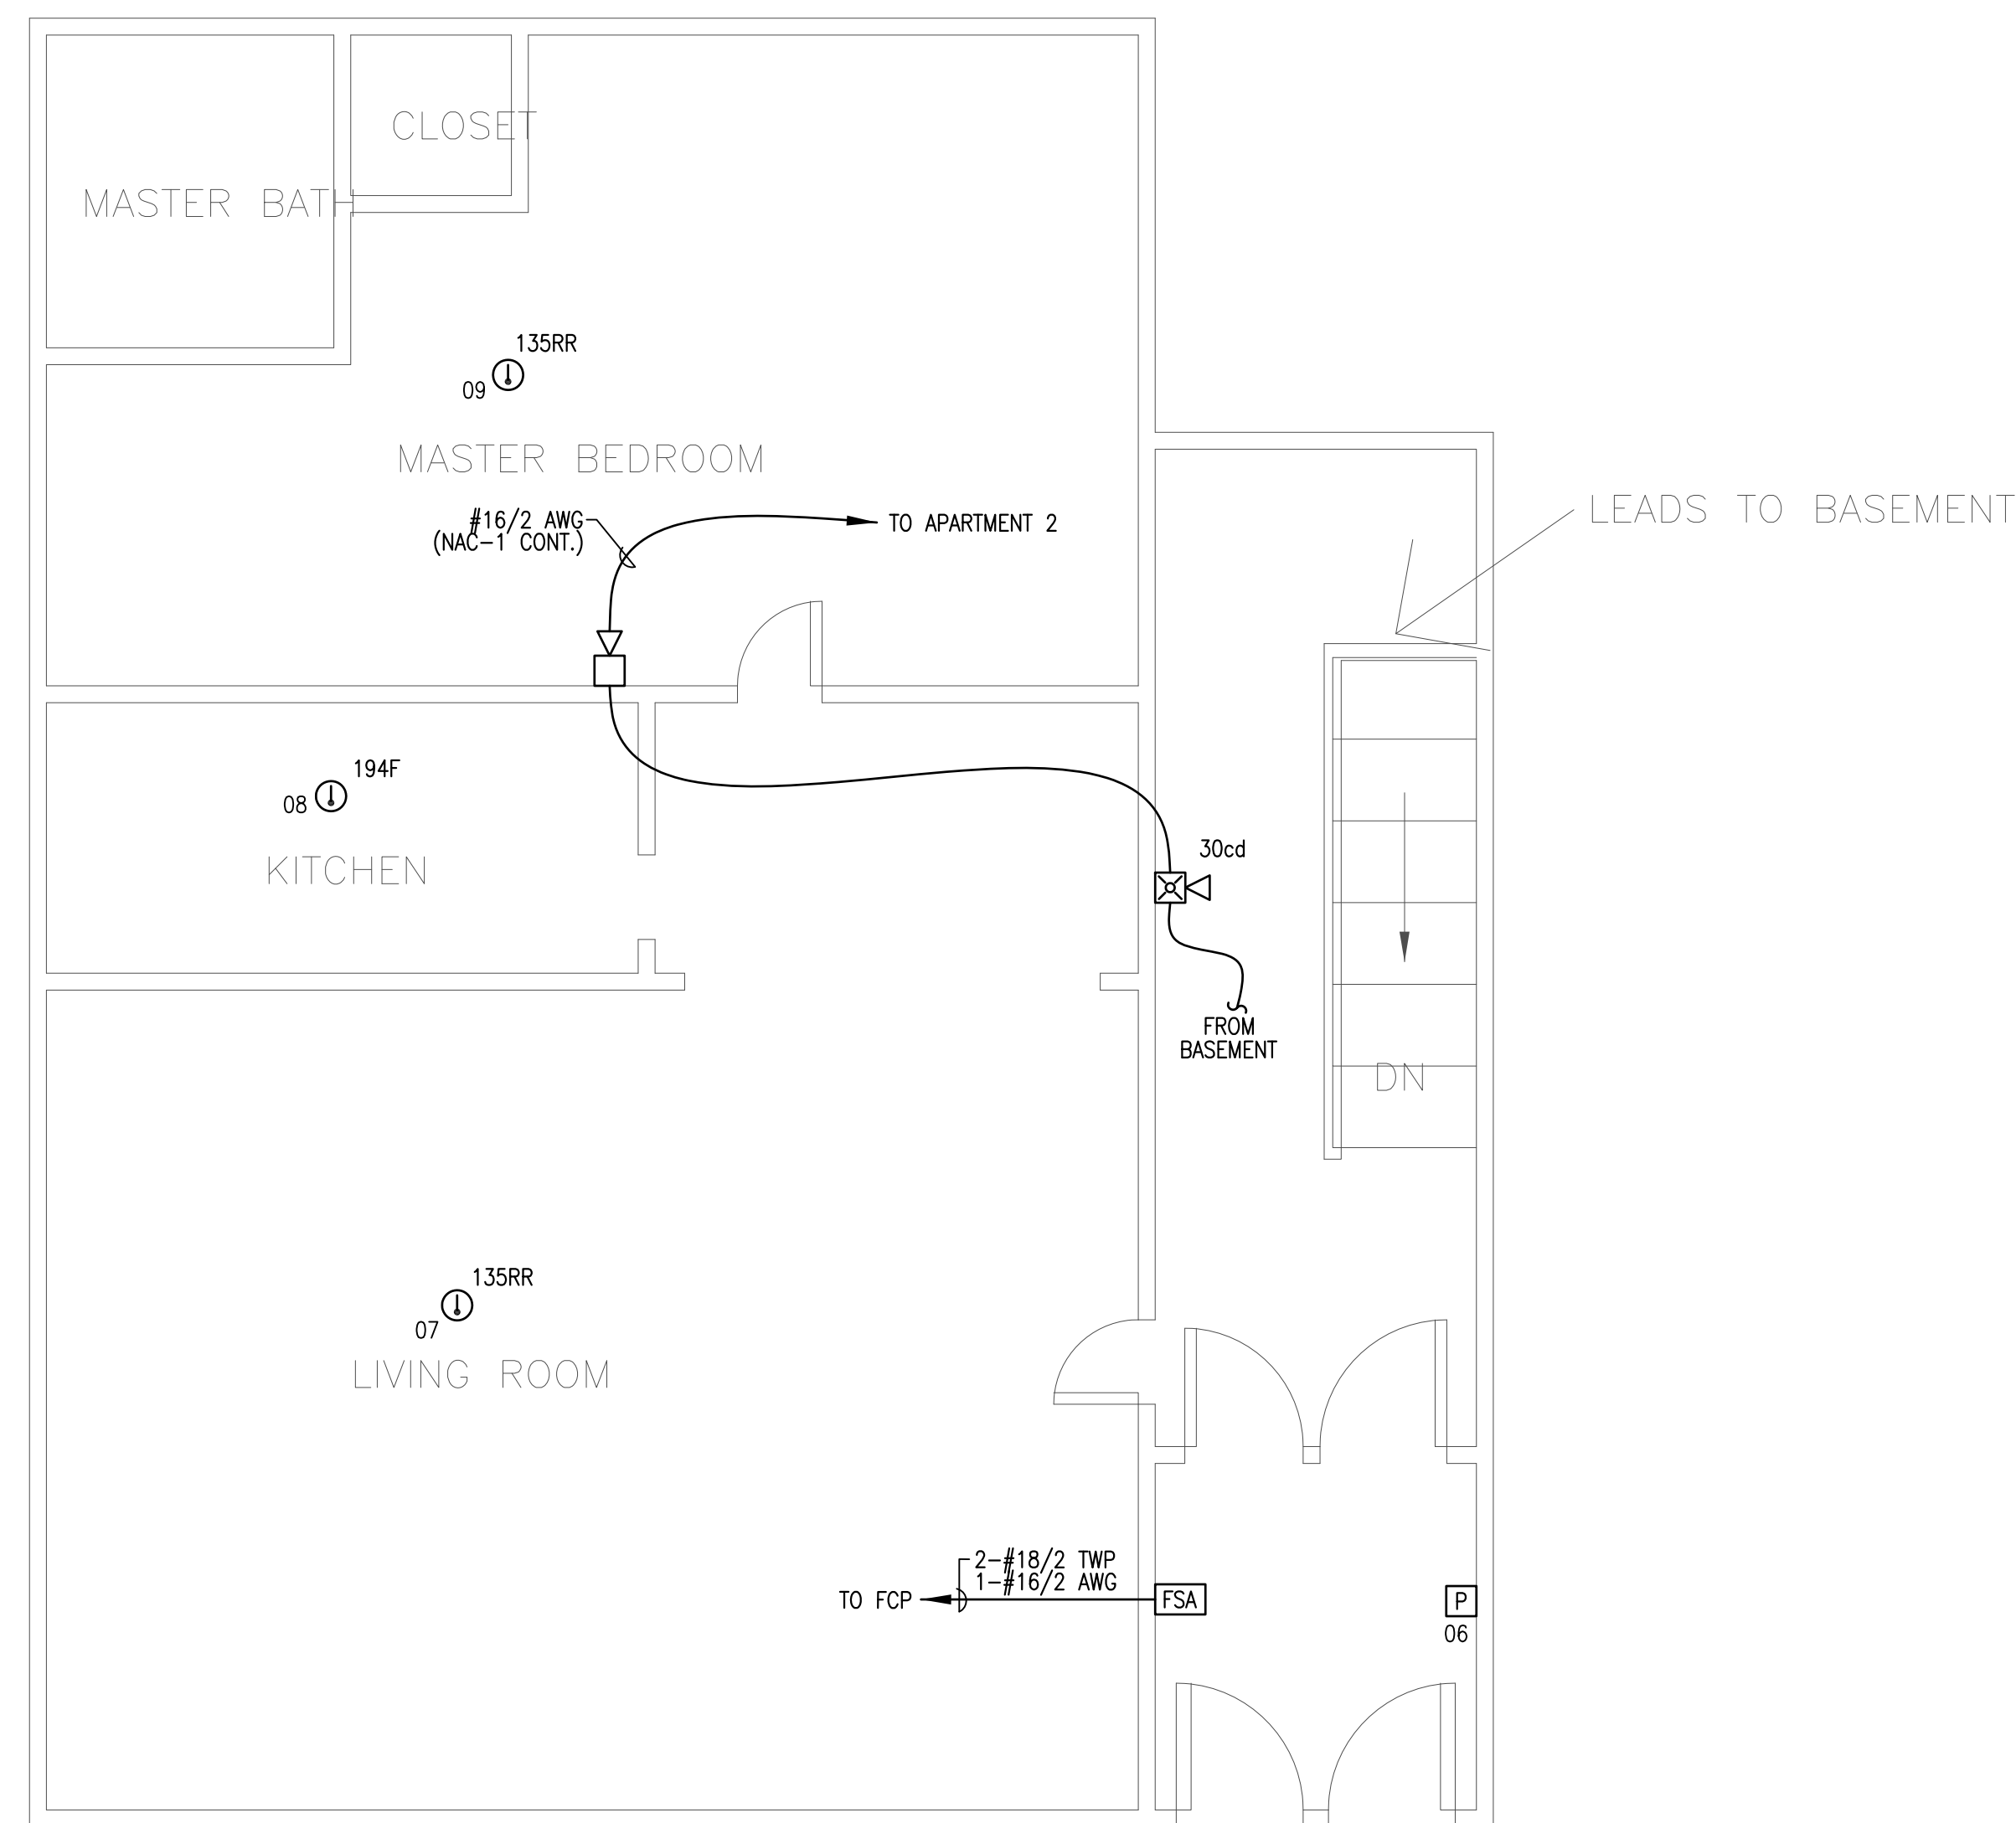


GROUND LEVEL APARTMENT 1 FIRE ALARM PLAN
SCALE: 1/4"=1'-0"



APT. 2

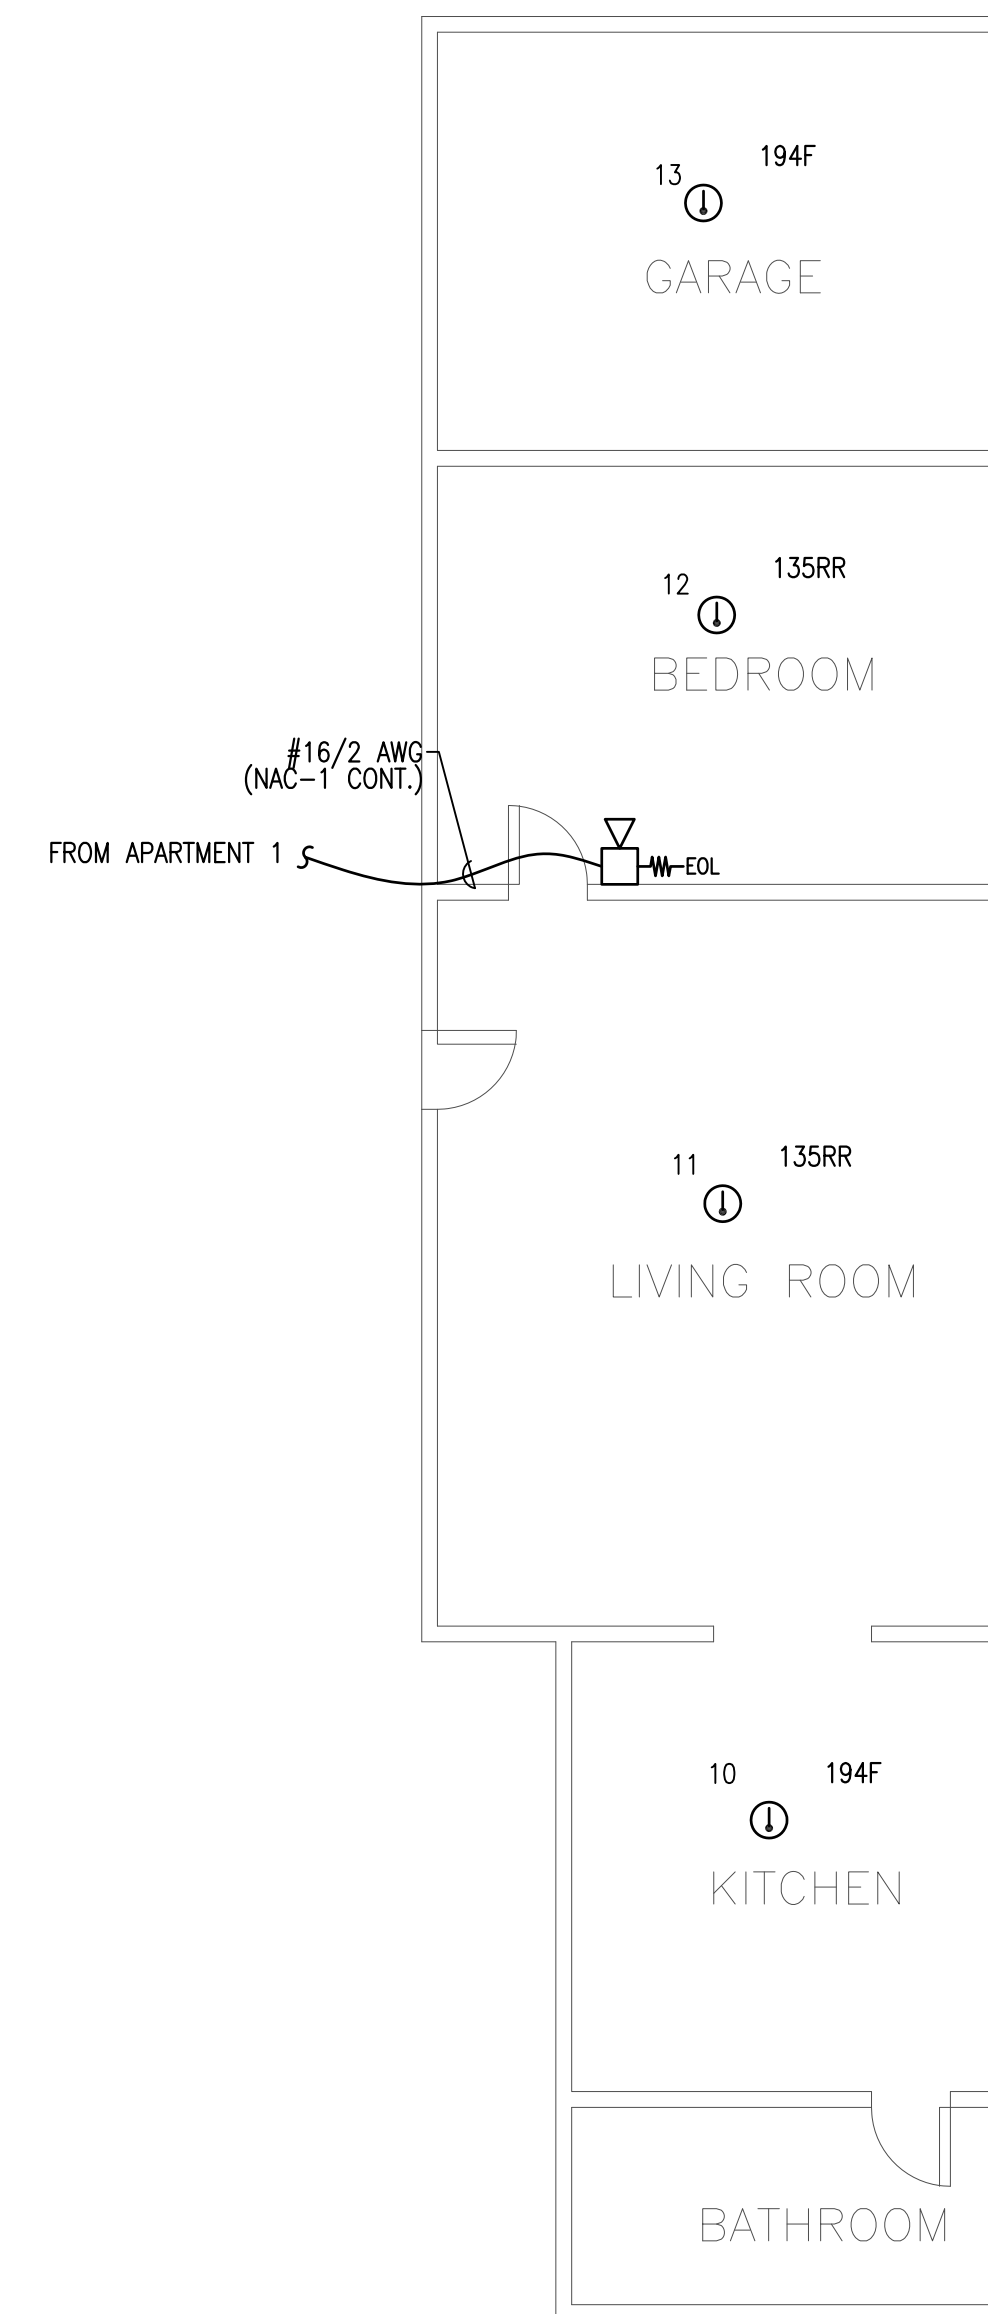

 GROUND LEVEL APARTMENT 2 FIRE ALARM PLAN
SCALE: 1/4"=1'-0"



RESERVED FOR CITY STAMP

REVISION	DESCRIPTION	DATE
0	ISSUED FOR REVIEW & APPROVAL	6/17/2015

SEACOAST SECURITY

4 Summer Street • Freeport, Maine 04032
Office: (207) 706-3369 • Fax: (207) 865-0852

112 PARK STREET LLC
APARTMENTS
PORTLAND, MAINE
FIRST FLOOR APARTMENTS 1 & 2 FIRE ALARM PLAN

DRAWN	TEE UNICAD JOB #15349
CHECKED	WAYNE B. HAWS NICET IV 90496
DATE	5/22/2015
REVISION	0
SCALE	1/4" = 1'-0"

SCALED MEASUREMENTS ARE APPROXIMATE AND ARE BASED ON 3RD PARTY FIELD SURVEY
Accurate locations of all walls, doors, structures, equipment, etc.;
their shape, size or square footage should all be verified.

NICET IV
Fire Alarm Systems

Wayne B. Haws
Wayne B. Haws / Signature
Date: 6/17/2015

Fire Protection Engineering
Technology
Fire Alarm Systems
Cert. No. 90496

shop drawings
created by
5784 W. 4600 St.
Hesper, UT 84315
Oftice: 801.985.0410

UNICAD Inc.
www.unicad.net Fire Alarm Design & Drafting Services

FA-3