



APT. 3 (LEVEL 1)

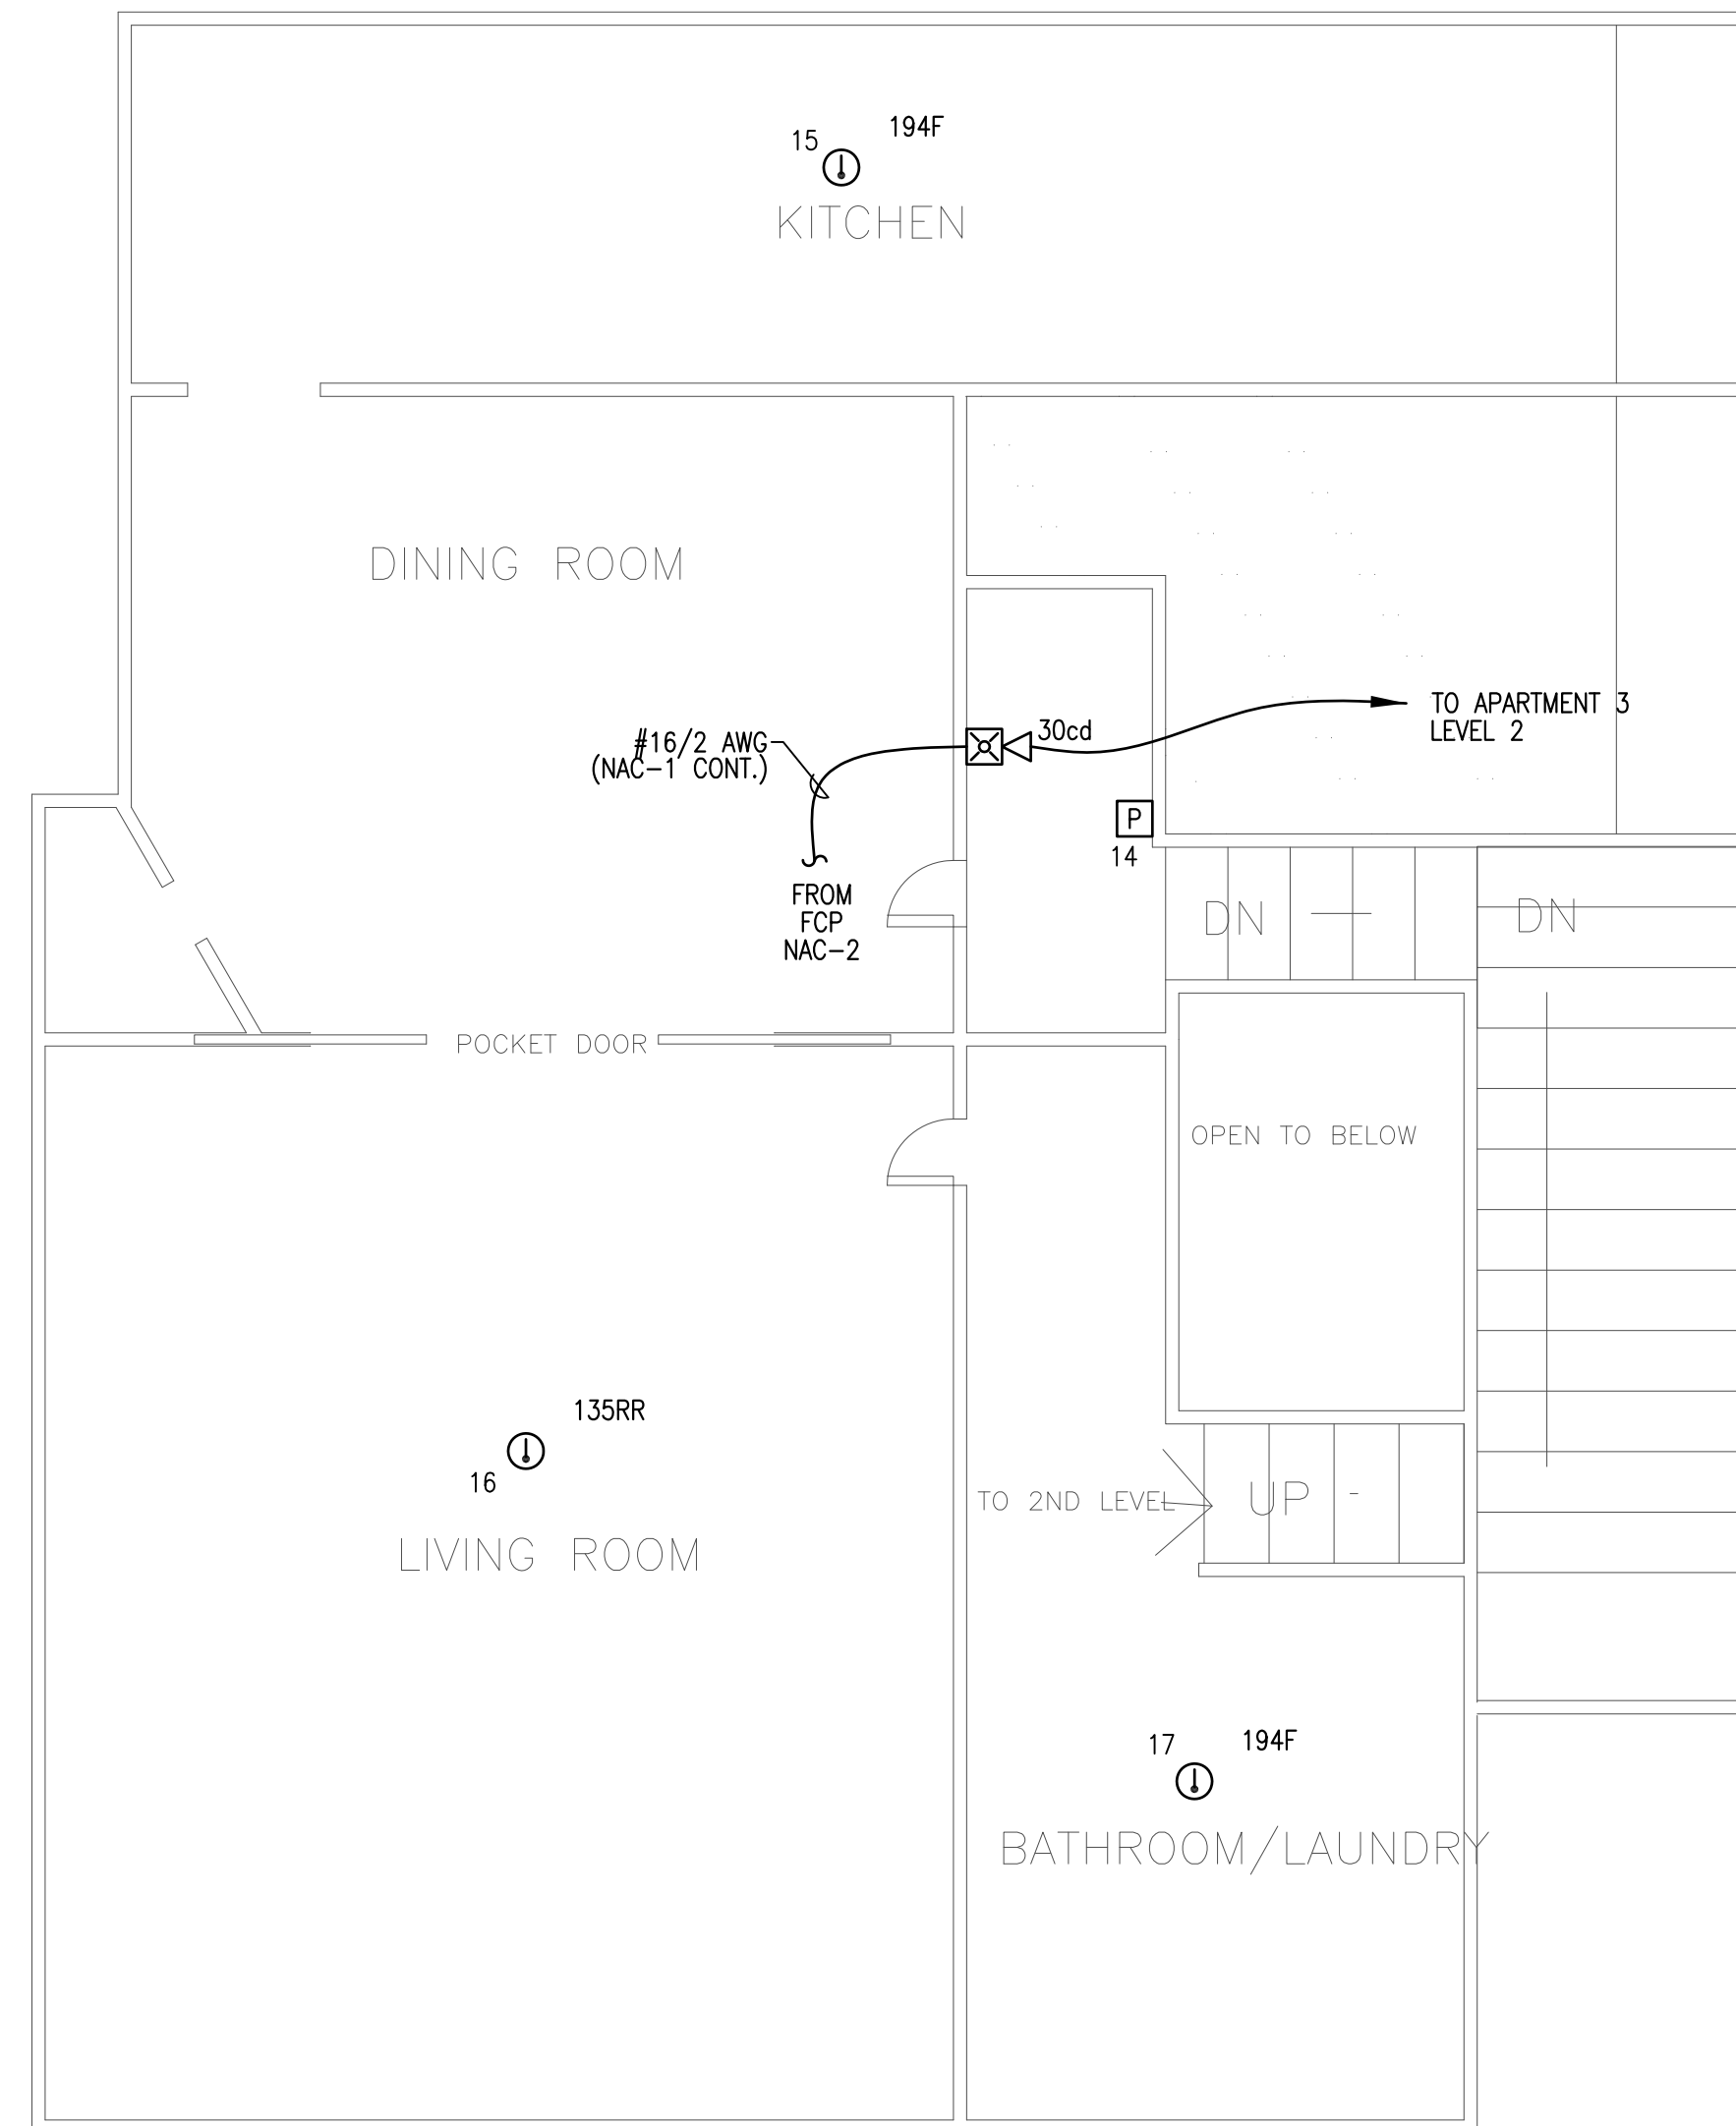

SECOND FLOOR LEVEL 1 FIRE ALARM PLAN  
SCALE: 1/4"=1'-0"

APT. 3 (LEVEL 2)

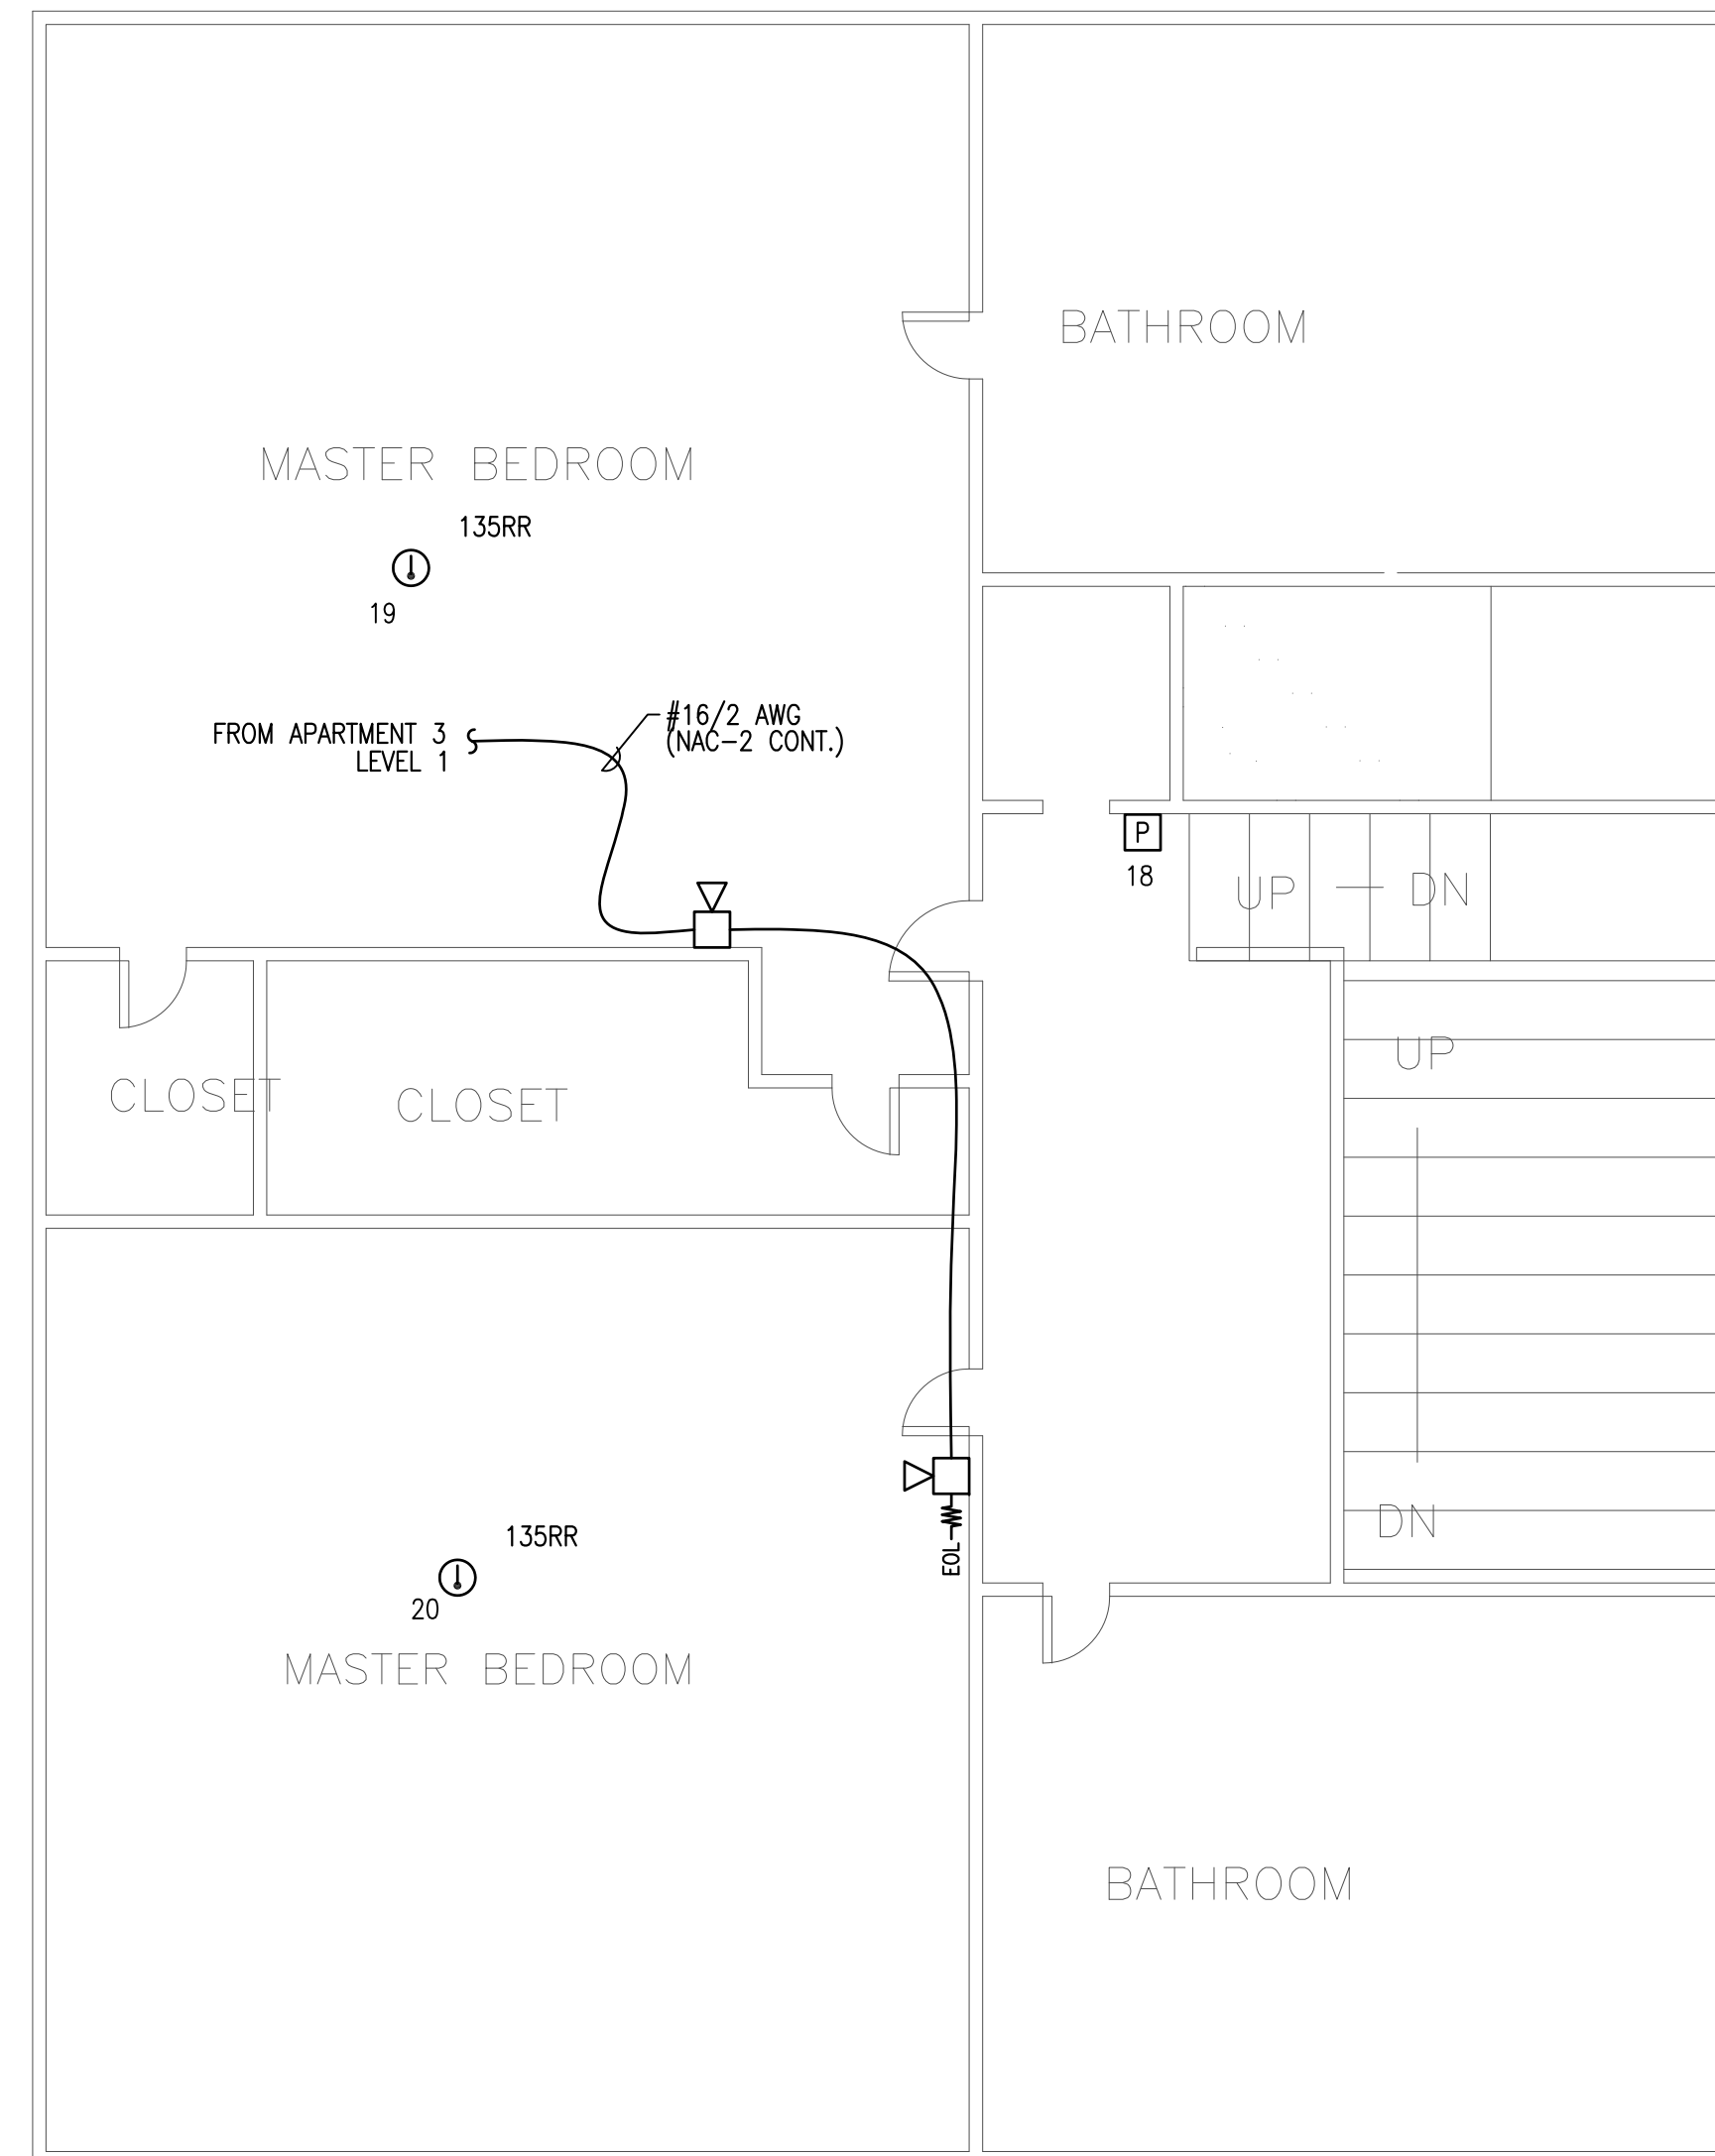

SECOND FLOOR LEVEL 2 FIRE ALARM PLAN  
SCALE: 1/4"=1'-0"

RESERVED FOR CITY STAMP

| REVISION | DESCRIPTION                  | DATE      |
|----------|------------------------------|-----------|
| 0        | ISSUED FOR REVIEW & APPROVAL | 6/17/2015 |
|          |                              |           |
|          |                              |           |
|          |                              |           |

**SEACOAST SECURITY**




4 Summer Street • Freeport, Maine 04032  
Office: (207) 706-3369 • Fax: (207) 865-0852

112 PARK STREET LLC  
APARTMENTS  
PORTLAND, MAINE  
SECOND FLOOR LEVEL 1 & 2 FIRE ALARM PLAN

|          |                                 |
|----------|---------------------------------|
| DRAWN    | TEE<br>UNICAD JOB #15349        |
| CHECKED  | WAYNE B. HAWS<br>NICET IV 90496 |
| DATE     | 5/22/2015                       |
| REVISION | 0                               |
| SCALE    | 1/4" = 1'-0"                    |

SCALED MEASUREMENTS ARE APPROXIMATE AND ARE BASED ON 3RD PARTY FIELD SURVEY  
Accurate locations of all walls, doors, structures, equipment, etc.;  
their shape, size or square footage should all be verified.

NICET IV  
Fire Alarm Systems

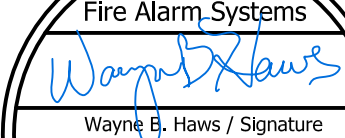

Wayne B. Haws / Signature  
Date: 6/17/2015  
Fire Protection Engineering  
Technology  
Fire Alarm Systems  
Cert. No. 90496

shop drawings  
created by  
5784 W. 4600 St.  
Hesper, UT 84215  
OFFICE: 801.985.0410  
www.unicad.net

**UNICAD** Inc.  
Fire Alarm Design & Drafting Services

FA-4