


APT. 5

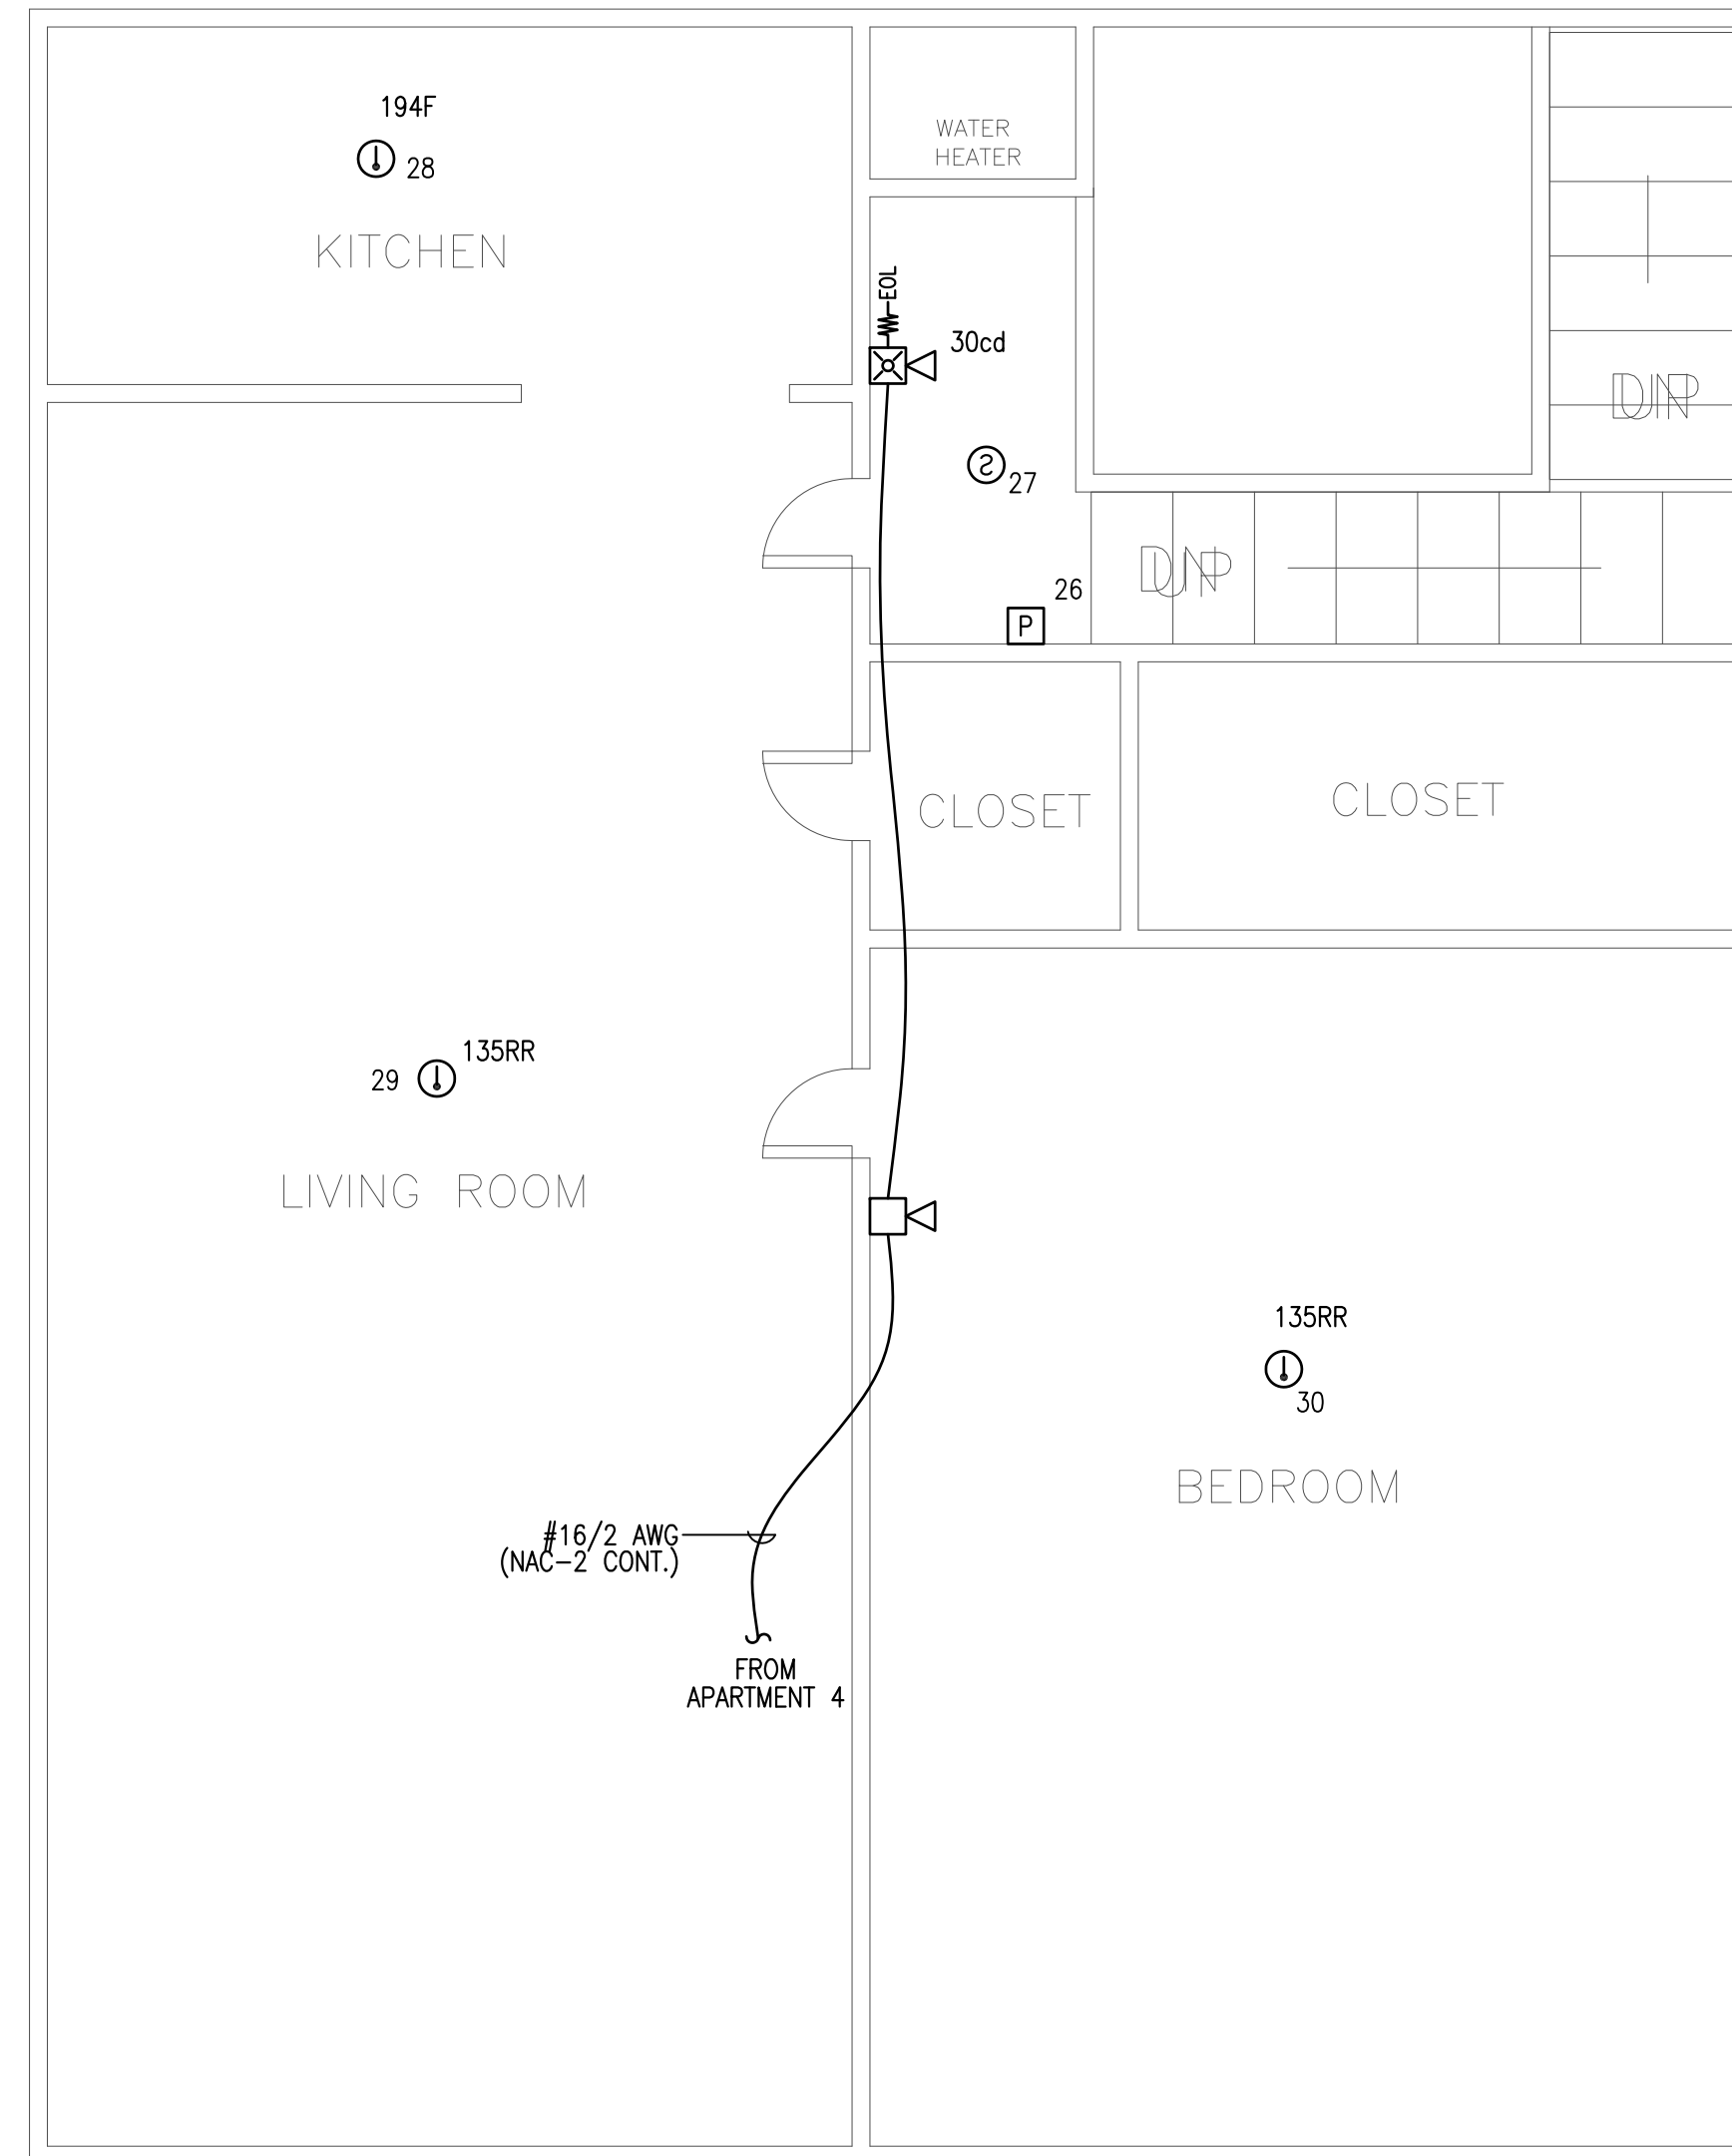

FIFTH FLOOR APARTMENT 5 FIRE ALARM PLAN  
SCALE: 1/4"=1'-0"

RESERVED FOR CITY STAMP

REVISION	DESCRIPTION	DATE
0	ISSUED FOR REVIEW & APPROVAL	6/17/2015

**SEACOAST SECURITY**



4 Summer Street • Freeport, Maine 04032  
Office: (207) 706-3369 • Fax: (207) 865-0852

112 PARK STREET LLC  
APARTMENTS  
PORTLAND, MAINE  
FIFTH FLOOR APARTMENT 5 FIRE ALARM PLAN

DRAWN	TEE UNICAD JOB #15349
CHECKED	WAYNE B. HAWS NICET IV 90496
DATE	5/22/2015
REVISION	0
SCALE	1/4" = 1'-0"

SCALED MEASUREMENTS ARE APPROXIMATE AND ARE BASED ON 3RD PARTY FIELD SURVEY  
Accurate locations of all walls, doors, structures, equipment, etc.;  
their shape, size or square footage should all be verified.

NICET IV  
Fire Alarm Systems

*Wayne B. Haws*  
Wayne B. Haws / Signature  
Date: 6/17/2015

Fire Protection Engineering  
Technology  
Fire Alarm Systems  
Cert. No. 90496

shop drawings  
created by  
5784 W. 4600 St.  
Hesper, UT 84215  
Oftex: 801.985.0410

**UNICAD** Inc.  
www.unicad.net Fire Alarm Design & Drafting Services

FA-6