


DEVICE MOUNTING & WIRING DETAIL  
SCALE: N.T.S.

FIRE ALARM SYSTEM RISER DETAIL  
SCALE: N.T.S.

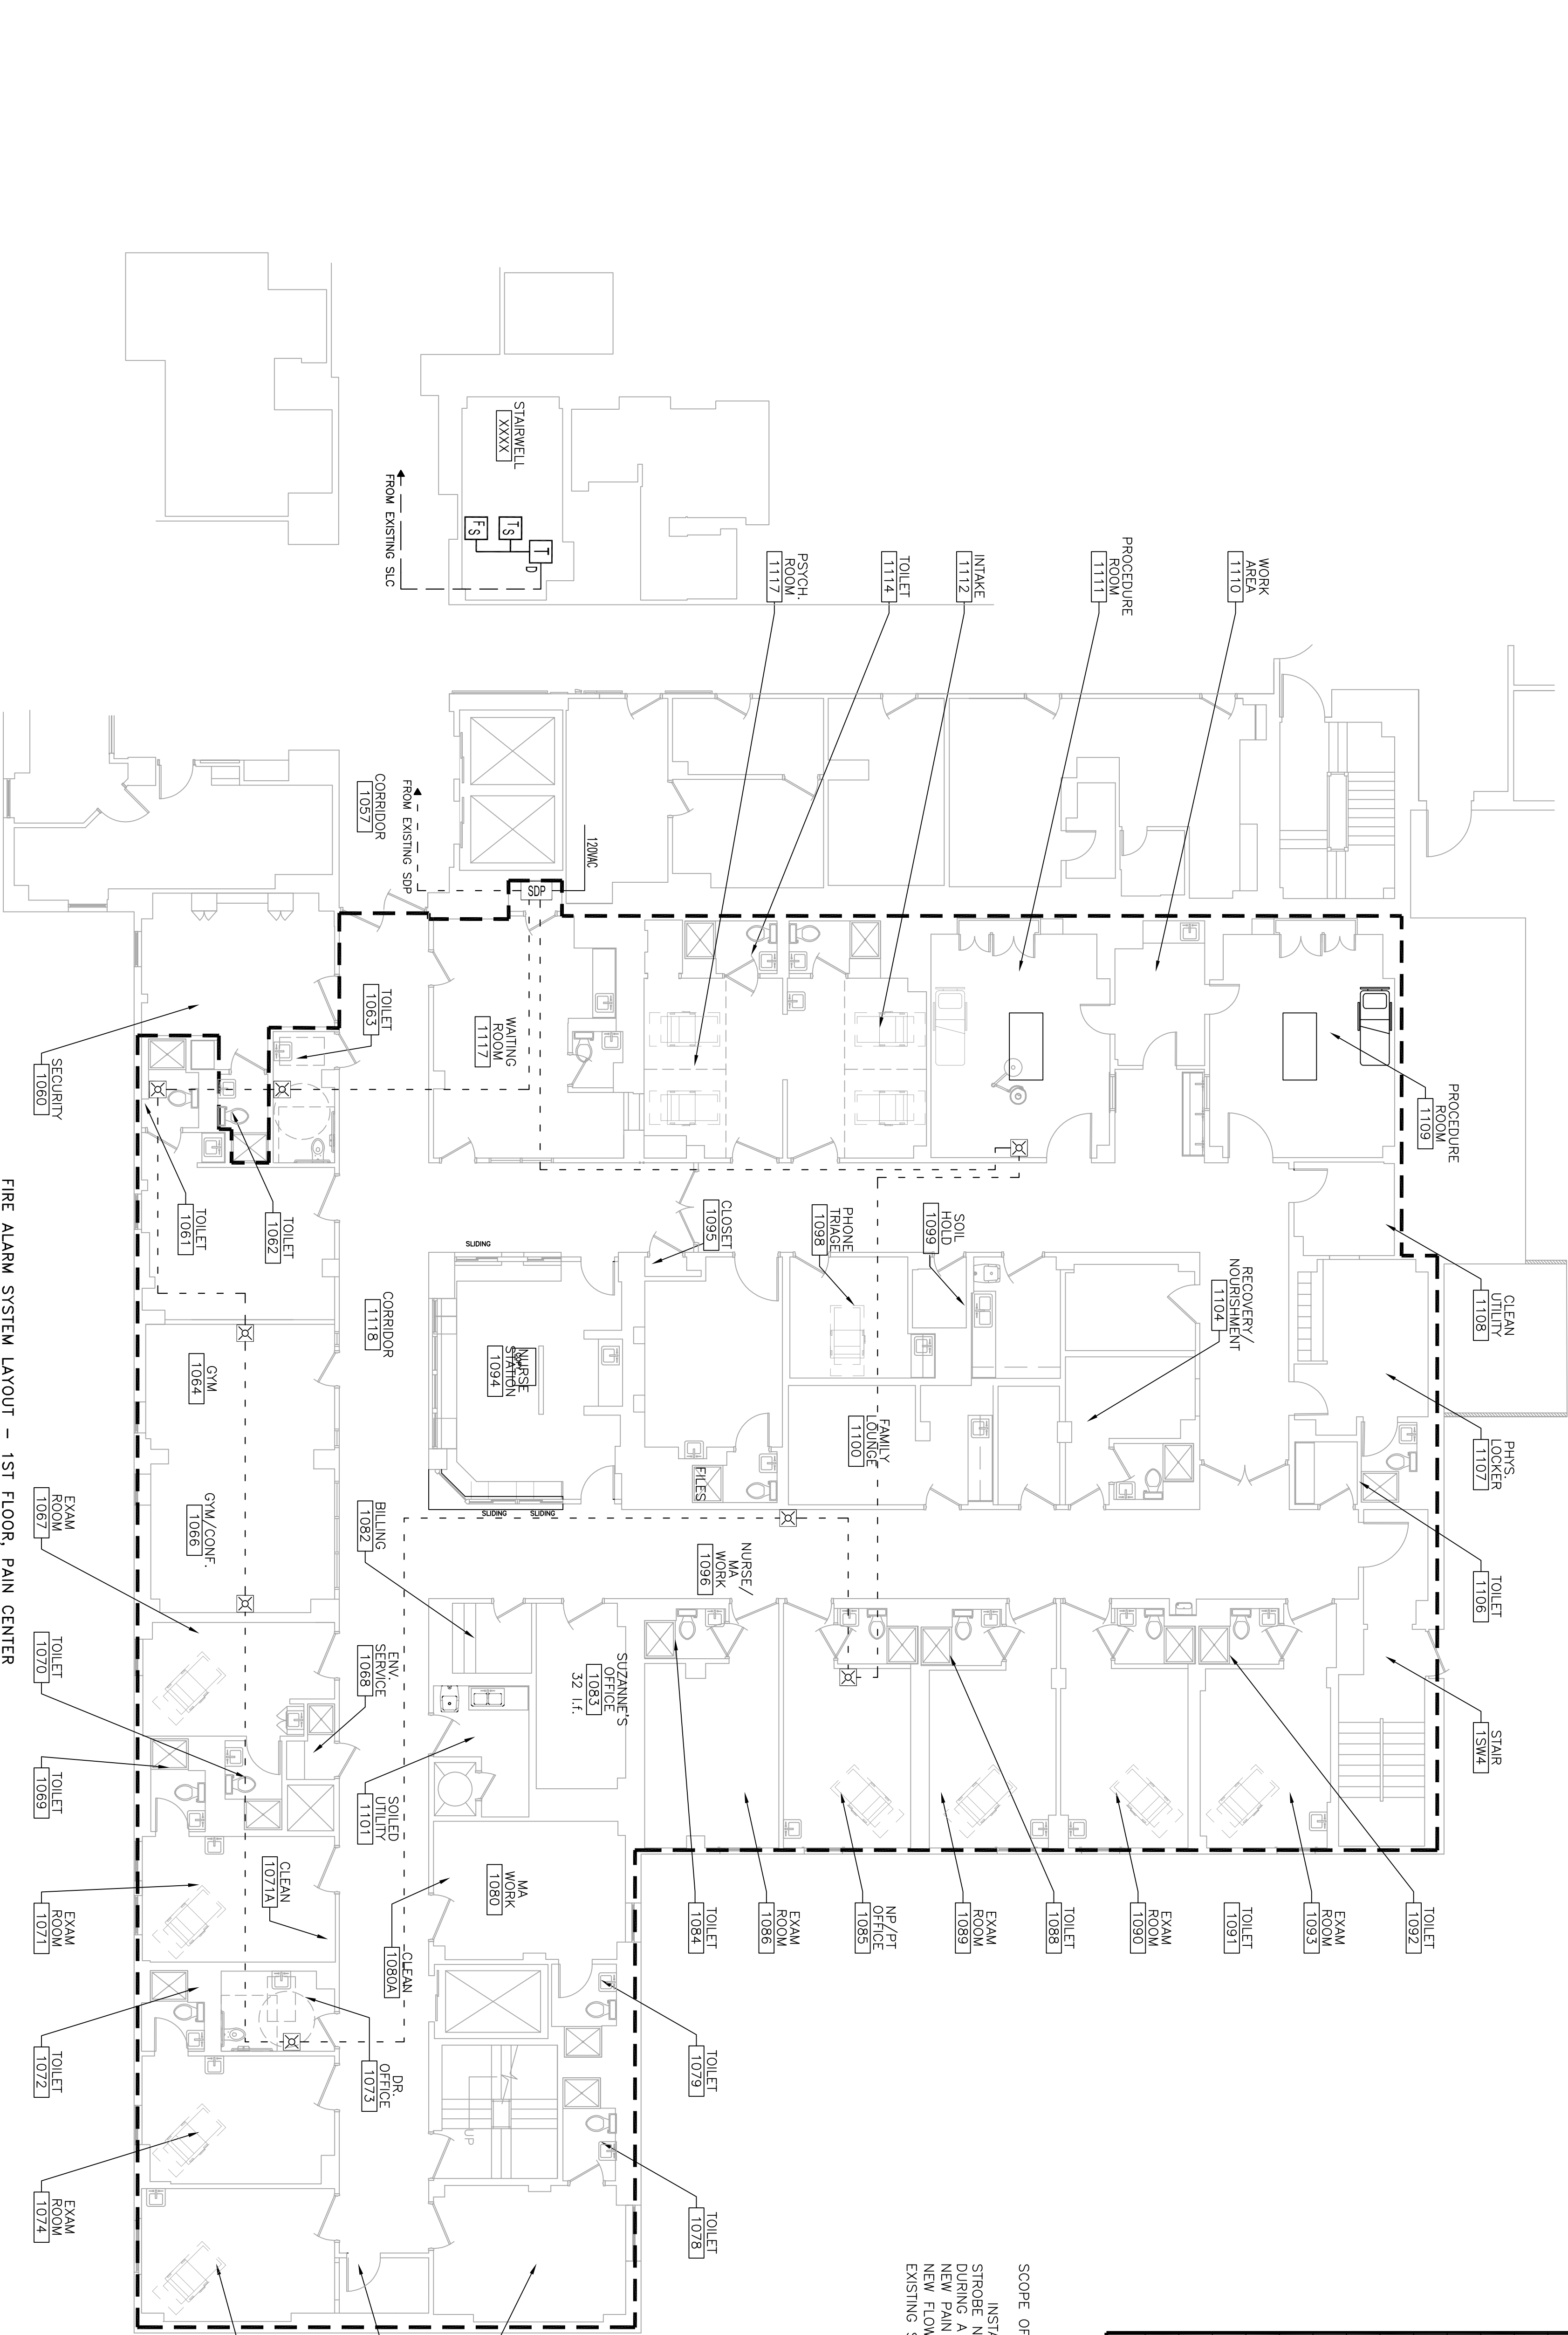

FIRE ALARM SYSTEM LAYOUT - 1ST FLOOR, PAIN CENTER  
SCALE: N.T.S.

DEVICE LEGEND					
ITEM	QTY	SYM	ITEM	P/N	NOTE
1	0	FACP	FIRE ALARM CONTROL PANEL	FS-250	
2	0	FANN	FIRE ALARM ANNUNCIATOR	FS-802	
3	1	SDP	SIGNAL DRIVER PANEL	PD-3	
4	0	F	MANUAL PULL STATION	HMS-D	
5	0	P	SMOKE DETECTOR	HP-11	
6	0	P-D	DUCT SMOKE DETECTOR		
7	0	H	HEAT DETECTOR	HPH-11	
8	0	I-M	SINGLE INPUT INTERFACE MINI MODULE	HRM-M	
9	1	I-D	DUAL INPUT INTERFACE MODULE	HRM-D	
10	0	I-S	SINGLE INPUT INTERFACE MODULE	HRM-S	
11	0	I-R	SINGLE INPUT INTERFACE MODULE WITH RELAY	HRM-R	
12	0	ZH-W-R	HRM/STROBE	ZH-W-R	
13	8	S	STROBE		
14	1	TS	TAMPER SWITCH	FA0	
15	1	FS	FLOW SWITCH	FA0	
16	0	PB	PULL BOX	FA0	
17	0	CA	CLEAN AGENT		
18	0	PA	PRE-ACTION		
19	0	FSD	FAN SHUT DOWN		
20	0	TSM	TEST SWITCH MODULE		
21	0	R	REMOTE LAMP		
22					
23					
24					
25					

SCOPE OF WORK:  
INSTALL NEW SIGNAL DRIVER PANEL AND NEW STROBE NOTIFICATION APPLIANCES TO ACTIVATE DURING A GENERAL ALARM AND TO ACCOMMODATE NEW PAIN CENTER FLOOR PLAN. ALSO, CONNECT NEW FLOW AND TAMPER SWITCHES (BY OTHERS) TO EXISTING SIGNALING LINE CIRCUIT (SLC).

REQUIRED APPROVALS

CONTRACTOR/ENGINEER  
PORTLAND BLDG INSPECTIONS

DRAWN BY: DRS

CHECKED BY: BWB

PROJECT:  
**MERCY HOSPITAL  
PAIN CENTER  
RENOVATIONS**  
144 STATE STREET  
PORTLAND, MAINE

FIRE ALARM CONTRACTOR:  
**EASTERN FIRE SERVICES, INC.**  
AUBURN/LEWISTON INDUSTRIAL AIRPARK, AUBURN, MAINE 04210  
170 KITHURK AVENUE, P.O. BOX 190  
Phone: (207)84-507 Fax: (207)82-0986

CONTRACT WITH: OWNER

DWG. NO. **FA-1**  
JOB NUMBER EFSFA46140  
SCALE N.T.S.  
DATE 8/11/11