


DEMOLITION KEY NOTES:

- 1 REMOVE FAN COIL, ASSOCIATED PIPING, CONTROLS, AND CONDENSING UNIT ON ROOF IN ITS ENTIRETY. RE-CLAIM REFRIGERANT AS REQUIRED. PREPARE CONDENSATE DRAIN FOR NEW FAN COIL UNITS.

LEGEND - ABBREVIATIONS

- (E) EXISTING
- (R) REMOVE
- (REL) RELOCATE
- LIMIT OF REMOVAL
- ⊕ CONNECT TO EXISTING
- ↔ MEDICAL VACUUM INLET
- ↔ MEDICAL AIR OUTLET
- - - DEMOLITION
- EXISTING
- NEW

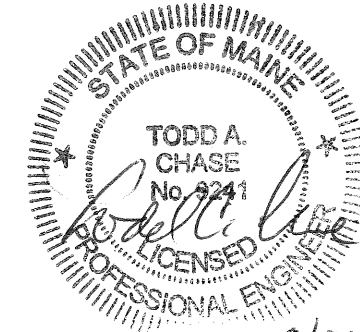

8/31/12

144 Fore Street/P.O. Box 618
Portland, Maine 04104
tel. (207) 772-3846
fax. (207) 772-1070
www.smrinc.com

ARCHITECTURE
ENGINEERING
PLANNING
INTERIOR DESIGN
COMMISSIONING

SMART

**MERCY HOSPITAL
IR EQUIPMENT REPLACEMENT
PORTLAND, MAINE**

ISSUED FOR DEMOLITION	8-31-12	DATE
CURRENT ISSUE STATUS:		
0	ISSUED FOR DEMOLITION	8-31-12
REV	DESCRIPTION	DATE

SCALE: 1/4"=1'-0"

PROJECT MANAGER: KD

IC/DRAWN BY: MBD

A/E OF RECORD: KD

CAD FILE: MD100-12076


PROJECT NO: 12076

DATE: 8-31-12

SHEET TITLE:
HVAC
DEMOLITION PLAN

SHEET No. MD100

© COPYRIGHT 2012 SMRT INC.

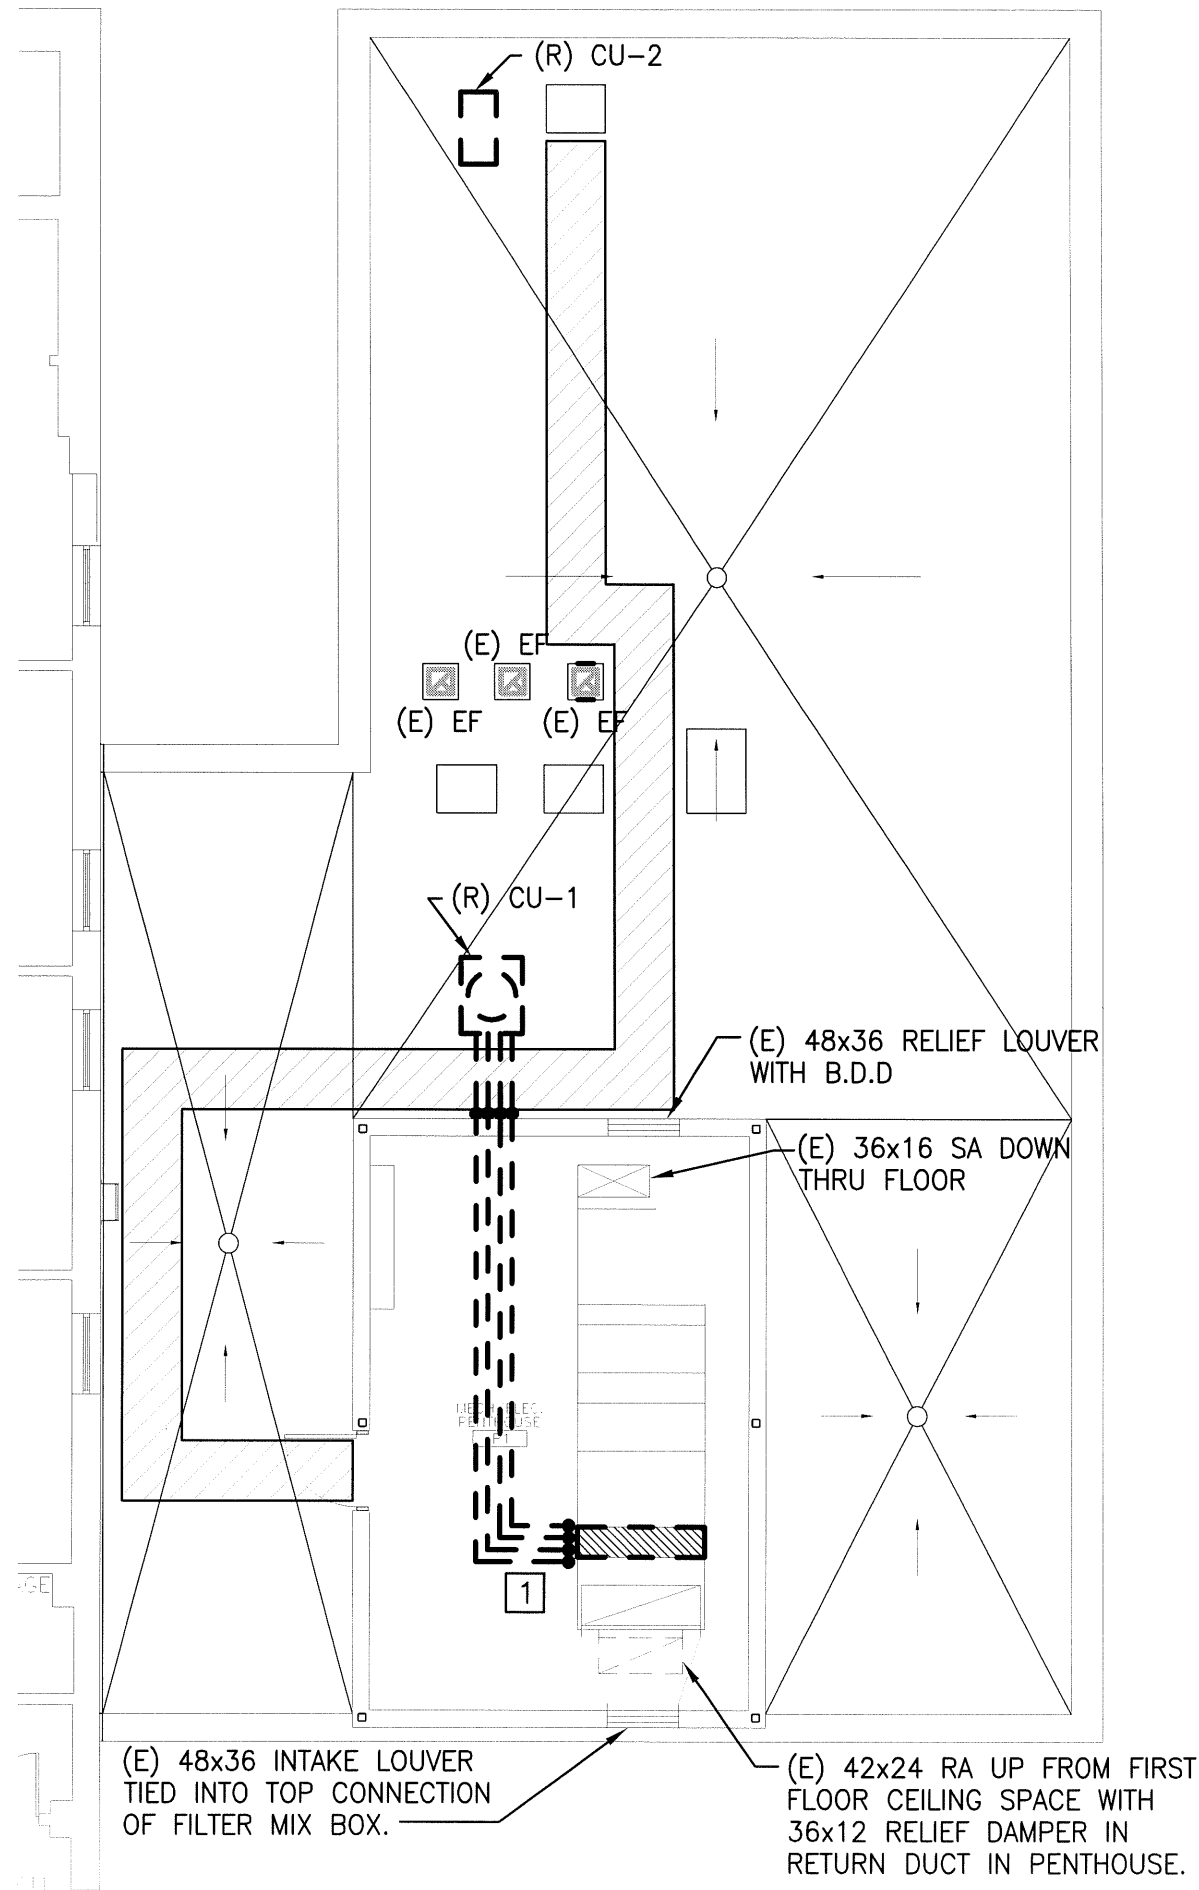


DEMOLITION KEY NOTES:

- 1 REMOVE EXISTING DX COIL, ASSOCIATED PIPING, AND CONDENSING UNIT IN ITS ENTIRETY. RECLAIM REFRIGERANT AS REQUIRED.

LEGEND—ABBREVIATIONS

- (E) EXISTING
- (R) REMOVE
- (REL) RELOCATE
- LIMIT OF REMOVAL
- CONNECT TO EXISTING
- MEDICAL VACUUM INLET
- MEDICAL AIR OUTLET
- DEMOLITION
- EXISTING
- NEW

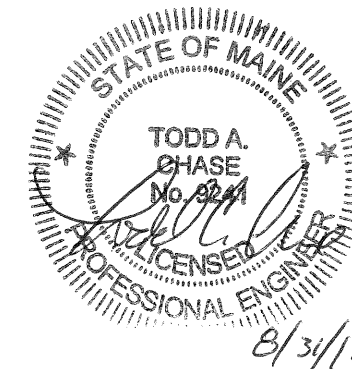

144 Fore Street/P.O. Box 618
Portland, Maine 04104
tel. (207) 772-3846
fax. (207) 772-1070
www.smrtinc.com

ARCHITECTURE
ENGINEERING
PLANNING
INTERIOR DESIGN
COMMISSIONING

SMRT

MERCY HOSPITAL
IR EQUIPMENT REPLACEMENT
PORTLAND, MAINE

ISSUED FOR DEMOLITION
8-31-12


CURRENT ISSUE STATUS:

REV	DESCRIPTION	DATE
0	ISSUED FOR DEMOLITION	8-31-12

SCALE:	1/8"=1'-0"
PROJECT MANAGER:	KD
JC/DRAWN BY:	MBD
A/E OF RECORD:	KD
CAD FILE:	MD101-12076
PROJECT NO:	12076
DATE:	8-31-12

SHEET TITLE:
HVAC DEMOLITION
ROOF PLAN

SHEET No. MD101

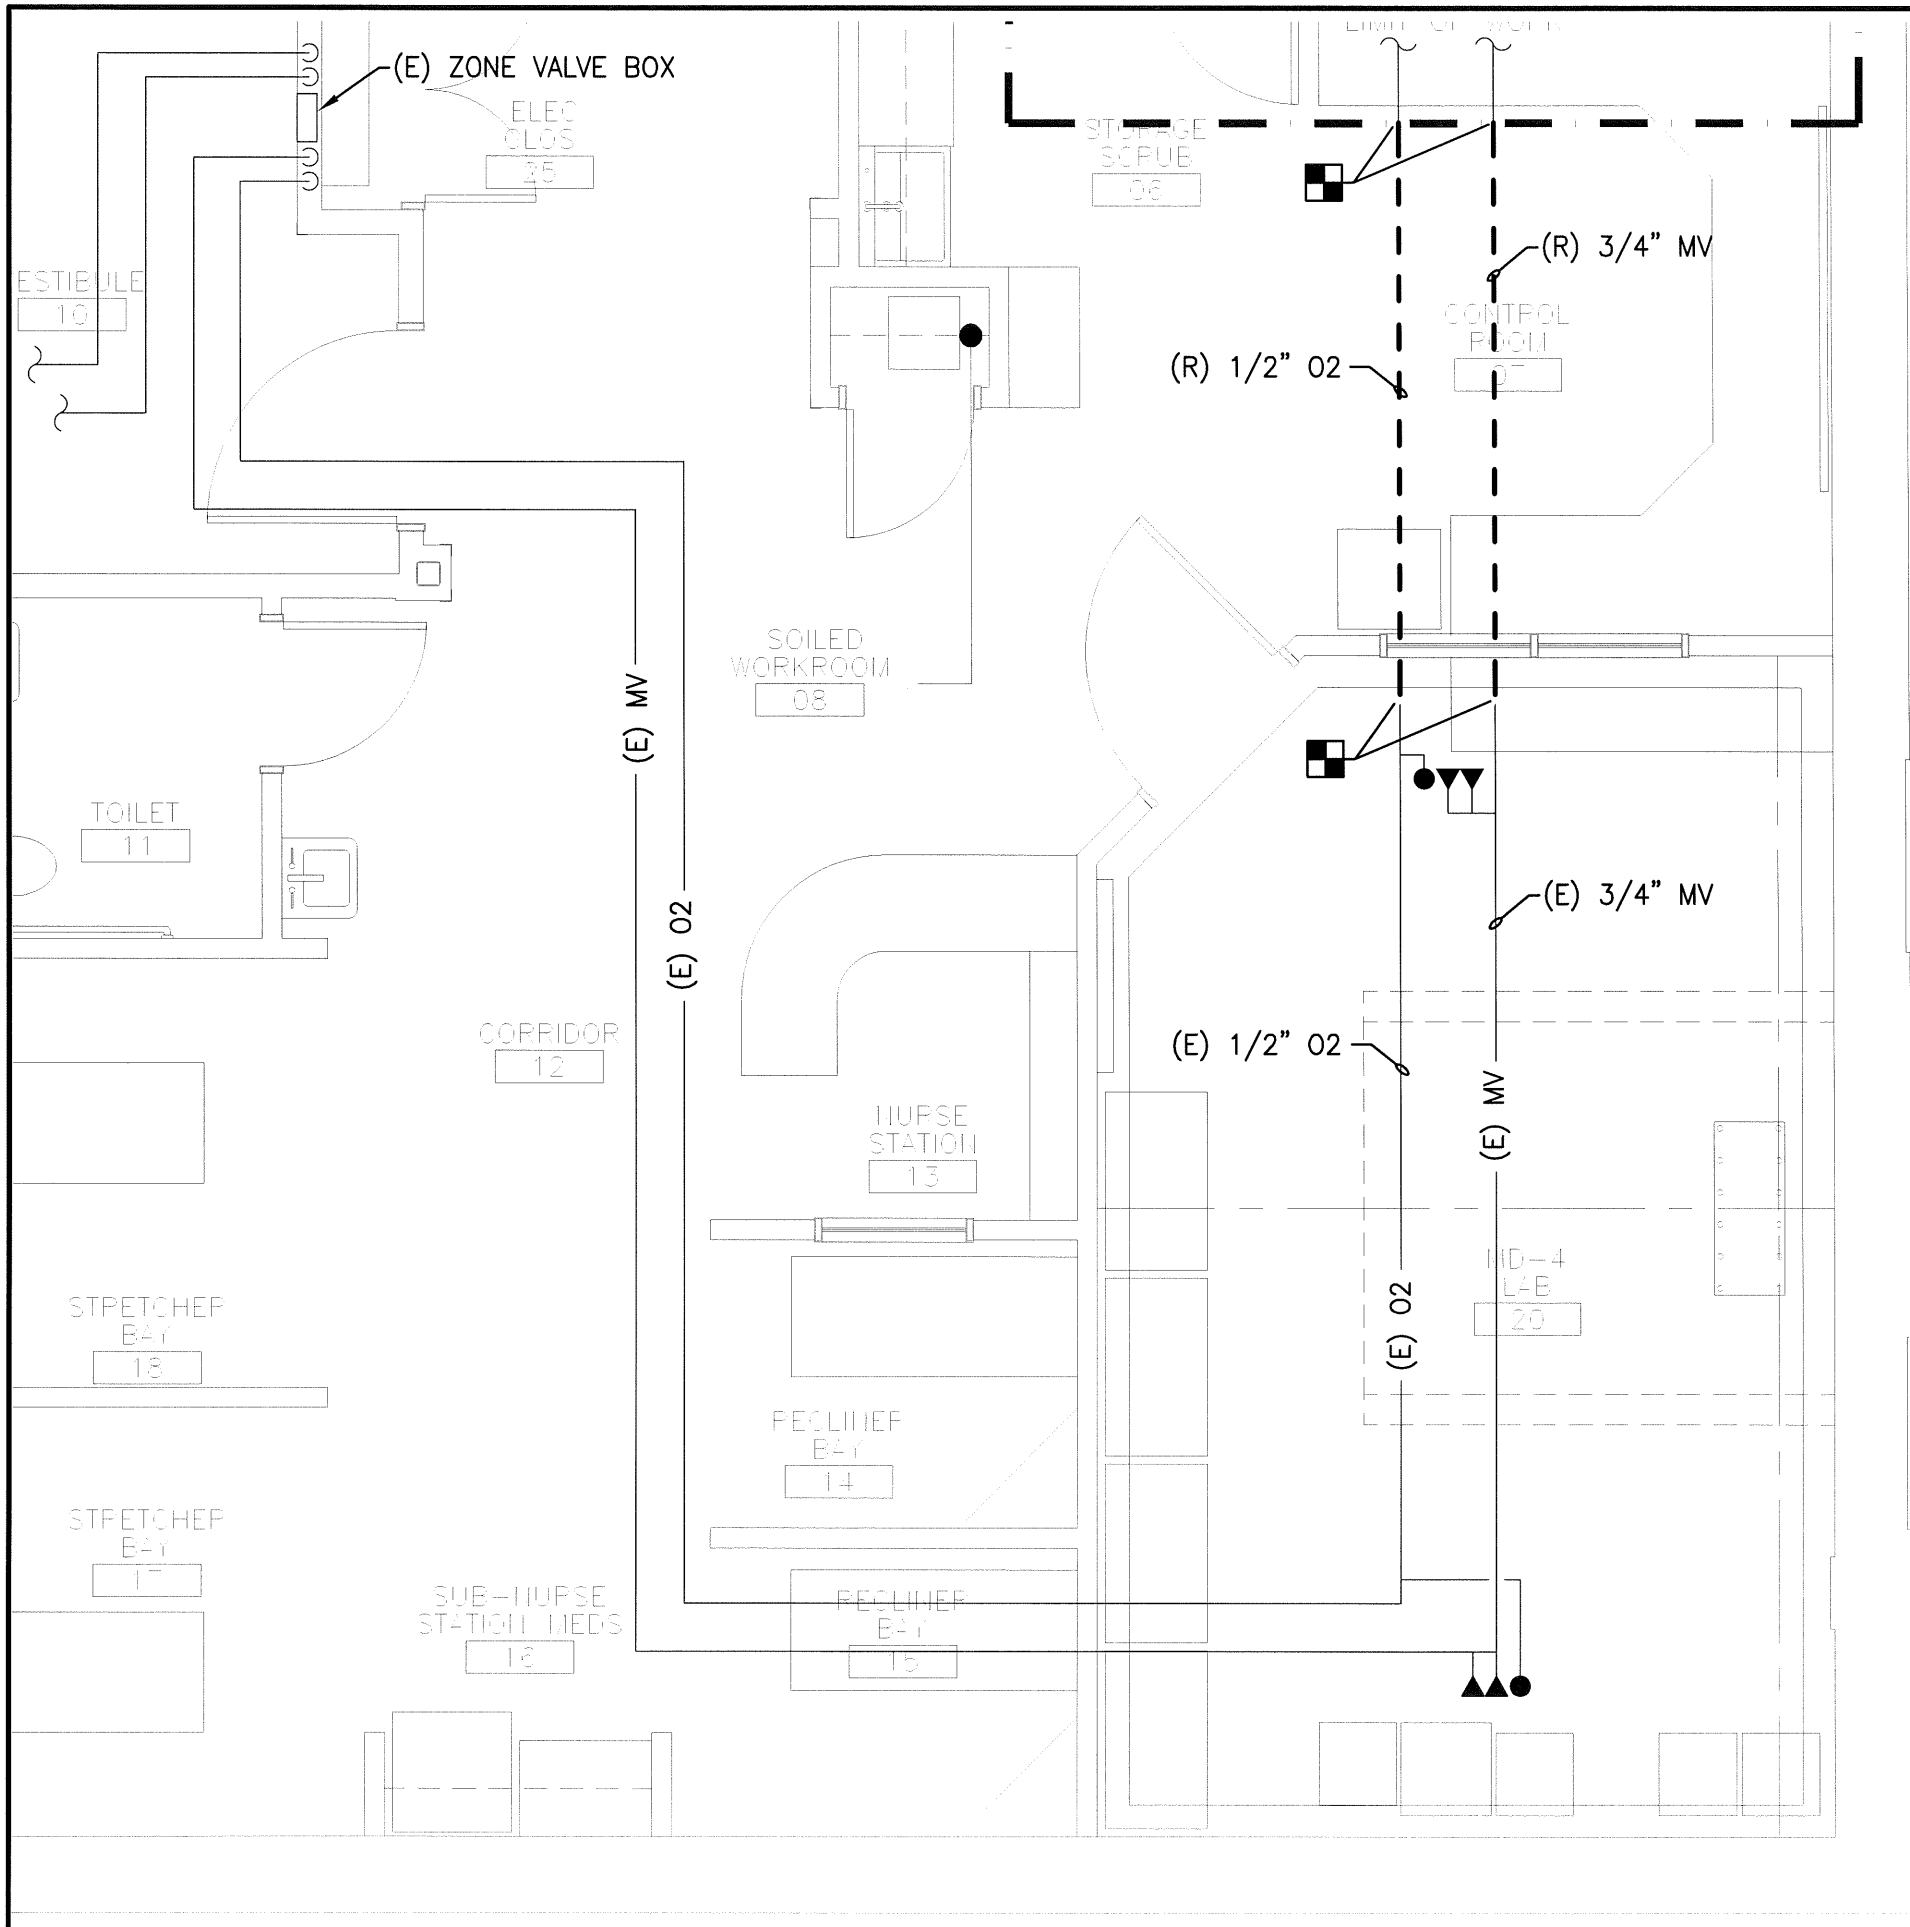

LEGEND-ABBREVIATIONS

- (E) EXISTING
- (R) REMOVE
- (REL) RELOCATE
- ◻◻ LIMIT OF REMOVAL
- ⊕ CONNECT TO EXISTING
- ▶▶ MEDICAL VACUUM INLET
- ◀◀ MEDICAL AIR OUTLET
- - - - - DEMOLITION
- — — — — EXISTING
- — — — — NEW

144 Fore Street/P.O. Box 618
 Portland, Maine 04104
 tel. (207) 772-3846
 fax. (207) 772-1070
 www.smrinc.com


ARCHITECTURE
 ENGINEERING
 PLANNING
 INTERIOR DESIGN
 COMMISSIONING


SMART

**MERCY HOSPITAL
 IR EQUIPMENT REPLACEMENT**
 PORTLAND, MAINE

ISSUED FOR DEMOLITION 8-31-12		DATE
CURRENT ISSUE STATUS:		
0	ISSUED FOR DEMOLITION	8-31-12
REV	DESCRIPTION	DATE

SCALE:	1/4"=1'-0"
PROJECT MANAGER:	KD
JC/DRAWN BY:	MBD
A/E OF RECORD:	KD
CAD FILE:	PD100-12076
PROJECT NO:	12076
DATE:	8-31-12
SHEET TITLE:	PIPING DEMOLITION PLAN
SHEET No.	PD100

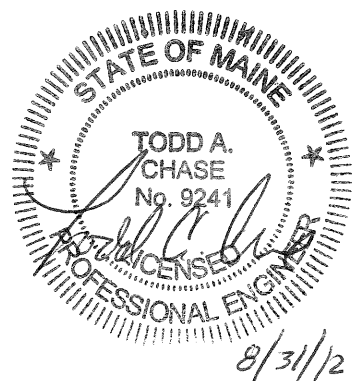

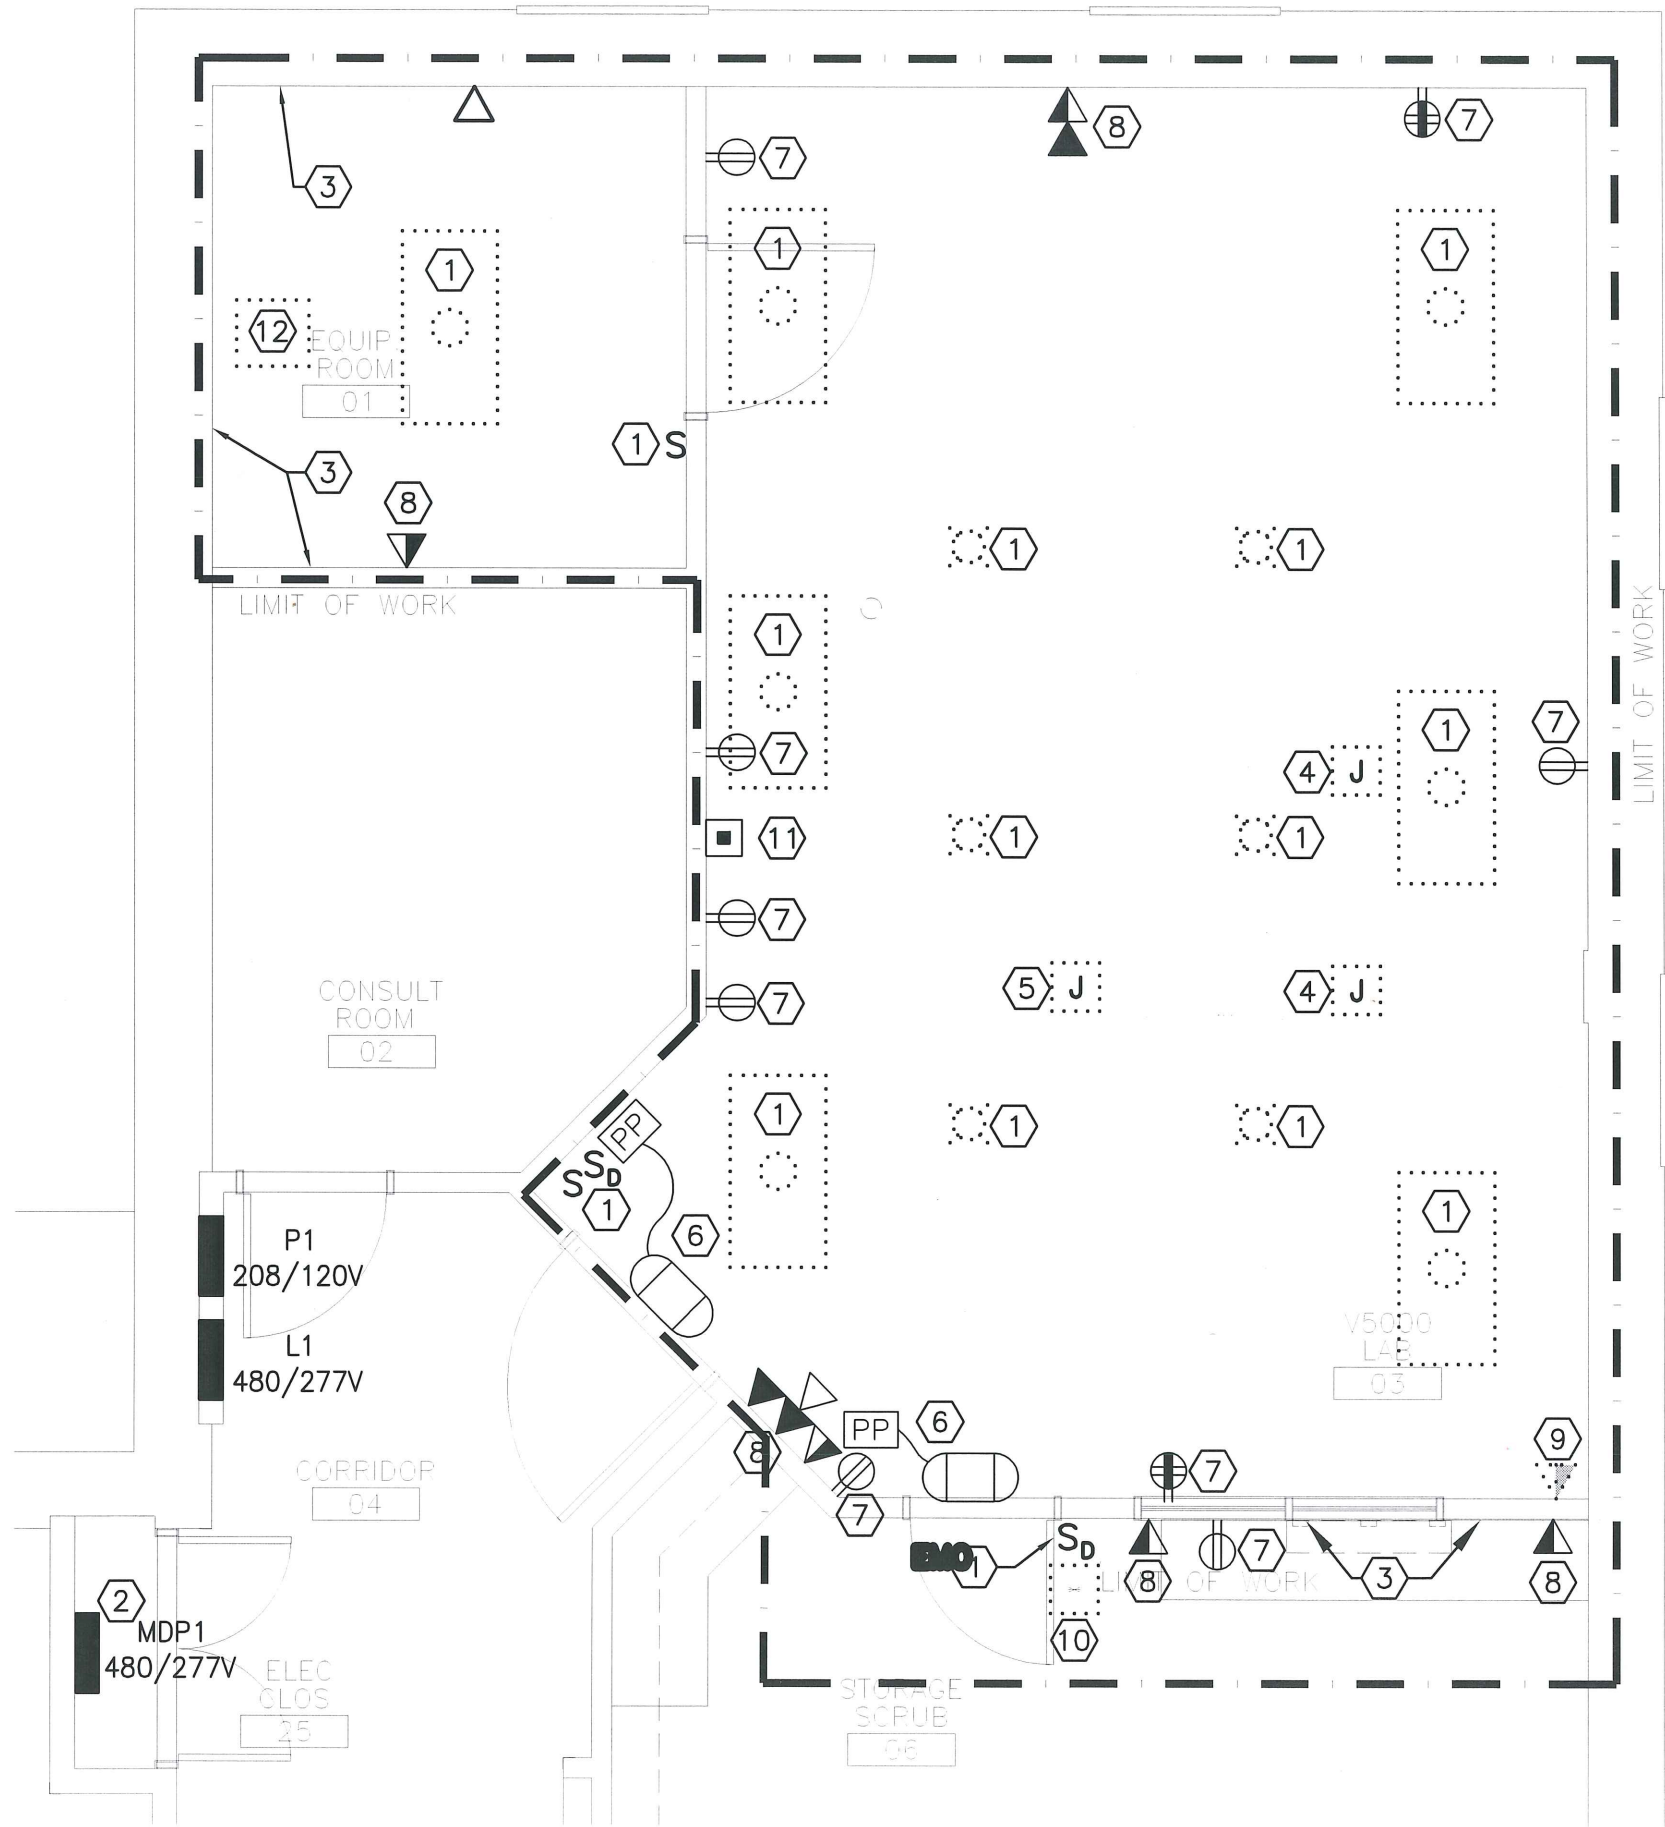


GENERAL NOTES:

1. SEE SHEET E-001 FOR LEGEND AND GENERAL NOTES.
2. REMOVE FEEDER TO CONDENSING UNIT CU-2 BACK TO SOURCE. REMOVE CONNECTION AT CONDENSING UNIT CU-1, FEEDER REMAINS FOR REUSE. SEE MECHANICAL DRAWING MD-101 FOR LOCATIONS.

KEYED NOTES:

- 1 REMOVE FIXTURES AND SWITCHES. LIGHTING CIRCUIT TO REMAIN.
- 2 REMOVE FEEDER SERVING EXISTING "ALLURA" EQUIPMENT. 125A BREAKER TO REMAIN FOR REUSE UNDER NEW WORK.
- 3 REMOVE WIRE TROUGH, JUNCTION BOXES AND CONDUITS ASSOCIATED WITH IMAGING EQUIPMENT.
- 4 REMOVE CEILING JUNCTION BOXES AND CONDUITS ASSOCIATED WITH IMAGING EQUIPMENT.
- 5 REMOVE FLOOR JUNCTION BOX, FLOOR TROUGH AND CONDUITS ASSOCIATED WITH IMAGING EQUIPMENT.
- 6 EXISTING DOOR OPERATORS REMAIN.
- 7 EXISTING RECEPTACLES REMAIN.
- 8 EXISTING TELE/DATA REMAINS.
- 9 REMOVE TELE/DATA JACK AND CABLES.
- 10 REMOVE EXISTING EMERGENCY OFF BUTTON.
- 11 CODE BLUE BUTTON REMAINS.
- 12 REMOVE FEEDER TO AHU-2 BACK TO SOURCE.

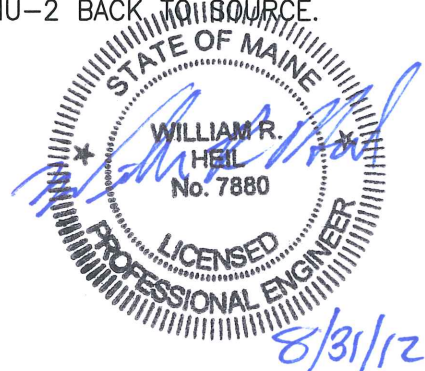

144 Fore Street/P.O. Box 618
 Portland, Maine 04104
 tel. (207) 772-3846
 fax. (207) 772-1070
 www.smrinc.com

ARCHITECTURE
 ENGINEERING
 PLANNING
 INTERIOR DESIGN
 COMMISSIONING



MERCY HOSPITAL
 IR EQUIPMENT REPLACEMENT
 PORTLAND, MAINE

ISSUED FOR DEMOLITION
 8-31-12

REV	DESCRIPTION	DATE

SCALE:	1/4"=1'-0"
PROJECT MANAGER:	KD
JC/DRAWN BY:	CDS
A/E OF RECORD:	WRH
CAD FILE:	E-E100-12076
PROJECT NO:	12076
DATE:	8-31-12

SHEET TITLE:
 ELECTRICAL DEMOLITION PLAN

SHEET No. E-100