

1 2 3 4 5


CONSULTANTS



Ranor Mechanical  
P.O. Box 5036  
962 Main Street  
North Jay, ME 04262

OWNER

West End Place  
44 Pine St.  
Portland, ME  
Redfern Properties LWS, LLC  
361 US Route 1  
Falmouth, ME 04105

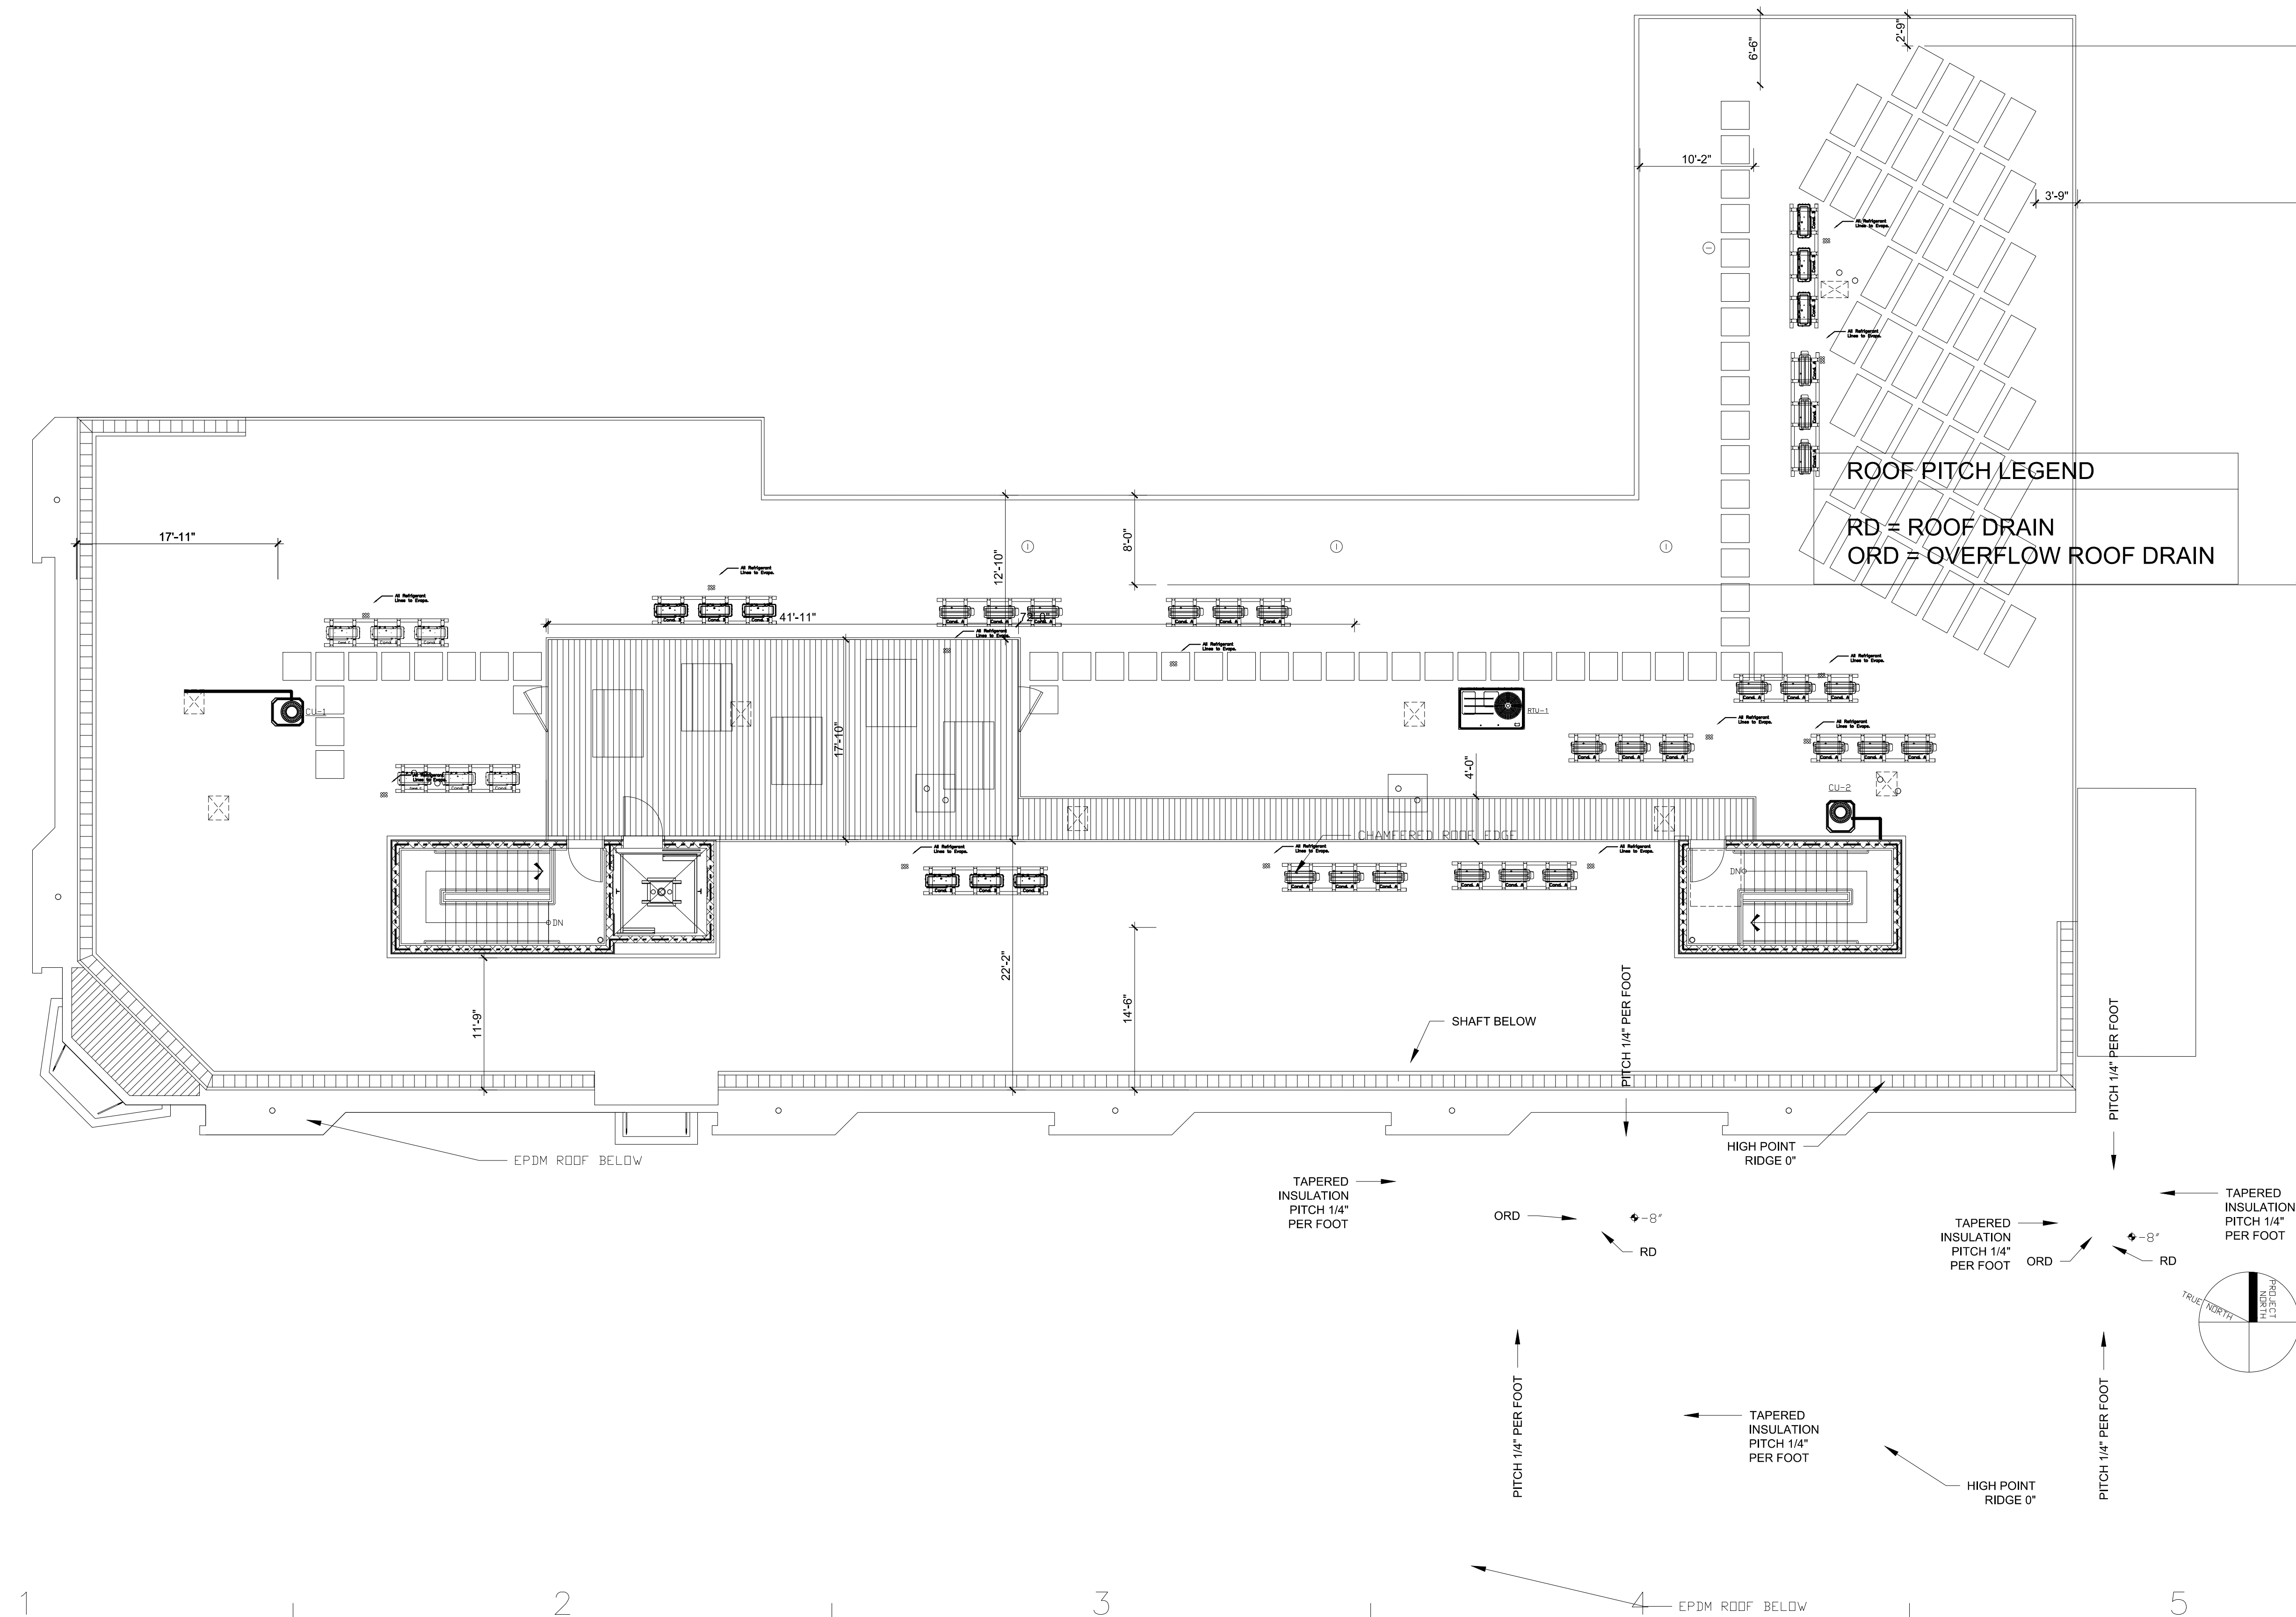

ROOF EDGE PT

HIGH POINT RIDGE

TAPERED INSULATION PITCH 1/4" PER FOOT

CHK'D BY: ###


COPYRIGHT:

SHEET TITLE

Roof HVAC Plan

M5-1

SHEET 1 OF 1

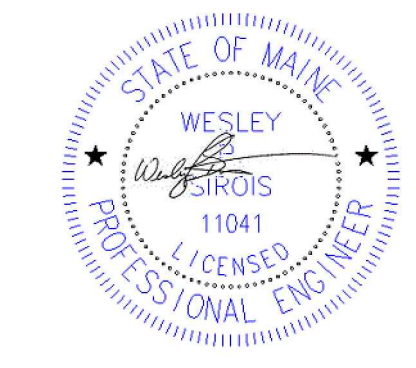

Rev.	DATE	DESCRIPTION
1	5/28/13	100% For Construction

SCALE: 1/8" = 1"

PROJECT NO: ---

CAD DWG FILE: WEST END.DWG

DRAWN BY: WPS

CHK'D BY: ###

COPYRIGHT:

SHEET TITLE

Roof HVAC Plan

M5-1

SHEET 1 OF 1