
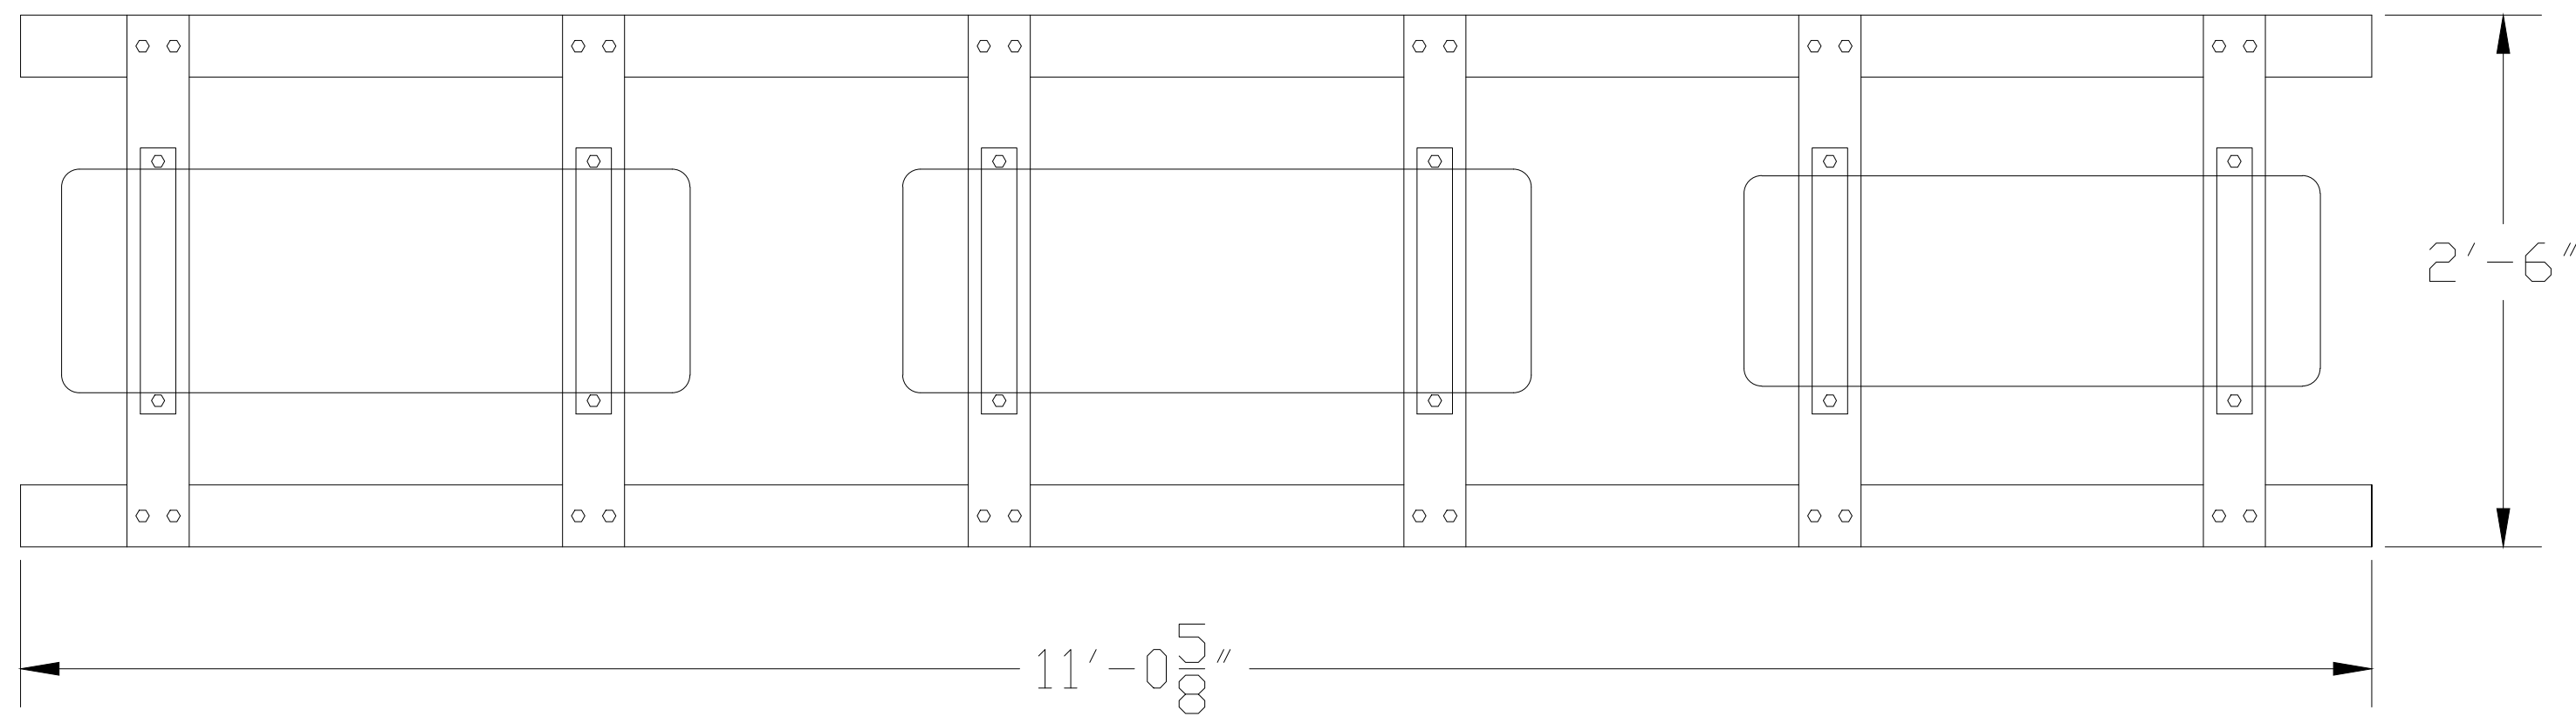


4MXS32GVJU

3MXS24GVJU

2MXS18GVJU

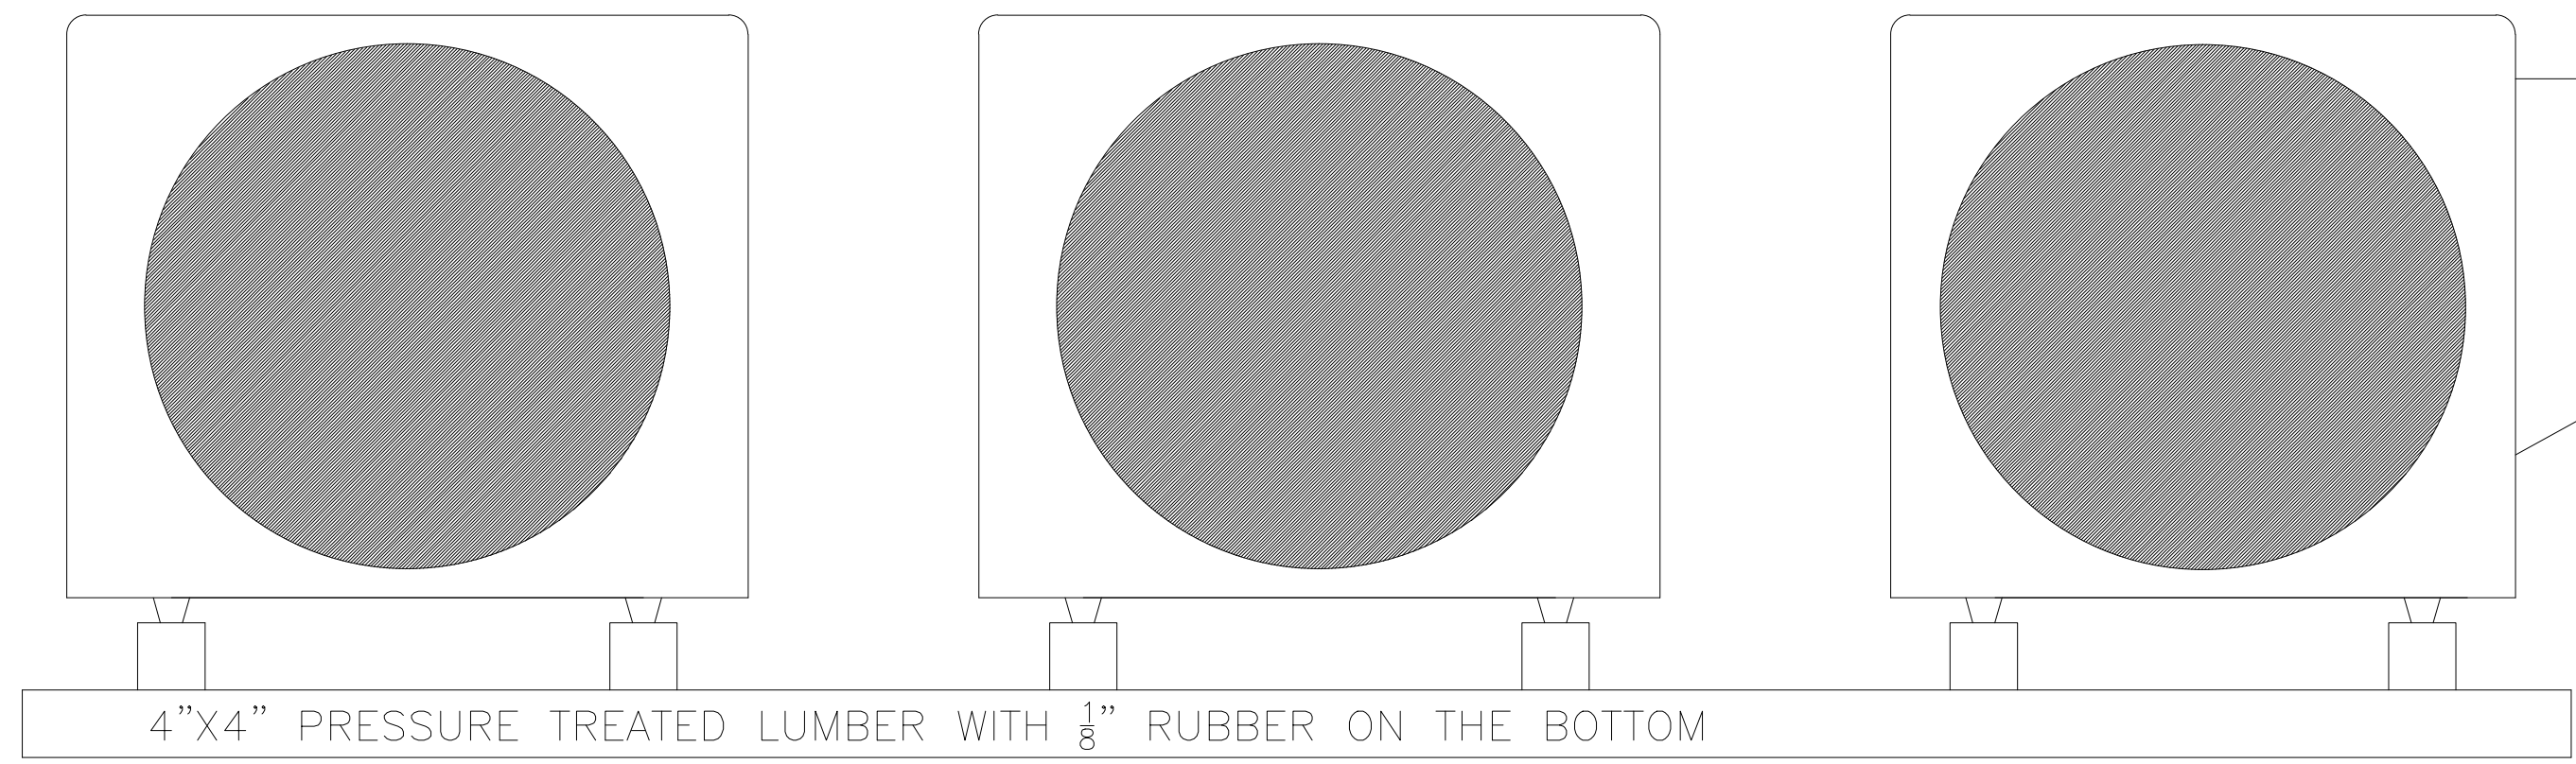

Condenser Mounting Detail

LEGEND	
SYMBOL	DESCRIPTION
	BRANCH DUCT TAKE-OFF SEE DETAIL
	TURNING VANES
	DUCT TEE CONNECTION
	RETURN AIR DUCT TAKE-OFF SEE DETAIL
	DUCT TRANSITION
	OPPOSED BLADE VOLUME DAMPER W/ CONCEALED CEILING DAMPER REGULATOR
	GRILLE OR DIFFUSER MARK C F M
	SUPPLY AIR
	RETURN AIR
	EXHAUST AIR
	THERMOSTAT
	HUMIDISTAT
R.A.	RETURN AIR
S.A.	SUPPLY AIR
F.A.	FRESH AIR
C.A.	COMBUSTION AIR
M.A.	MIXED AIR
F.D.	FIRE DAMPER

MECHANICAL ABBREVIATIONS	
ABBR.	DESCRIPTION
SD	SUPPLY DIFFUSER
RG	RETURN GRILLE
EG	EXHAUST GRILLE
ERV	ENERGY RECOVERY VENTILATOR
EA	EXHAUST AIR
FA	FRESH AIR
RA	RETURN AIR
OA	OUTSIDE AIR
SA	SUPPLY AIR
CFM	CUBIC FEET PER MINUTE
GPM	GALLONS PER MINUTE
BTU	BRITISH THERMAL UNITS
BRU/HR	BRITISH THERMAL UNITS PER HOUR
EQUIPMENT ABBREVIATIONS	
CU	CONDENSING UNIT
COND.	CONDENSOR
EVAP.	EVAPORATOR
RTU	ROOF TOP UNIT
CUH	CABINET UNIT HEATER
EF	EXHAUST FAN
HVAC	PACKAGED HVAC UNIT
PIPING ABBREVIATIONS	
RG	REFRIGERANT GAS
RL	REFRIGERANT LIQUID
CND	CONDENSATE


CONSULTANTS



Ranor Mechanical
P.O. Box 5036
962 Main Street
North Jay, ME 04262

OWNER

West End Place
44 Pine St.
Portland, ME
Redfern Properties LWS, LLC
361 US Route 1
Falmouth, ME 04105

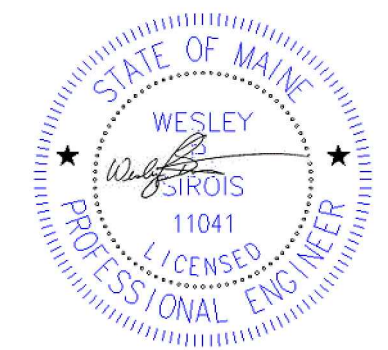

Rev: 1 5/28/13 100% For Construction

MARK DATE DESCRIPTION

SCALE: NTS

PROJECT NO: ----

CAD DWG FILE: WEST END.DWG

DRAWN BY: WPS

CHK'D BY: ###

COPYRIGHT:

SHEET TITLE

Mechanical Details

M6-1
SHEET 1 OF 1