


REFLECTED CEILING PLAN

SCALE 1/4" = 1'-0"

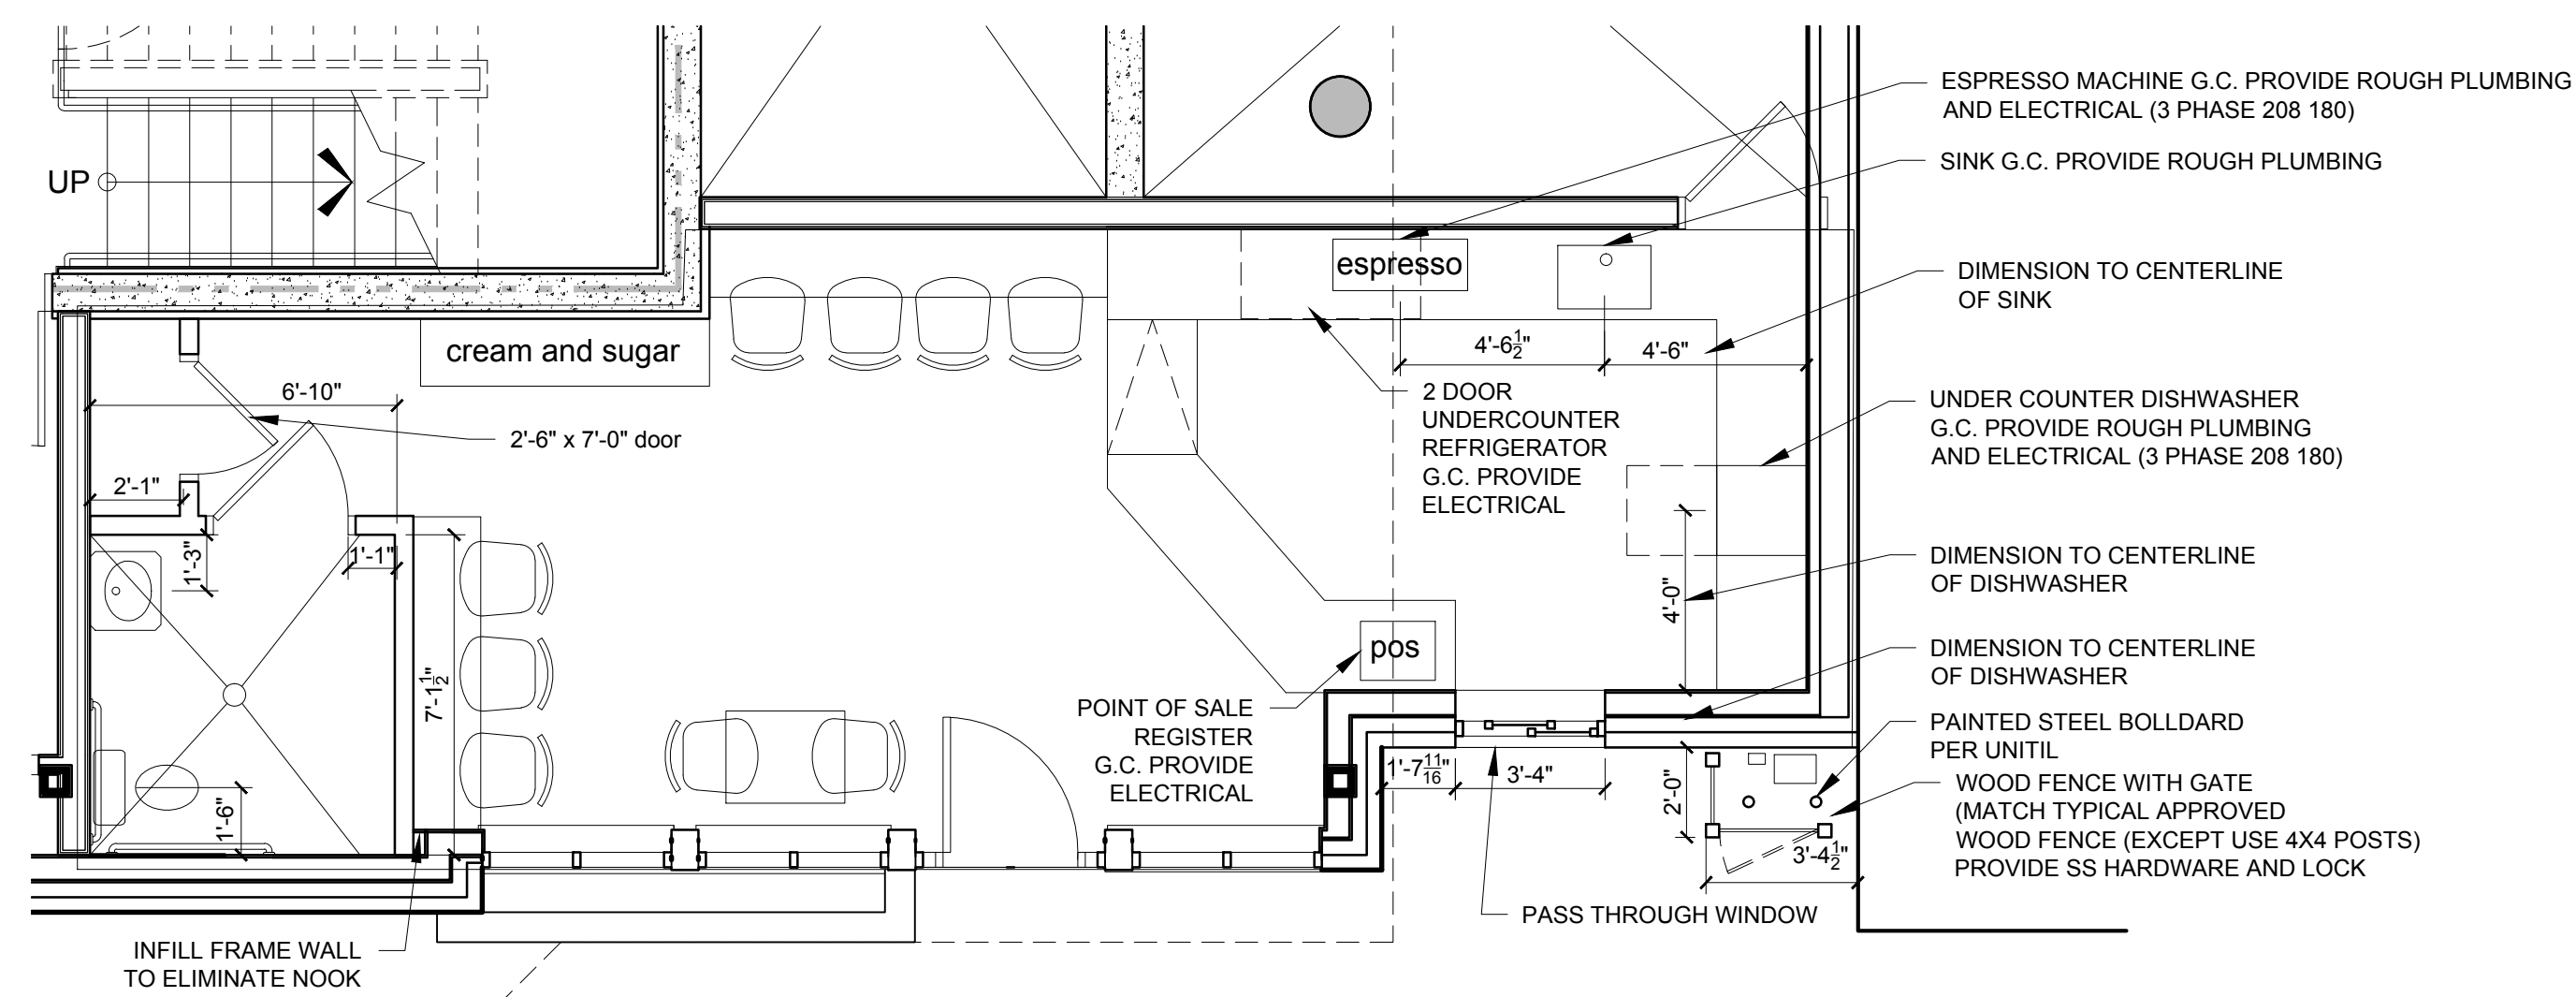


COFFEE SHOP PLAN

SCALE 1/4" = 1'-0"

EQUIPMENT SCHEDULE			
TYPE	MANUFACTURER	MODEL	ELECTRICAL INFO
ESPRESSO MACHINE	BLACK EAGLE	2 HEAD UNIT	208-240V, 7100 WATTS, 32 AMP DRAW, NEMA 6-50
UNDERCOUNTER REFRIGERATOR	TRUE	TUC-48	1/5 HP, 115V/60/1, 5.0 AMPS, NEMA 5-15P
DISHWASHER	CMA	UC65e	208-240v/60/1-PH, STANDARD

- NOTES:
- 1.) CABINETS AND COUNTERS BY OWNER
 - 2.) G.C. TO PROVIDE FINISHED ELECTRICAL SYSTEM PER CODE AND COORDIANTE WITH OWNERS EQUIPMENT
 - 3.) G.C. TO PROVIDE ROUGH PLUMBING TO LOCATIONS OF SINK, DISHWASHER, ESPRESSO MACHINE
 - 4.) G.C. TO PROVIDE FINISHED BATHROOM SIMILAR TO ORIGINAL PLAN (BUT IN NEW LOCATION)
 - 5.) G.C. TO PROVIDE HUNG 5/8" GWB CEILING WITH PAINTED FINISH, PROVIDE ACCESS PANELS AS REQUIRED
 - 6.) PROVIDE DIMMERS AND DIMMABLE FIXTURES FOR ALL LIGHTING

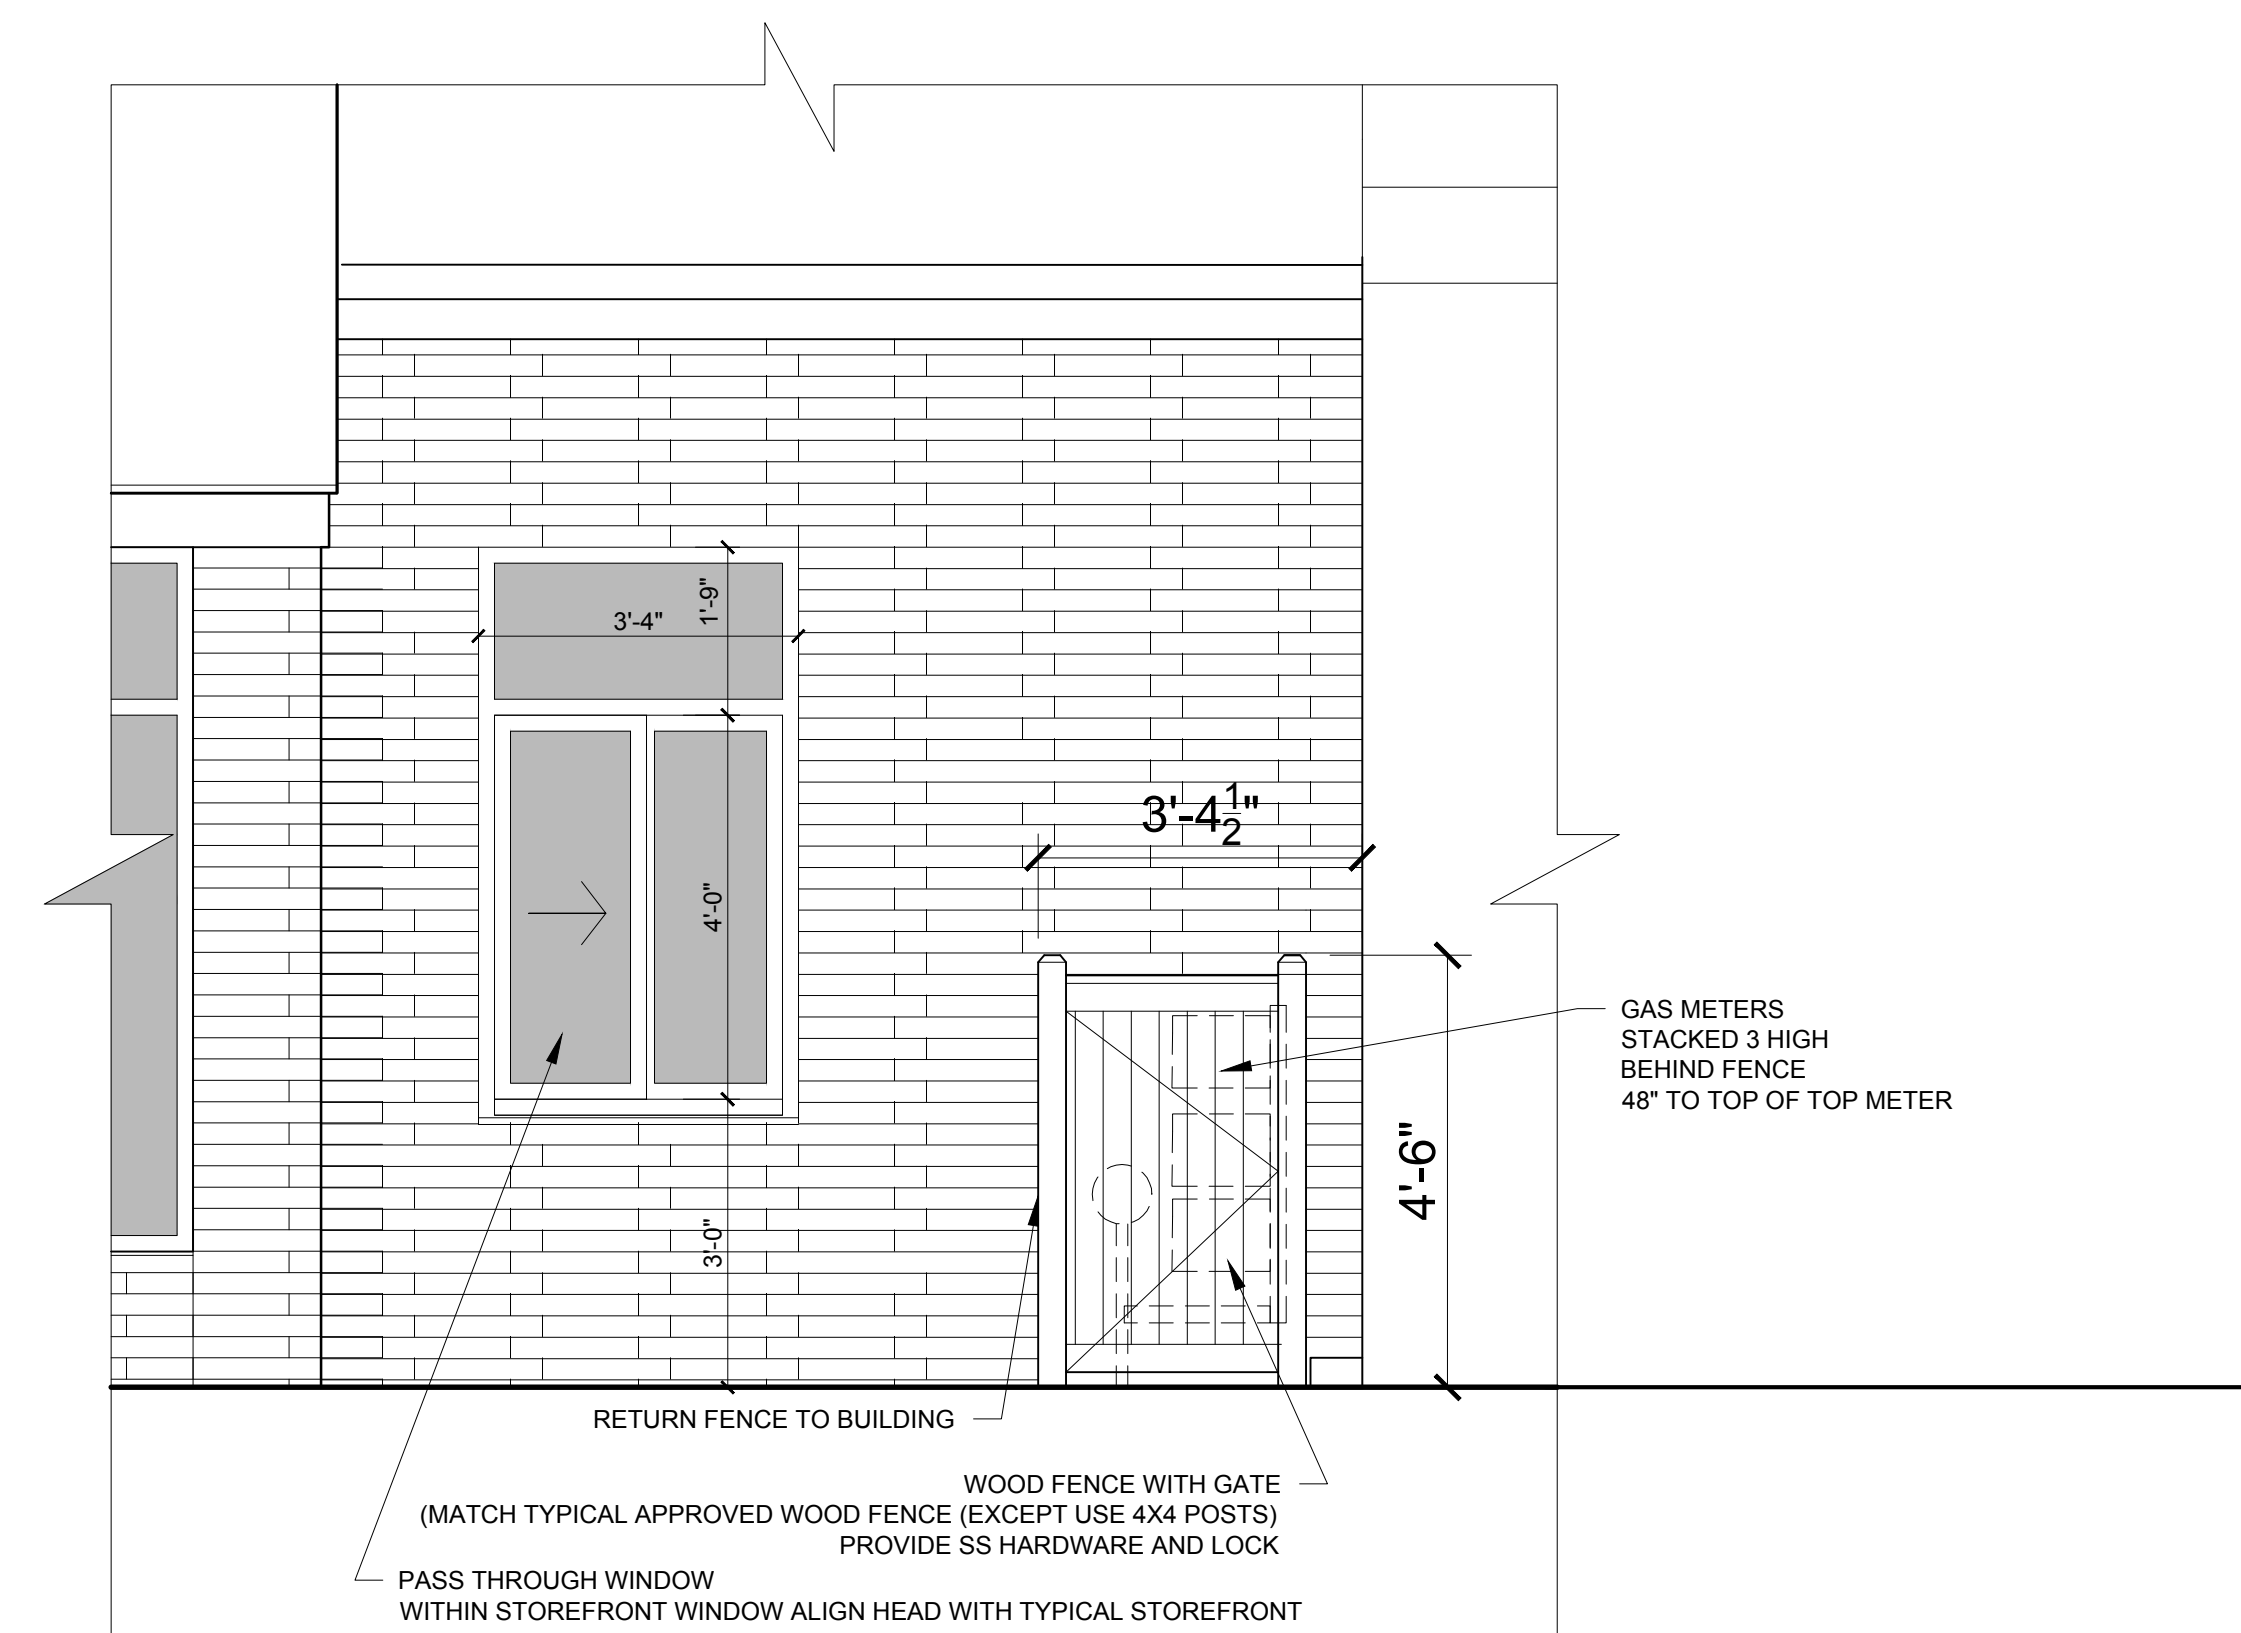

PASS THROUGH WINDOW ELEVATION

SCALE 1/2" = 1'-0"

PROGRESS PRINT
NOT FOR CONSTRUCTION