

 
 

 




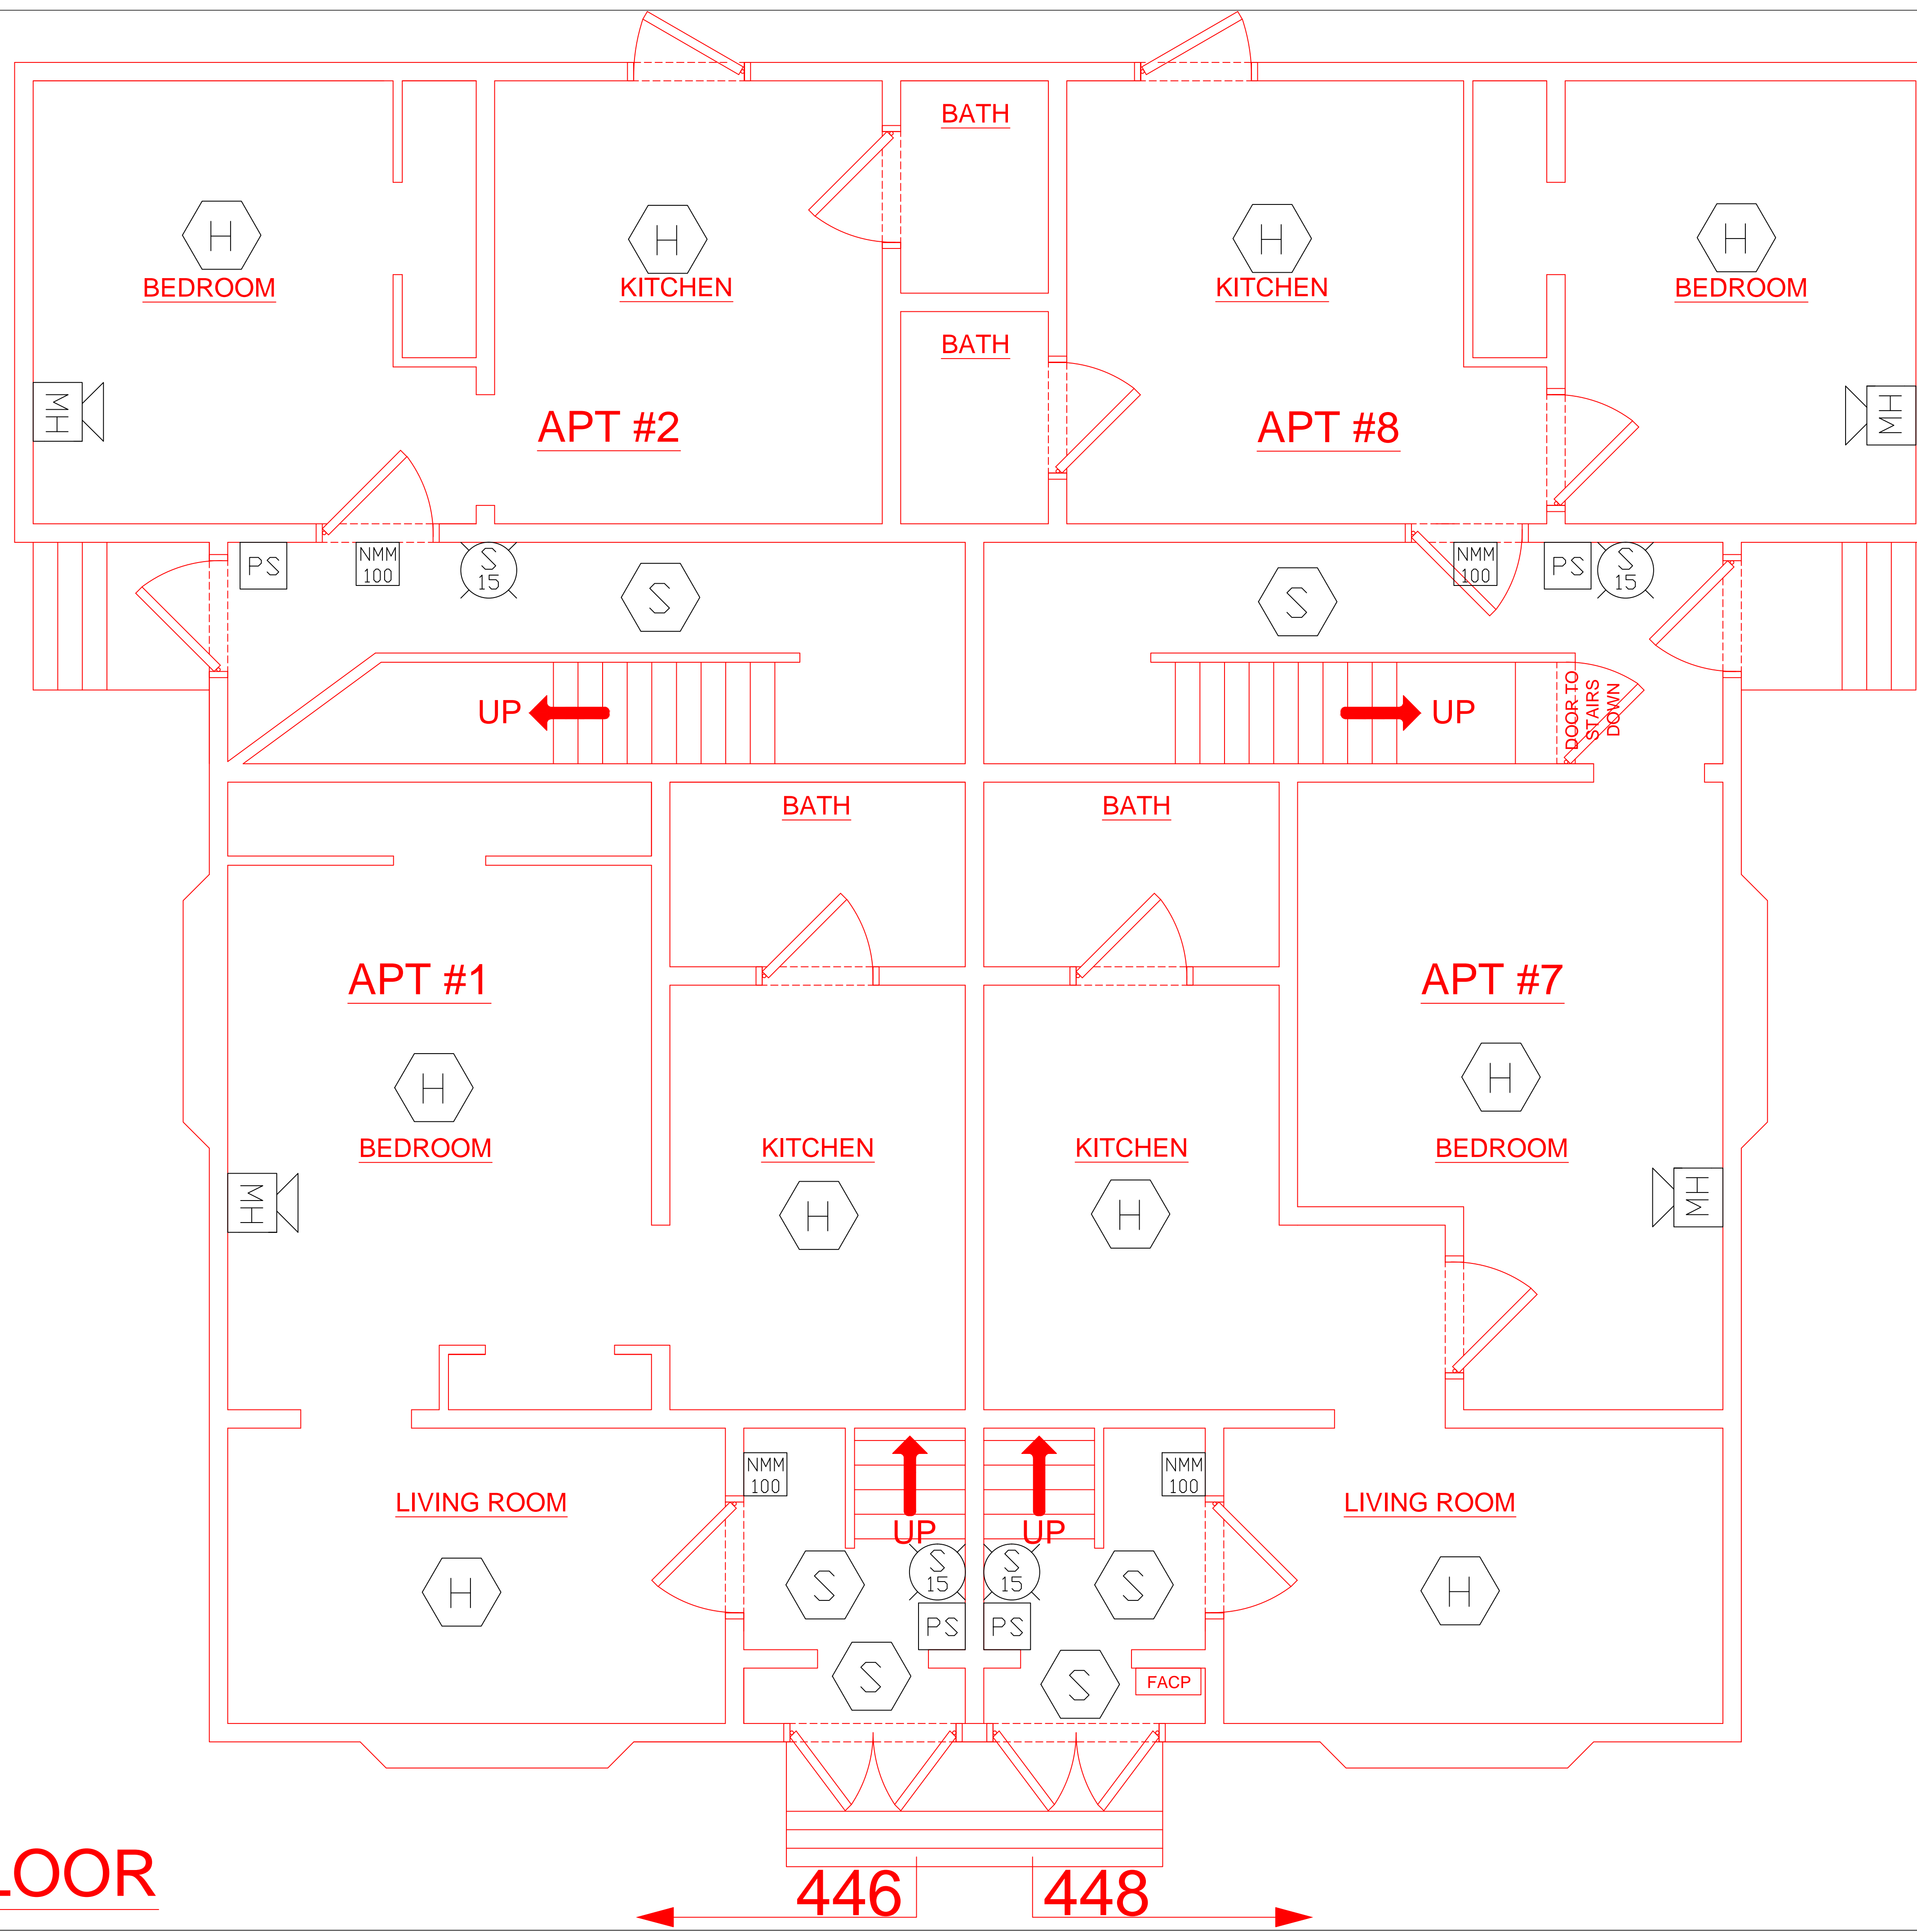



LEGEND

-  PULL STATION
-  SMOKE DETECTOR
-  HEAT DETECTOR
-  CARBON MONOXIDE DETECTOR
-  MINI-HORN
-  HORN/STROBE  
(XX NOTES CANDELA)
-  STROBE  
(XX NOTES CANDELA)  
(WP=WEATHERPROOF)
-  MONITOR MODULE
-  FIRE ALARM CONTROL PANEL
-  KNOX BOX



**1ST FLOOR**

REVISION 2	DATE:
REVISION 1	DATE:
REVISION 0 SUBMITTAL	DATE: 03/21/2014
FIRE ALARM LAYOUT FIRST FLOOR	
PROJECT NAME	SCALE NTS
446/448 CUMBERLAND AVE PORTLAND, ME	BY: JRS
	CK BY:
	SAVED AS:
 Prepared For Tomorrow, Delivered Today 2257 BROADWAY, SO. PORTLAND, MAINE	