

 
 

 




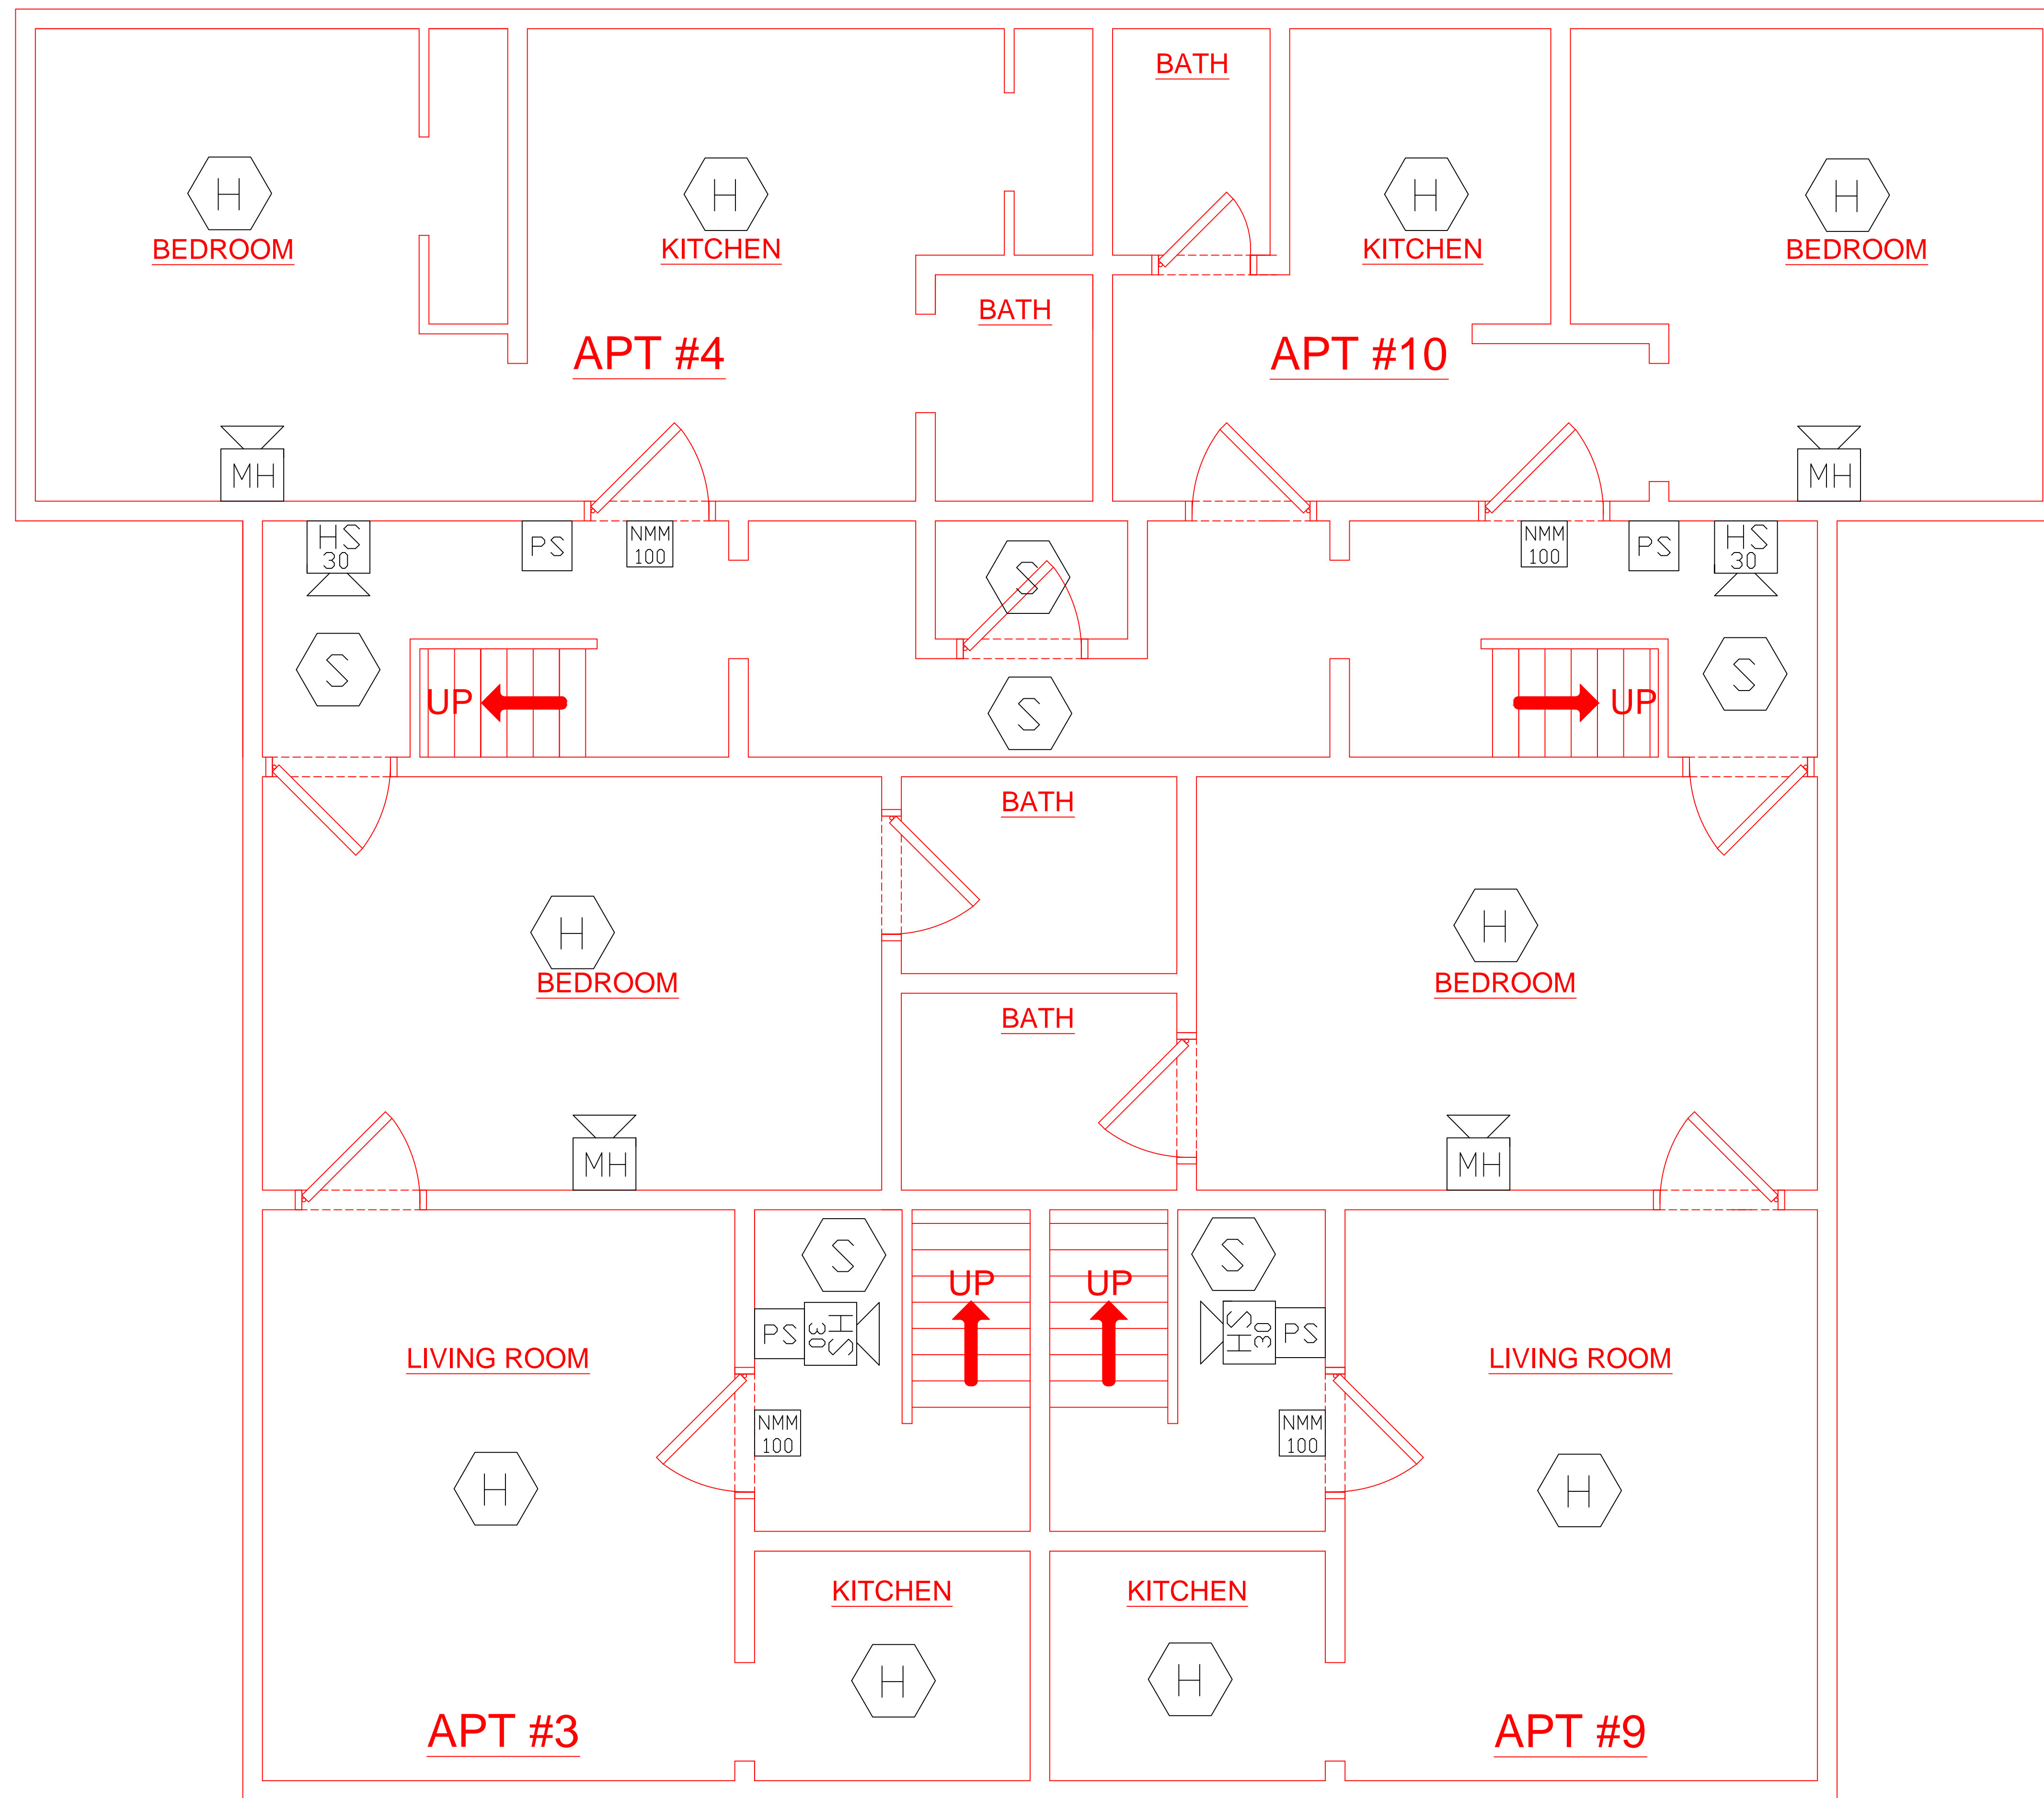



LEGEND

-  PULL STATION
-  SMOKE DETECTOR
-  HEAT DETECTOR
-  CARBON MONOXIDE DETECTOR
-  MINI-HORN
-  HORN/STROBE (XX NOTES CANDELA)
-  STROBE (XX NOTES CANDELA) (WP=WEATHERPROOF)
-  MONITOR MODULE
-  FIRE ALARM CONTROL PANEL
-  KNDX BOX



**2ND FLOOR**

← **446**      **448** →

REVISION 2	DATE:
REVISION 1	DATE:
REVISION 0 SUBMITTAL	DATE: 03/21/2014
FIRE ALARM LAYOUT SECOND FLOOR	
PROJECT NAME 446/448 CUMBERLAND AVE PORTLAND, ME	SCALE NTS BY: JRS CK BY:
 NORRIS INC Prepared For Tomorrow, Delivered Today 2257 BROADWAY, SO. PORTLAND, MAINE	SAVED AS: