

 
 

 




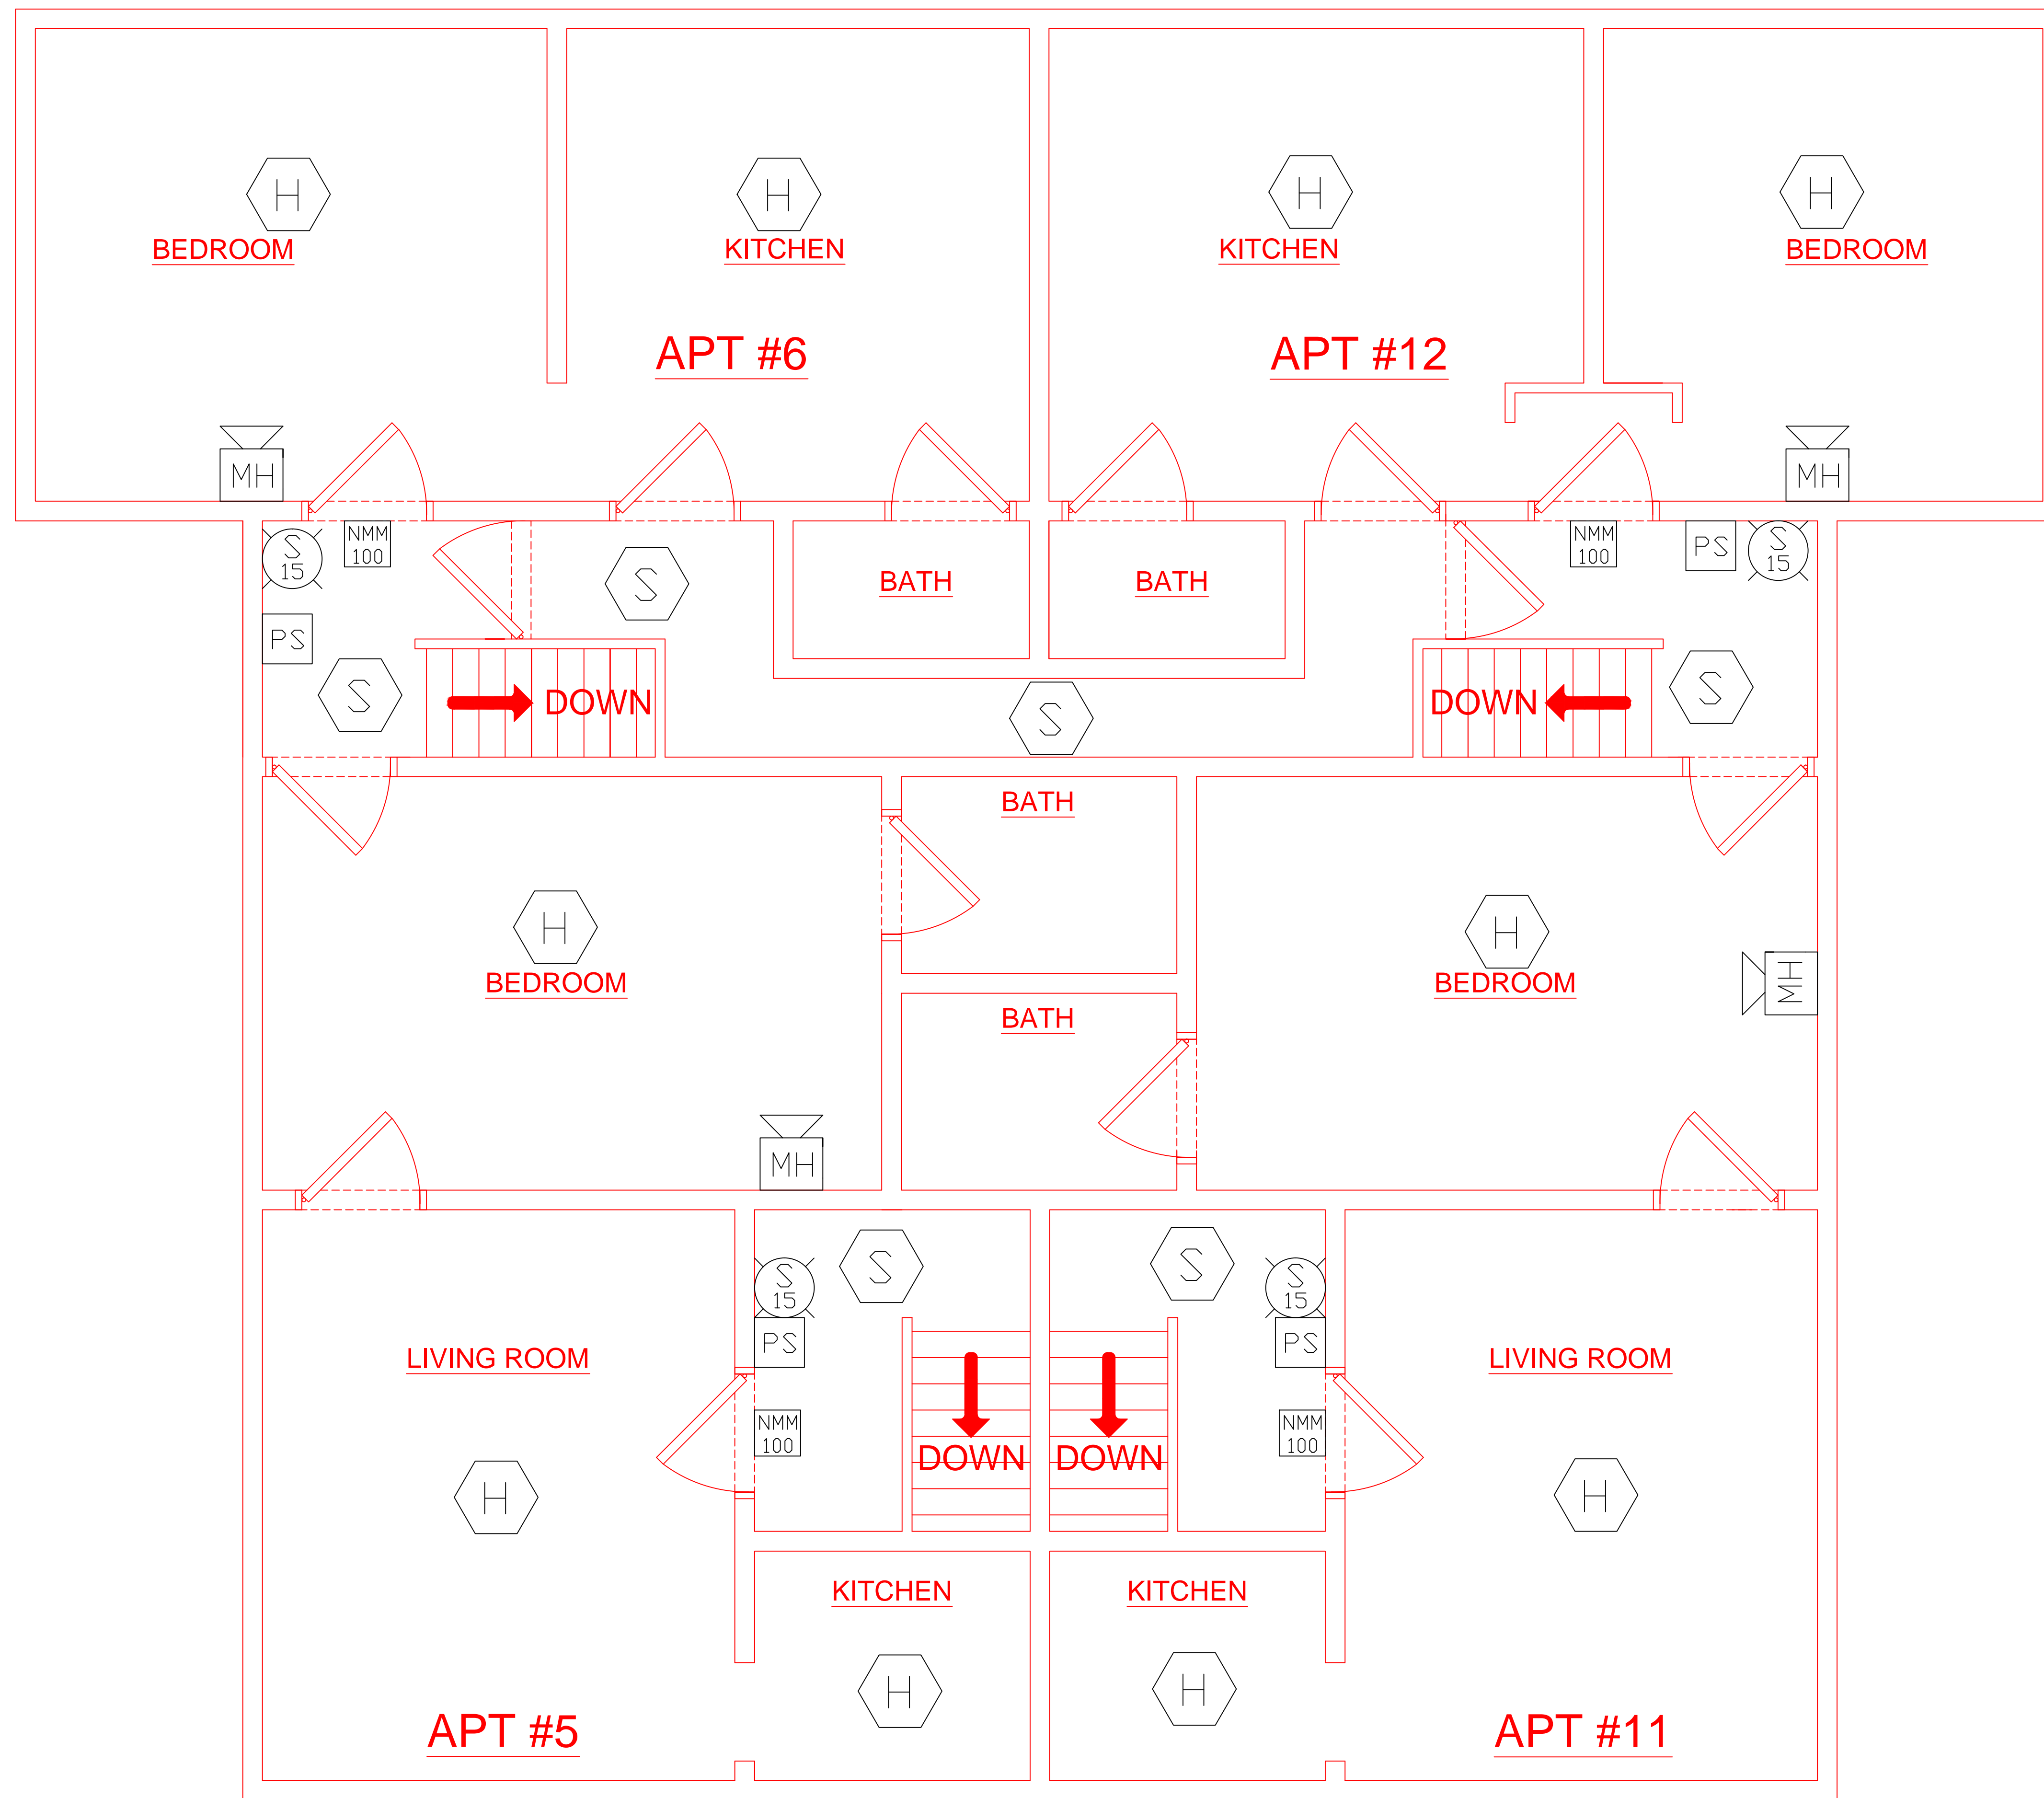



LEGEND

-  PULL STATION
-  SMOKE DETECTOR
-  HEAT DETECTOR
-  CARBON MONOXIDE DETECTOR
-  MINI-HORN
-  HORN/STROBE
(XX NOTES CANDELA)
-  STROBE
(XX NOTES CANDELA)
(WP=WEATHERPROOF)
-  MONITOR MODULE
-  FIRE ALARM CONTROL PANEL
-  KNEX BOX



3RD FLOOR

← **446** **448** →

REVISION 2	DATE:
REVISION 1	DATE:
REVISION 0 SUBMITTAL	DATE: 03/21/2014
FIRE ALARM LAYOUT THIRD FLOOR	
PROJECT NAME 446/448 CUMBERLAND AVE PORTLAND, ME	SCALE NTS
	BY: JRS
	CK BY:
 Prepared For Tomorrow, Delivered Today 2257 BROADWAY, SO. PORTLAND, MAINE	
	SAVED AS: