




NOTE: UNITS ARE CURRENTLY PROVIDED WITH SINGLE STATION SMOKE DETECTORS AND CO DETECTORS

NOTE: NO EXPOSED WIRING (CONDUIT) TO BE INSTALLED IN HATCHED AREAS. IN ALL OTHER AREAS SURFACE MOUNTED CONDUIT IS ACCEPTABLE.

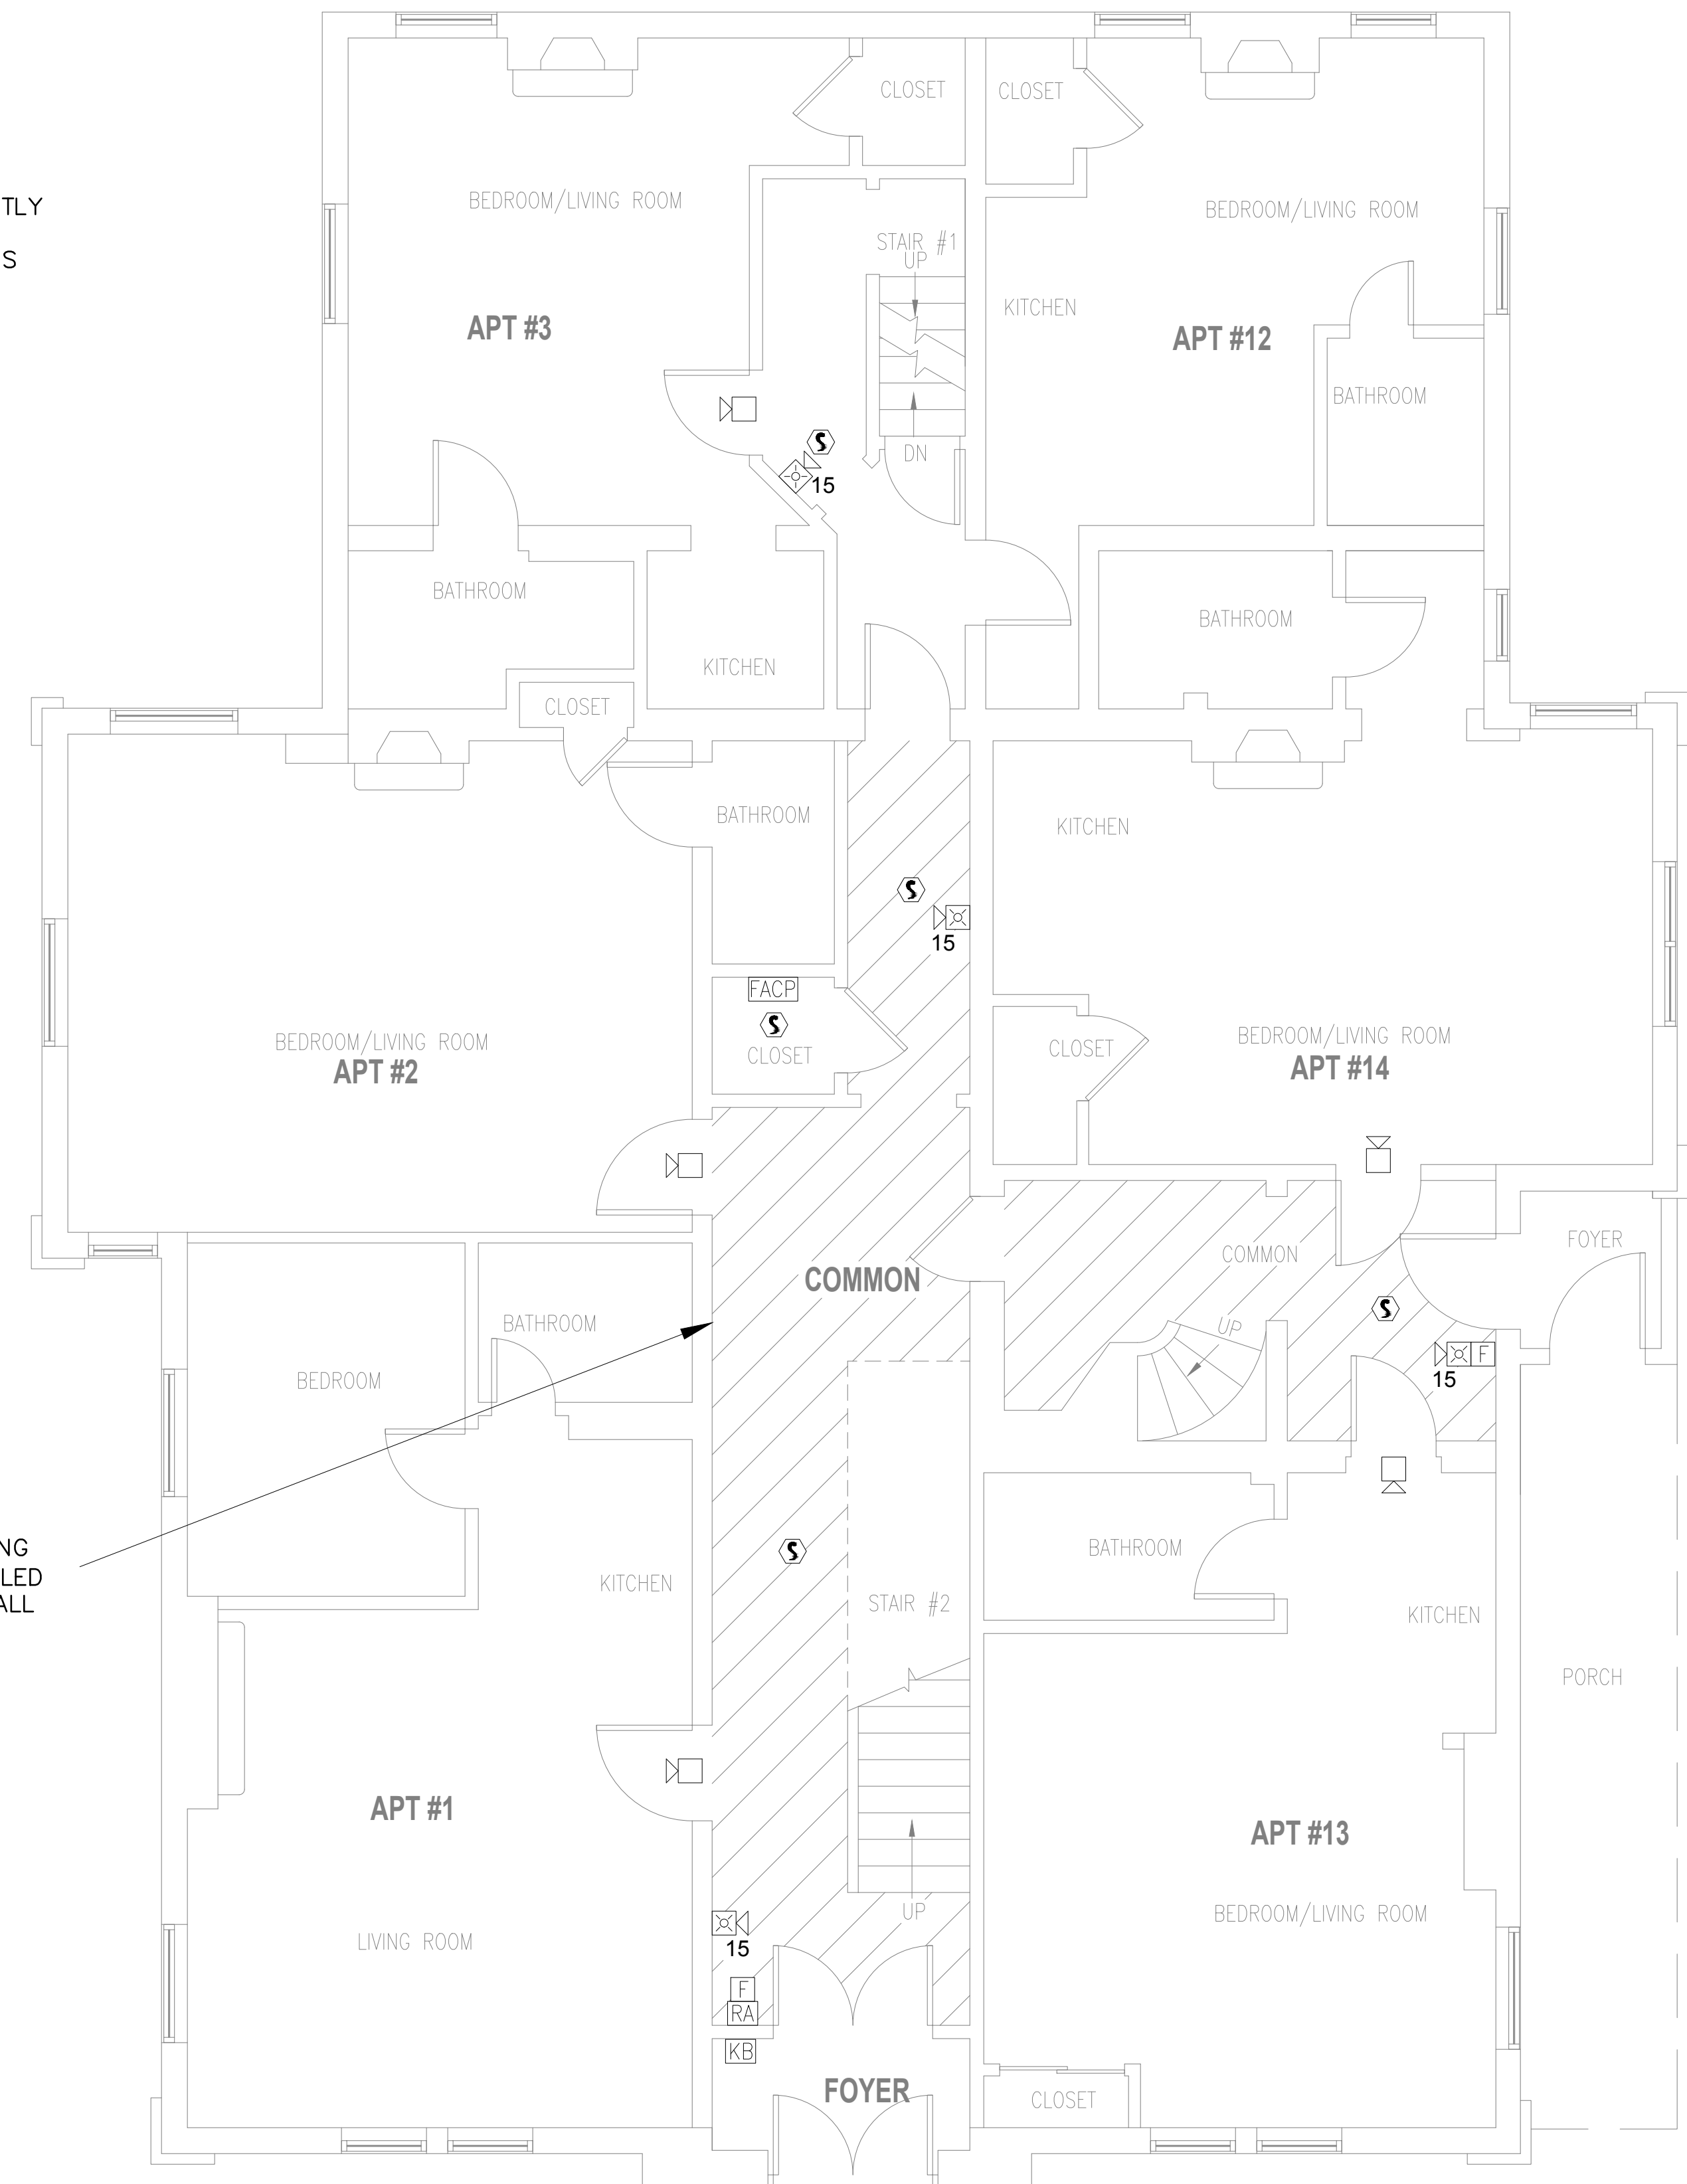


BASEMENT FIRE ALARM PLAN

SCALE: 1/4"=1'-0"

FIRST FLOOR FIRE ALARM PLAN

SCALE: 1/4"=1'-0"

BURNHAM PROPERTIES, LLC
 PO BOX 34
 SCARBOROUGH, ME 04070-00341
 207-885-0942
 KJP@MAINE.PR.COM

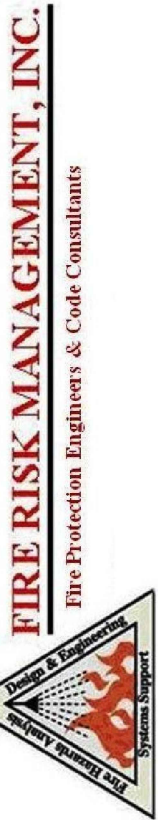

15-17 DEERING STREET
 PORTLAND, MAINE

**BASEMENT & FIRST FLOOR
 FIRE ALARM PLAN**

SHEET SIZE:
 22" x 34"
 DATE:
 01.07.2016

BID DOCUMENTS
 DRAWN BY:
 FRM, INC

FA101