
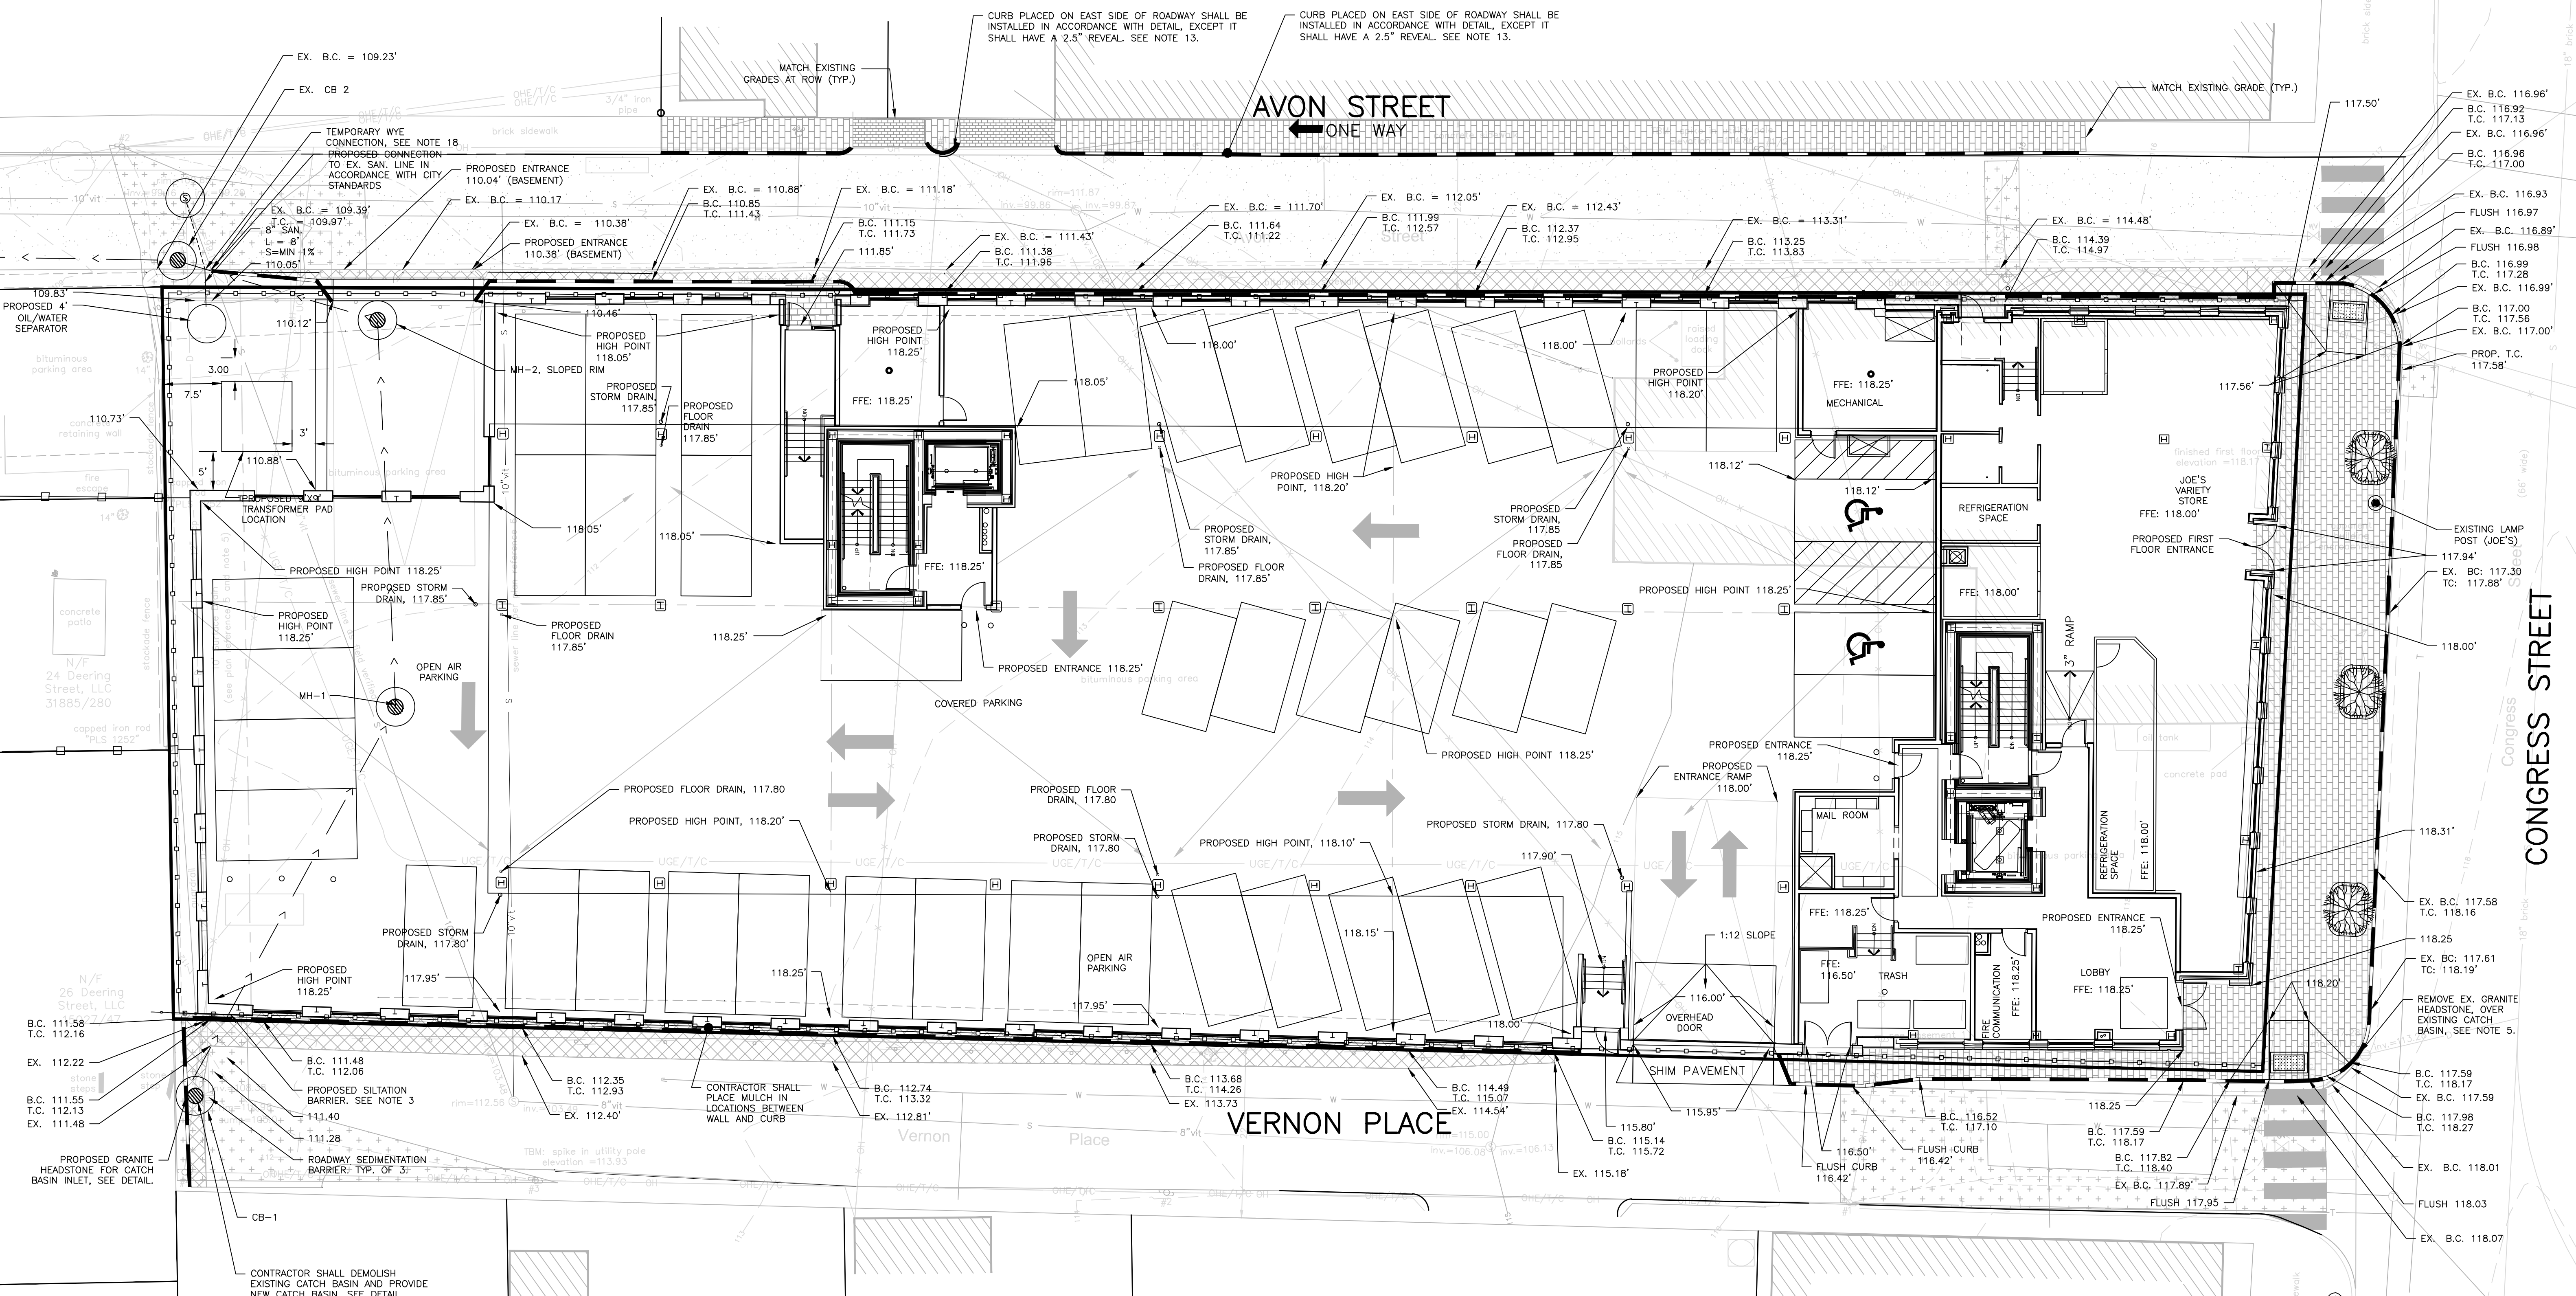


GENERAL NOTES: SEE SHEET C-30

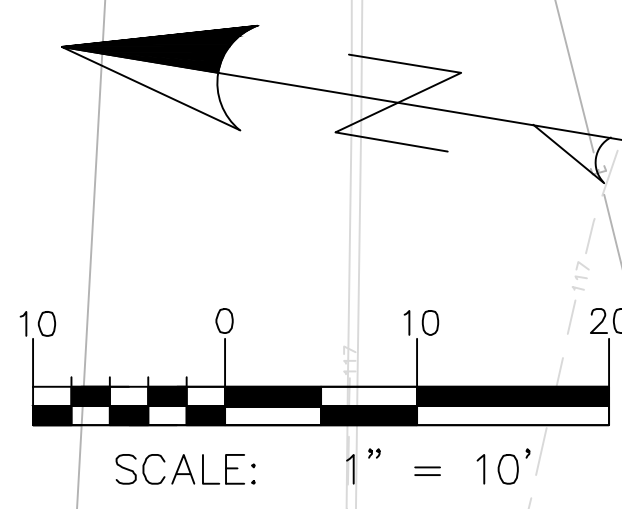


ISSUED FOR	BY	DATE
PRELIM. APPLICATION	WHS	7/30/15
PC DD SET	WHS	8/7/15
PC PROGRESS SET	WHS	9/21/15
COMMENT/RESPONSE	WHS	9/15/15
FINAL APPLICATION	WHS	10/13/15
BIDDING	WHS	10/18/15
COA	WHS	10/30/15
FOR CONSTRUCTION	WHS	11/2/15
CITY COMMENTS	WHS	12/4/15
CITY APPROVED PLAN	WHS	12/9/15
DEMINIMIS CHANGE	WHS	3/4/16

DRAWING NAME: **GRADING & DRAINAGE PLAN: FIRST FLOOR**
 PROJECT NAME: **667 CONGRESS STREET REDEVELOPMENT**
 CLIENT: **REDFERN LONGFELLOW, LLC.**
P.O. BOX 8616 PORTLAND, MAINE, 04104

A C C O R N
ENGINEERING, INC.

ACCORN ENGINEERING, INC. MAINE 04102
158 DANFORTH (207) 779-2665

FILE: 1060_CONGRESS
 DATE: 4/6/2015
 JUN: 1060
 SCALE: 1"=10'
 DESIGNED BY: MAG
 DRAWN BY: MAG
 CHECKED BY: WHS

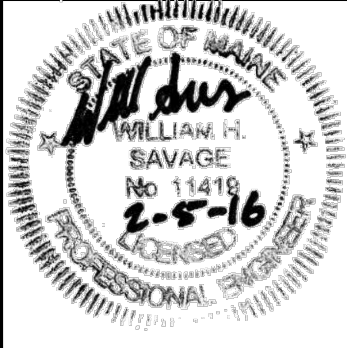

DRAWING NO.
C-31

ISSUED FOR CONSTRUCTION