


E1 PLUMBING ROOF PLAN

1/8"=1'-0"

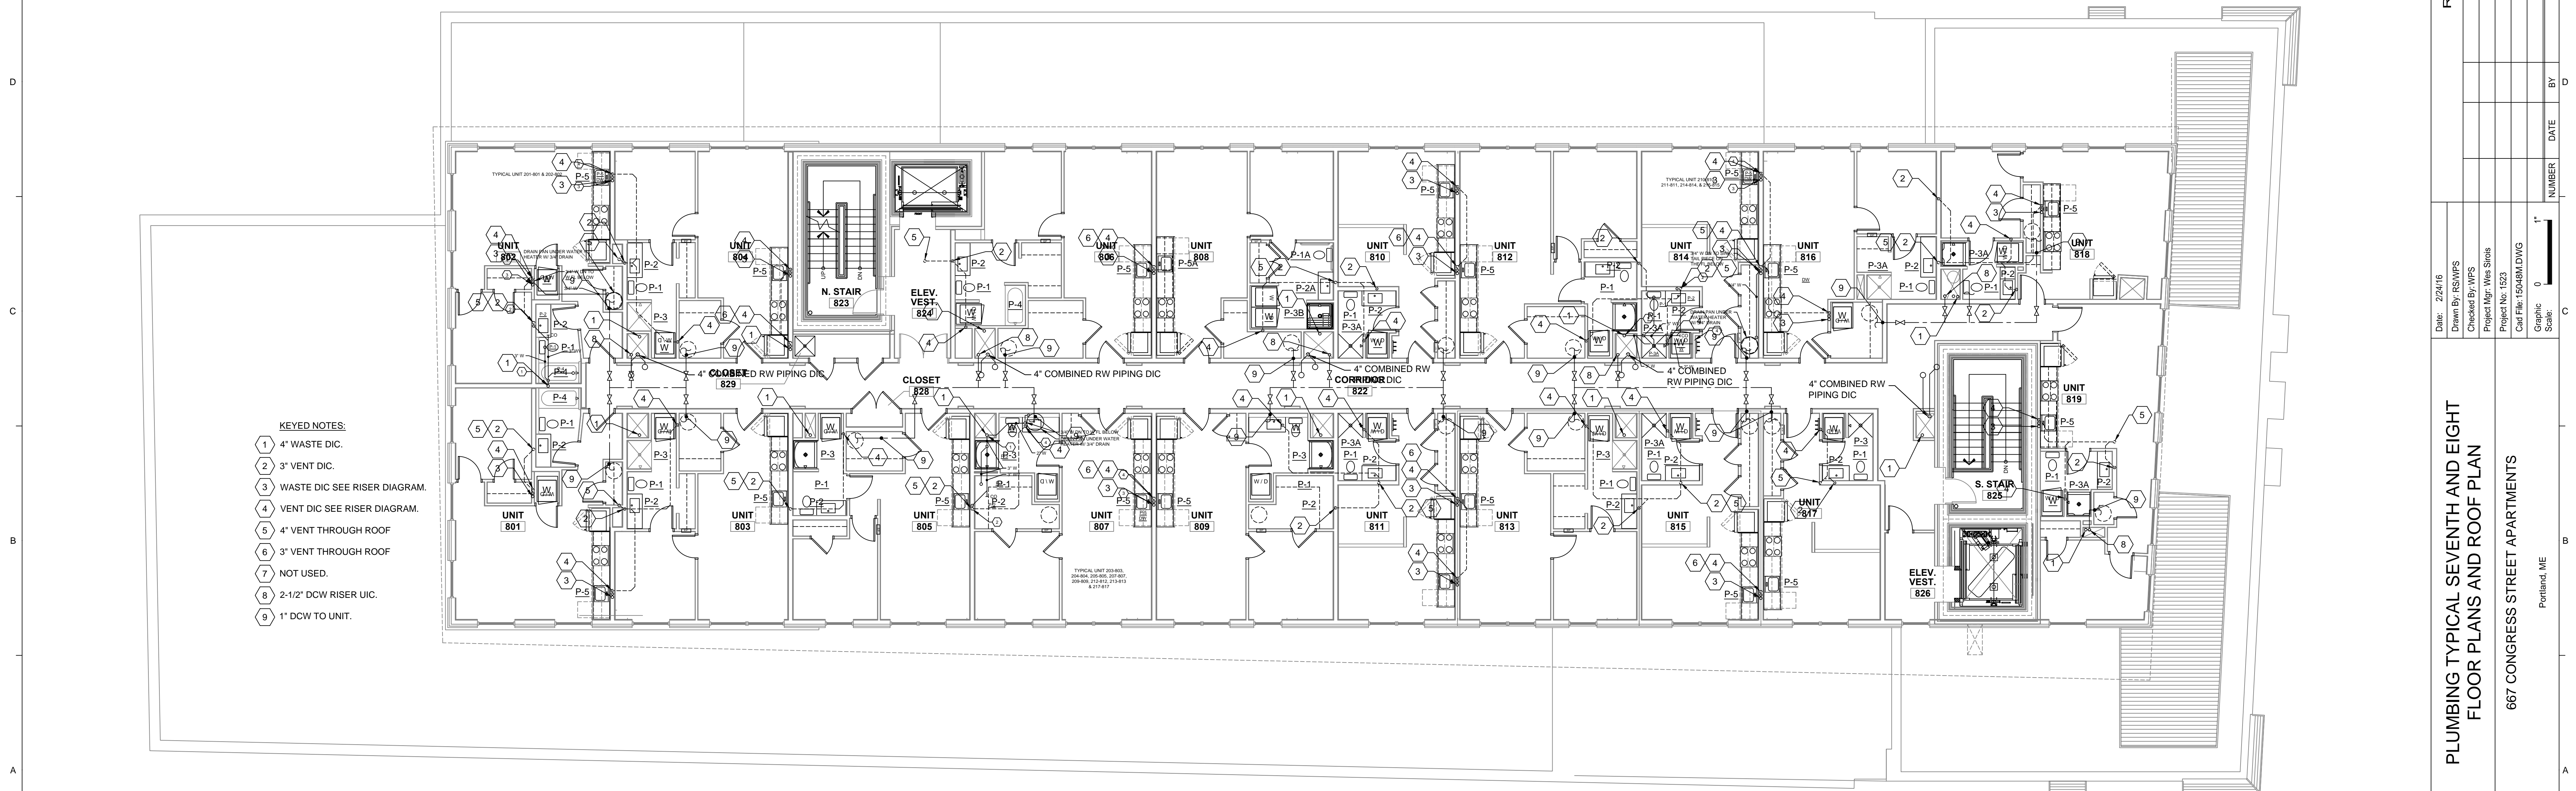

A1 PLUMBING TYPICAL SEVENTH AND EIGHT FLOOR PLANS

1/8"=1'-0"

REVISIONS

NUMBER	DATE	BY	DESCRIPTION

Date: 2/24/16
 Drawn By: RS/WPS
 Checked By: WPS
 Project Mgr: Wes Strub
 Project No: 1523
 Cad File: 1508R4DWG
 Graphic Scale: 0 1'

PLUMBING TYPICAL SEVENTH AND EIGHT FLOOR PLANS AND ROOF PLAN

667 CONGRESS STREET APARTMENTS

Portland, ME

P1-2

PERMIT SET ~ 24 February 2016 - NOT FOR CONSTRUCTION

