

B-H-Miliken
ELECTRICAL CONTRACTORS

175 ANDERSON STREET
PORTLAND, MAINE 04101
207.879.1877

667 CONGRESS STREET
APARTMENTS
667 CONGRESS ST
PORTLAND, MAINE

TITLE:

3RD FLOOR


REV1: 2/22/16

SCALE: 1/8" = 1'-0"

DATE: 1/29/2016

SHEET:

E2.2

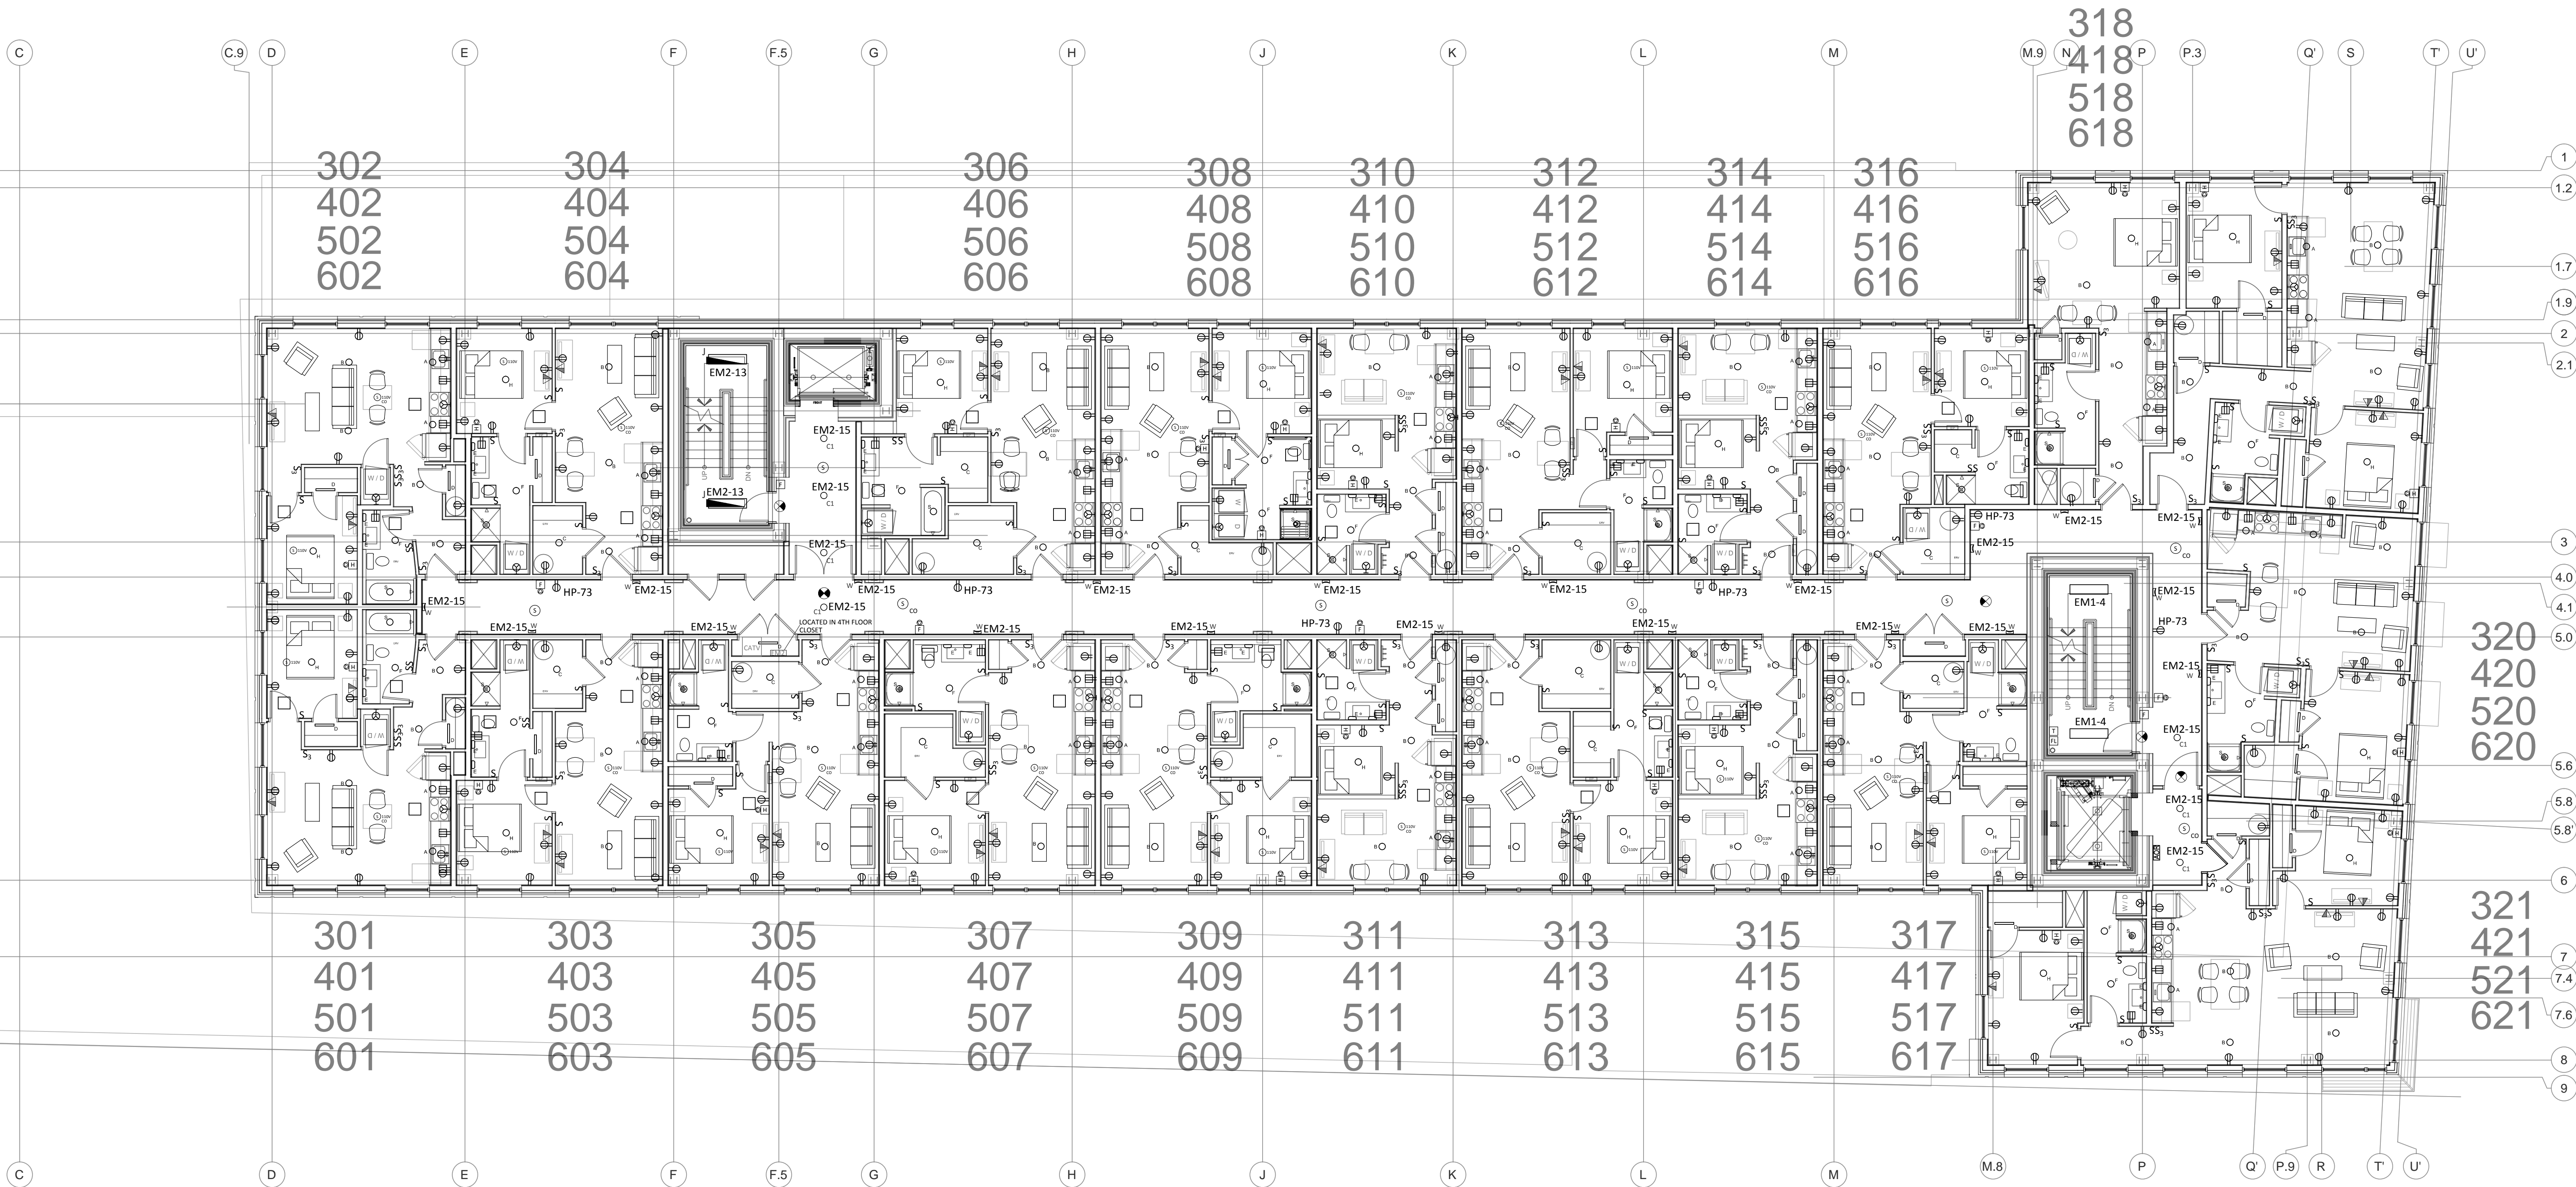

NOTE: ADA COMPLIANT ROOMS (208-808)

NOTE: CIRCUITING SHOWN FOR FLOOR 3 ONLY. REFER TO PANEL SCHEDULES FOR CIRCUITS ON FLOORS 4-6.

NOTE: EXIT SIGNS TO BE CONNECTED TO SAME LIGHTING CIRCUIT AS AREA SERVED.

