


E1 MECHANICAL ROOF PLAN
1/8"=1'-0"

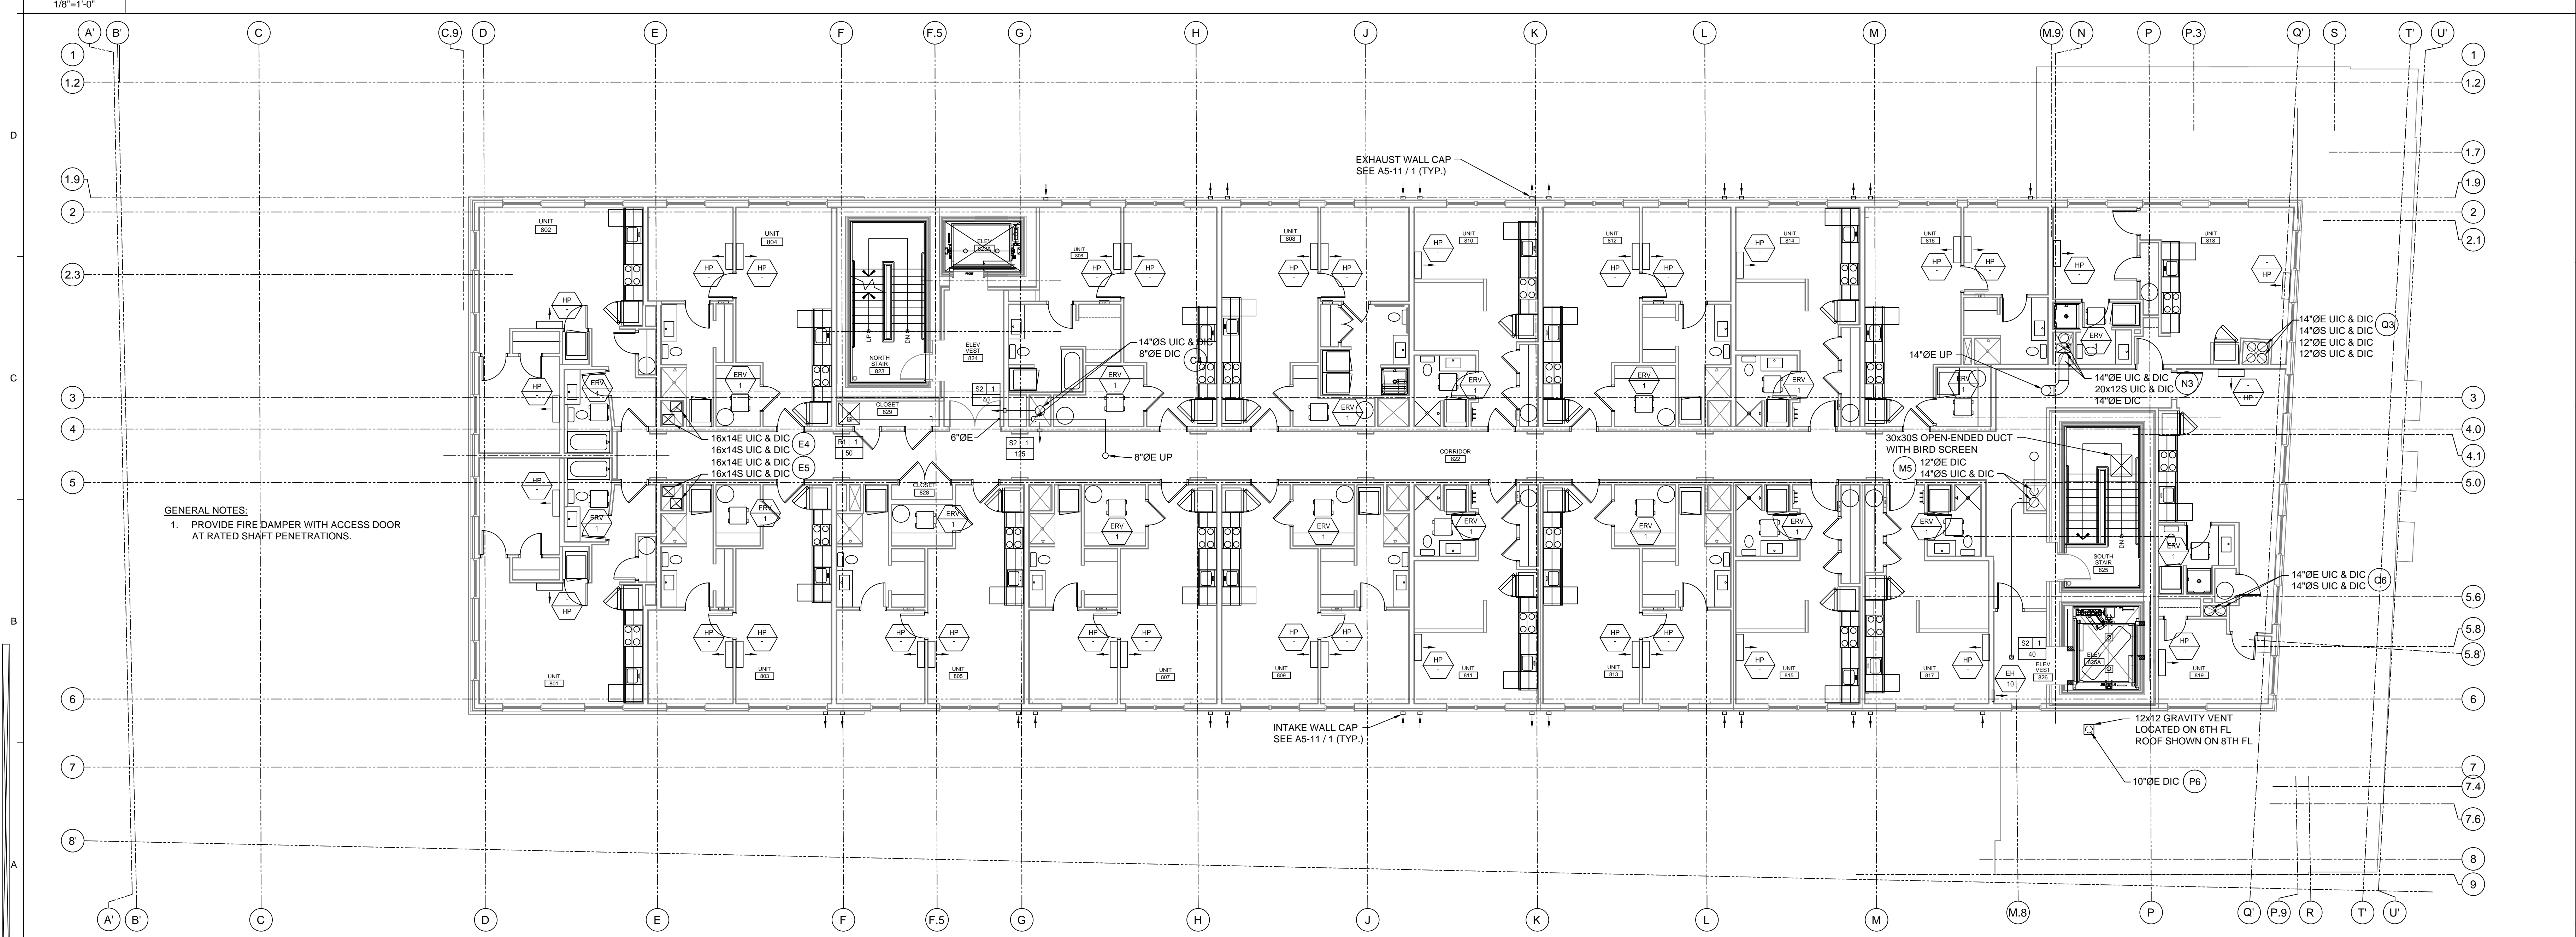

A1 MECHANICAL TYPICAL SEVENTH AND EIGHT FLOOR PLANS
1/8"=1'-0"

RMI
 RMI Mechanical
 P.O. Box 5038
 962 Main Street
 North Jay, ME 04956

STATE OF MAINE
 REGISTERED PROFESSIONAL ENGINEER
 11015
 000005

| REVISIONS | DATE | BY | NUMBER | DESCRIPTION |
|-----------|------|----|--------|-------------|
| | | | | |

Date: 1/29/16
 Drawn By: SCL/WPS
 Checked By: WPS
 Project Mgr: Wes Strub
 Project No: 1523
 Cad File: 1508RMDWG
 Graphic Scale: 0' 1"

MECHANICAL TYPICAL SEVENTH AND EIGHT FLOOR PLAN AND ROOF PLAN
 667 CONGRESS STREET APARTMENTS
 Portland, ME

M1-2
 PERMIT SET ~ 29 January 2016 - NOT FOR CONSTRUCTION