
 UNIVERSITY OF <b>SOUTHERN MAINE</b>	Portland Hall Basement Floor		Date	03-04-04
	2003-027 Portland Hall Fire Alarm University of Southern Maine Portland Campus		Scale	1/16"=1'
			Page	1 of 11

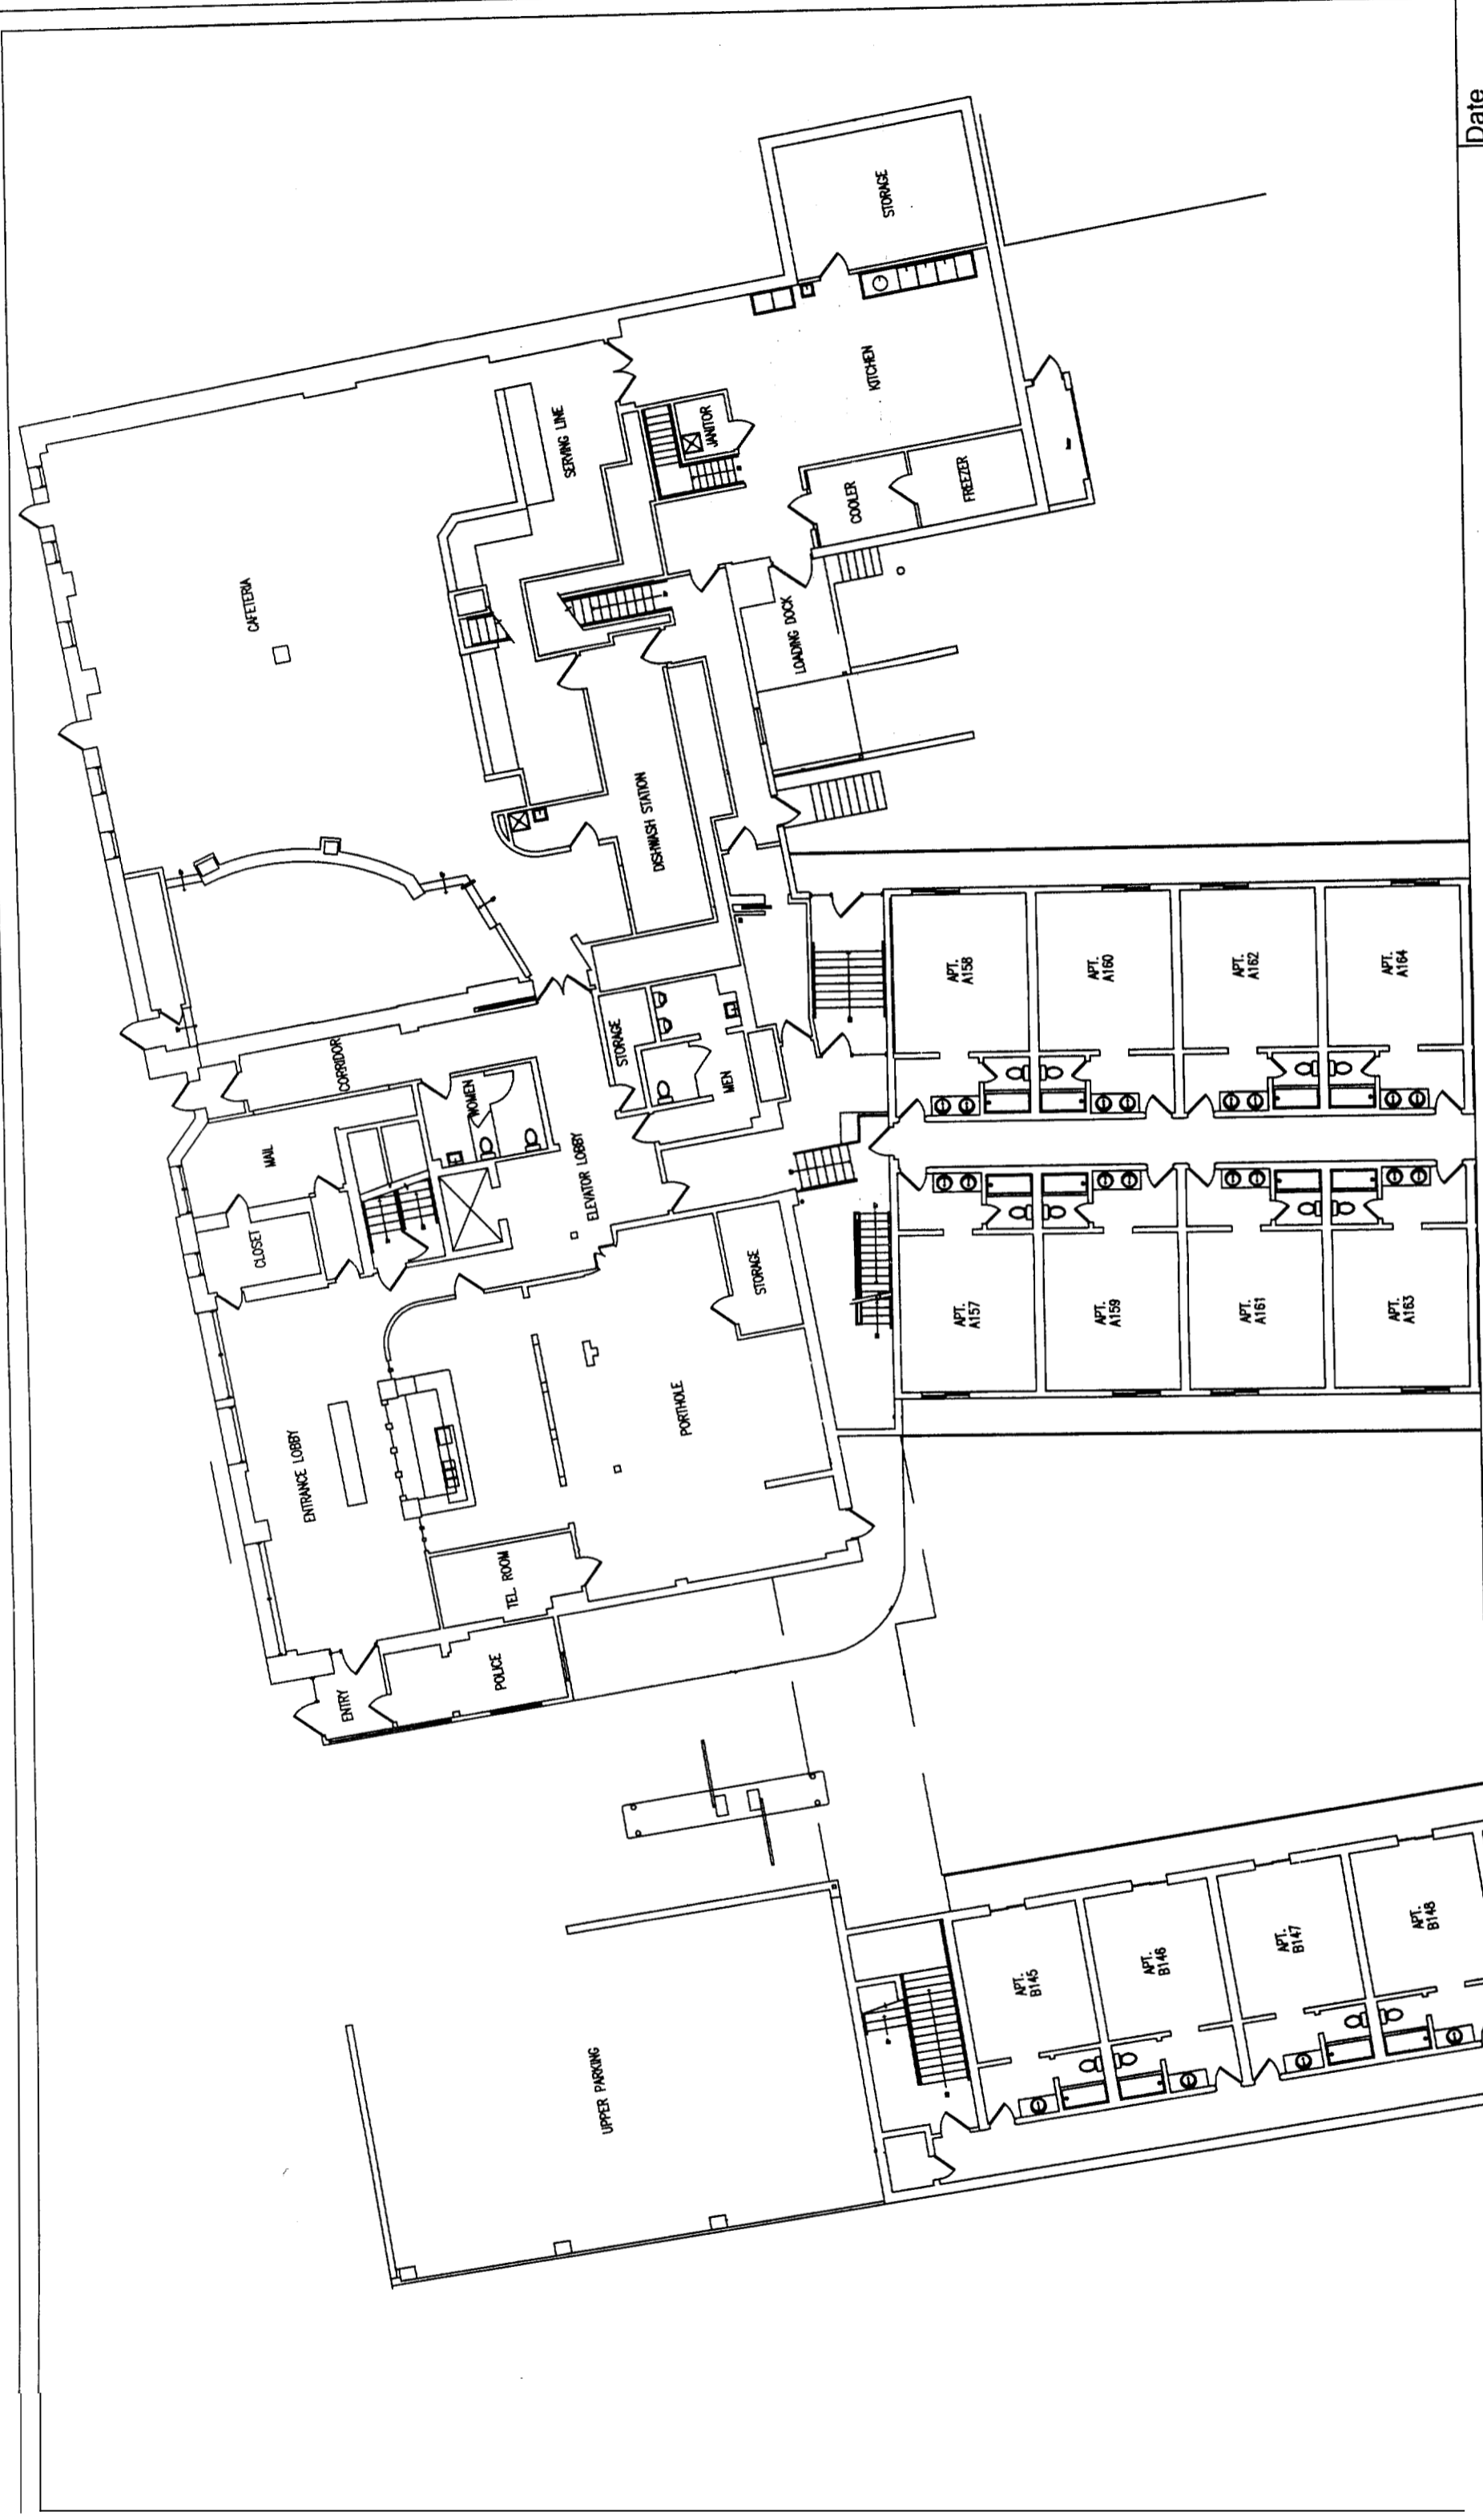

Portland Hall First Floor Main Building

2003-027 Portland Hall Fire Alarm University of Southern Maine Portland Campus



UNIVERSITY OF  
SOUTHERN MAINE



Portland Hall First Floor Plan Wing A & B

2003-027 Portland Hall Fire Alarm



UNIVERSITY OF  
SOUTHERN MAINE

Date  
03-04-04

Scale  
1/16" = 1'

Page  
3 of 11




Portland Hall First Floor Yankee Clipper


2003-027 Portland Hall Fire Alarm

Date 03-04-04

Scale 1/16"=1'

Page 4 of 11

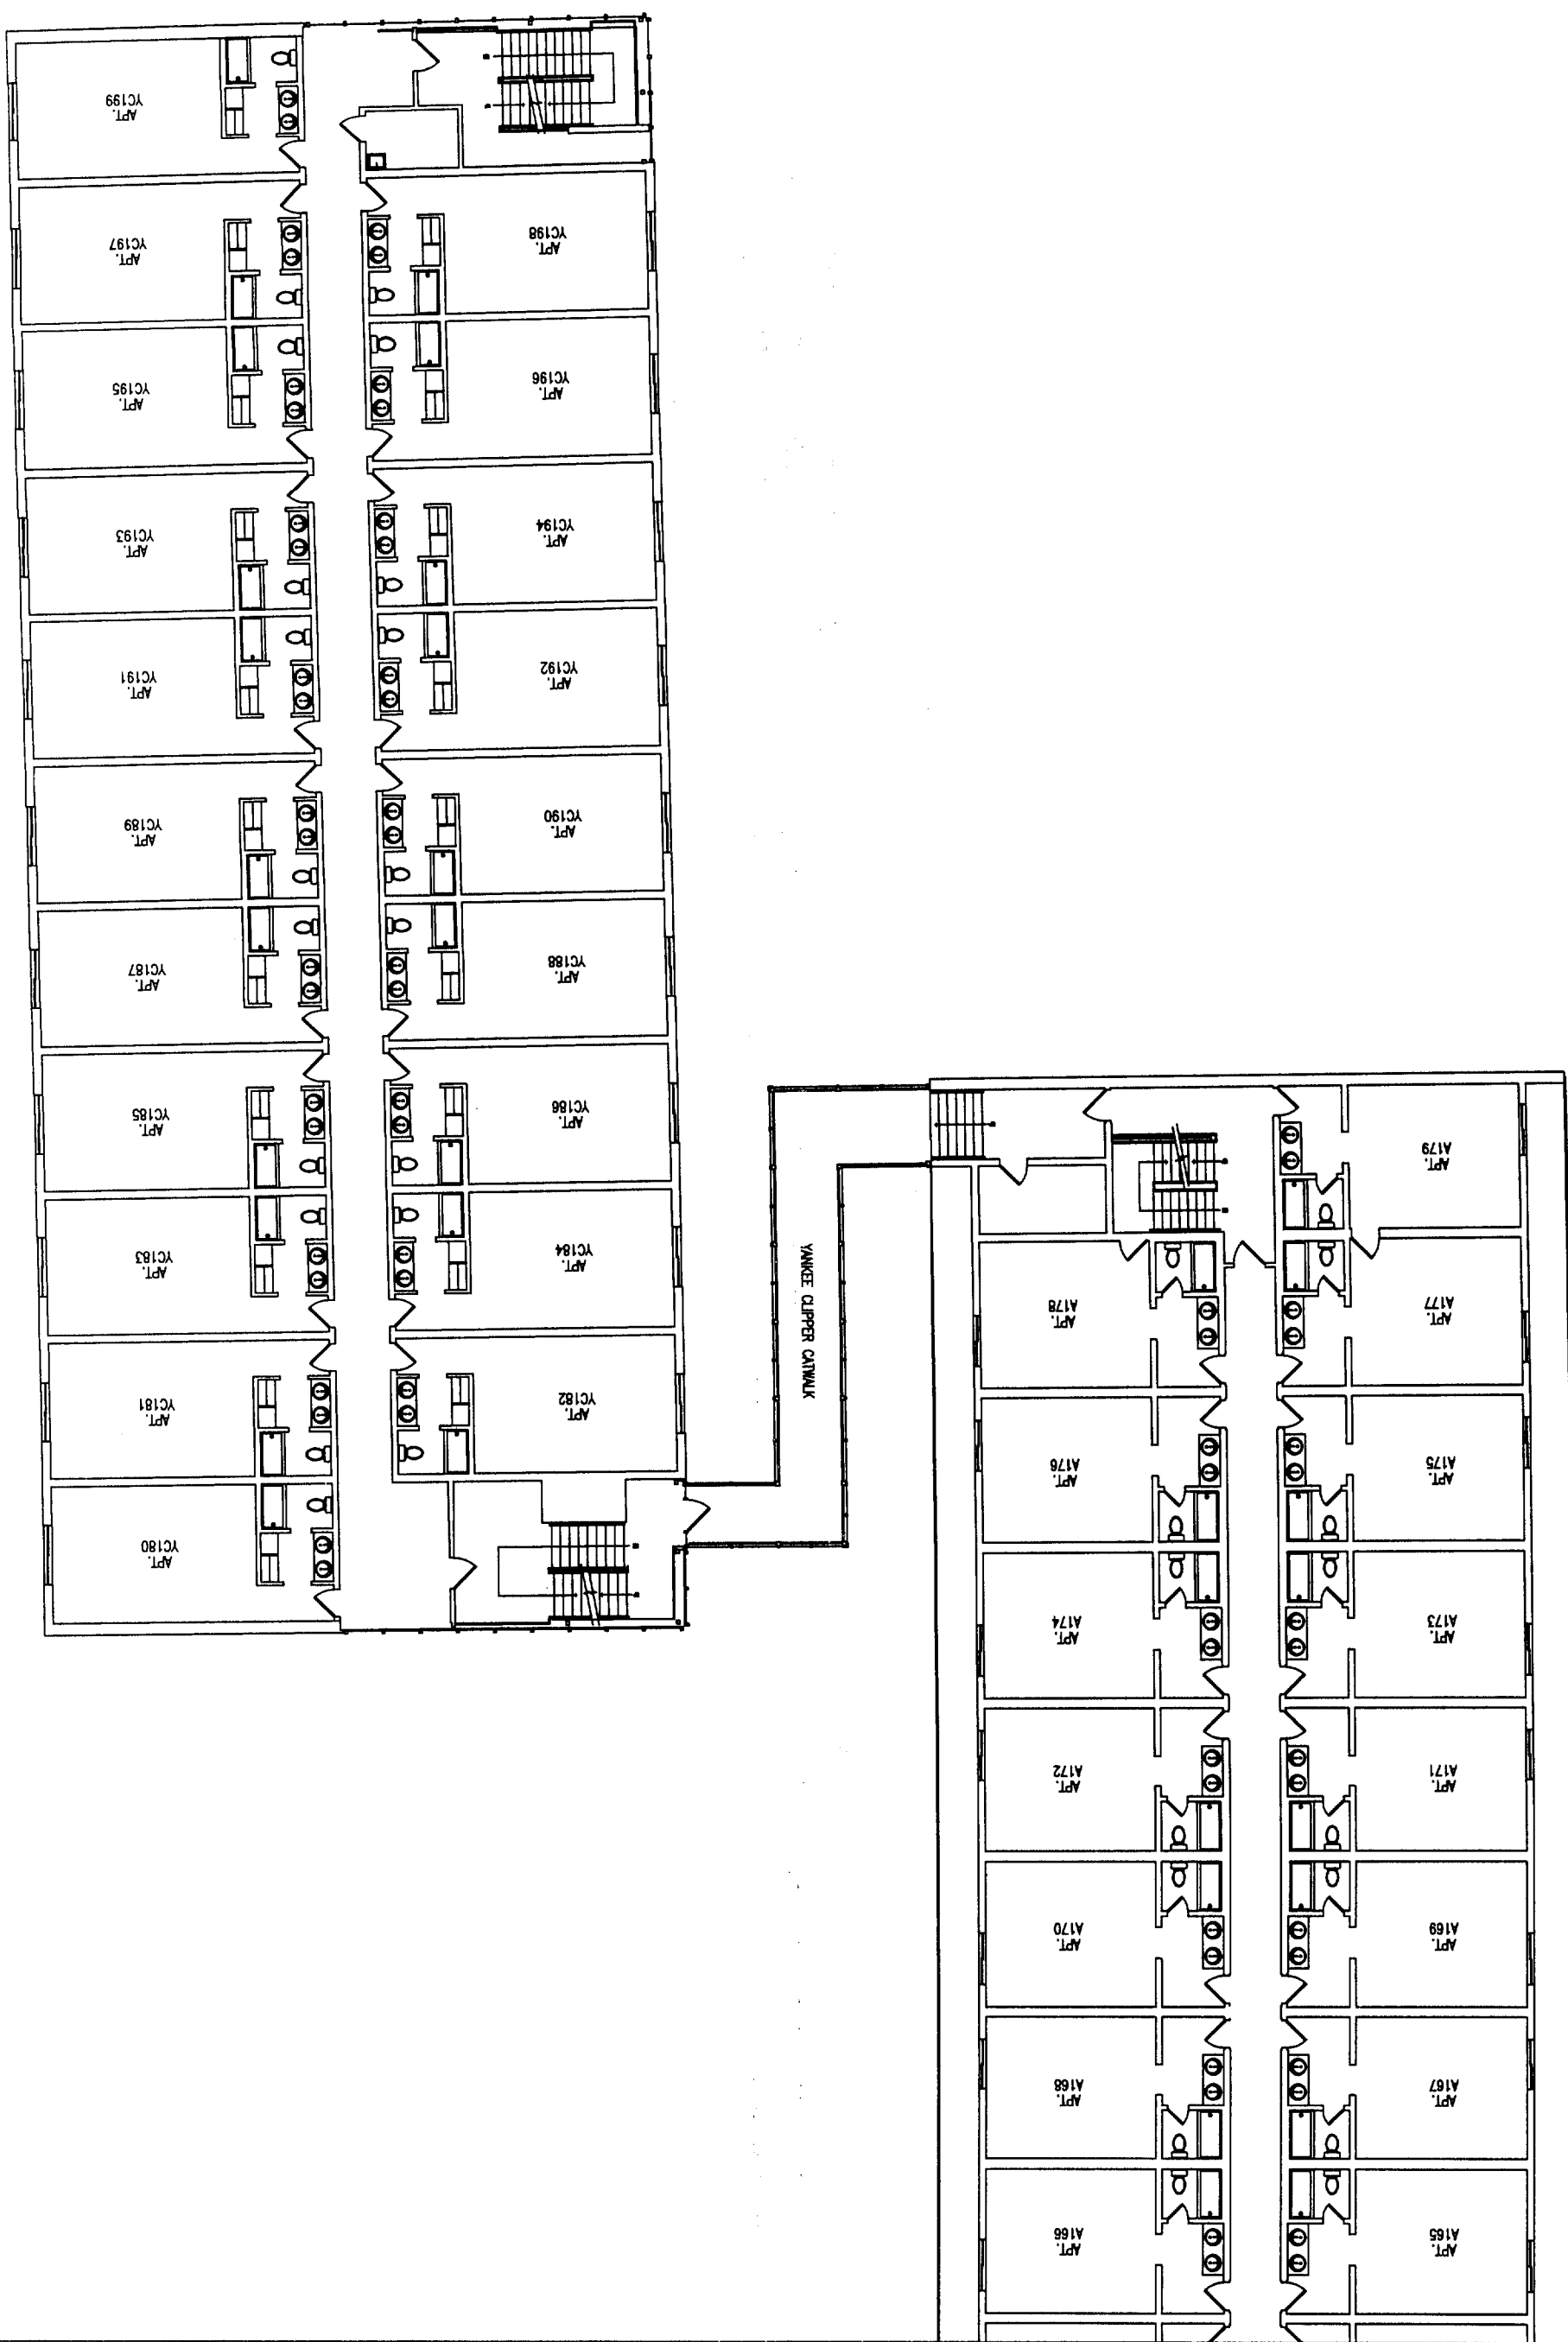

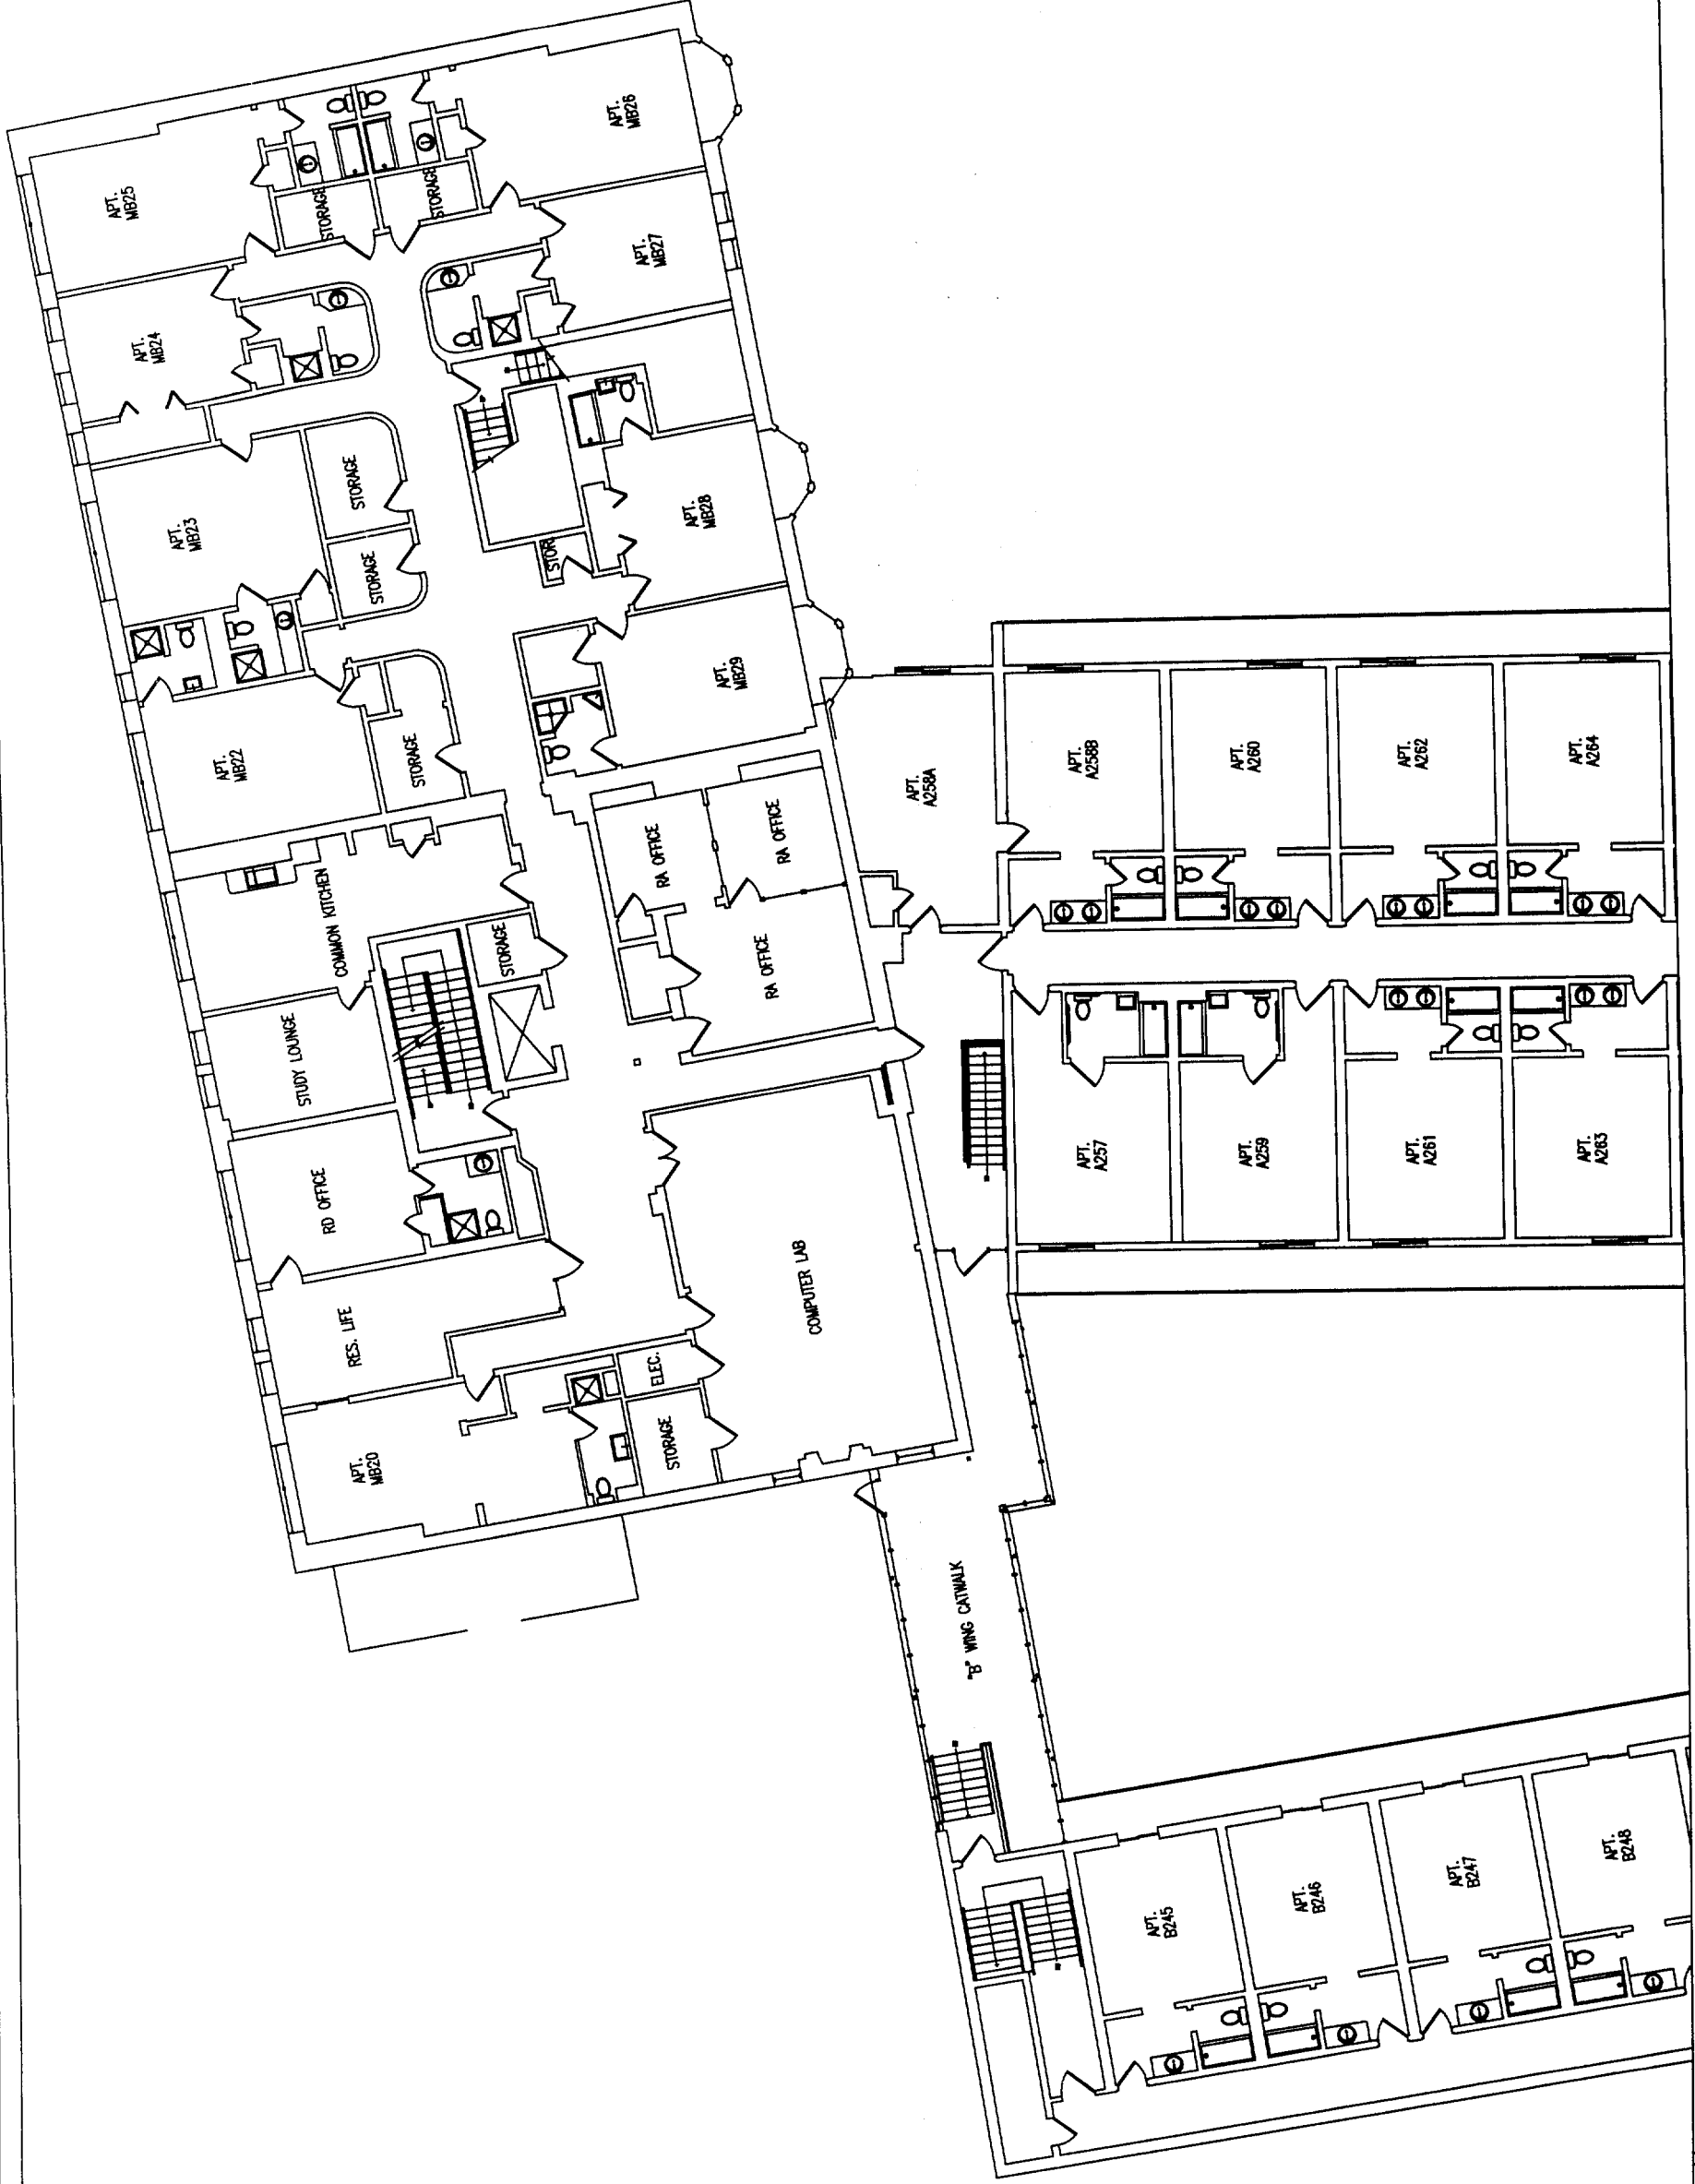



2003-027 Portland Hall Fire Alarm


Portland Hall Second Floor Wing A & B

Wing A and Wing B

Date 03-04-04

Scale 1/16"=1'

Page 6 of 11

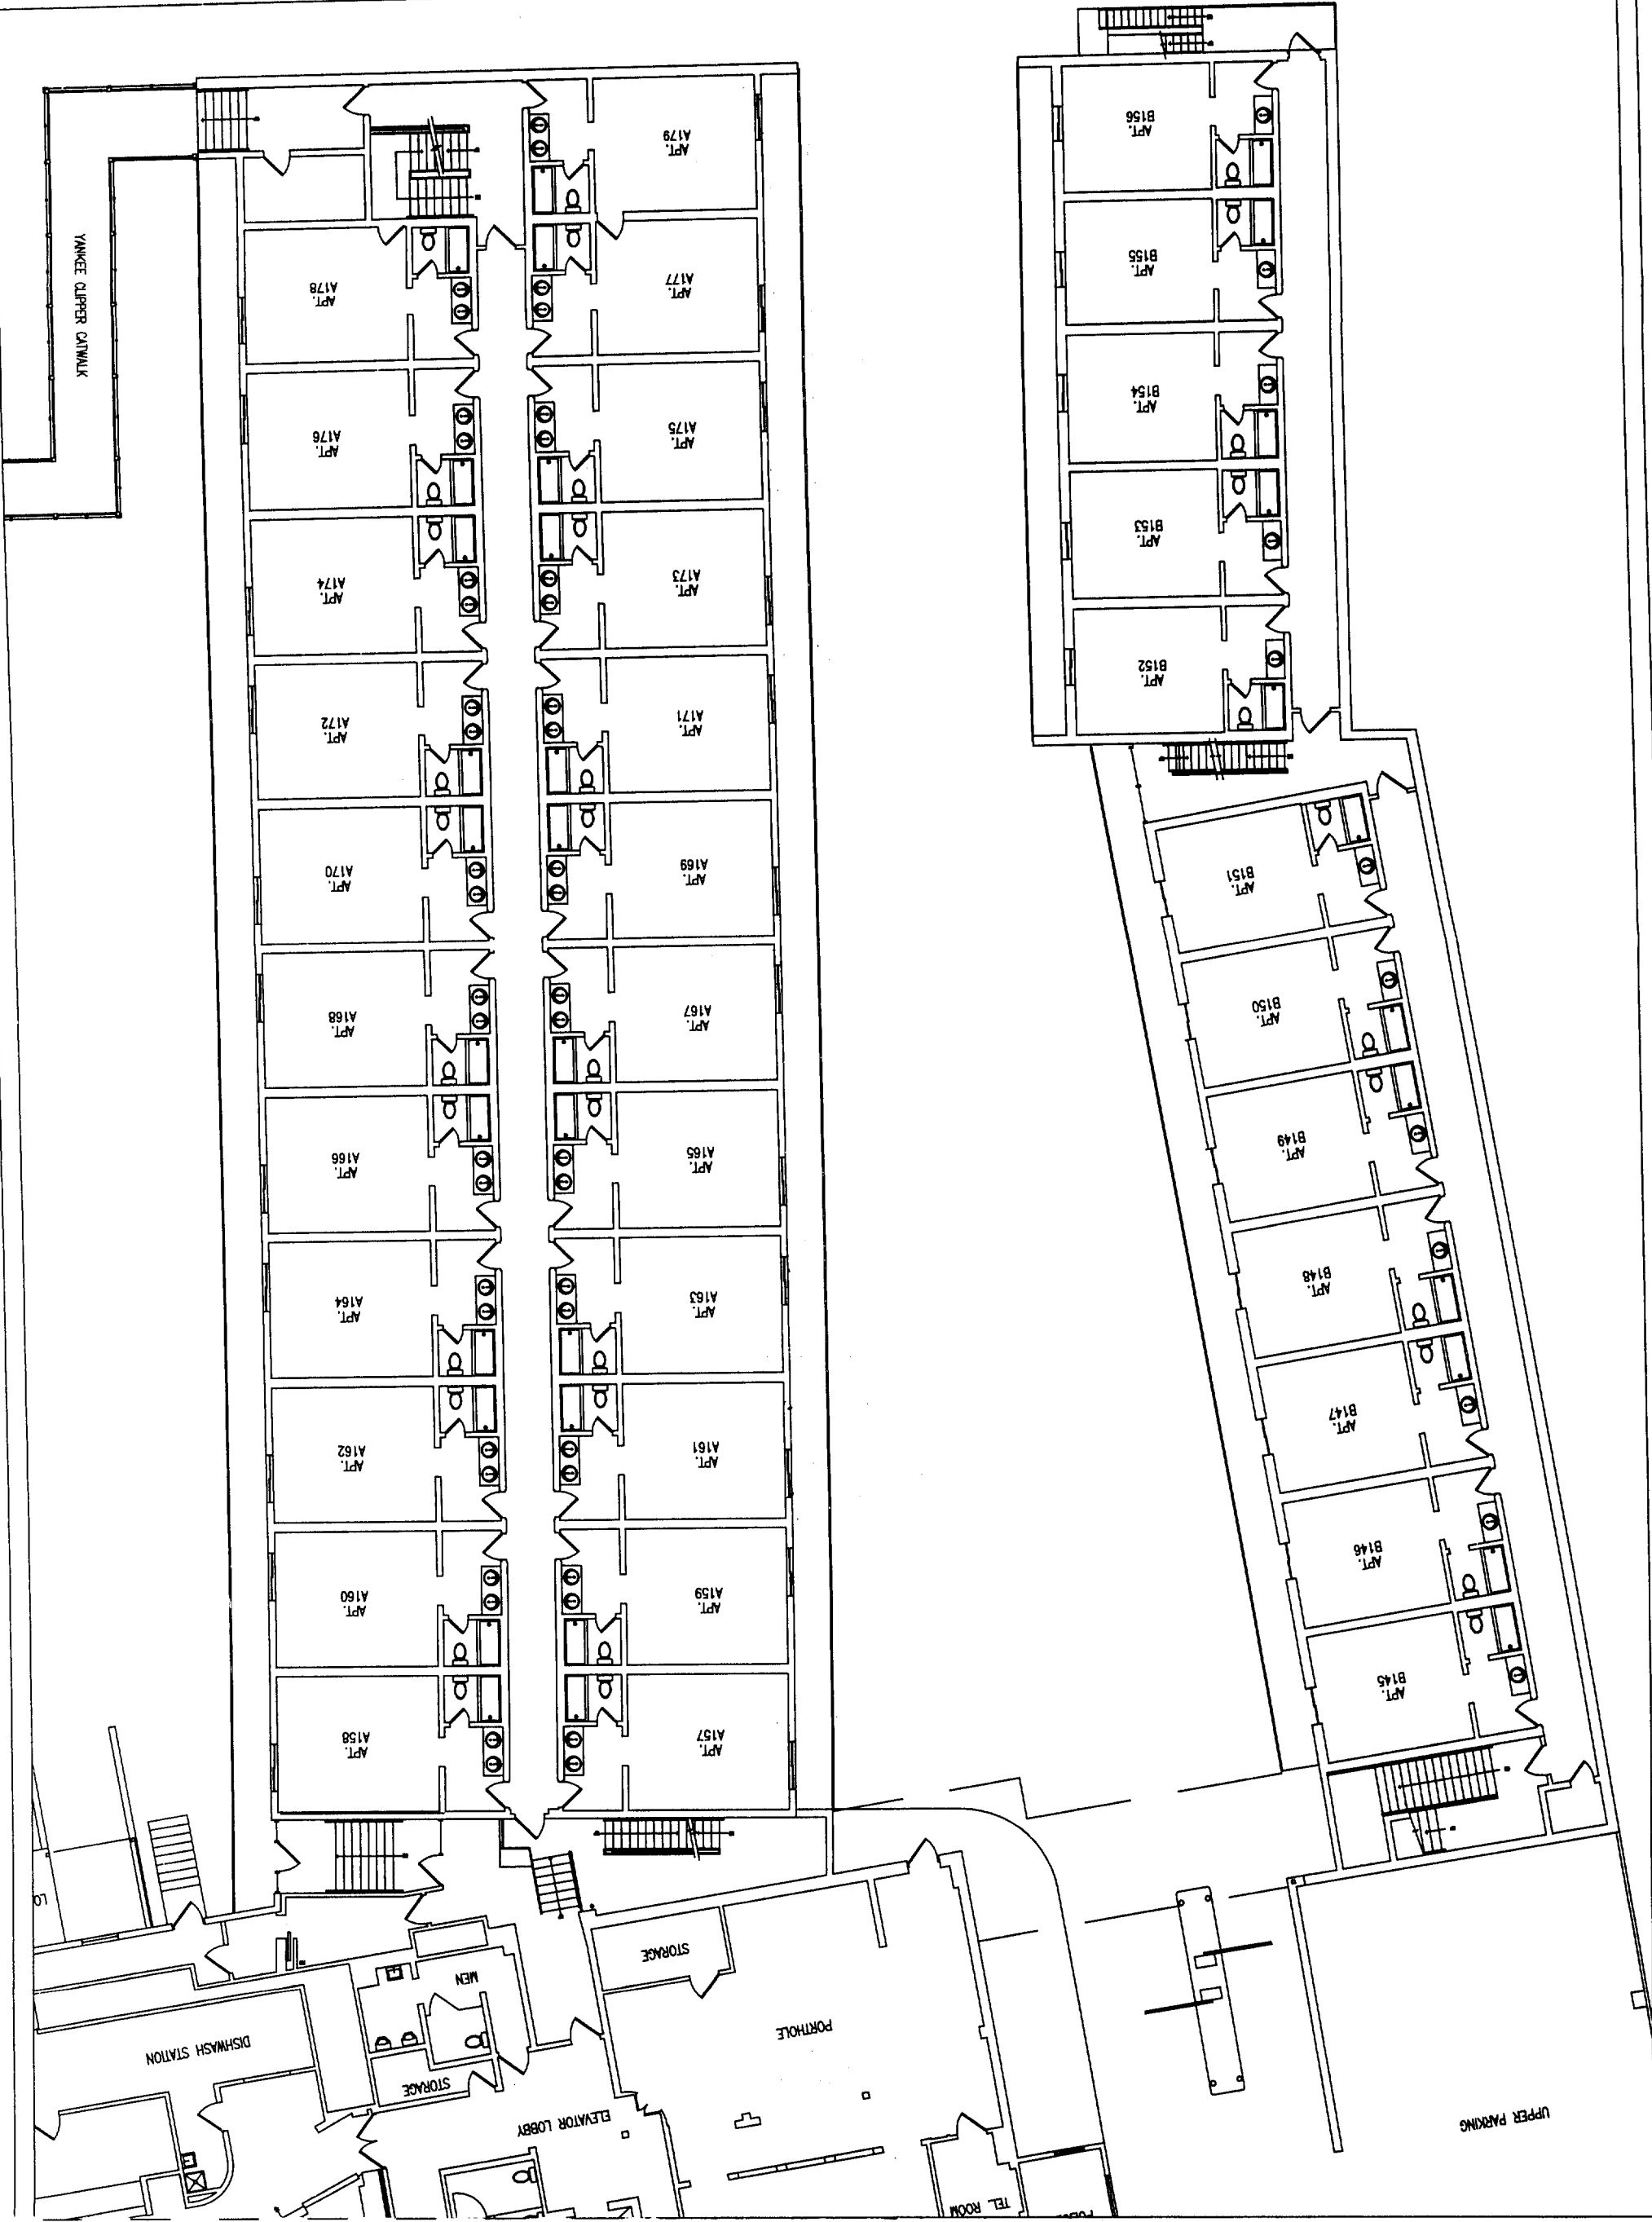




2003-027 Portland Hall Fire Alarm


Portland Hall Second Floor Yankee Clipper

Date 03-04-04

Scale 1/16"=1'

Page 7 of 11

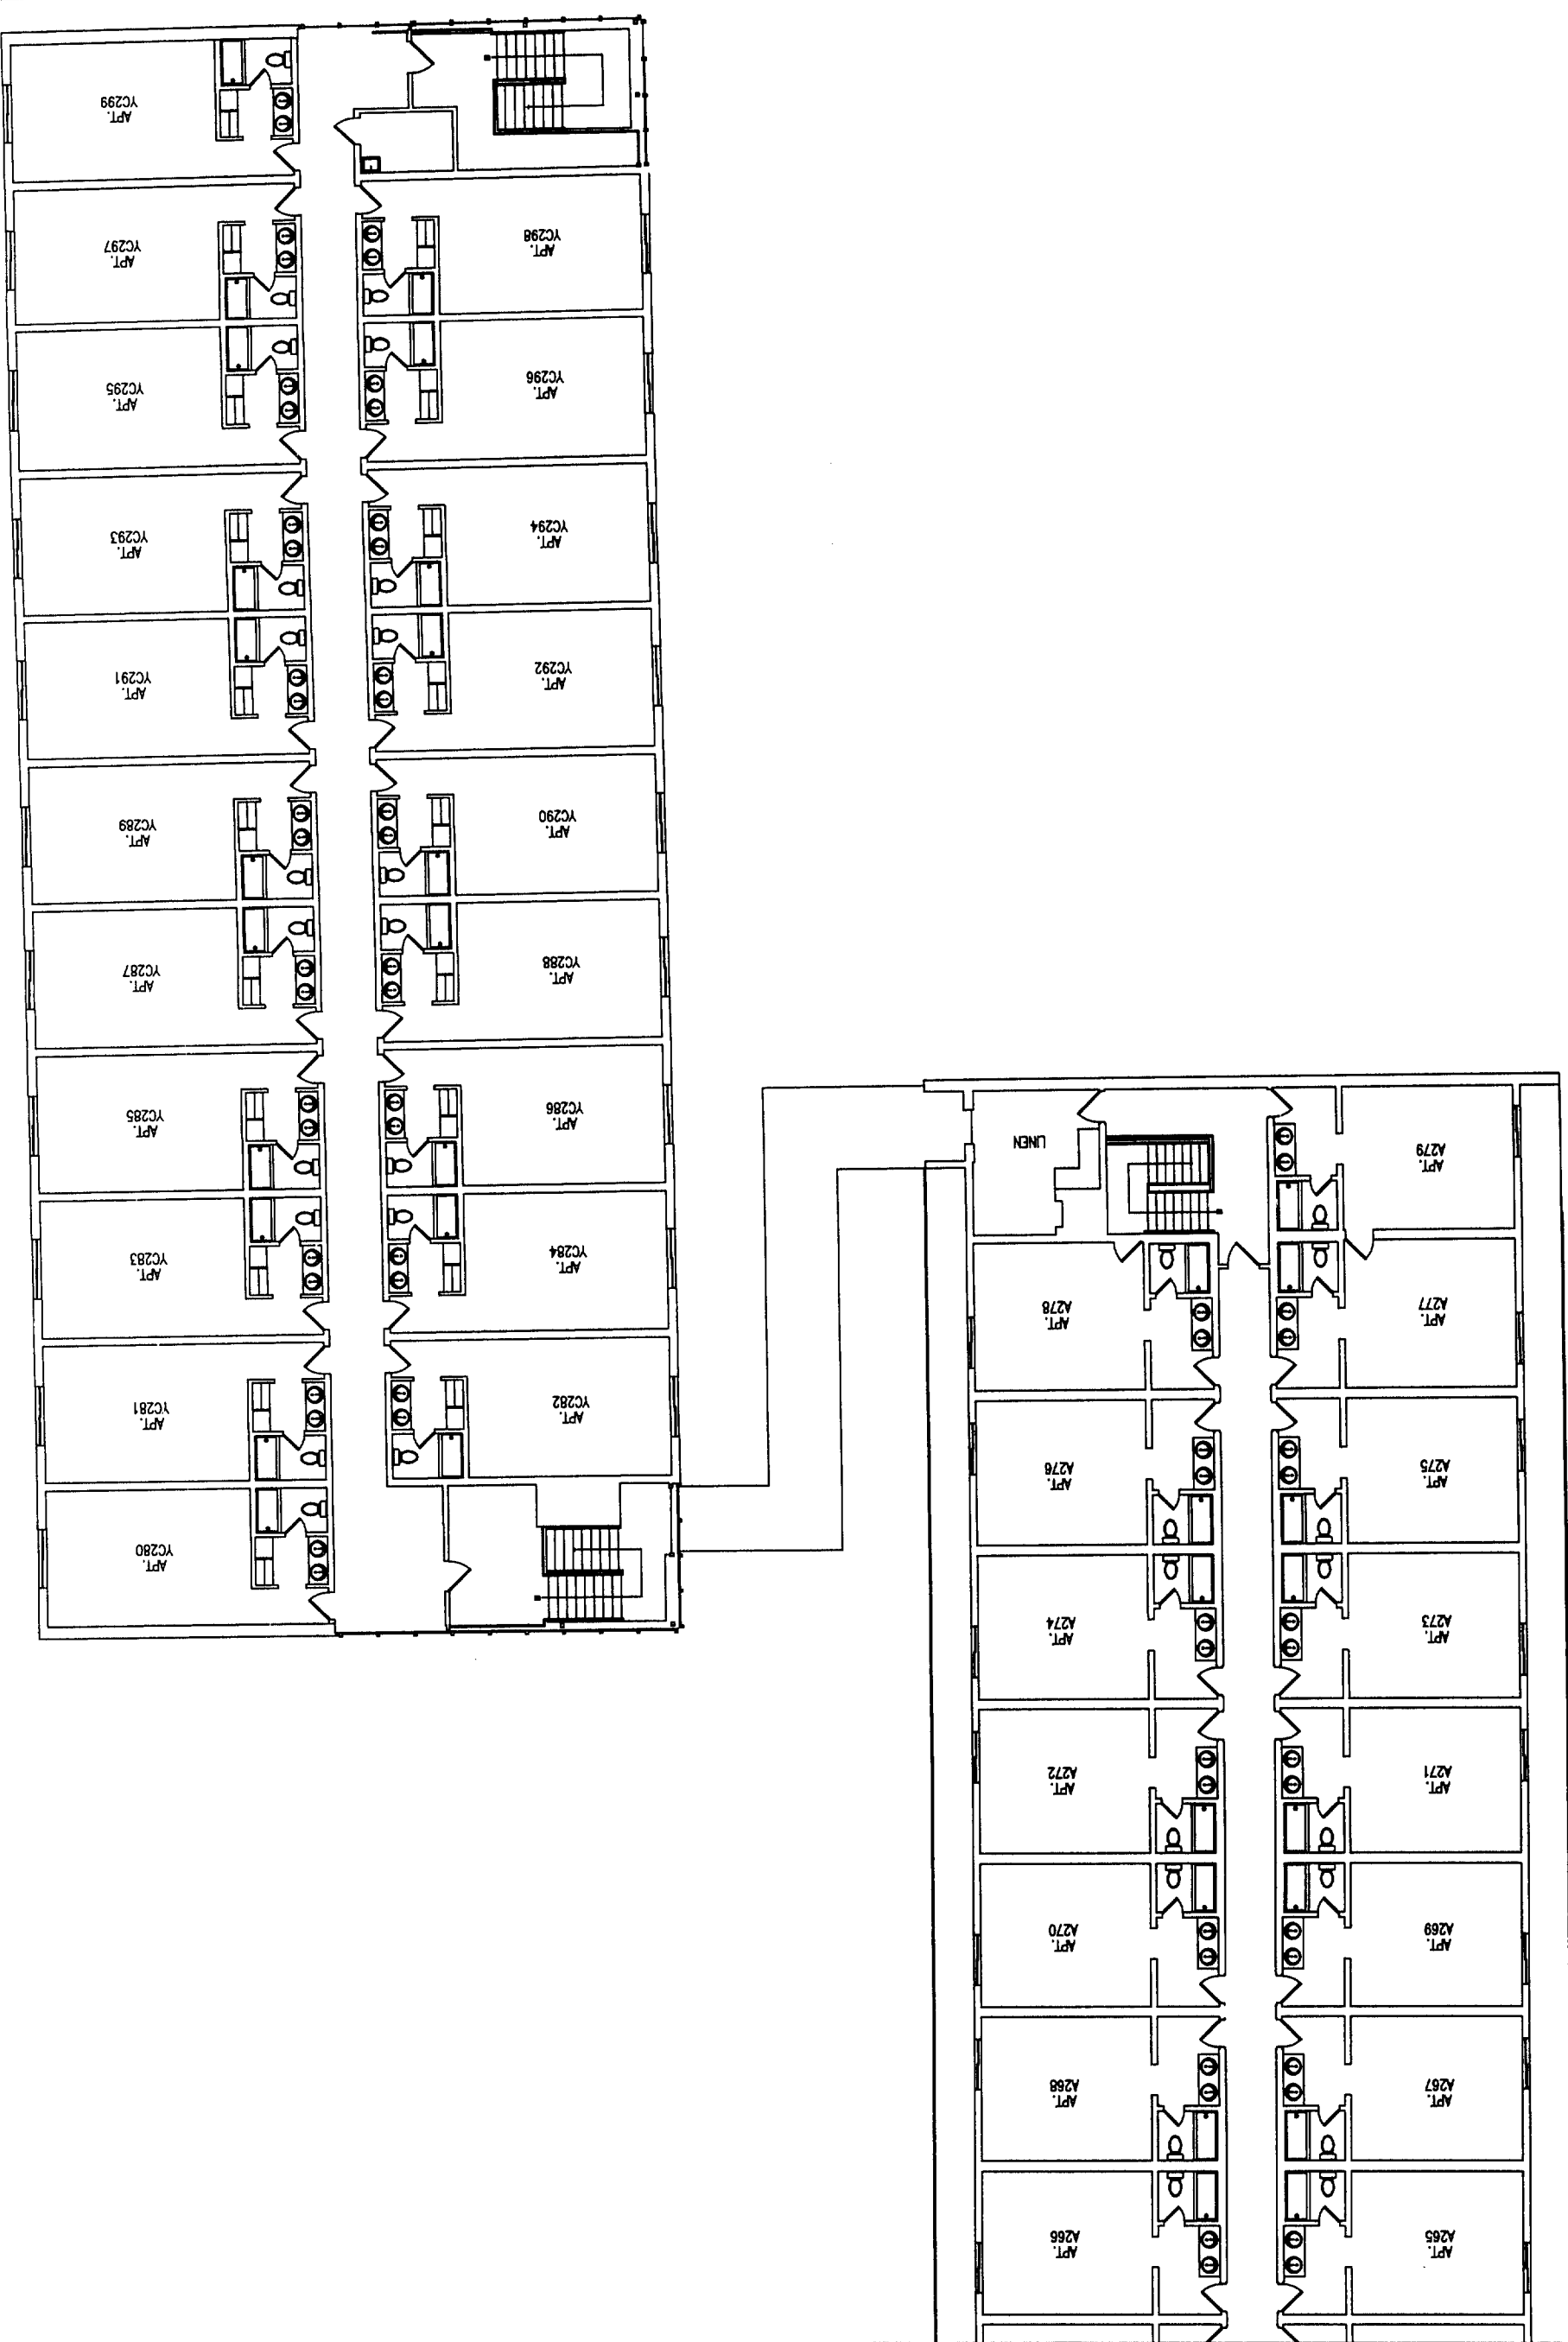

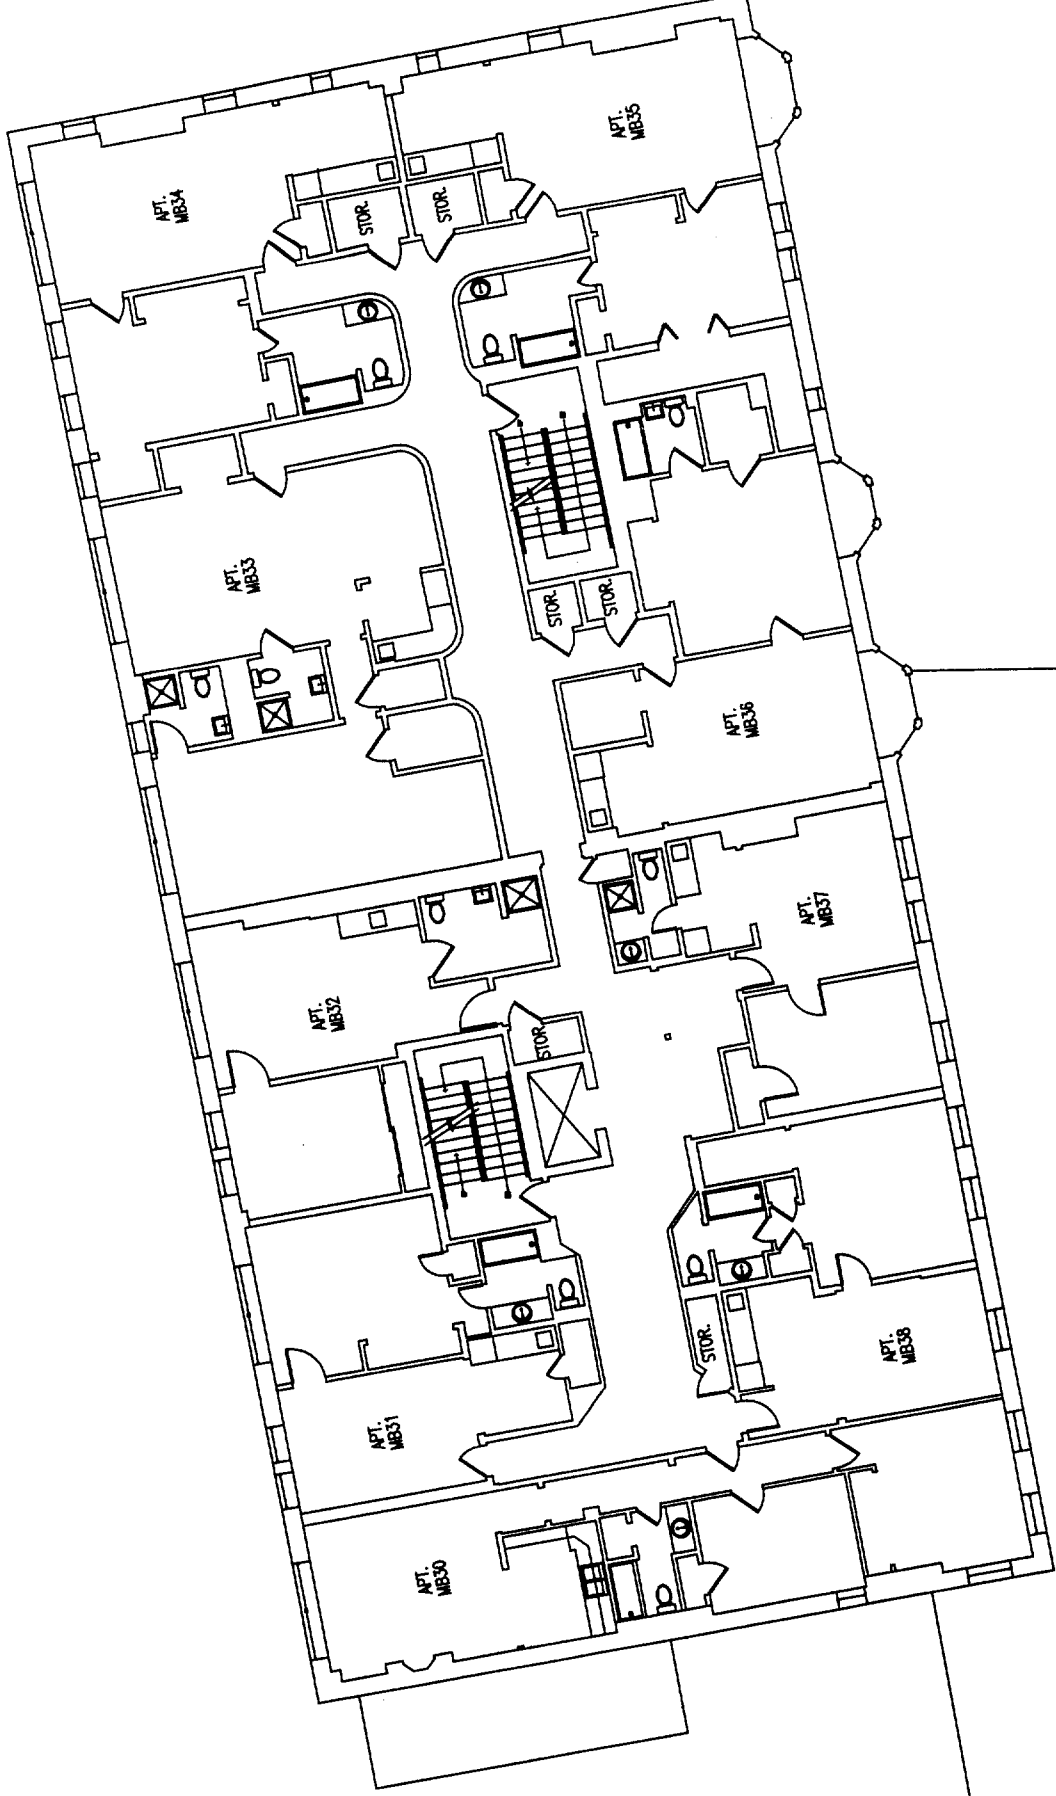

UNIVERSITY OF  
SOUTHERN MAINE

Portland Hall Third Floor Main Building



2003-027 Portland Hall Fire Alarm University of Southern Maine Portland Campus

Scale  
1/16"=1'

Date  
03-04-04

Page  
8 of 11



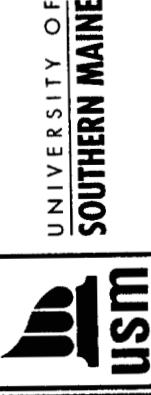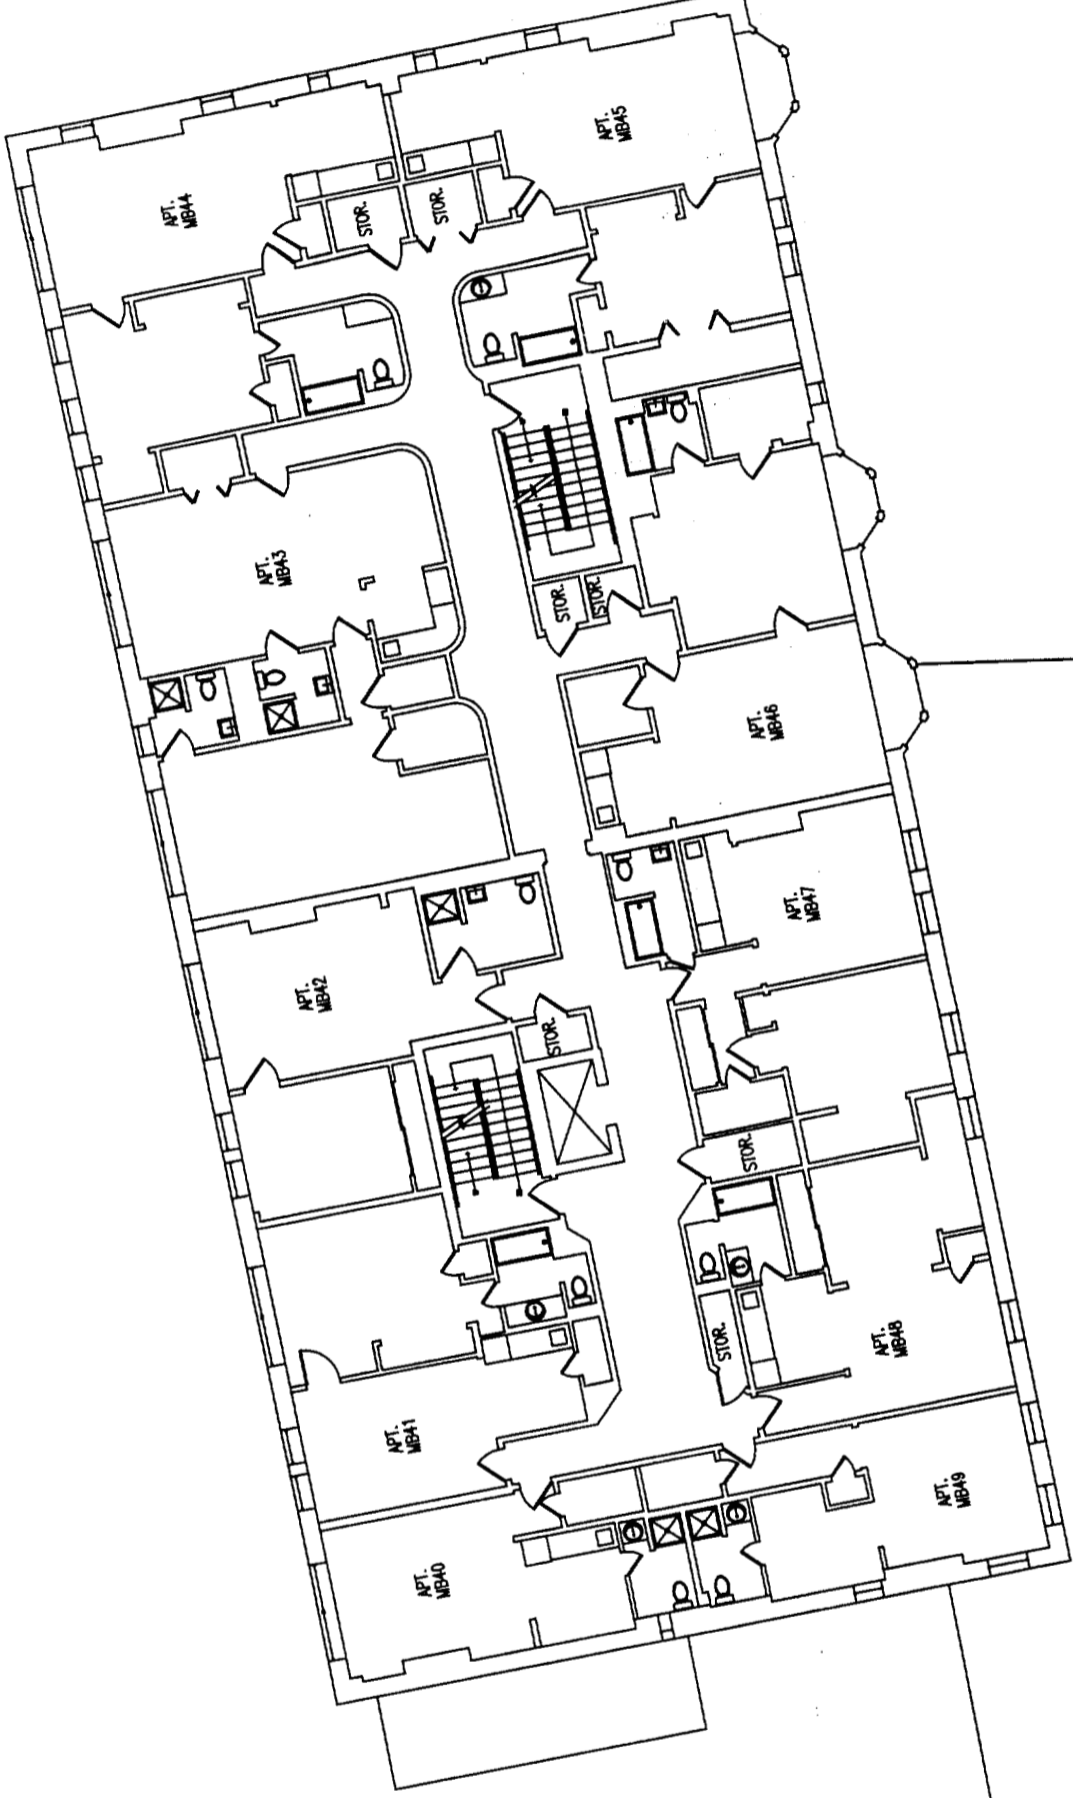

Portland Hall Fourth Floor Main Building

2003-027 Portland Hall Fire Alarm University of Southern Maine Portland Campus

Scale


1/16"=1'

Date

03-04-04

Page

9 of 11

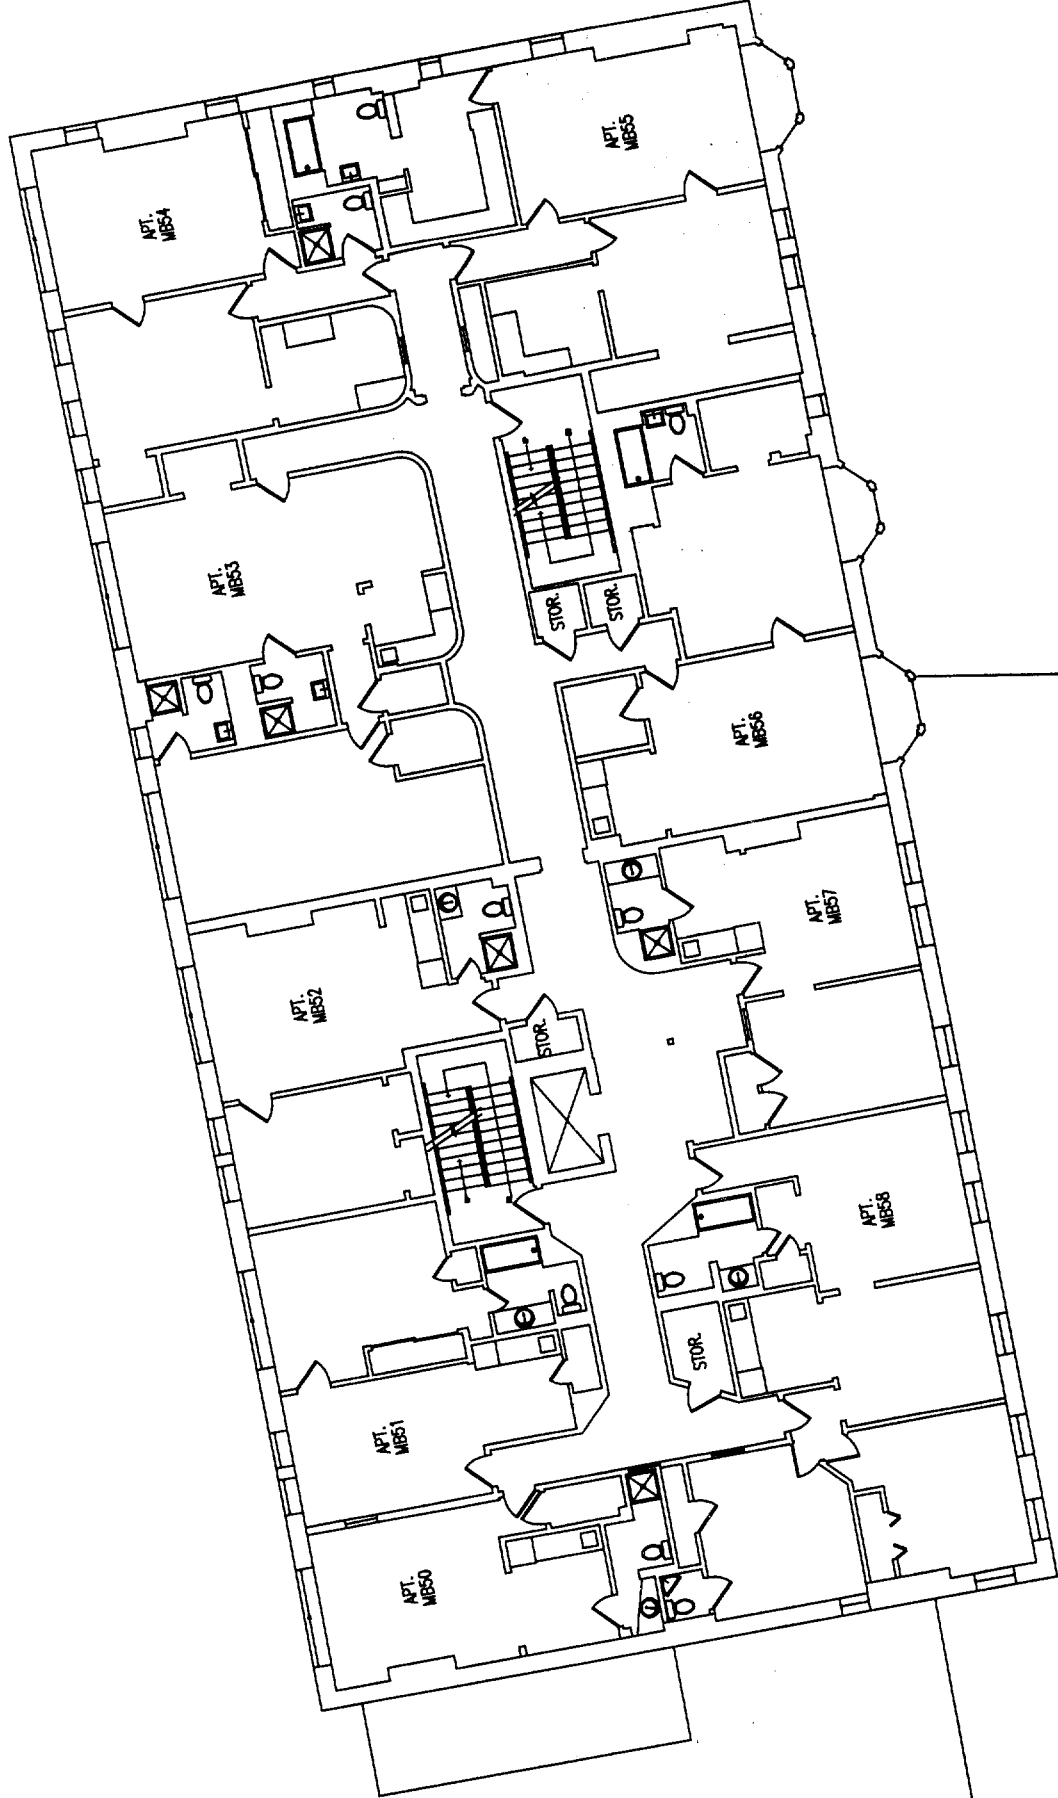

Portland Hall Fifth Floor Main Building

2003-027 Portland Hall Fire Alarm University of Southern Maine Portland Campus



