


BASEMENT

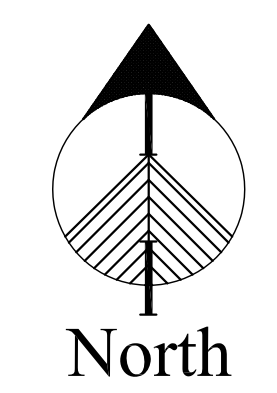

A

BASEMENT FLOOR FIRE ALARM PLAN

SCALE: 1/8" = 1'-0"

NOT FOR CONSTRUCTION

Development Consultant
SHINBERG CONSULTING
 477 CONGRESS ST.
 5TH FLOOR
 PORTLAND, MAINE, 04101

ZADE ASSOCIATES LLC
 CONSULTING ENGINEERS
 140 BRACE STREET, BOSTON, MA 02111
 TEL: (617) 552-6400
 FAX: (617) 451-8540
 E-MAIL: zades@aol.com



RENOVATIONS TO
 645 CONGRESS ST.
 PORTLAND, ME 04101

Project No: 08.436

Drawing Title:

BASEMENT FLOOR FIRE ALARM PLAN

Scale: AS NOTED


Date: 1-20-10

Revisions:


- △
- △
- △
- △
- △
- △

Drawing Number:

FA1.0

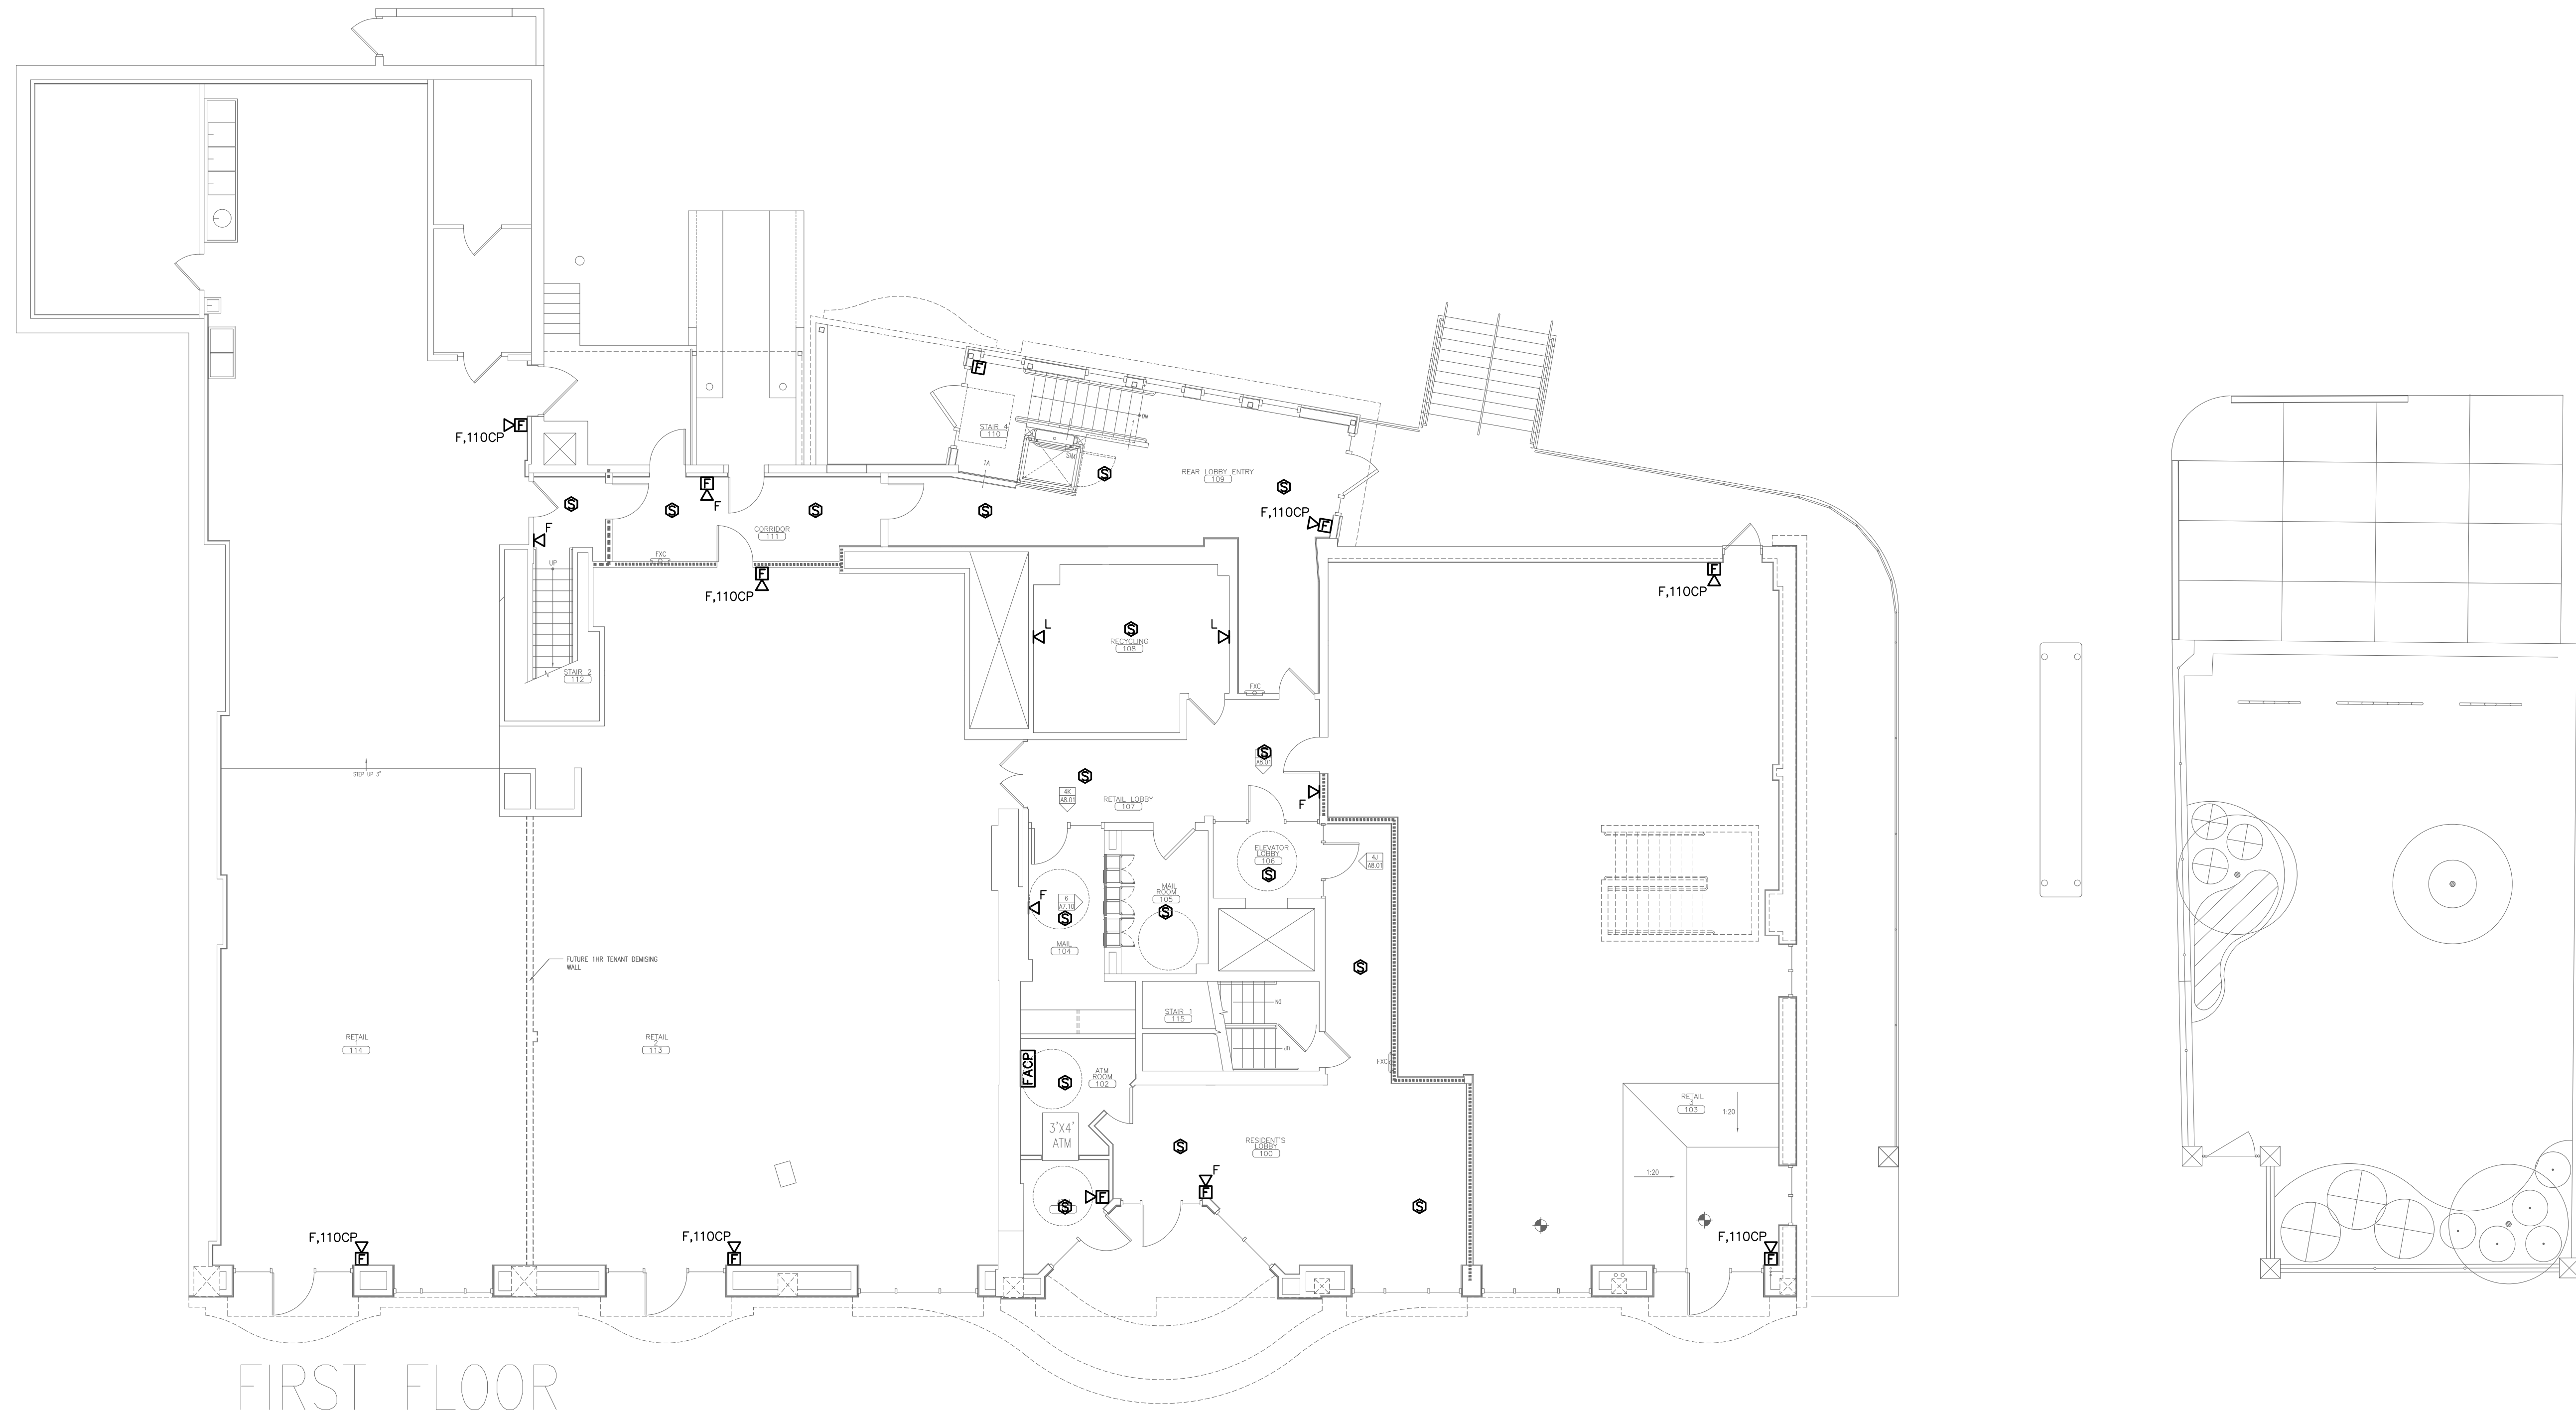

FIRST FLOOR

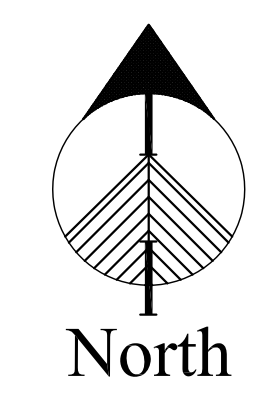


A FIRST FLOOR FIRE ALARM PLAN

SCALE: 1/8" = 1'-0"

NOT FOR CONSTRUCTION

Development Consultant
SHINBERG CONSULTING
 477 CONGRESS ST.
 5TH FLOOR
 PORTLAND, MAINE, 04101

ZADE ASSOCIATES LLC
 CONSULTING ENGINEERS
 140 BRACE STREET, BOSTON, MA 02111
 TEL: (617) 552-6400
 FAX: (617) 451-8540
 E-MAIL: zade@zade.com

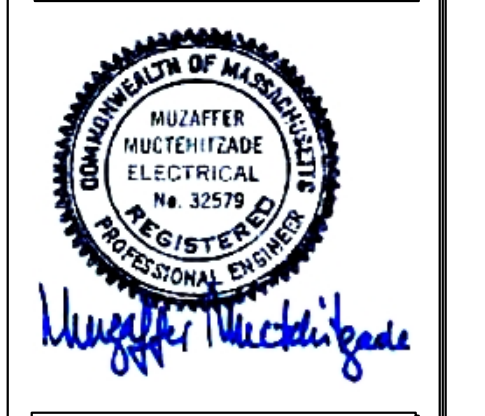

RENOVATIONS TO
 645 CONGRESS ST.
 PORTLAND, ME 04101

Project No: 08.436

Drawing Title:
**FIRST FLOOR
 FIRE ALARM
 PLAN**

Scale: AS NOTED


Date: 1-20-10

Revisions:


- △
- △
- △
- △
- △
- △

Drawing Number:

FA1.1

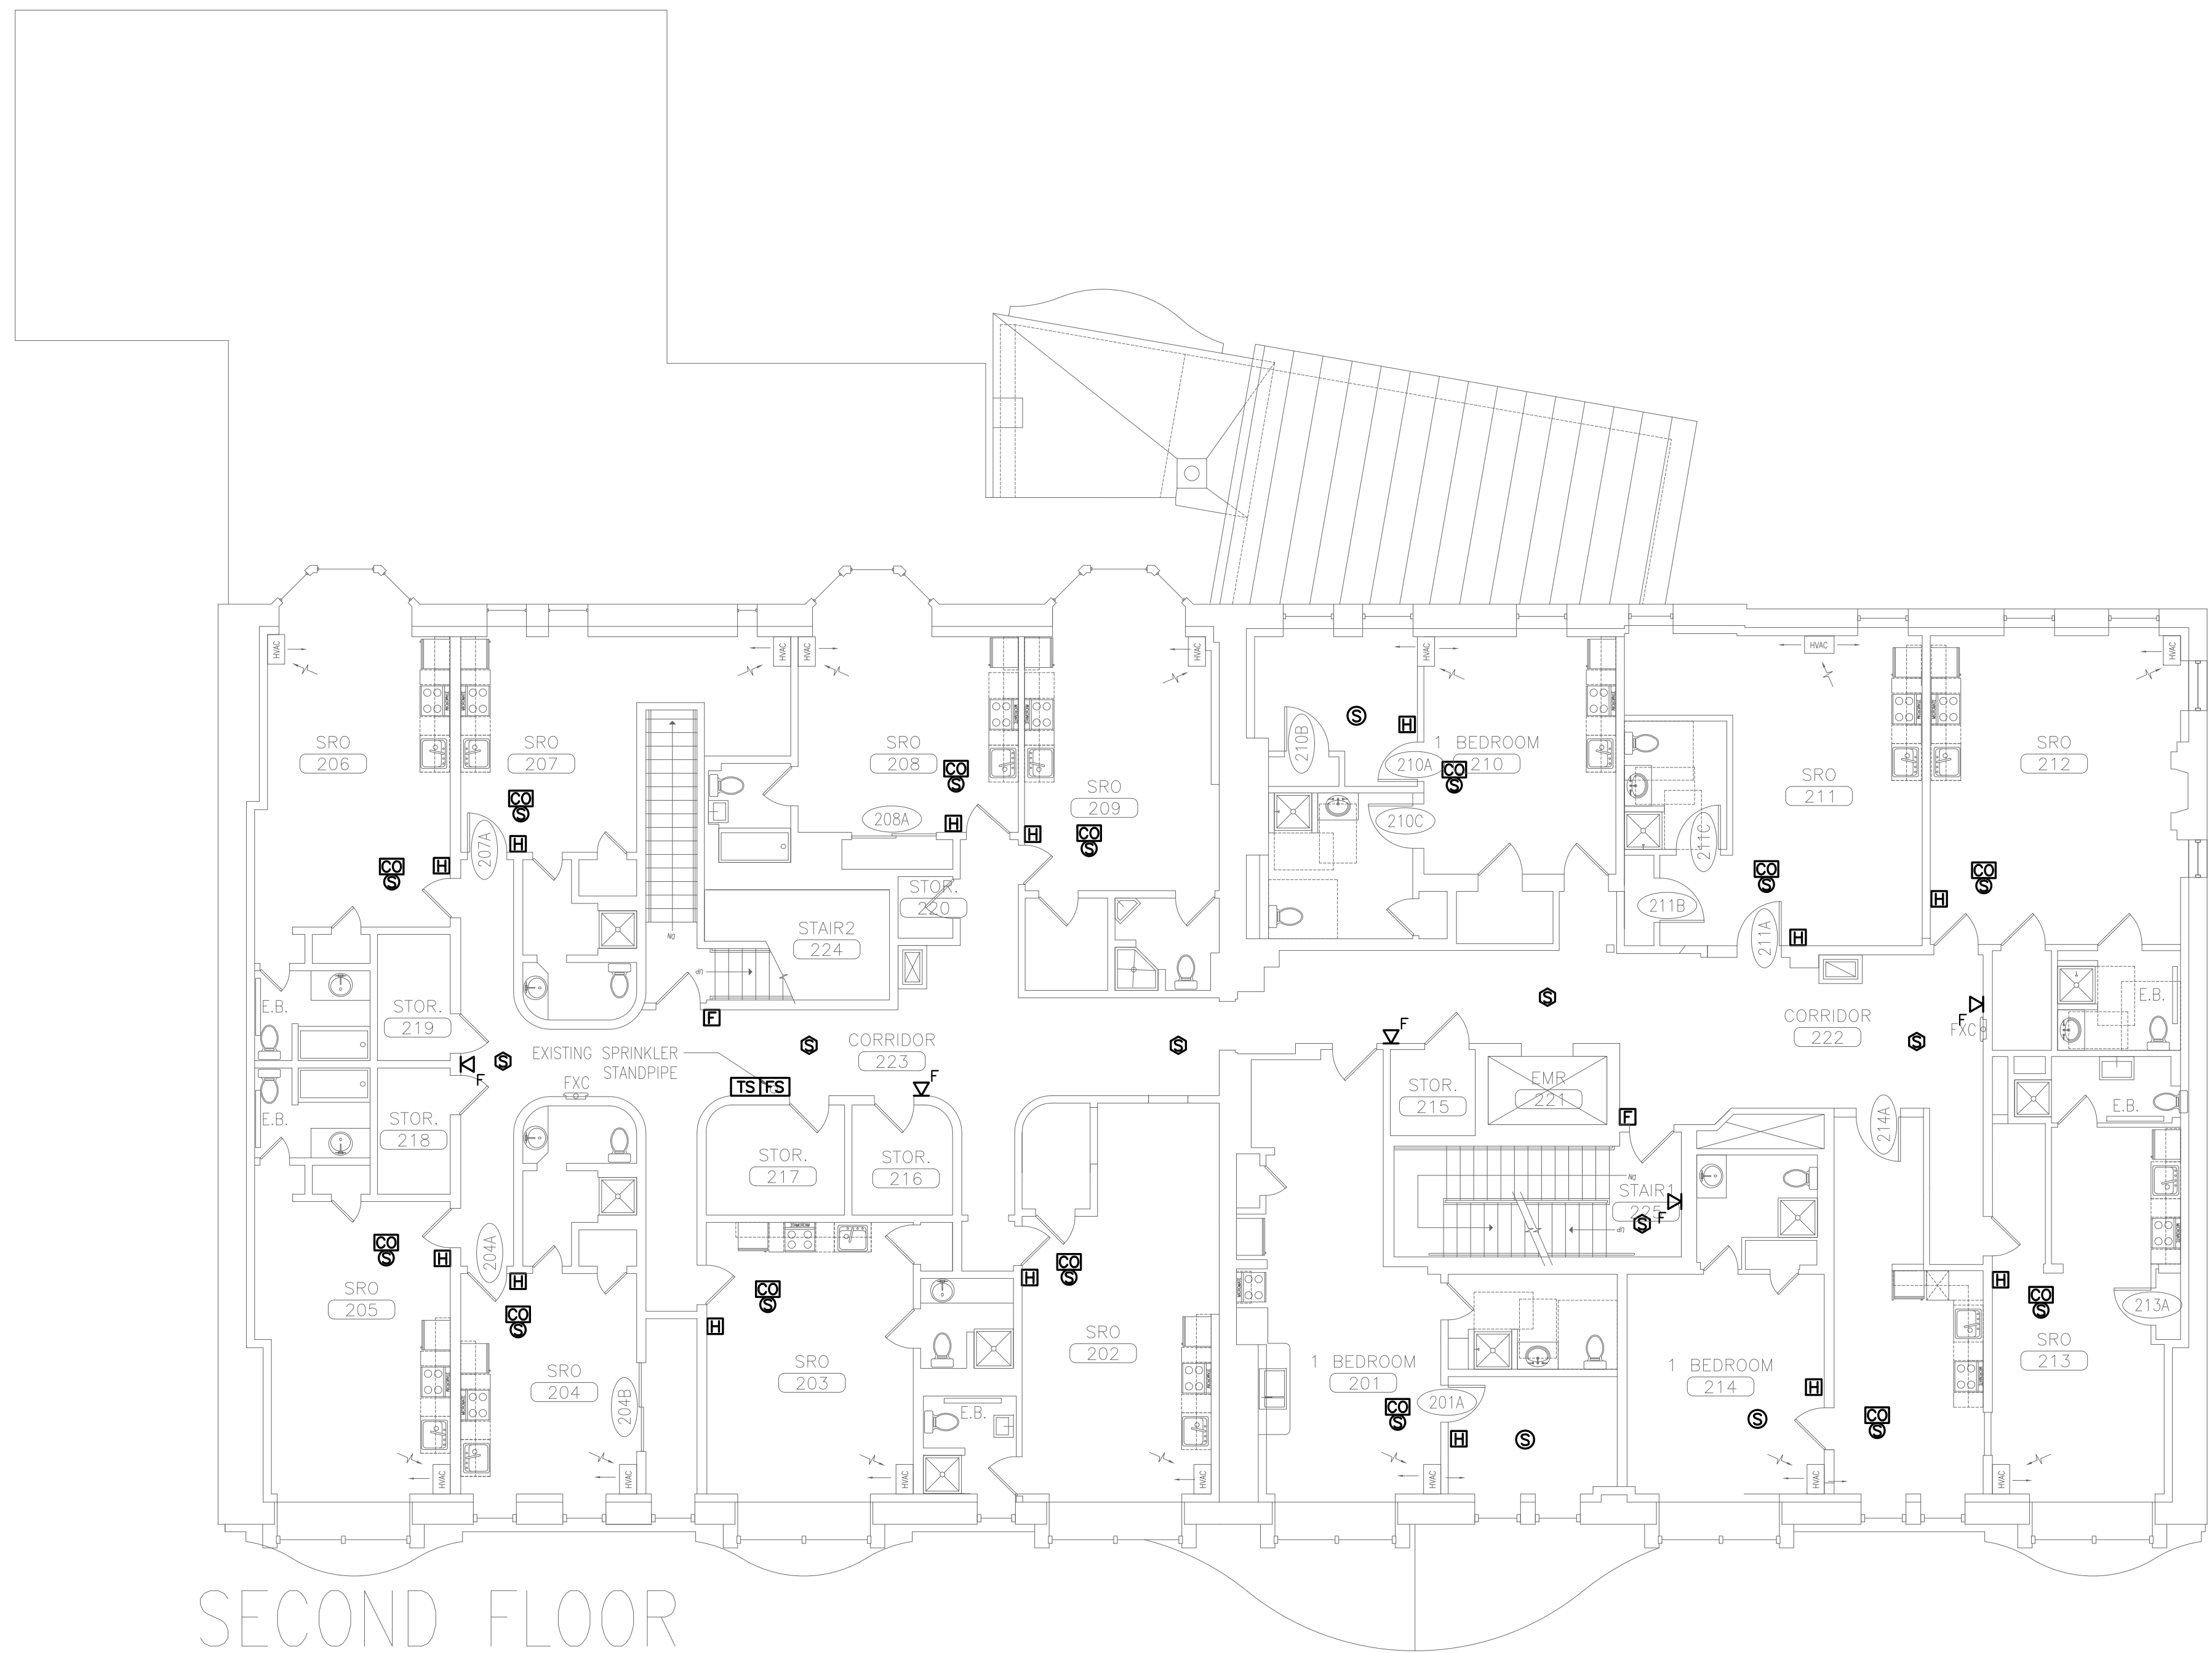

SECOND FLOOR

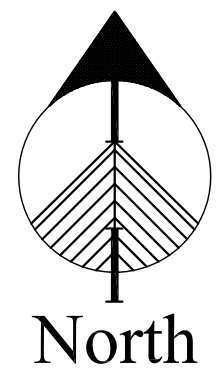

A


SECOND FLOOR FIRE ALARM PLAN

SCALE: 1/8" = 1'-0"

NOT FOR CONSTRUCTION

Development Consultant
SHINBERG CONSULTING
 477 CONGRESS ST.
 5TH FLOOR
 PORTLAND, MAINE, 04101

ZADE ASSOCIATES LLC
 CONSULTING ENGINEERS
 140 BRACE STREET, BOSTON, MA 02111
 TEL: (617) 552-6400
 FAX: (617) 451-8540
 E-MAIL: zades@aol.com

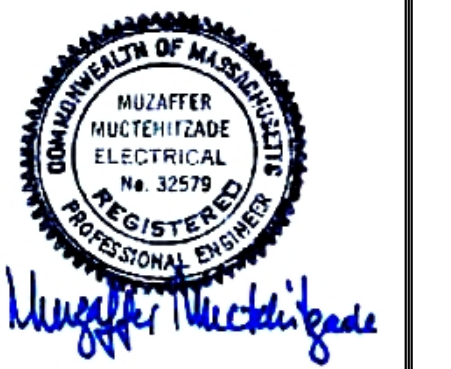

RENOVATIONS TO
 645 CONGRESS ST.
 PORTLAND, ME 04101

Project No: 08.436

Drawing Title:

SECOND FLOOR
 FIRE ALARM
 PLAN

Scale: AS NOTED


Date: 1-20-10

Revisions:


- △
- △
- △
- △
- △
- △

Drawing Number:

FA1.2

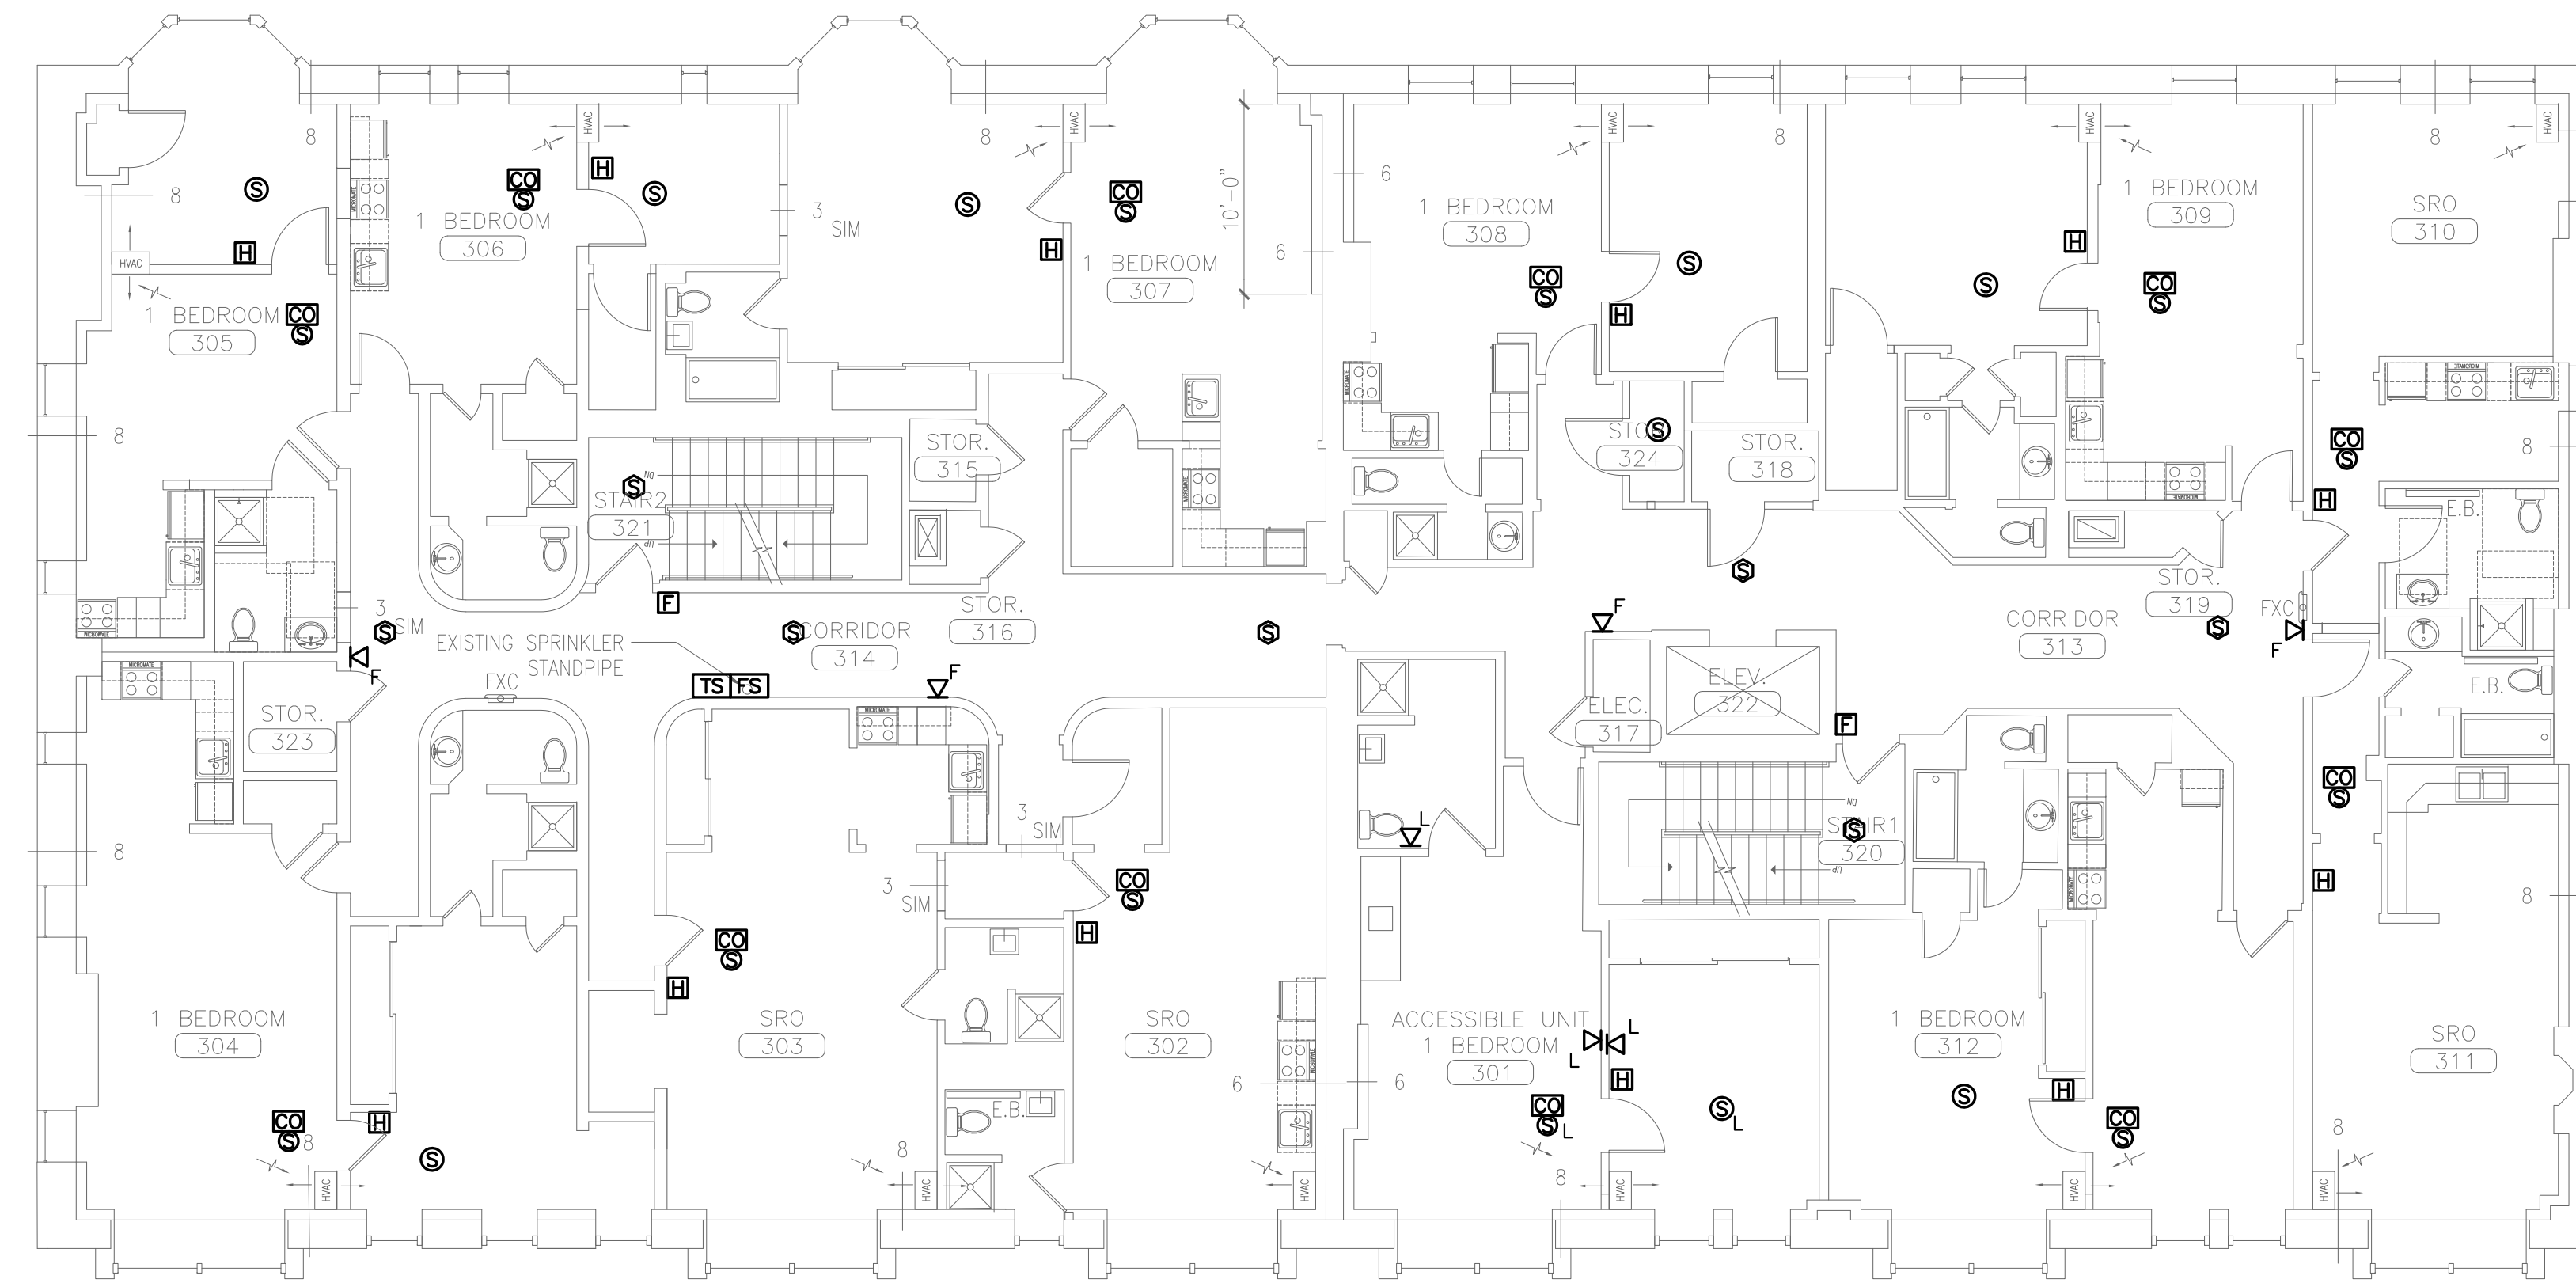

THIRD FLOOR

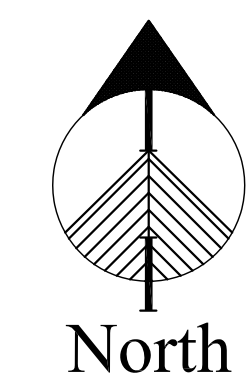

A

THIRD FLOOR FIRE ALARM PLAN

SCALE: 1/8" = 1'-0"

NOT FOR CONSTRUCTION

Development Consultant
**SHINBERG
 CONSULTING**
 477 CONGRESS ST.
 5TH FLOOR
 PORTLAND, MAINE, 04101

ZADE ASSOCIATES LLC
 CONSULTING ENGINEERS
 140 BRACE STREET, BOSTON, MA 02111
 TEL: (617) 552-6400
 FAX: (617) 451-8540
 E-MAIL: zade@zade.com



Mullaher Electrical

RENOVATIONS TO
 645 CONGRESS ST.
 PORTLAND, ME 04101

Project No: 08.436

Drawing Title:

THIRD FLOOR
 FIRE ALARM
 PLAN

Scale: AS NOTED


Date: 1-20-10

Revisions:


- △
- △
- △
- △
- △
- △

Drawing Number:

FA1.3

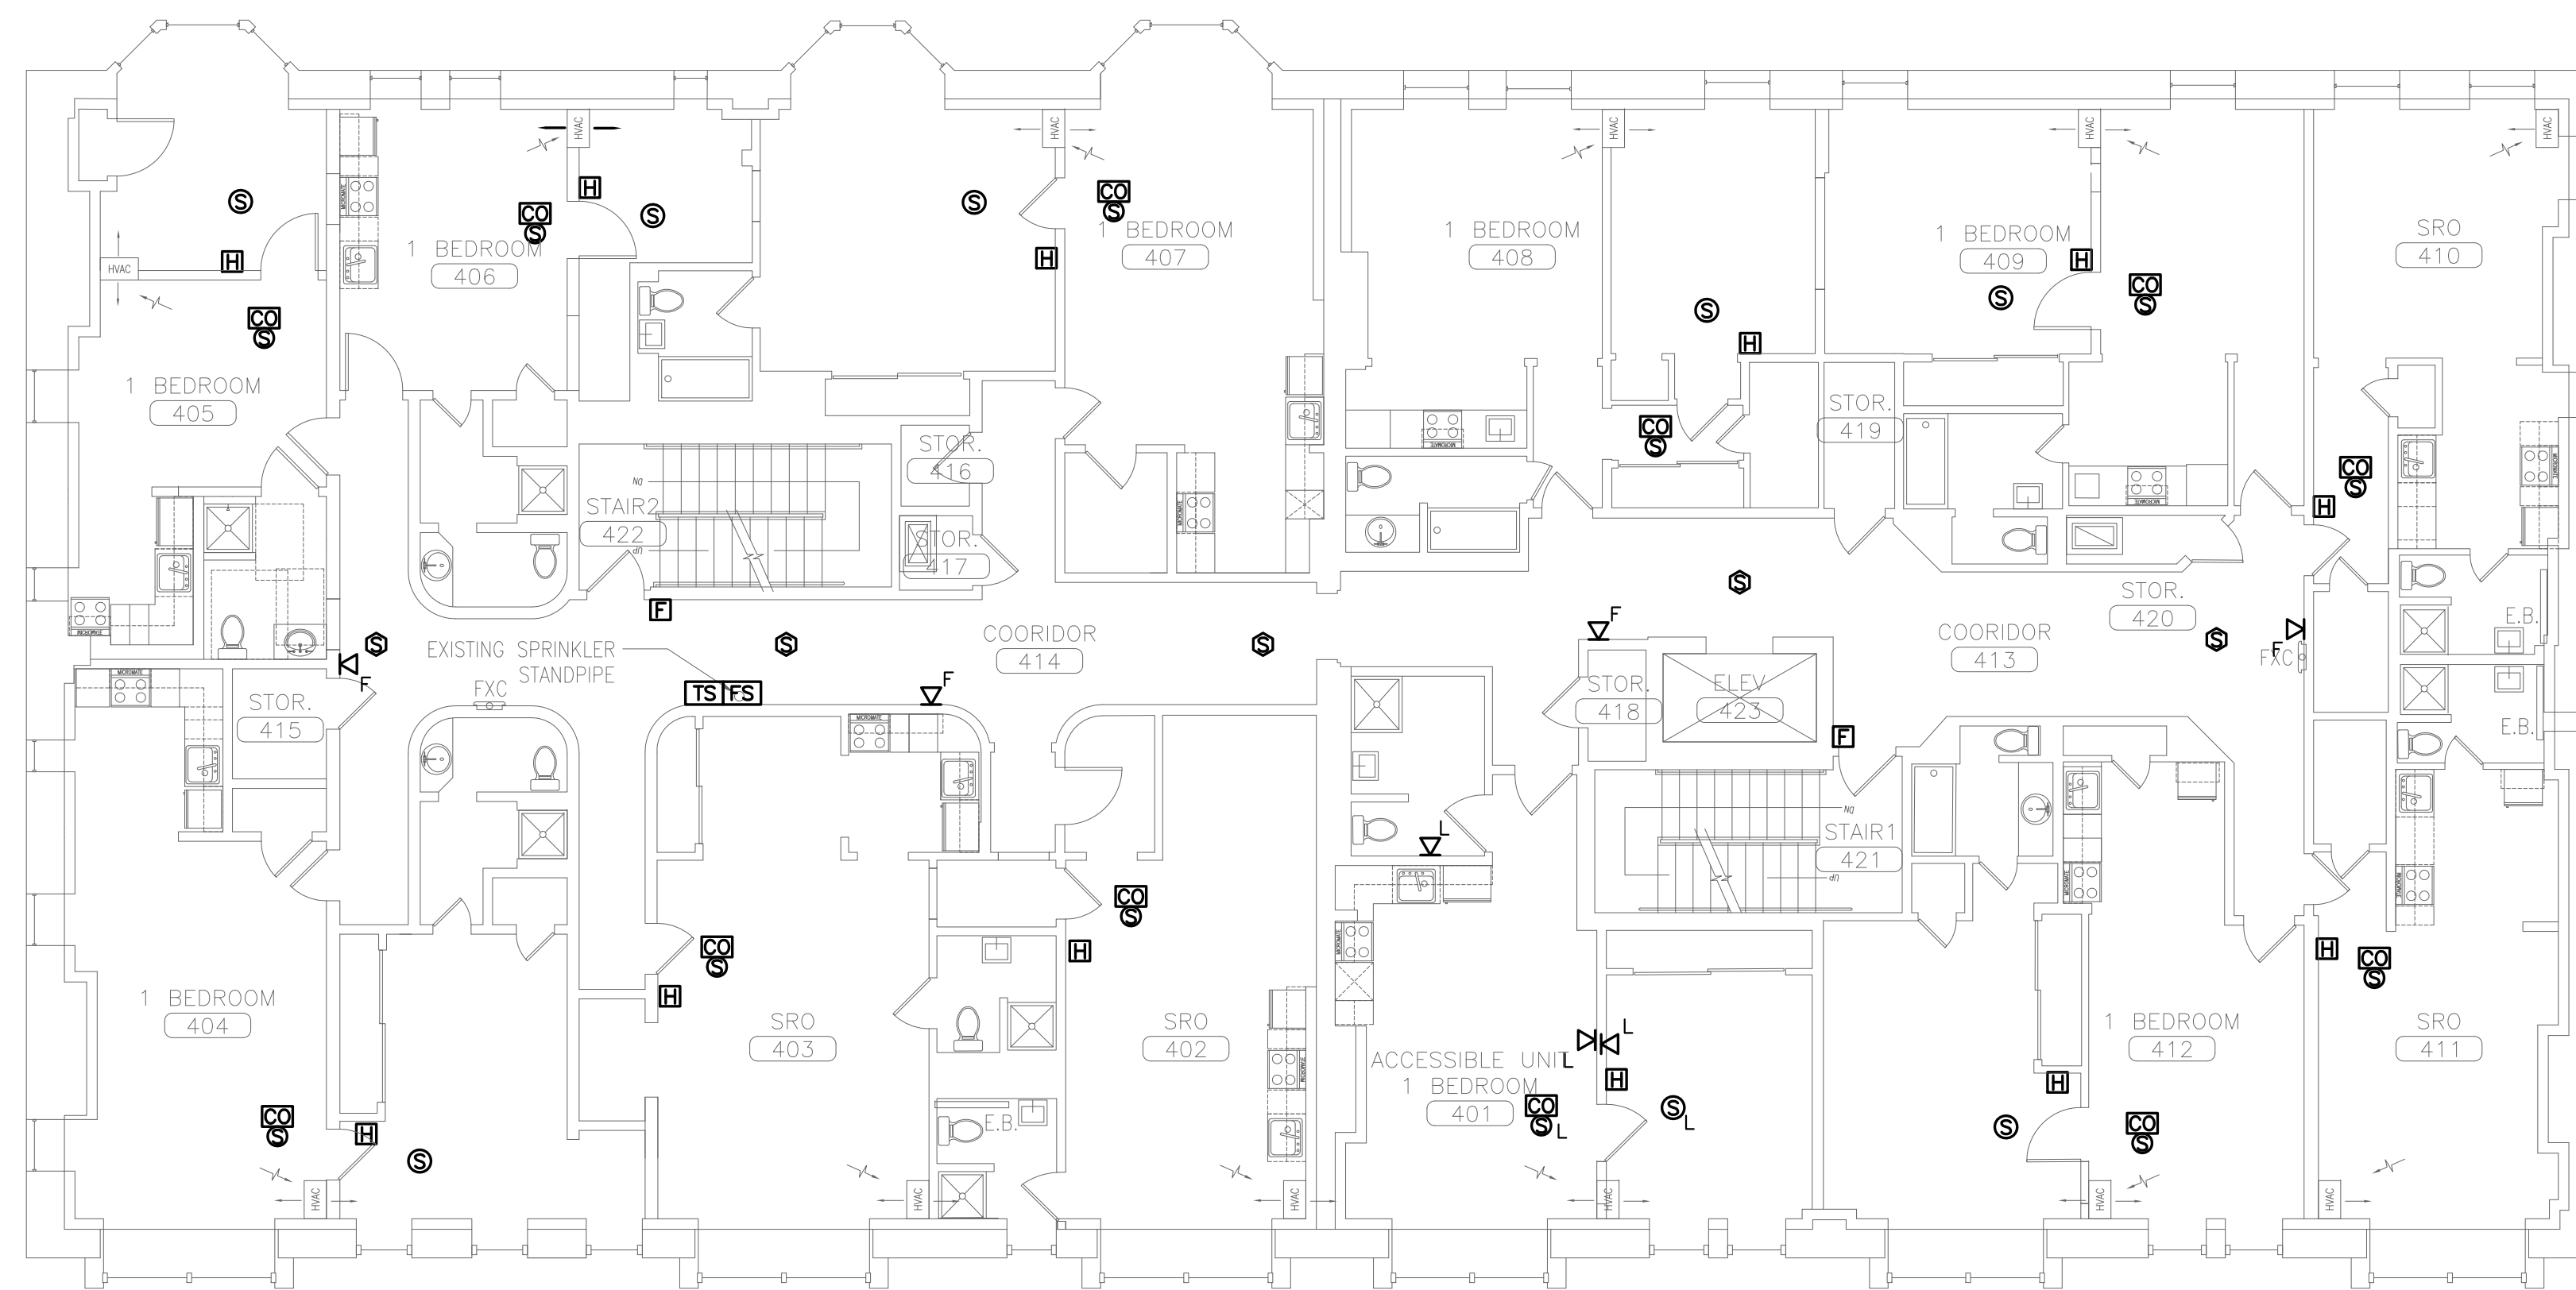

FOURTH FLOOR

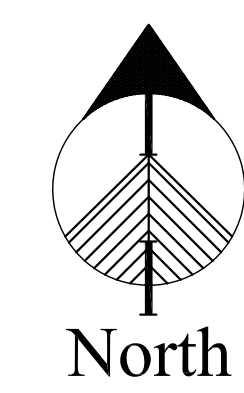

North

A

FOURTH FLOOR FIRE ALARM PLAN

SCALE: 1/8" = 1'-0"

Development Consultant
SHINBERG CONSULTING
 477 CONGRESS ST.
 5TH FLOOR
 PORTLAND, MAINE, 04101

ZADE ASSOCIATES LLC
 CONSULTING ENGINEERS
 140 BRACE STREET, BOSTON, MA 02111
 TEL: (617) 552-6400
 FAX: (617) 451-8540
 E-MAIL: zade@zade.com



RENOVATIONS TO
 645 CONGRESS ST.
 PORTLAND, ME 04101

Project No: 08.436

Drawing Title:

FOURTH FLOOR
 FIRE ALARM
 PLAN

Scale: AS NOTED

Date: 1-20-10


Revisions:

- △
- △
- △
- △
- △
- △


Drawing Number:

FA1.4

NOT FOR CONSTRUCTION

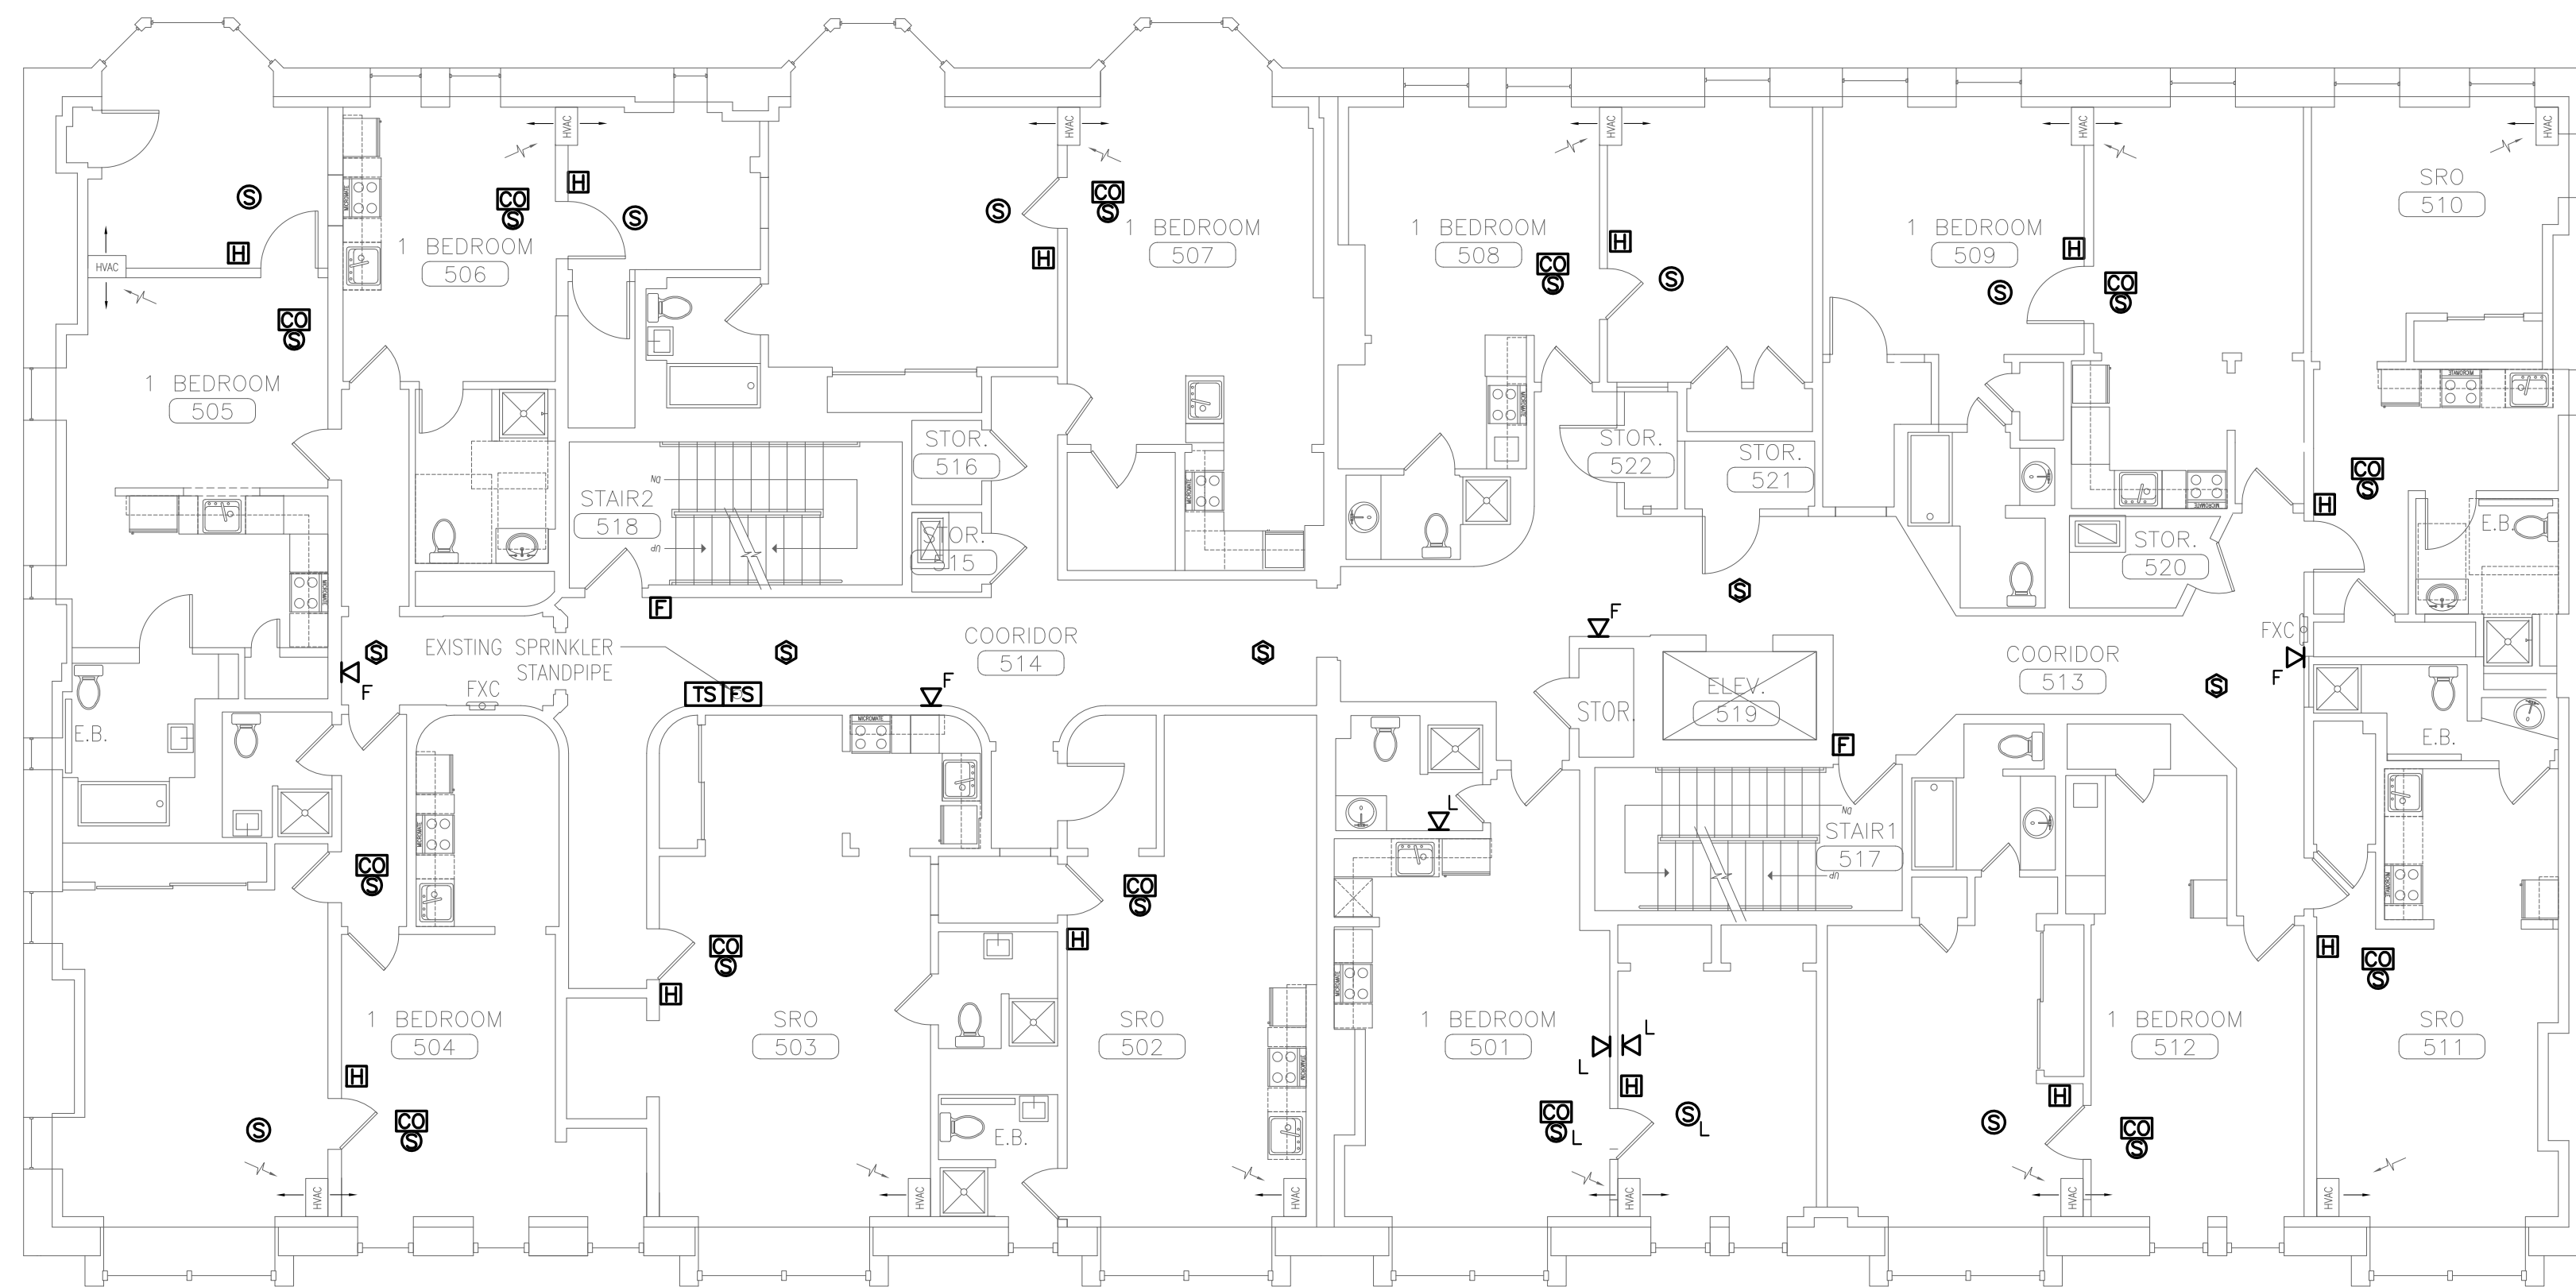

FIFTH FLOOR

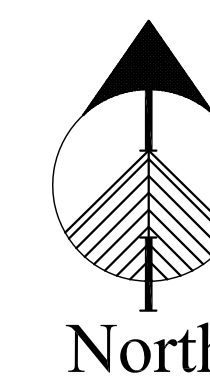

A

FIFTH FLOOR FIRE ALARM PLAN

SCALE: 1/8" = 1'-0"

NOT FOR CONSTRUCTION

Development Consultant
**SHINBERG
 CONSULTING**
 477 CONGRESS ST.
 5TH FLOOR
 PORTLAND, MAINE, 04101

ZADE ASSOCIATES LLC
 CONSULTING ENGINEERS
 140 BRACE STREET, BOSTON, MA 02111
 TEL: (617) 552-6400
 FAX: (617) 451-8540
 E-MAIL: zade@zade.com



RENOVATIONS TO
 645 CONGRESS ST.
 PORTLAND, ME 04101

Project No: 08.436

Drawing Title:

FIFTH FLOOR
 FIRE ALARM
 PLAN

Scale: AS NOTED


Date: 1-20-10

Revisions:

- △
- △
- △
- △
- △
- △

Drawing Number:


FA1.5

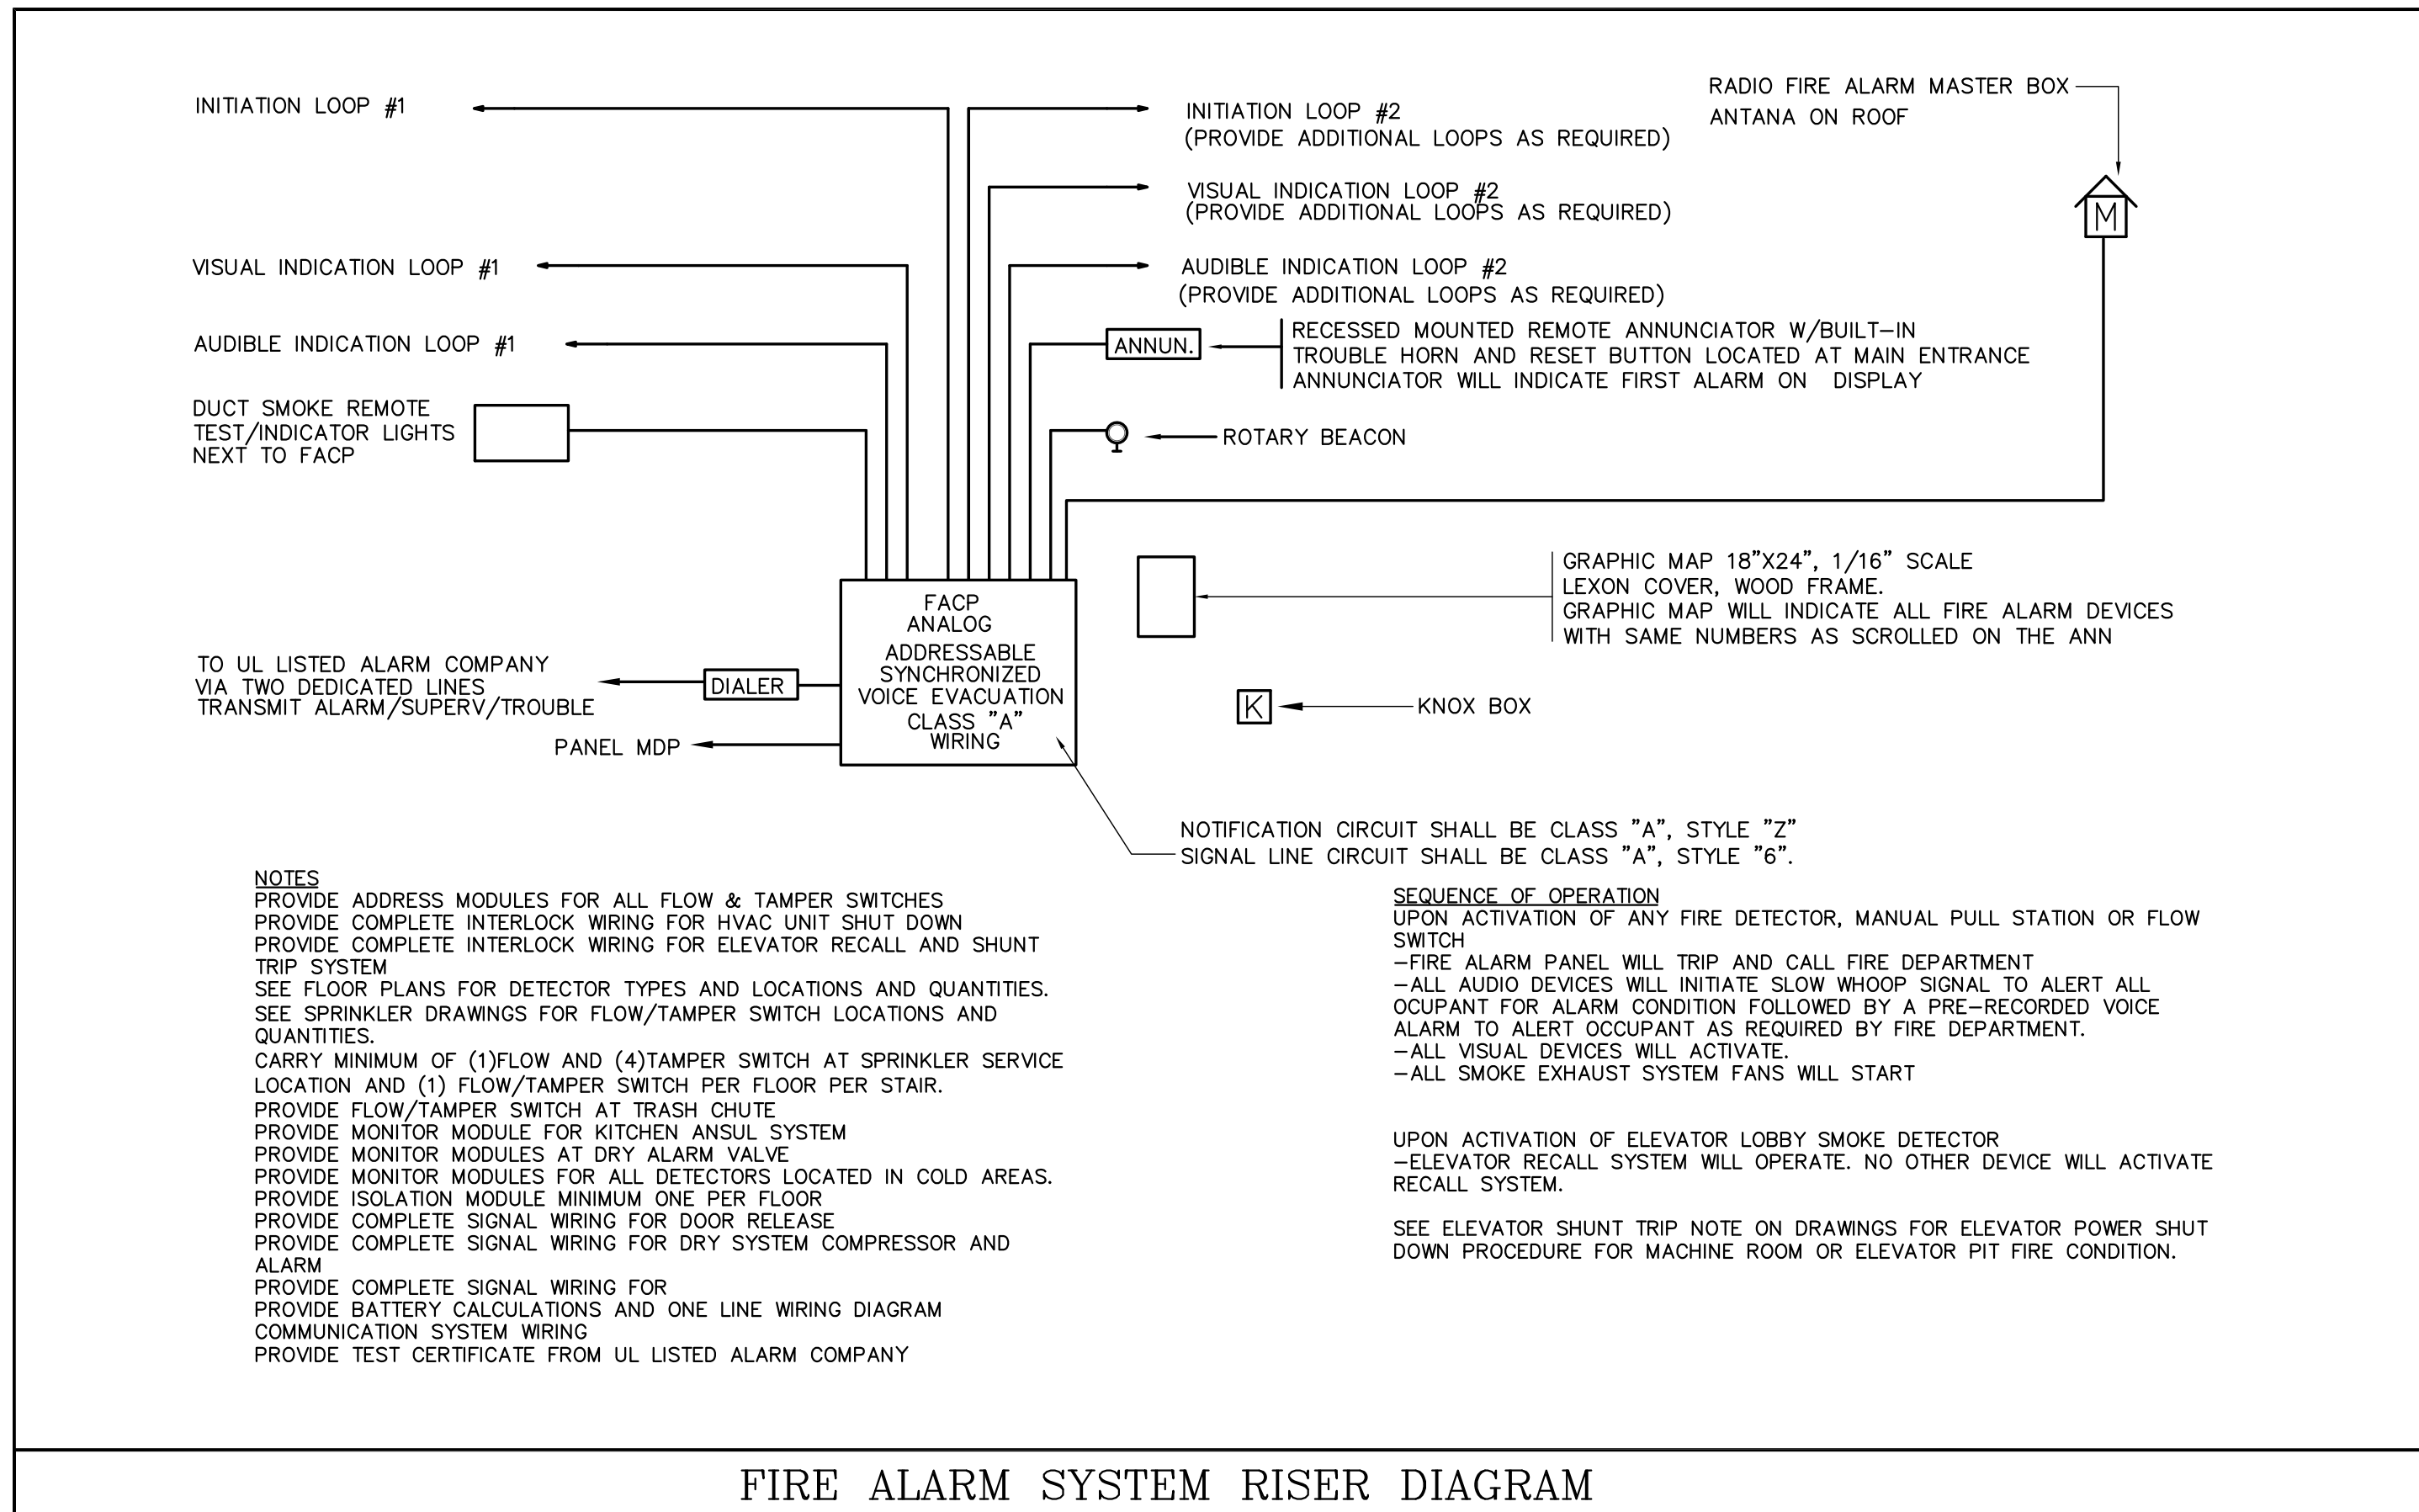


LEGEND

(S)	SYSTEM TYPE SMOKE DETECTOR, ANALOG ADDRESSABLE	(TS)	SPRINKLER SYSTEM TAMPER SWITCH, WIRING ONLY.
(S _D)	DUCT SMOKE DETECTOR WITH REMOTE TEST SWITCH. TUBE WILL HAVE MINIMUM 10 HOLES	(PS)	LOW PRESSURE SWITCH WIRED AS SUPERVISORY
(H)	HEAT DETECTOR, ADDRESSABLE TYPE	(FACP)	FIRE ALARM CONTROL PANEL.
(F)	FIRE ALARM PULL AND HORN/LIGHT DEVICE. ADDRESSABLE/TEMPORAL PER NFPA 72/SYNCHRONIZED. 15CD IN CORR., 60CD IN COMMON AREAS	(FAA)	FIRE ALARM REMOTE ANNUNCIATOR WITH TROUBLE BUZZER.
(F)	FIRE ALARM PULL STATION, ADDRESSABLE, MOUNTED AT 4'-0" AFF.	(DIAL)	DIALER BY E.C. WIRED TO UL LISTED ALARM CO.
(F)	FIRE ALARM HORN/LIGHT(TEMPORAL/SYNCHRONIZED). MTD AT 6'-8" AFF 15 CD IN CORRIDORS, 60 CD IN COMMON AREAS	(S)	LOCAL TYPE 110V SMOKE DETECTOR, PHOTOELECTRIC TYPE WITH BATTERY BACK-UP. "L" INDICATES BUILT-IN STROBE 177CD)TANDEM WIRED WITH OTHER LOCAL DETECTORS IN THE UNIT. WIRED TO LIGHTING CIRCUIT
(F)	FIRE ALARM LIGHT ONLY(SYNCHRONIZED).MTD AT 6'-8"AFF 15 CD IN CORRIDORS, 60 CD IN COMMON AREAS	(H)	MINI HORN/ TEMPORAL PER NFPA 72
(FS)	SPRINKLER SYSTEM FLOW SWITCH, WIRING ONLY.	(M)	FIRE ALARM CITY TIE-IN MASTER BOX.
(M)	ADDRESSABLE MODULE	(EL)	EMERGENCY LIGHT
		(X)	EXIT SIGN

FIRE ALARM SYSTEM RISER DIAGRAM

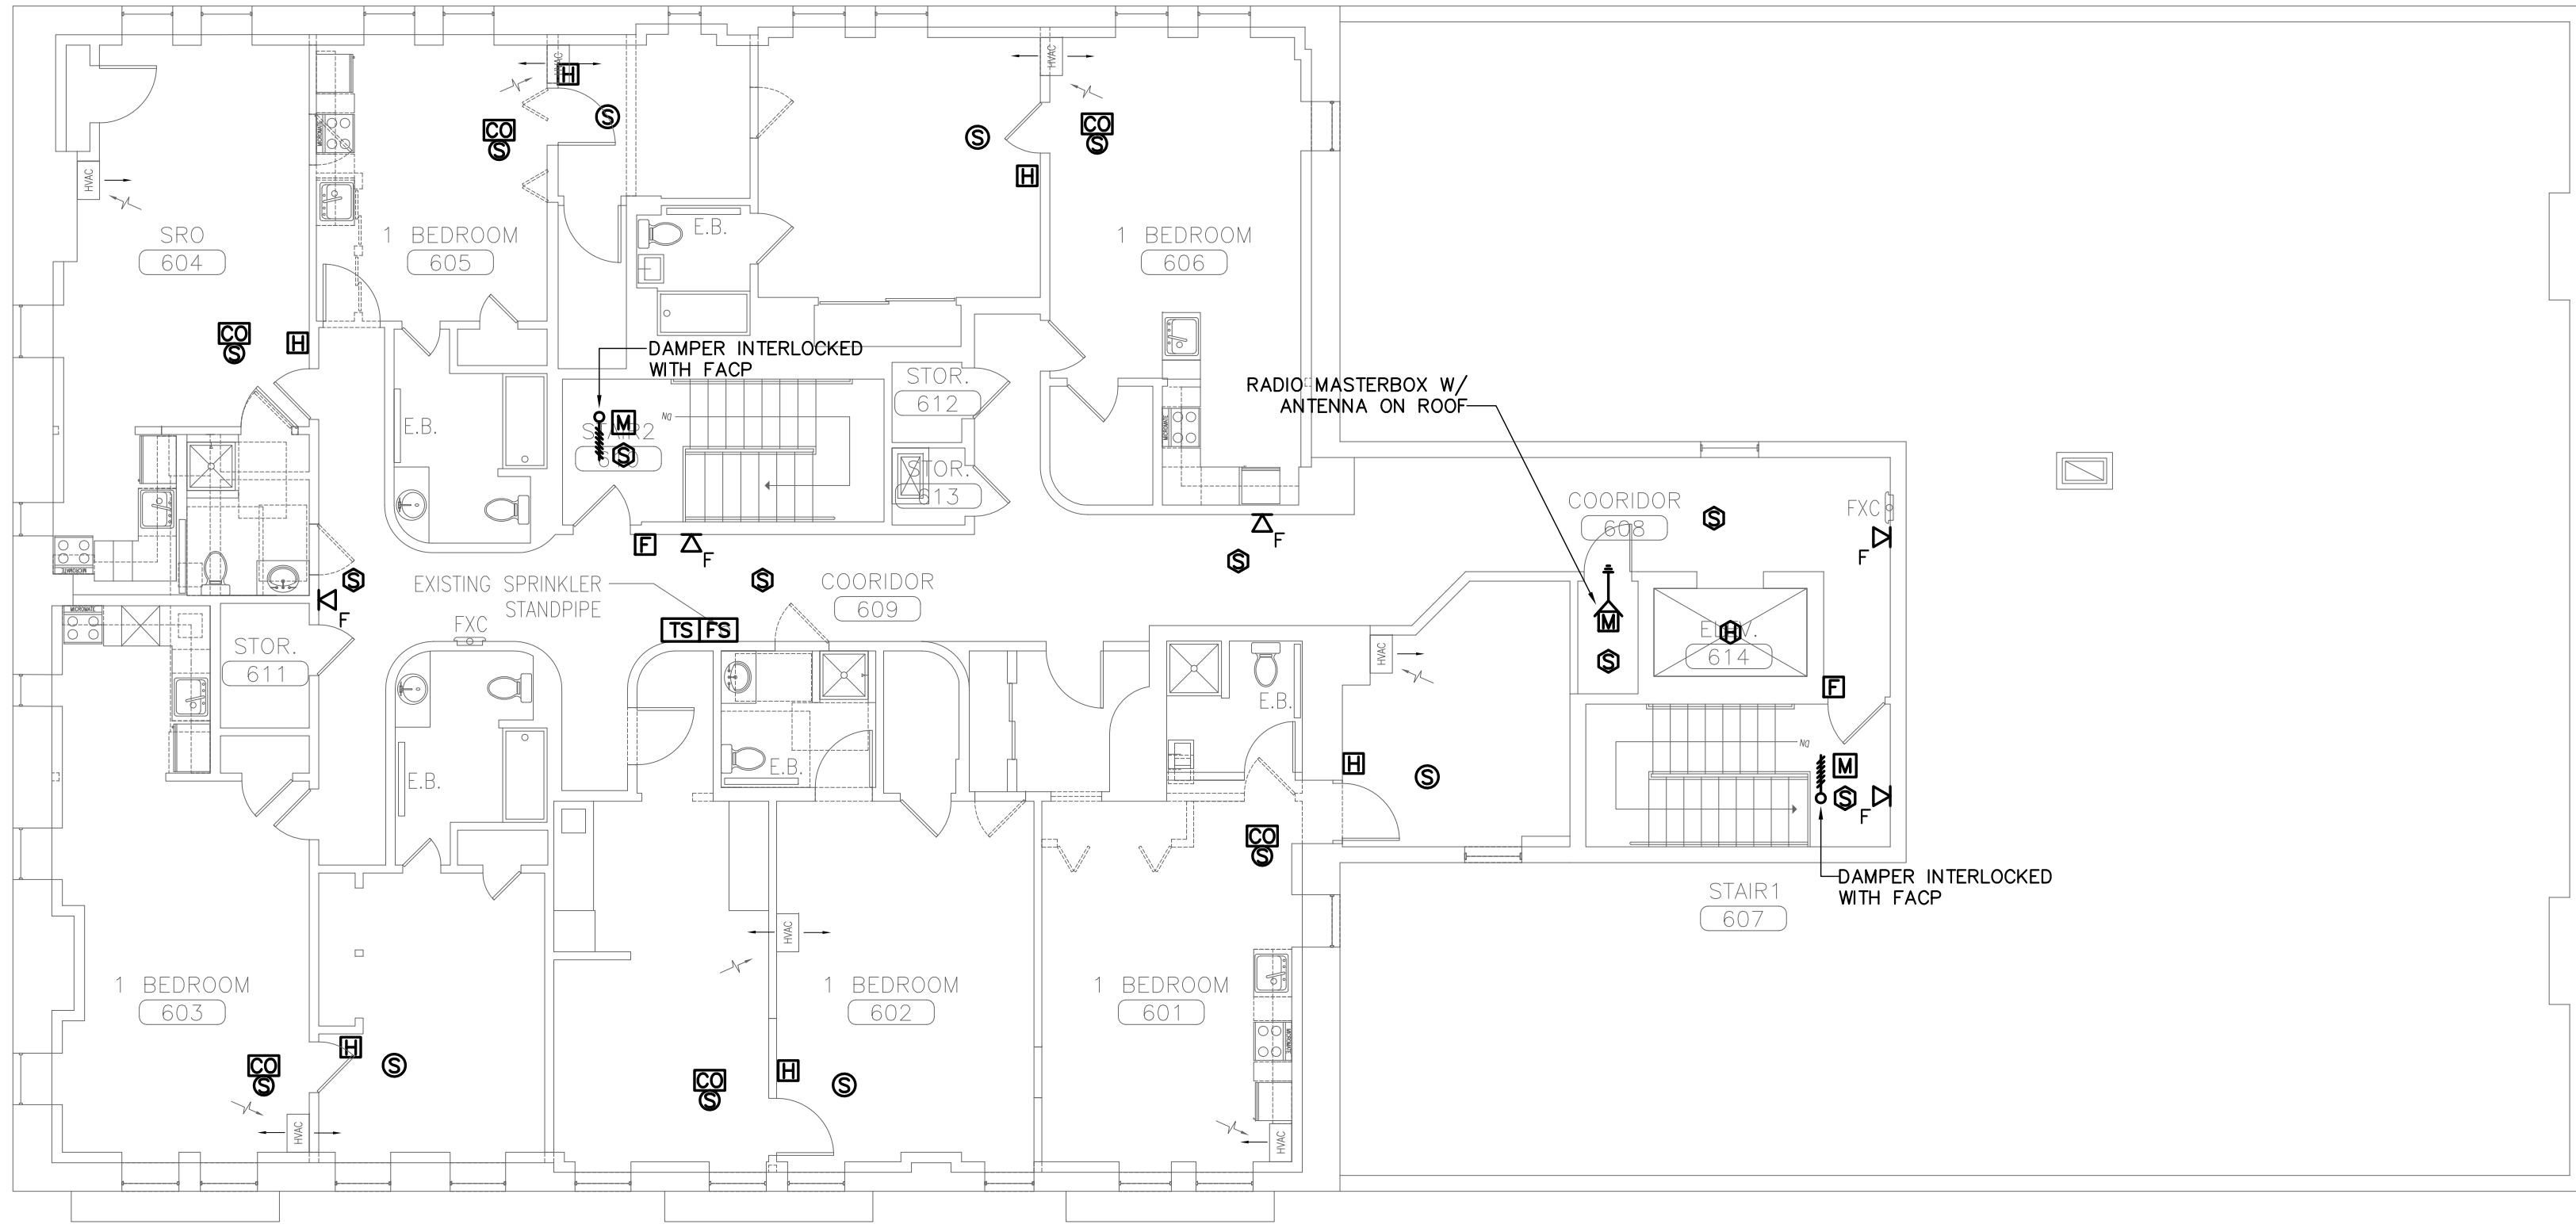

SIXTH FLOOR

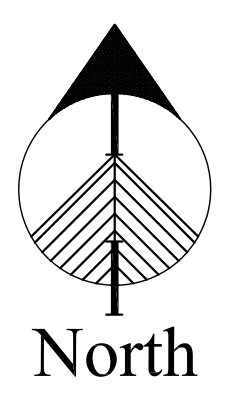

Development Consultant
SHINBERG CONSULTING
 477 CONGRESS ST.
 5TH FLOOR
 PORTLAND, MAINE, 04101

ZADE ASSOCIATES LLC
 CONSULTING ENGINEERS
 140 BRACE STREET, BOSTON, MA 02111
 TEL: (617) 552-6400
 FAX: (617) 451-8540
 E-MAIL: zades@aol.com



RENOVATIONS TO
 645 CONGRESS ST.
 PORTLAND, ME 04101

Project No: 08.436

Drawing Title:

SIXTH FLOOR
 FIRE ALARM PLAN,
 RISERS & NOTES

Scale: AS NOTED

Date: 1-20-10

Revisions:

- △
- △
- △
- △
- △
- △

Drawing Number:

FA1.6